


ELEVATION

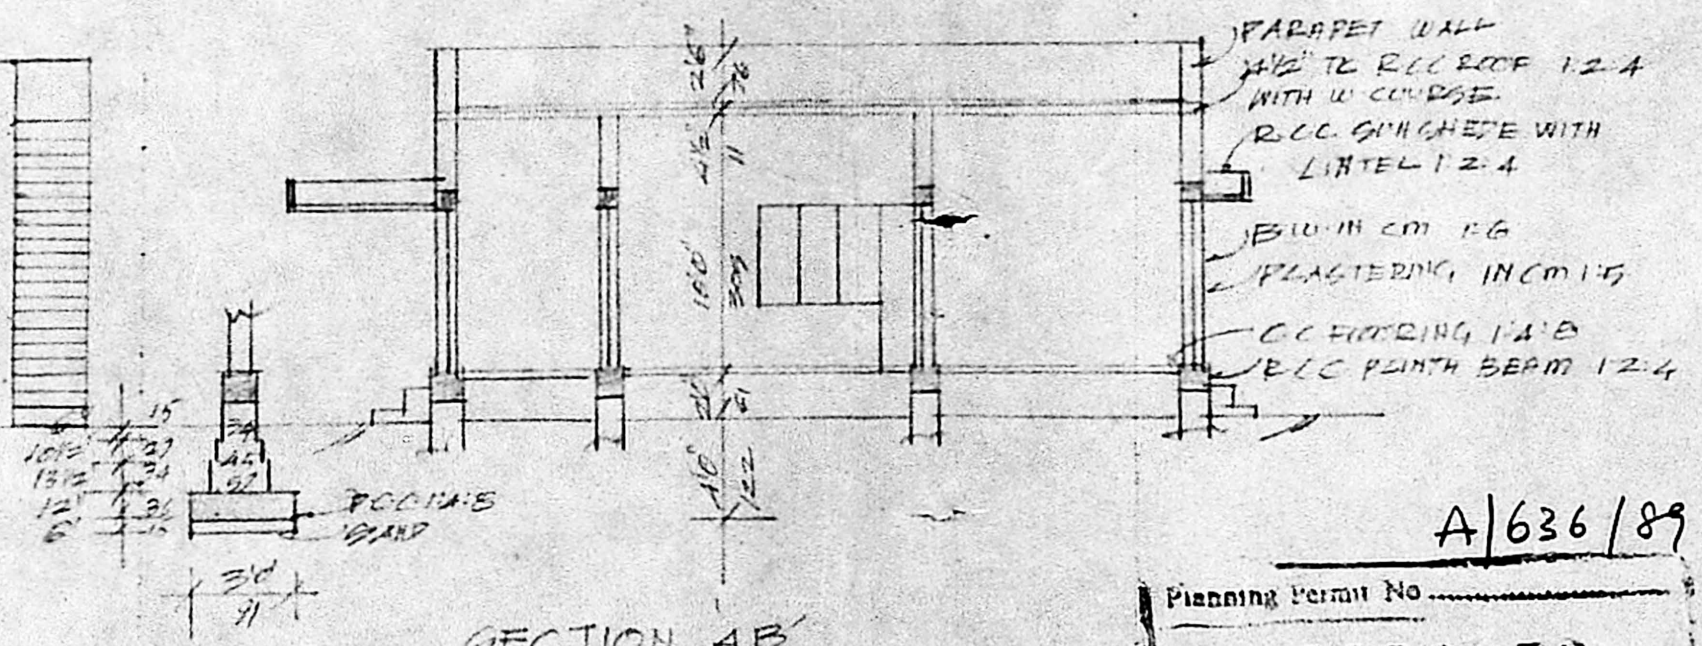


SECTION AB

PARAPET WALL  
 4 1/2" TO RCC ROOF 12.4  
 WITH W COURSE  
 RCC GINCHERE WITH  
 LIHTEL 12.4  
 150 MM CM 1:6  
 PLASTERING 1 IN CM 1:5  
 CC FLOORING 1:2:8  
 RCC PANTH BEAM 12.4

A/636/89

Planning Permit No. \_\_\_\_\_  
**APPROVED**  
 subject to the conditions in  
 this office letter.  
 No. A/4847/89 dt. 12/7-88  
*T. S.* 12/7/88  
 FOR MEMBER SECRETARY  
 MADRAS METROPOLITAN  
 DEVELOPMENT AUTHORITY

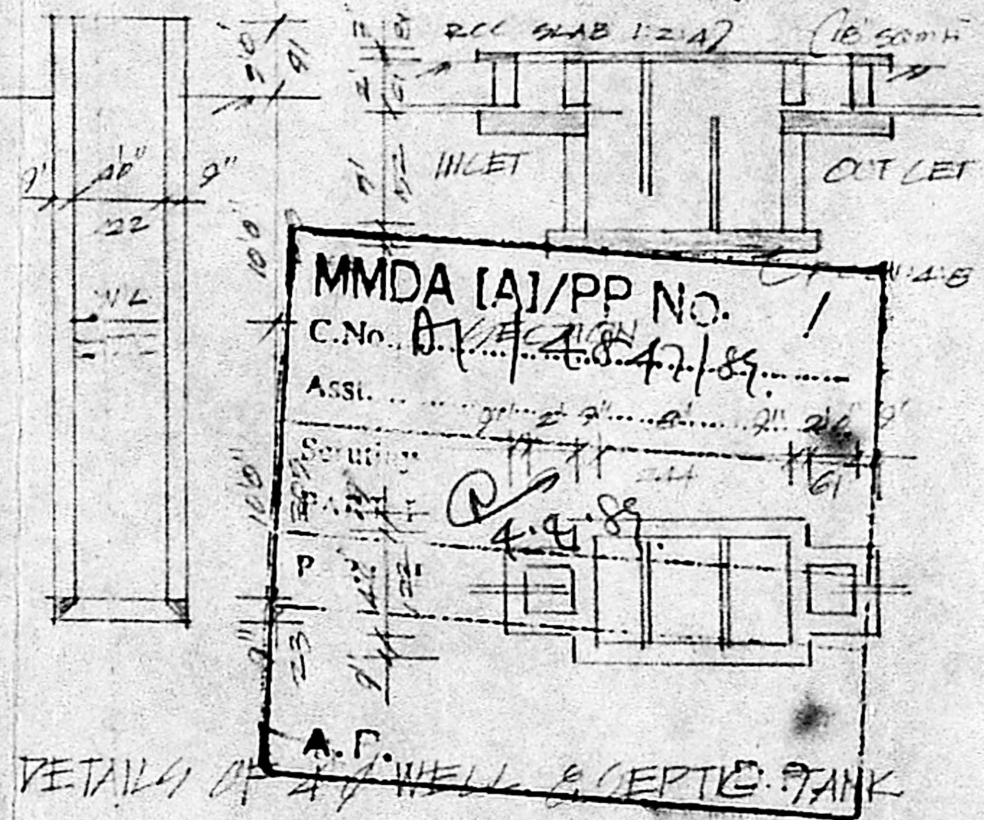

DETAILS OF WELL & SEPTIC TANK

JOINERY


D	DOOR	3'3" X 5'6"	100 X 200
D1	"	2'6" X 6'6"	70 X 200
W	WINDOW	5'0" X 4'0"	152 X 122
W1	"	3'0" X 4'0"	91 X 122
V	VENTILATOR	3'0" X 2'0"	91 X 91

SCALE 1/8" = 1'-0"


FROM DWELLING HOUSE IN PLOT No 11 C  
 9th OAI ULLAGARAM VILLAGE  
 CHIDAPET TALUK CHINGLEPUT  
 DISTRICT.

*R. Madan*  
 FOR Mr. R. MADHAVAN


*A. Arunachal*

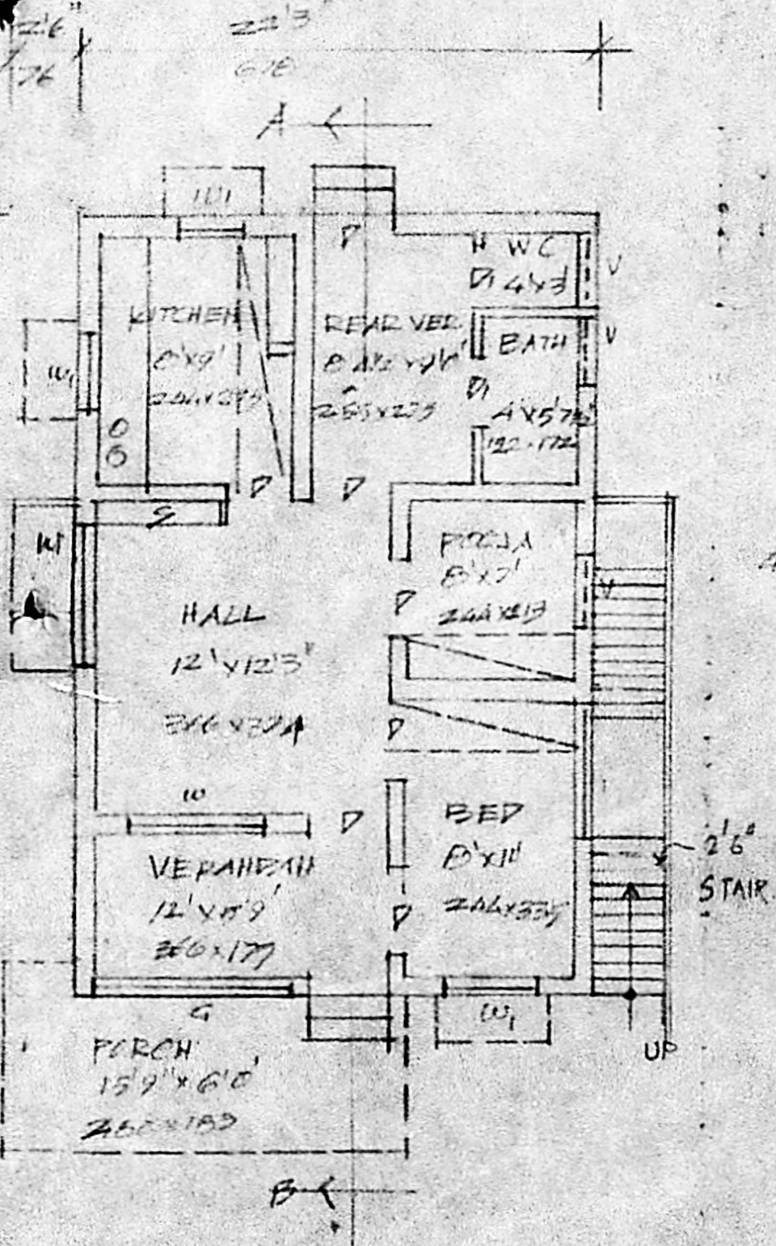

PLAN

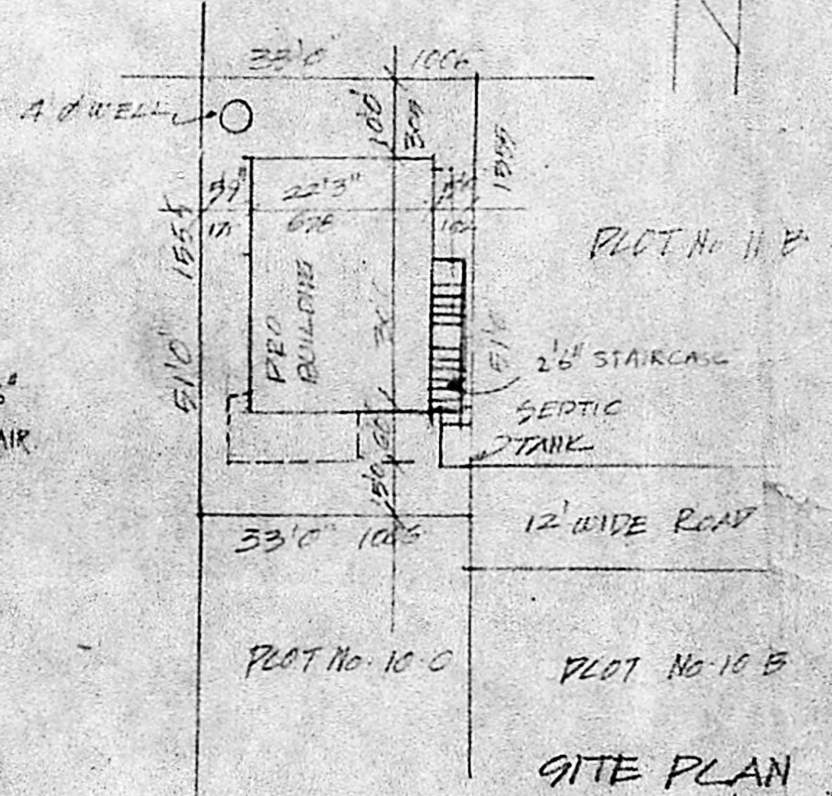

SITE PLAN  
 SCALE 1/16" = 1'-0"

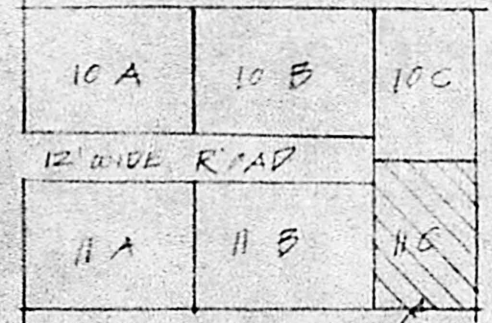

KEY PLAN  
 HTS

PHONO: 62173  
**A. ARUNACHAL A.M. D.C.E.**  
 CONSULTING CIVIL ENGINEER & CONTRACTOR  
 MADRAS CORPORATION LICENSED SURVEYOR  
 ALANDUR MUNICIPALITY  
 AMBATTUR TOWNSHIP.  
 LICENCE NO: 9  
 2, KALAINAR KARUNANIDHI ROAD  
 SALIGRAMAM : ENKATHAS-600 093  
 (NEXT TO SALIGRAMAM POST OFFICE)

CENTER