




ELEVATION

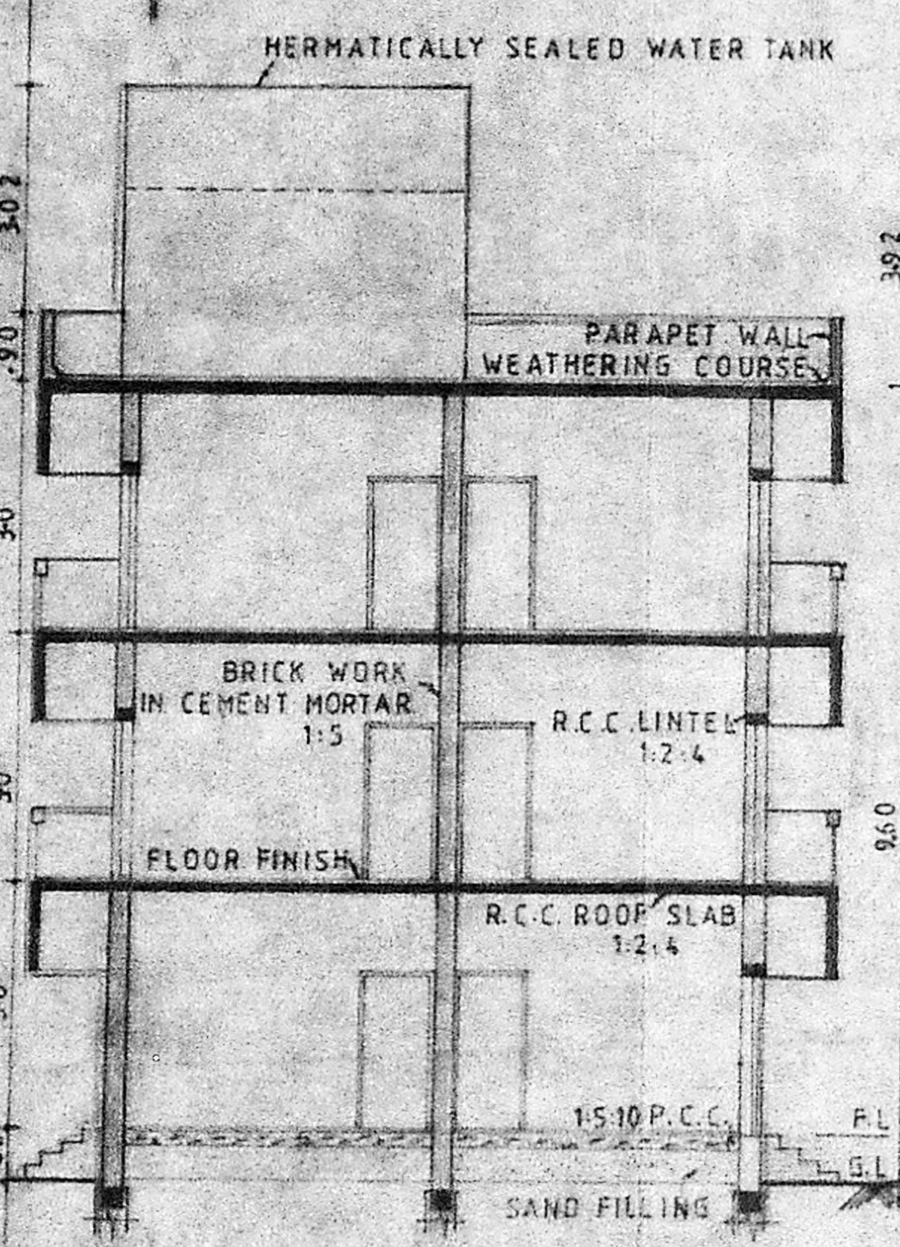


SECTION AT AA

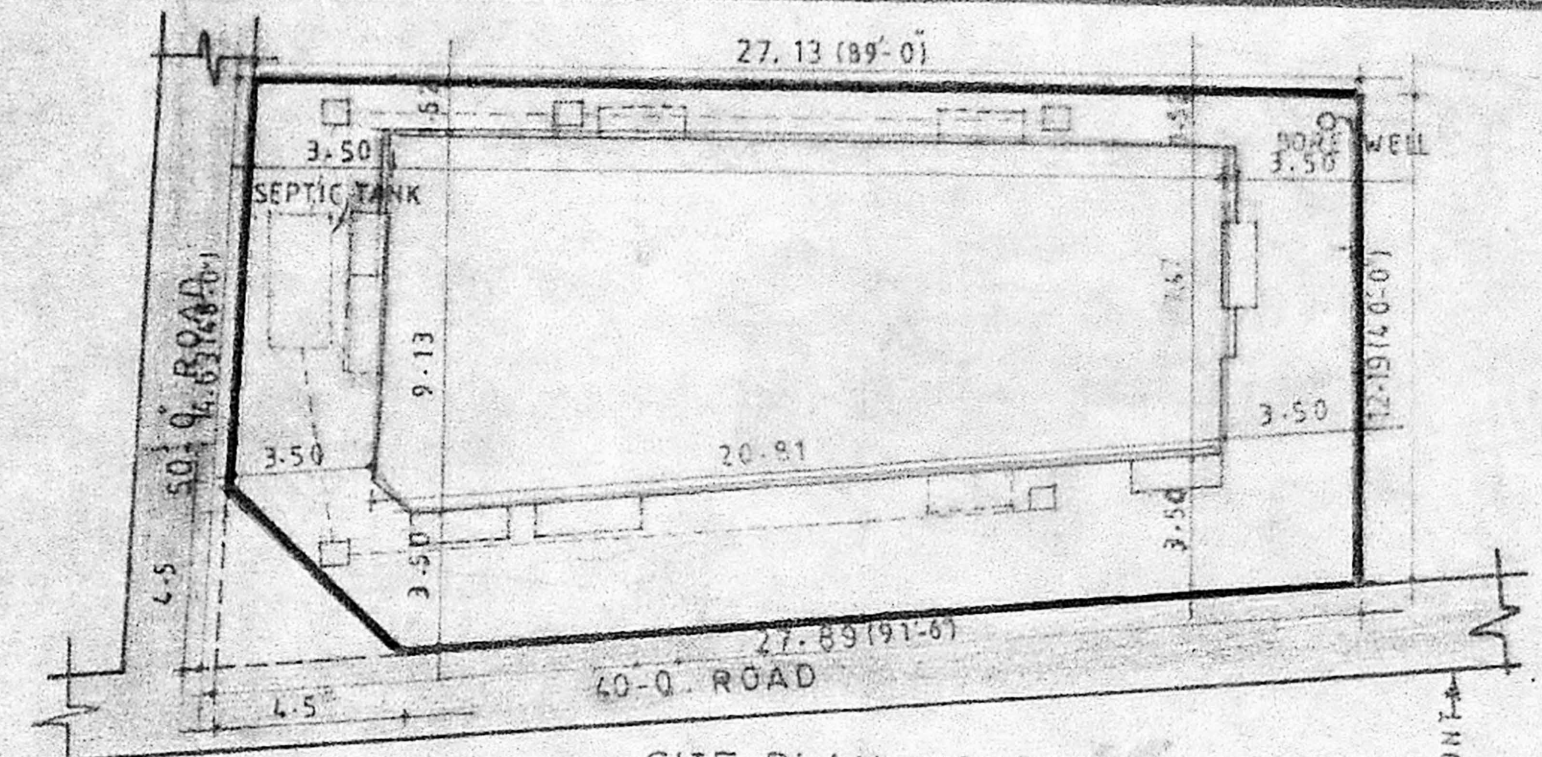

SITE PLAN (SCALE: 1:200)

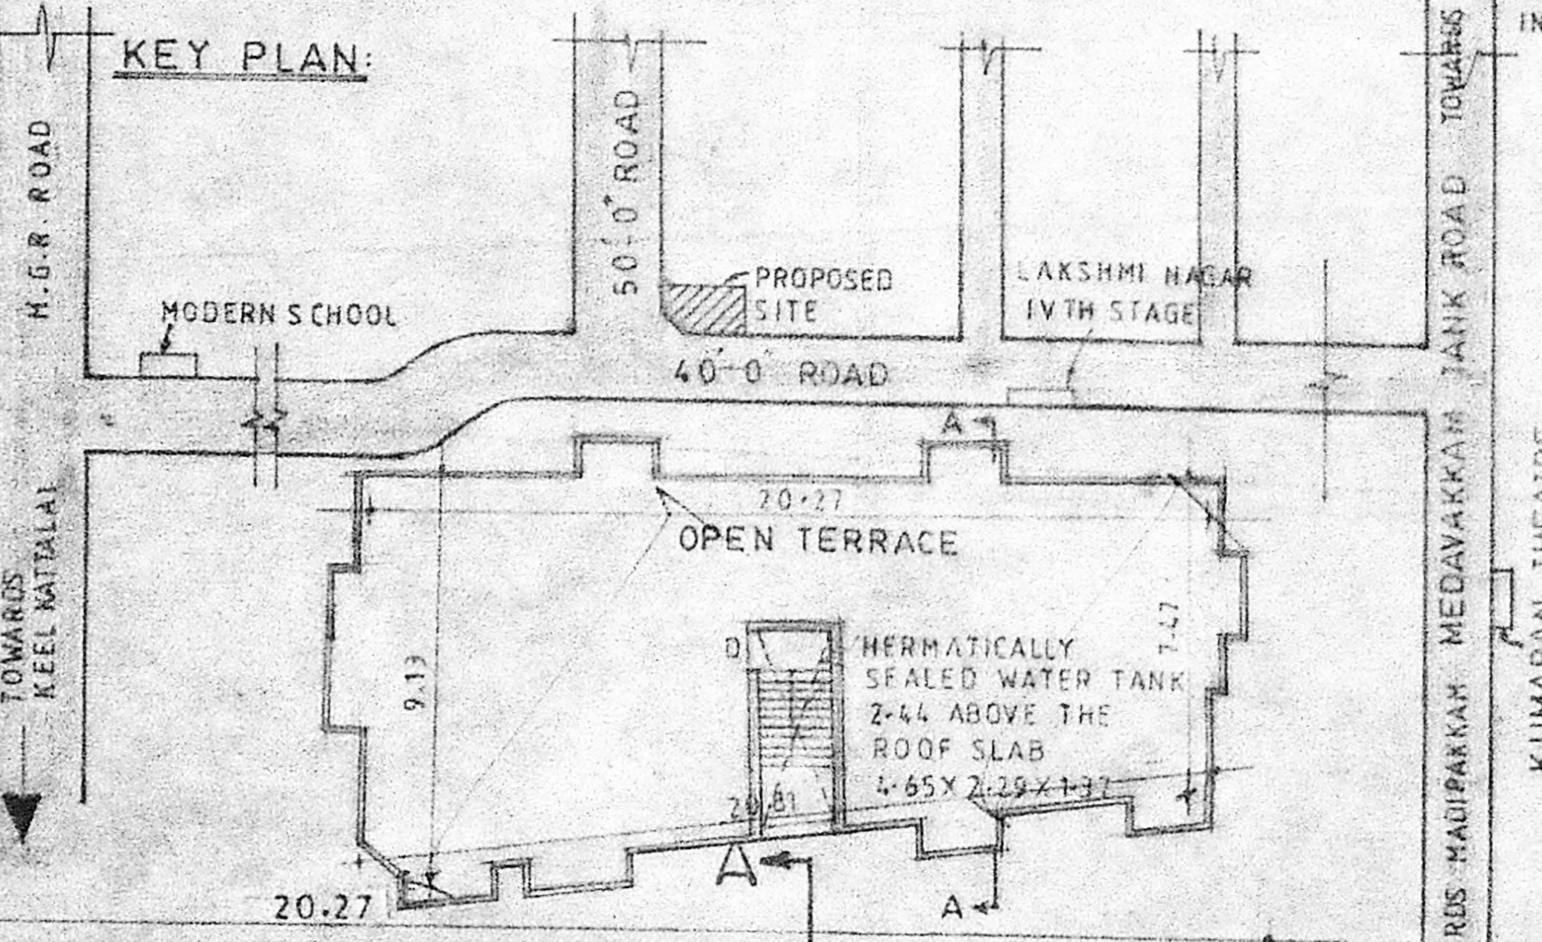


KEY PLAN:

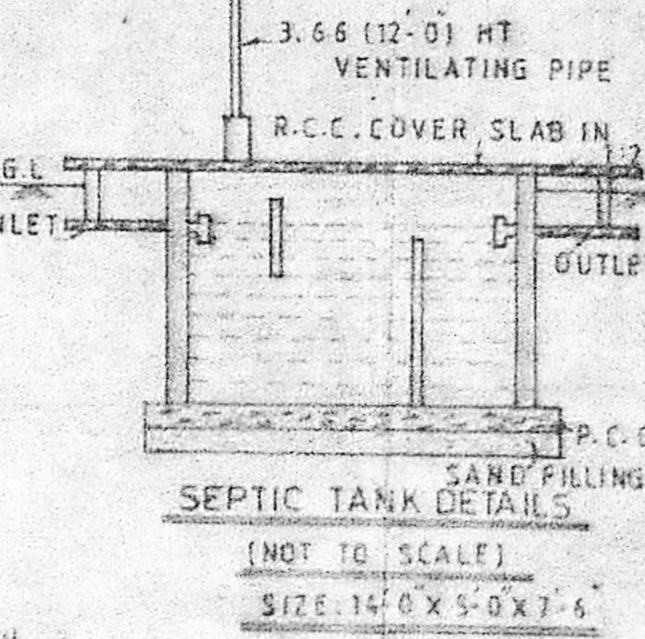


SEPTIC TANK DETAILS (NOT TO SCALE) SIZE: 14'0" X 5'0" X 7'6"




PLAN OF SEPTIC TANK

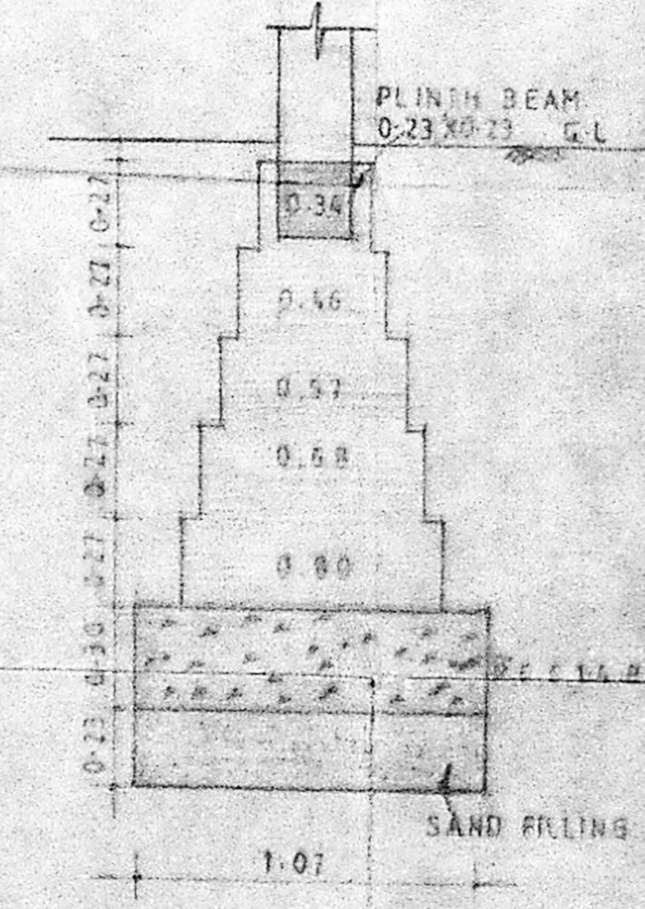

FOUNDATION DETAILS SCALE: 1:25

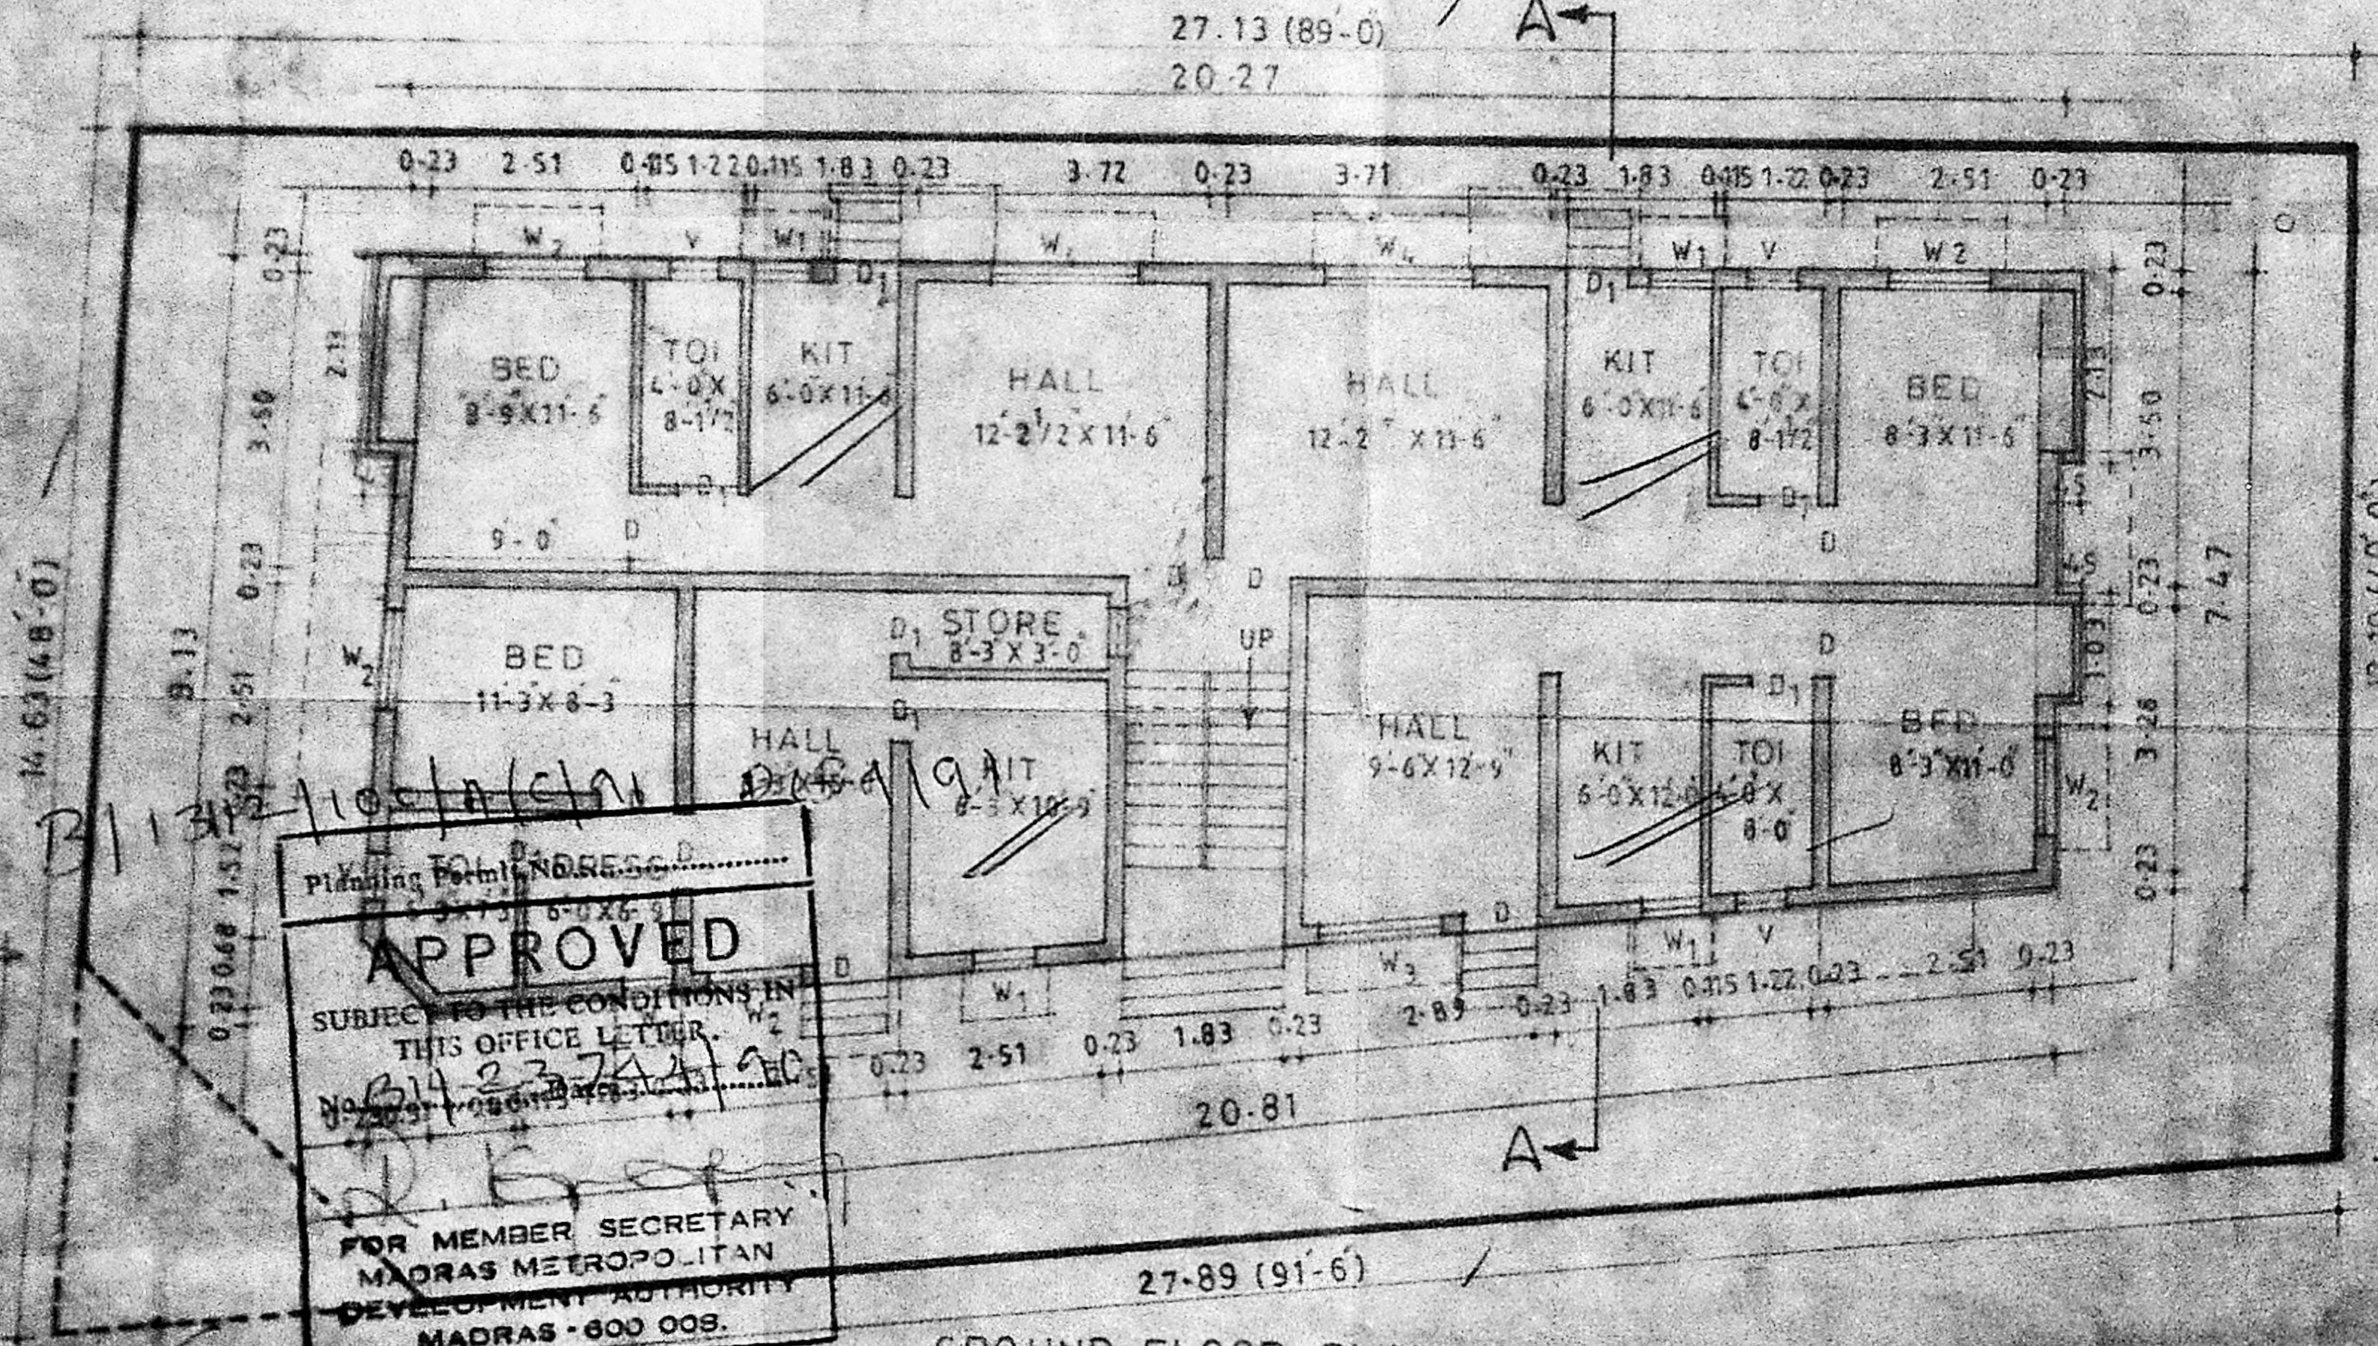

GROUND FLOOR PLAN

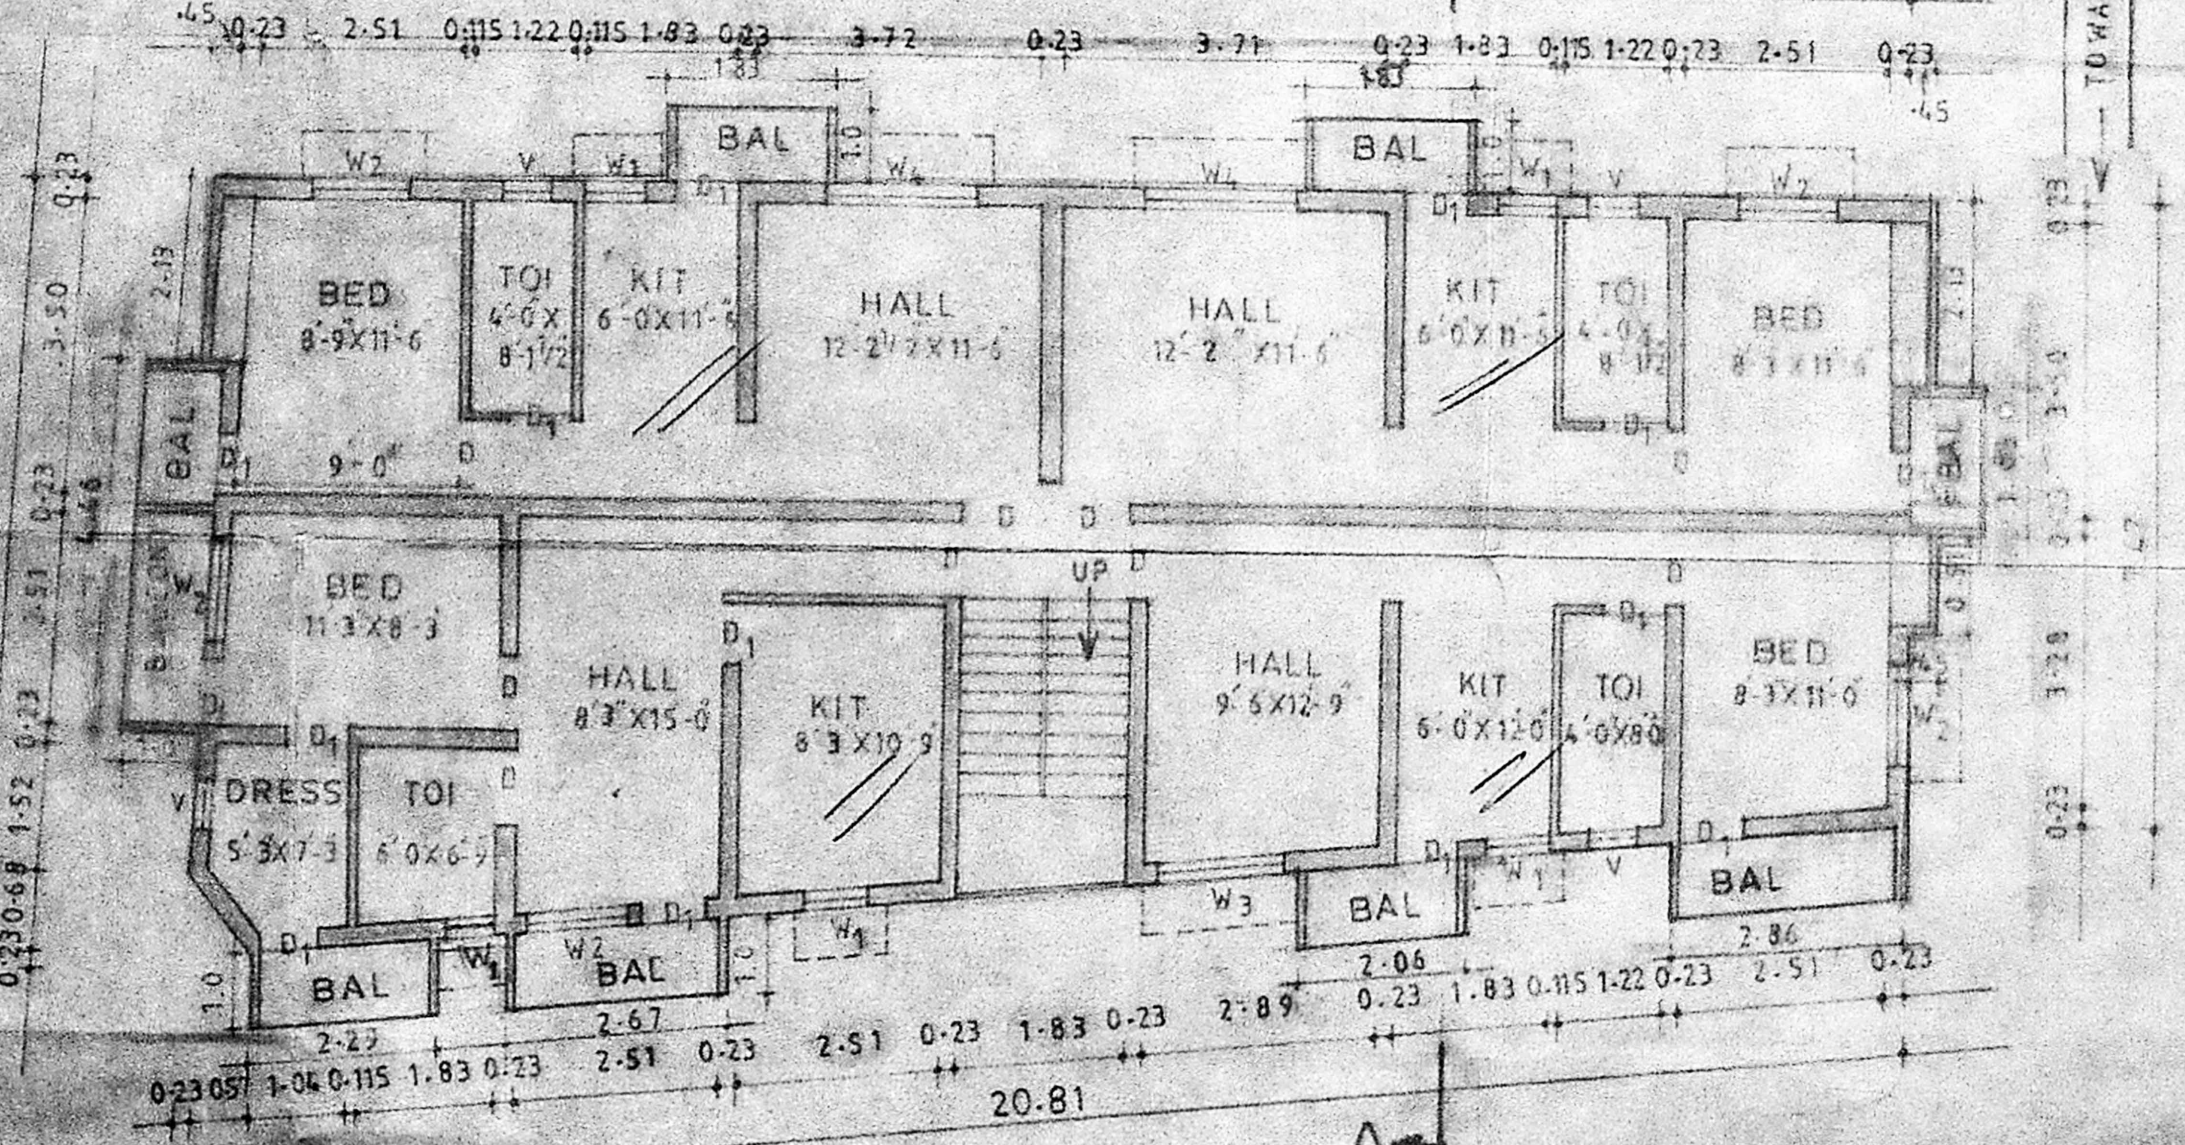

TYPICAL FLOOR PLAN (FIRST FLOOR SECOND FLOOR)

SCHEDULE OF JOINERY:

TYPE	DESCRIPTION	SIZE
W ₁	WINDOW	0.75 X 1.07
W ₂	WINDOW	1.22 X 1.37
W ₃	WINDOW	1.52 X 1.37
W ₄	WINDOW	1.83 X 1.37
V	VENTILATOR	0.61 X 0.91
D ₁	DOOR	0.76 X 1.98
D	DOOR	0.91 X 1.98

NOTE: ALL DIMENSIONS ARE IN METRE.
 MMDA B/PP/NO. 346/17/11
 REFERENCE: P.L. 23/24/99
 PROPOSED ROAD BOUNDARY
 EXISTING
 AREA STATEMENT
 PLOT AREA 511.91 346.17 M²
 GROUND FLOOR AREA 168.9 M²
 FIRST FLOOR AREA 149.20 M²
 SECOND FLOOR AREA 189.20 M²
 F.S.I.A.P. 1.25
 PLOT COVERAGE 51.7%
 TOTAL BUILT-UP AREA 547.30 M²


PROPOSED RESIDENTIAL FLAT AT PLOT NO. 26,
 VOLTAS STAFF COLONY EXTENSION,
 S NO 59/3 BIA TS NO 38,
 BLOCK NO.15 WARD NO D,
 NANGANALLUR, MADRAS-61.
 OWNER:

DRN BY: CHD BY:
 RATE: 9.99.90 SEAL: 1.10.8


ARCHITECTS:
suren associa

M M SURENDRAN, M.Arch. (I.I.T.I), M.T.P., M.I.P.A., M.C.A.
 P M G COMPLEX,
 57, SOUTH USMAN ROAD,
 T. NAGAR, MADRAS-17.

APPROVED
 SUBJECT TO THE CONDITIONS IN THIS OFFICE LETTER
 FOR MEMBER SECRETARY
 MADRAS METROPOLITAN
 DEVELOPMENT AUTHORITY
 MADRAS - 600 009.

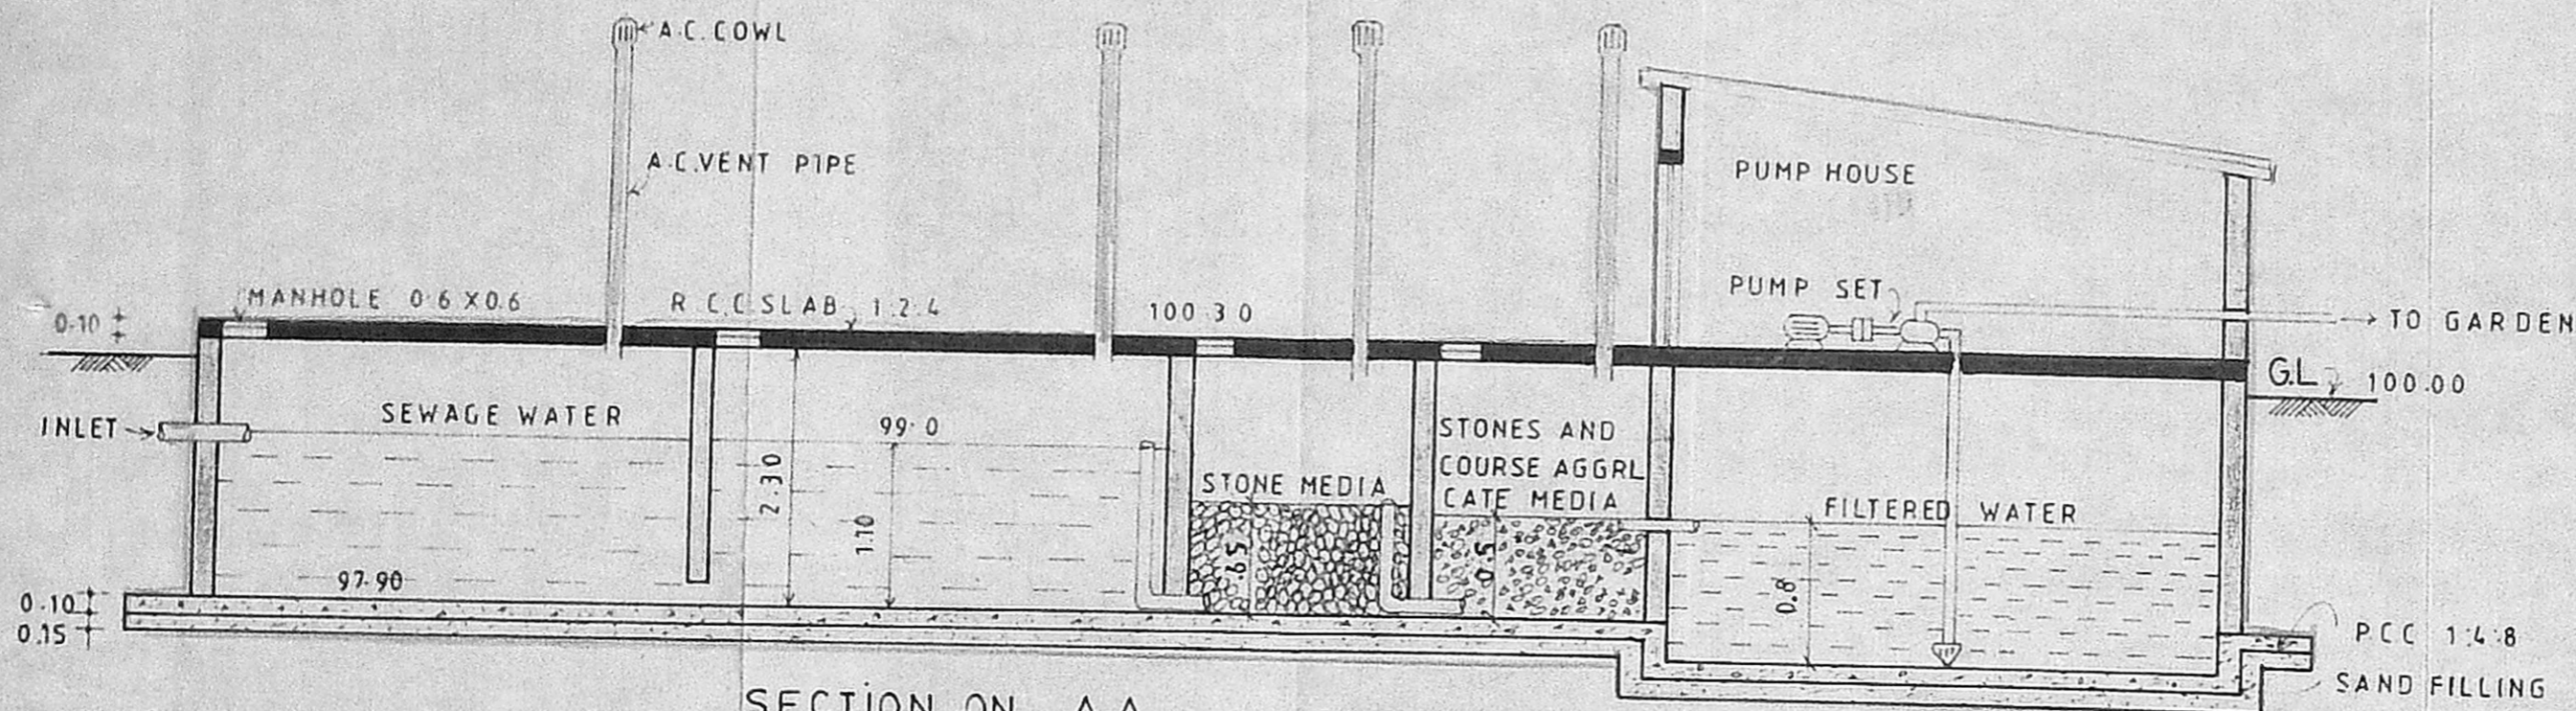

SECTION ON A-A

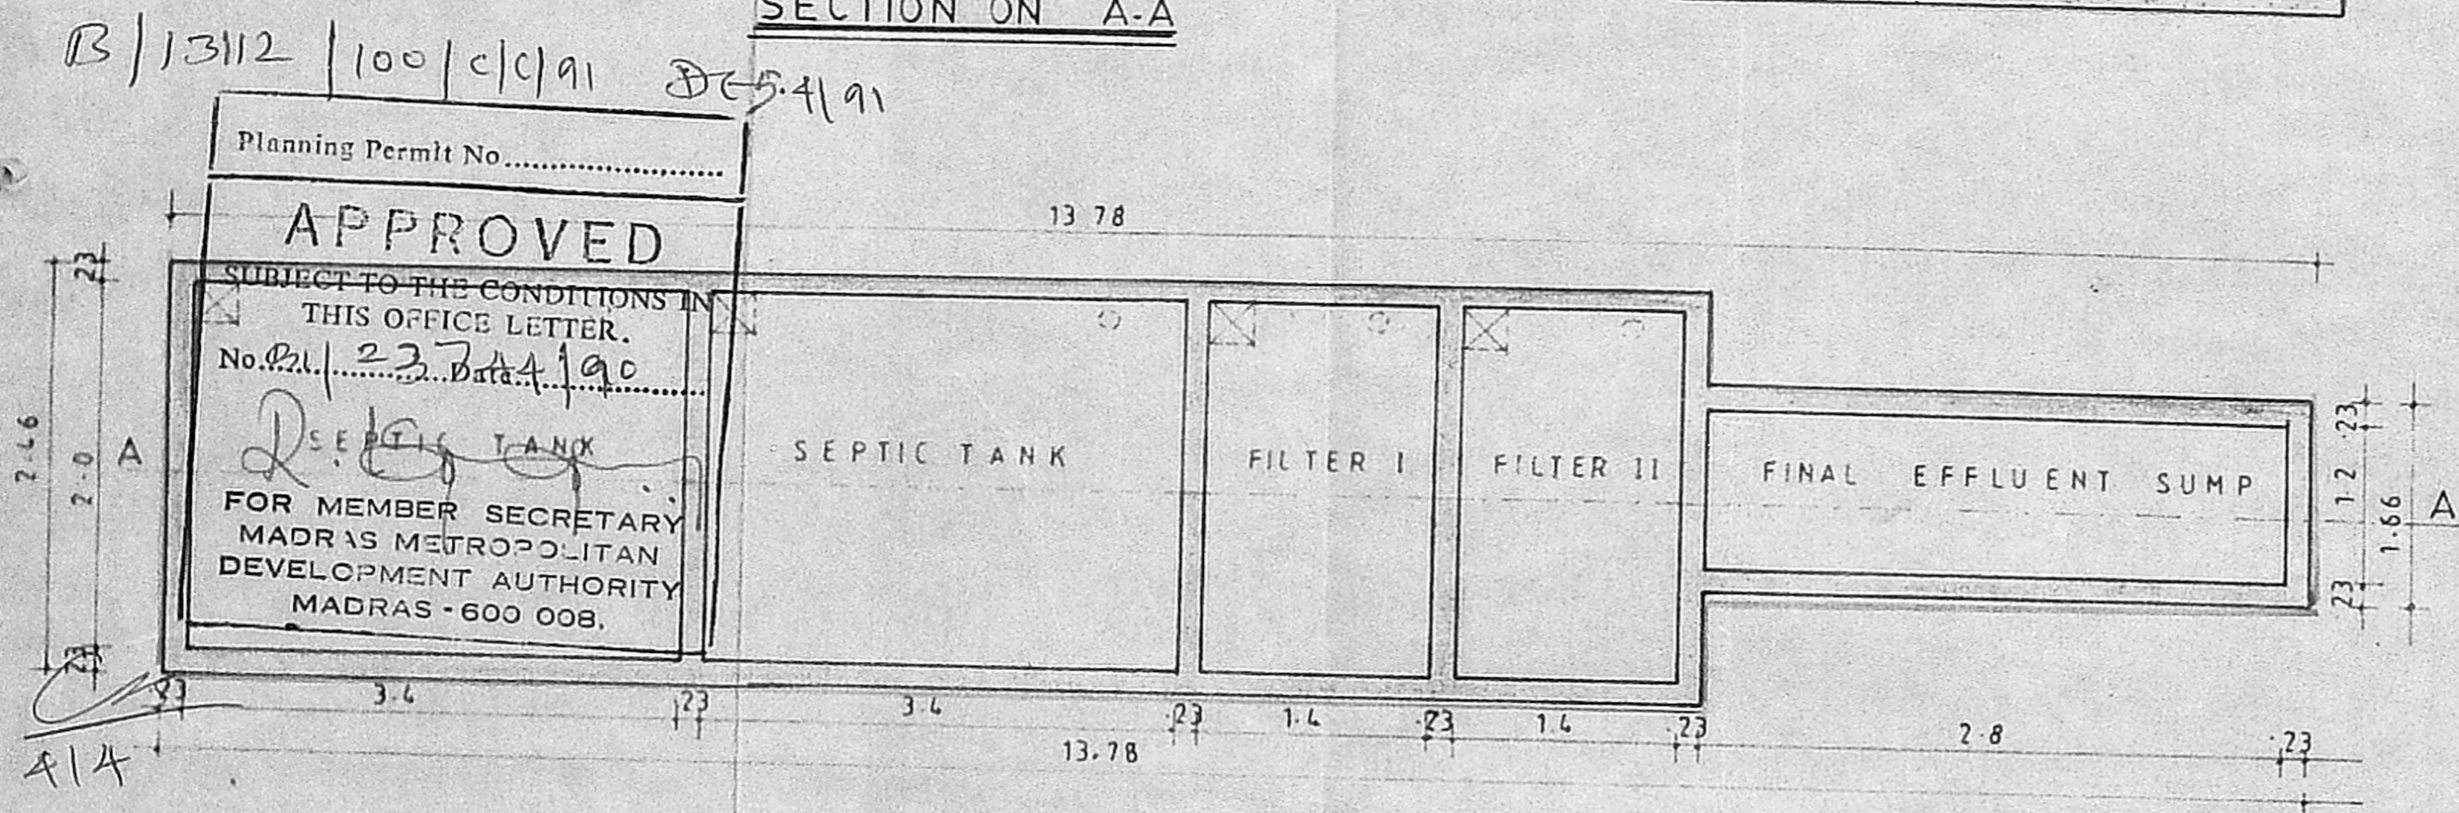

PLAN

Planning Permit No.
APPROVED
 SUBJECT TO THE CONDITIONS IN THIS OFFICE LETTER.
 No. B.1/23744/90
 23.7.4.190
 SEPTIC TANK
 FOR MEMBER SECRETARY
 MADRAS METROPOLITAN
 DEVELOPMENT AUTHORITY
 MADRAS - 600 008.

ADDRESS:

Design of SEPTIC TANK
 with Up Flow Filters,
 for the Proposed
 Residential Flat at,
 Plot no:26, Voltas Staff
 Colony Extention, s.no:53/3
 B 1A, T.S. no:38, Block 15, ward D
 NANGANALLUR, Madras 51.

DATE: 12-2-91.

NOTE: DIMENSIONS ARE ALL IN METRE.
 DRAWINGS ARE NOT TO SCALE

OWNER:

MMDA (B/PP No. /
 C.No. B.1/23744/90
 ANN. T.S. Sundaram
 Secretary
 PART I 25/2

LICENCED PLUMBER

A.P.

D.P.

C. Ravi Shankar

C. RAVI SHANKAR, B.E., M.I.S.T.E.

Licenced Plumber,

M.M.W.S.S. BOARD,

48/10, C.P.W.D. Quarters,

K.K. NAGAR, MADRAS - 600 078.