




FRONT ELEVATION

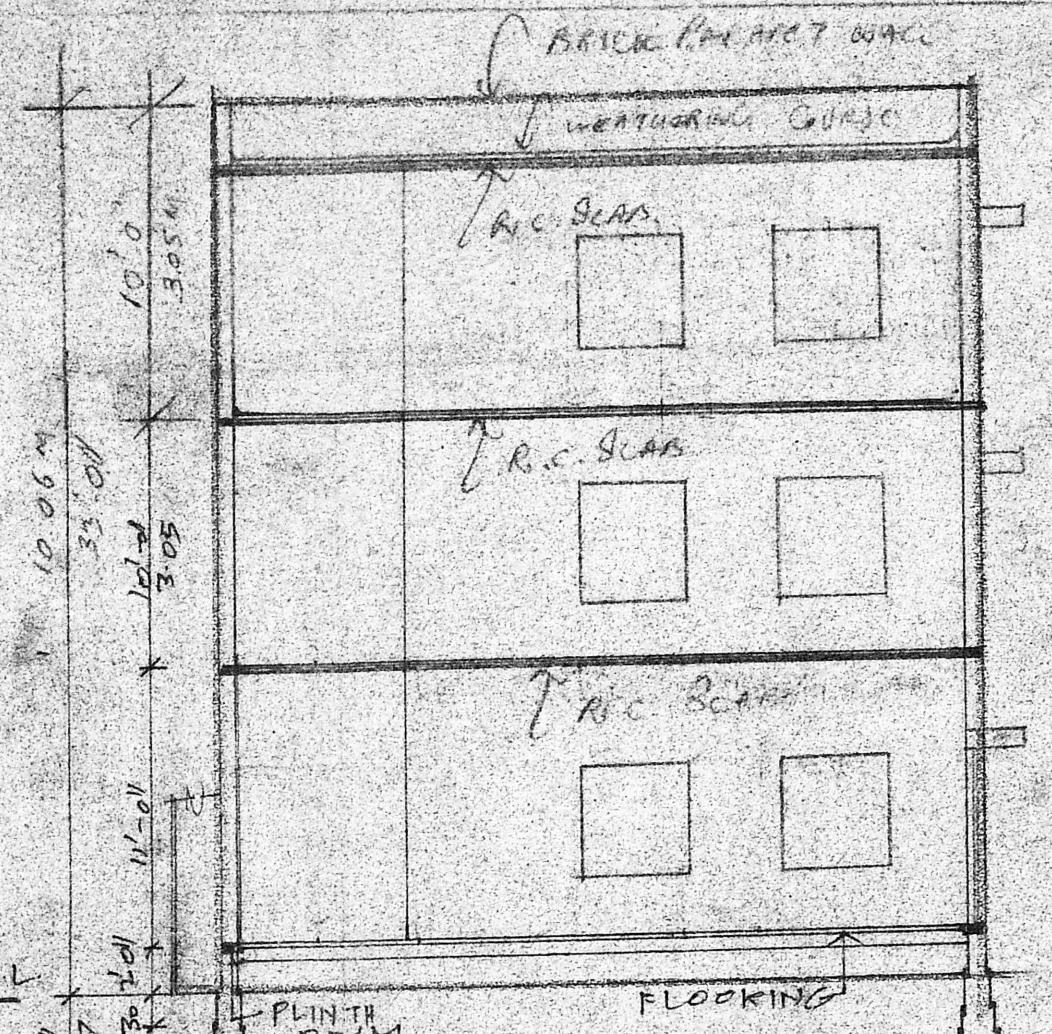


SECTION 'AA'

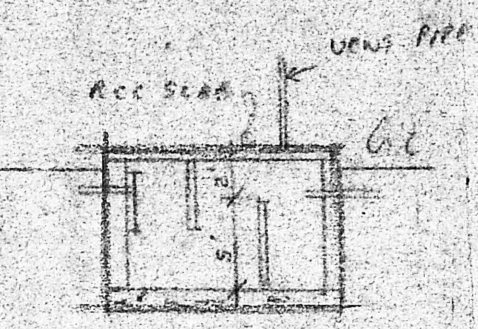

SECTION OF SEPTIC TANK

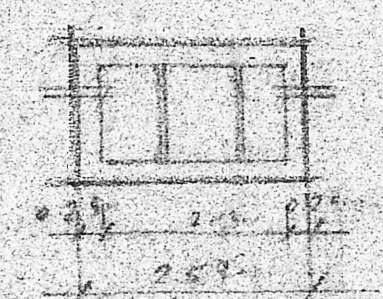

PLAN OF SEPTIC TANK

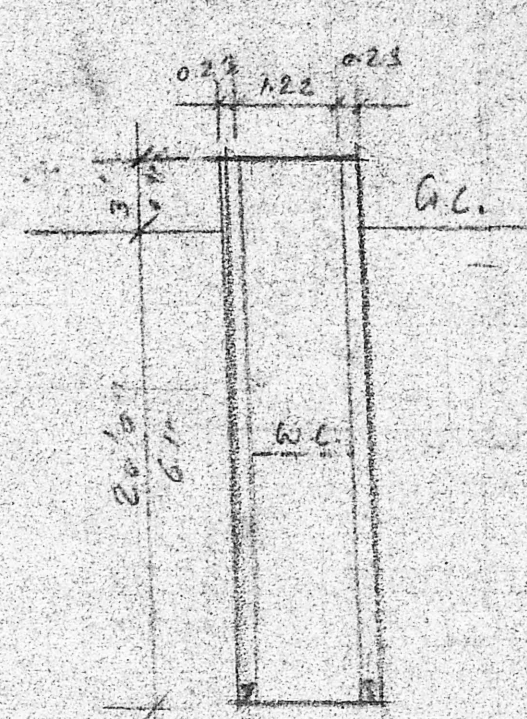

DETAIL OF SEPTIC TANK
SCALE 1:75

Planning Permit No. CP/158/90

APPROVED

SUBJECT TO THE CONDITIONS IN THIS OFFICE LETTER.

No. C2/5980/90 Date 1-8-73

FOR MEMBER SECRETARY
MADRAS METROPOLITAN
DEVELOPMENT AUTHORITY
MADRAS - 600 008.

KEY PLAN
NOT TO SCALE

Planning Permit No.

APPROVED

SUBJECT TO THE CONDITIONS IN THIS OFFICE LETTER.

No. Date

FOR MEMBER SECRETARY
MADRAS METROPOLITAN
DEVELOPMENT AUTHORITY
MADRAS - 600 008.

JOINERY DETAILS:		RS ROLLING SHUTTER 1-83x2-00	
D1 DOOR	1-00x2-00	W WINDOW	1-22x1-39
D2 DOOR	0-76x2-00	V VENTILATOR	0-31x0-61
AREA STATEMENT		SA. FT.	SA. M.
PLOT EXTENT		3720	364
GROUND FLOOR		800	74.34
FIRST FLOOR		800	74.34
SECOND FLOOR		800	74.34

LEGEND:
 PRO. WORK
 EXG. STREET
 PLOT OUTLINE

SCALE 1:100


PLAN SHOWING THE PROPOSED CONSTRUCTION OF FACTORY SHED AT PLOT NO. 2A IN S. NO. 27 MADURAVOYAL VILLAGE, SAIDAPET TK, CHINGLEPUT DT. ICE FACTORY WITH INSTALLATION OF 20 H.P.

K Venugopal
 K VENUGOPAL
 CONSULTING CIVIL ENGINEER
 LICENSE SURVEYOR CLASS I
 CORPORATION OF MADRAS


A. Vinayaga Murthy

SIG. OF OWNER:


SIG. OF LICENSED SURVEYOR:

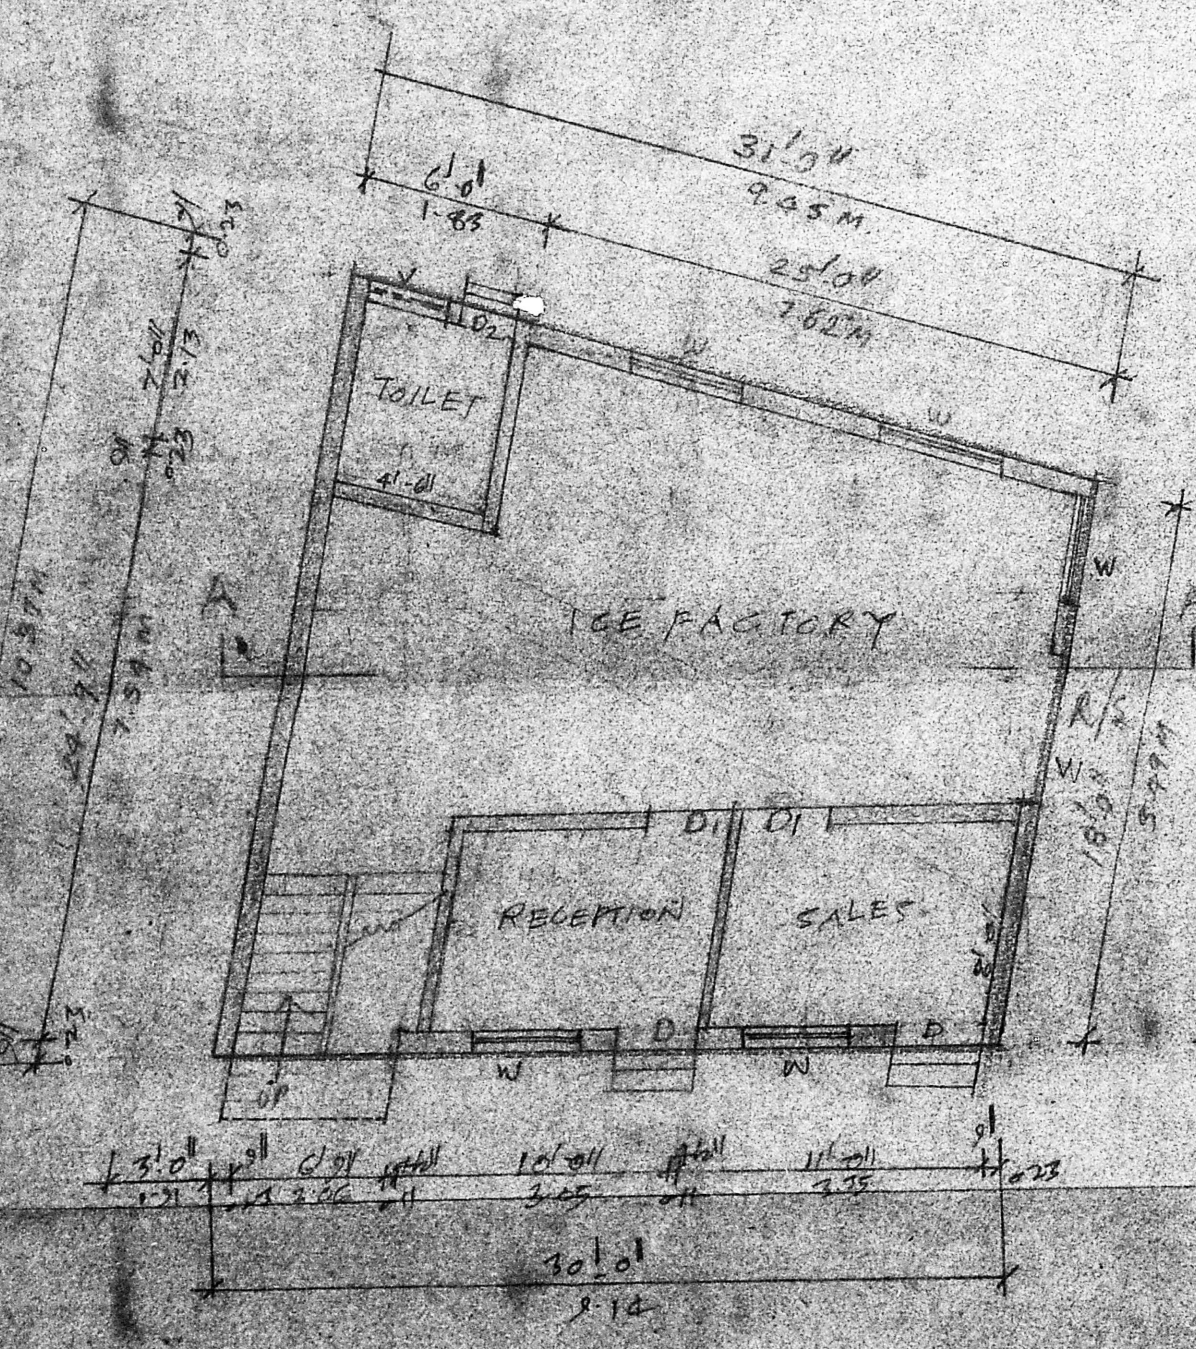

GROUND FLOOR PLAN

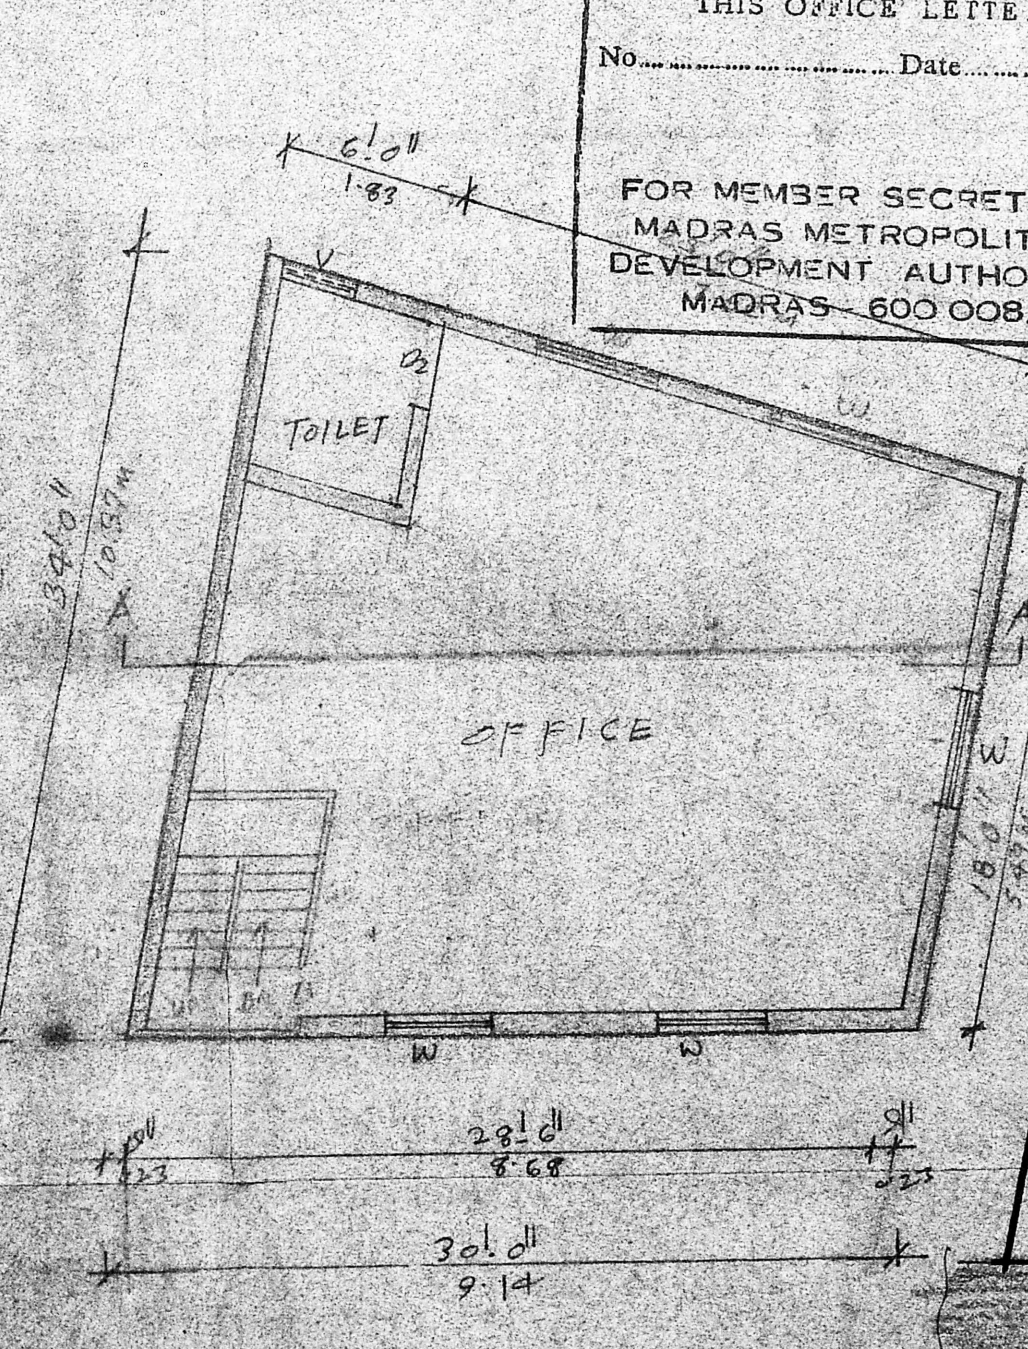

TYPICAL FLOOR PLAN
(FIRST AND SECOND FLOOR)

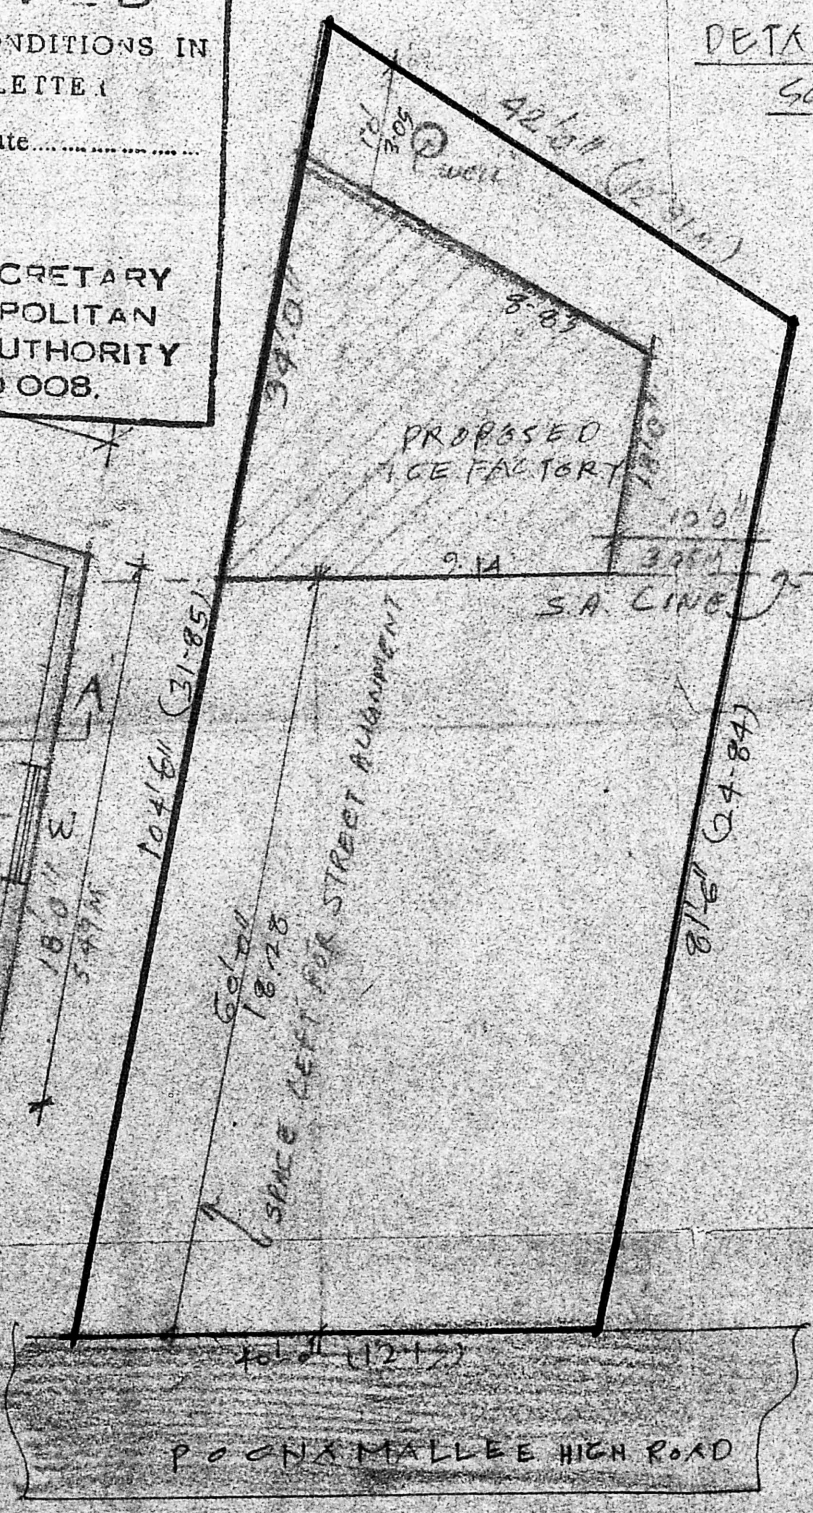

SITE PLAN
SCALE 1:200