



ELEVATION.

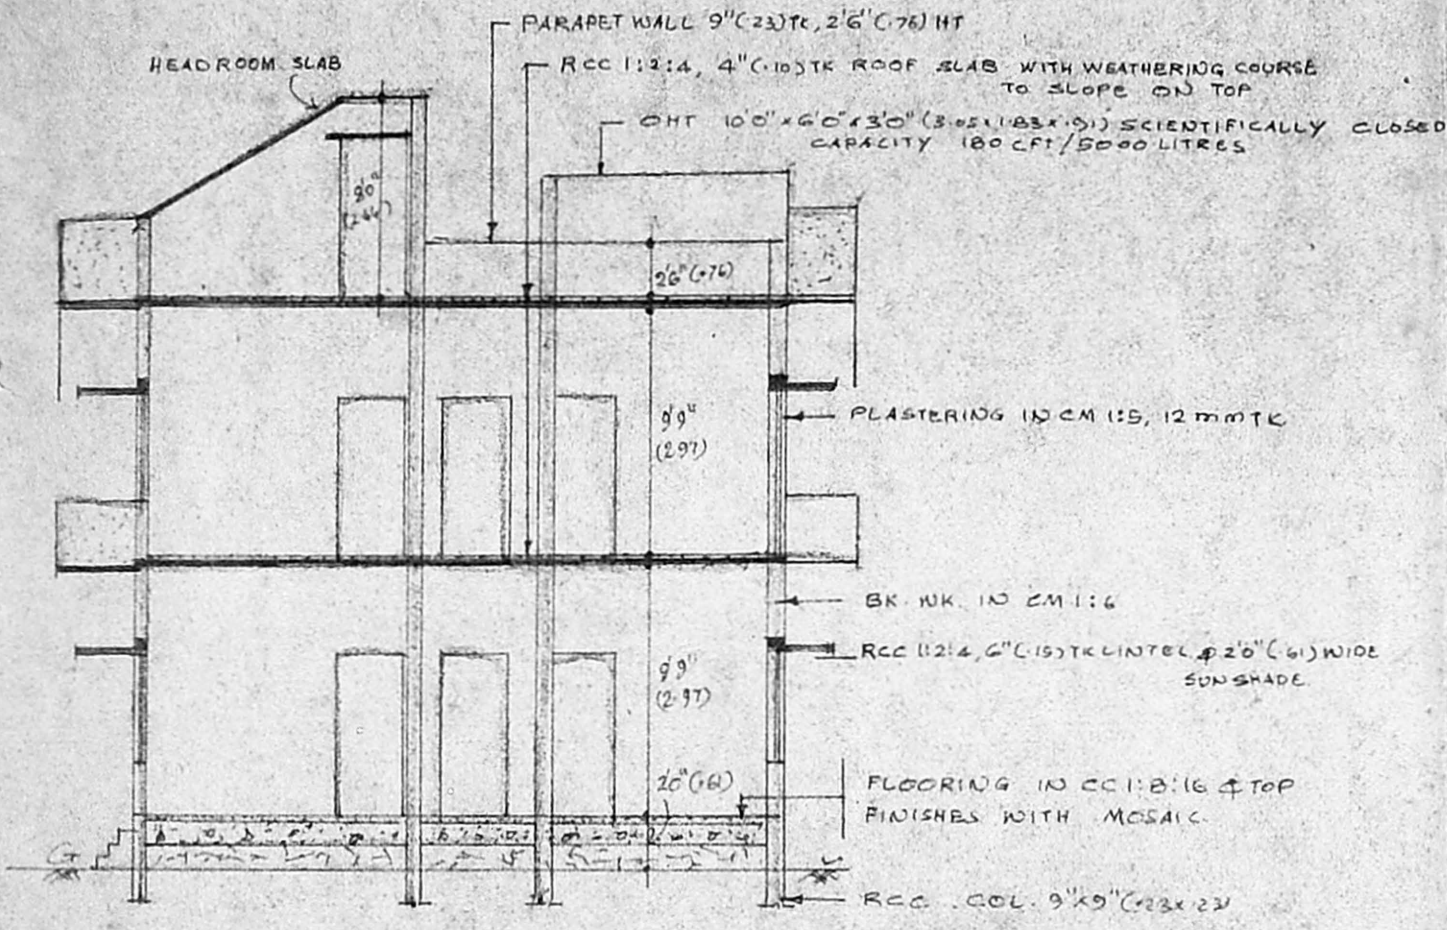


SECTION ON 'AA'.

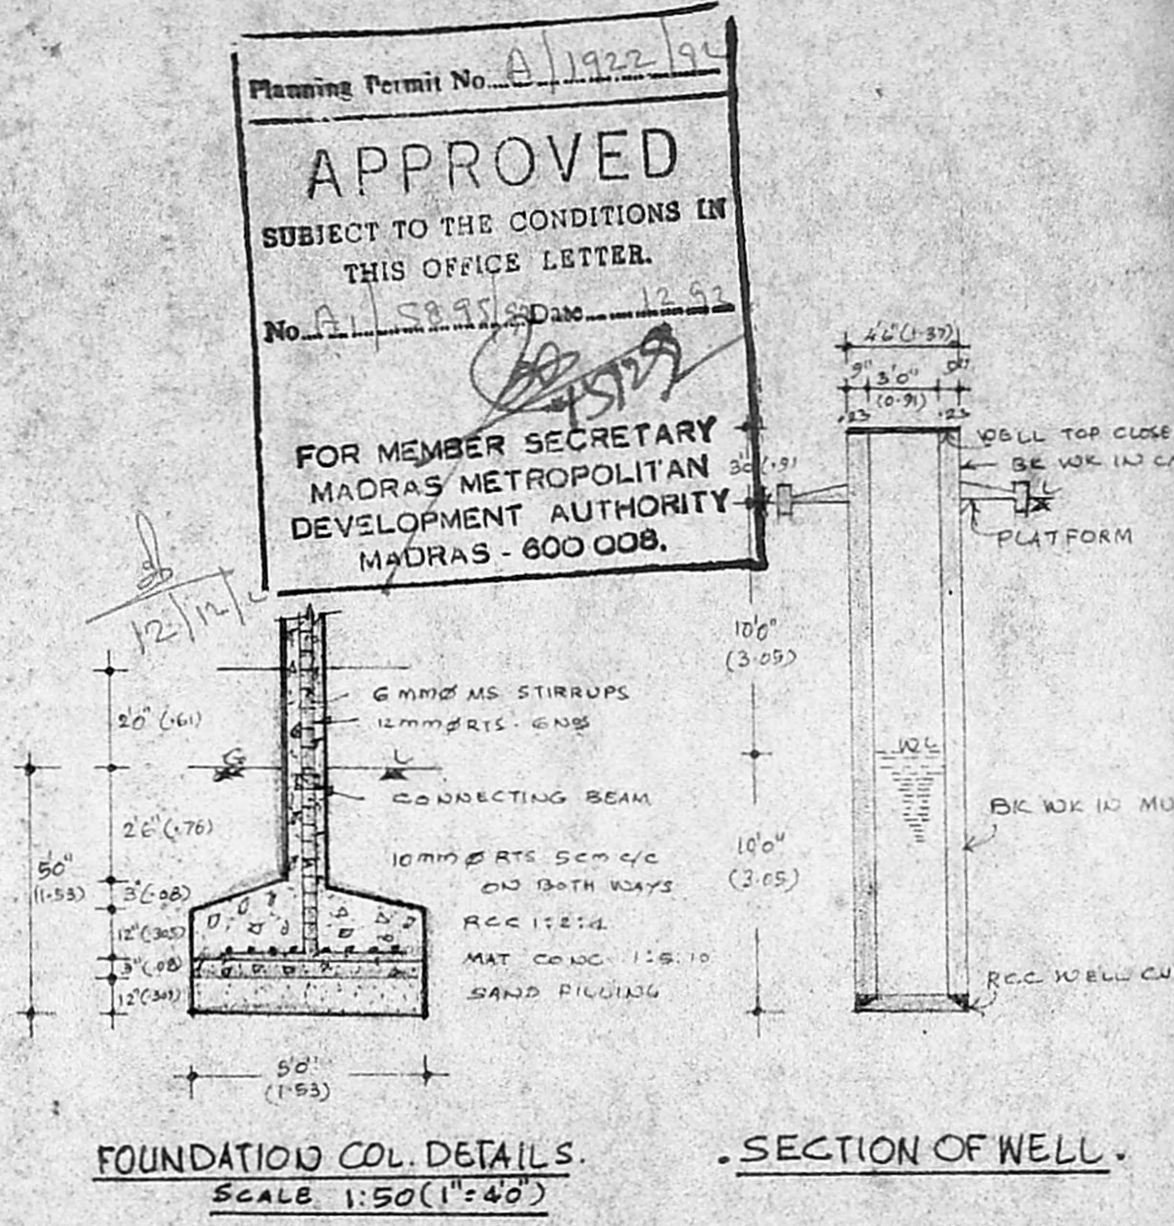


FOUNDATION COL. DETAILS.
SCALE: 1:50 (1"=40')


SECTION OF WELL.

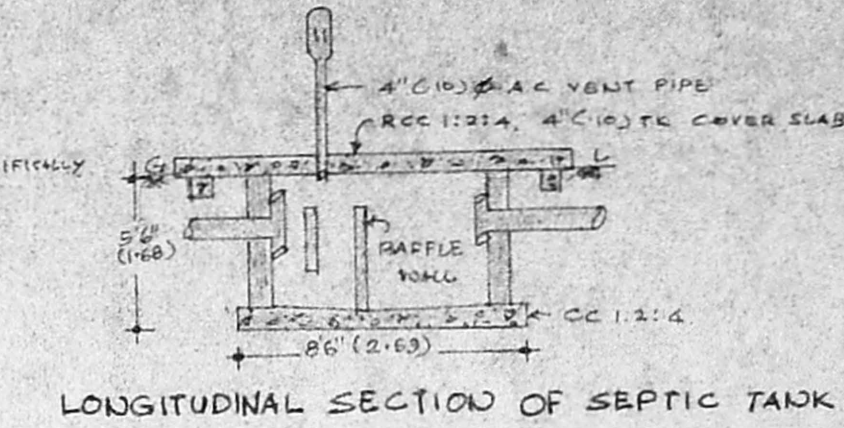

LONGITUDINAL SECTION OF SEPTIC TANK.

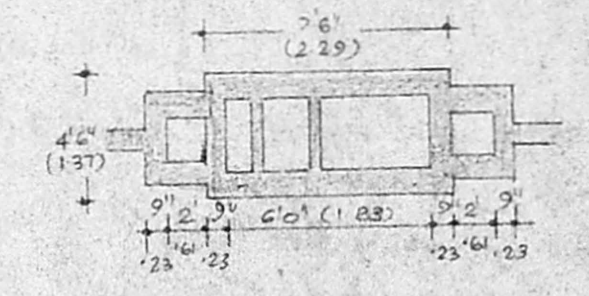

PLAN OF SEPTIC TANK.
SCALE: 1:300

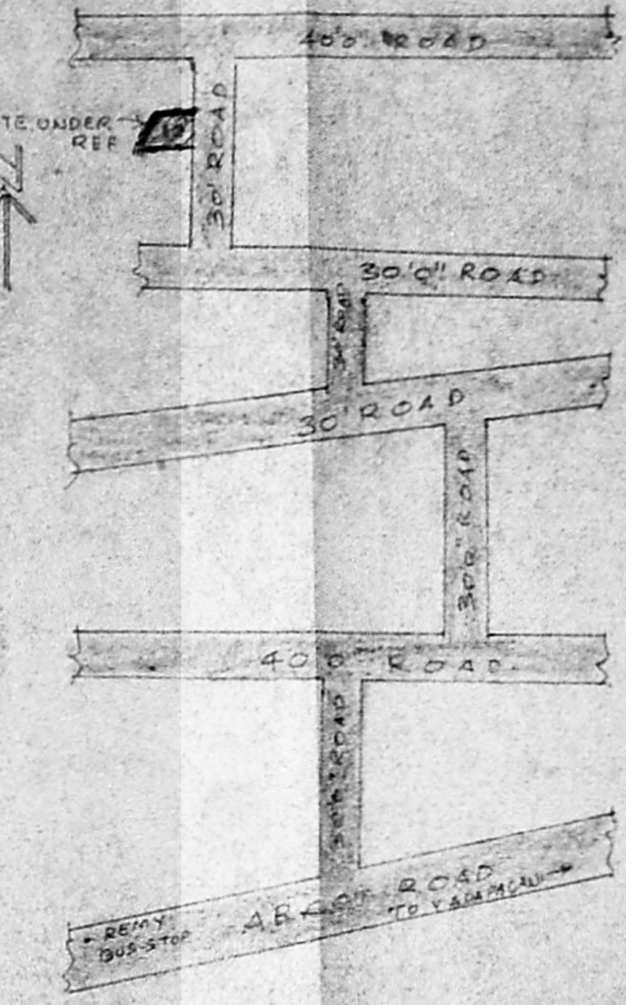

KEY PLAN.
NOT TO SCALE.

REFERENCE:


- D. DOOR 3'3" x 6'6" (1.00 x 2.00)
- D. DOOR 3'0" x 6'6" (0.91 x 2.00)
- D. DOOR 2'6" x 6'0" (0.76 x 1.83)
- W. WINDOW 2'8" x 4'6" (0.72 x 1.37)
- W. WINDOW 3'0" x 4'6" (0.91 x 1.37)
- V. VENTILATOR 2'6" x 1'6" (0.76 x 0.49)

NOTE:


- PROPOSALS
- ROAD
- BOUNDARY

AREA DETAILS.


PLOT AREA : 2775 SQ. FT. (257.80M²)
 PLOTH AREA : G.F. : 1476.78 SQ. FT. (137.20M²)
 B.F. : 1672.22 sq. ft. (154.60M²)
 TOTAL : 3149.00 sq. ft. (292.40M²)
 F.S.I. : 1.14
 PLOT COVERAGE : 53.20%

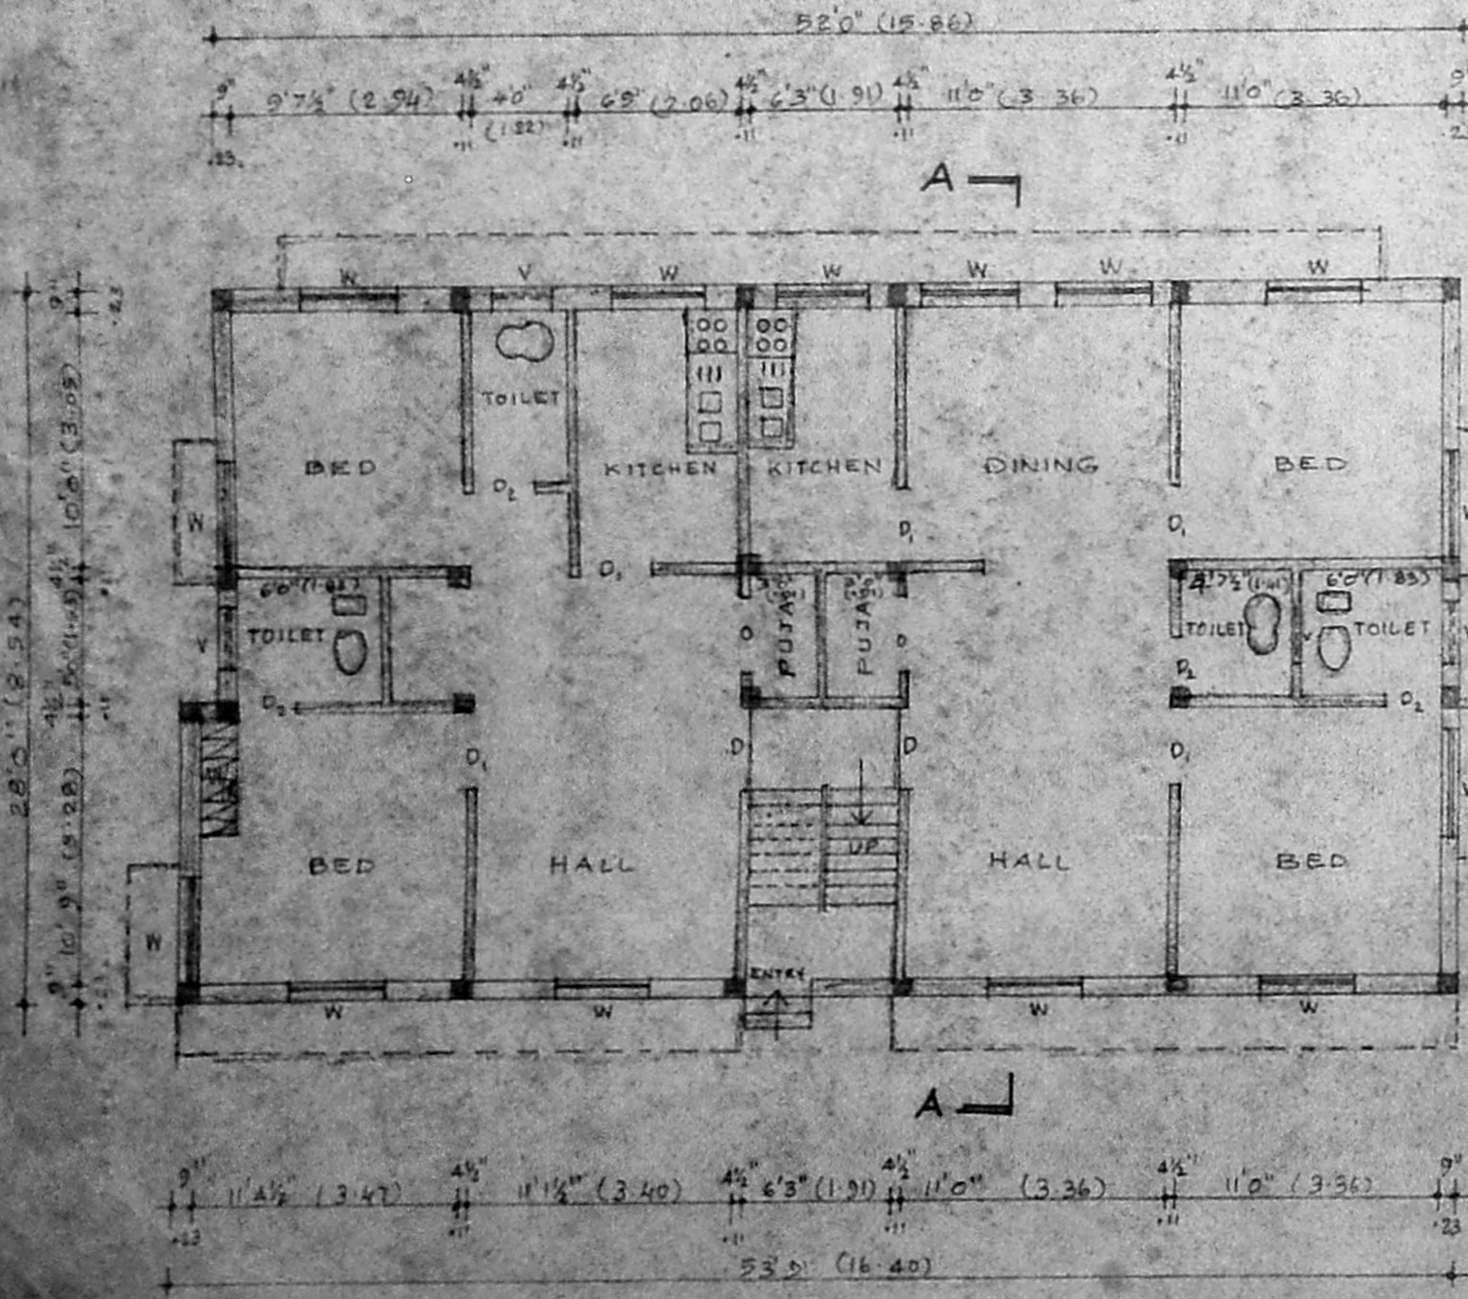


GROUND FLOOR PLAN.

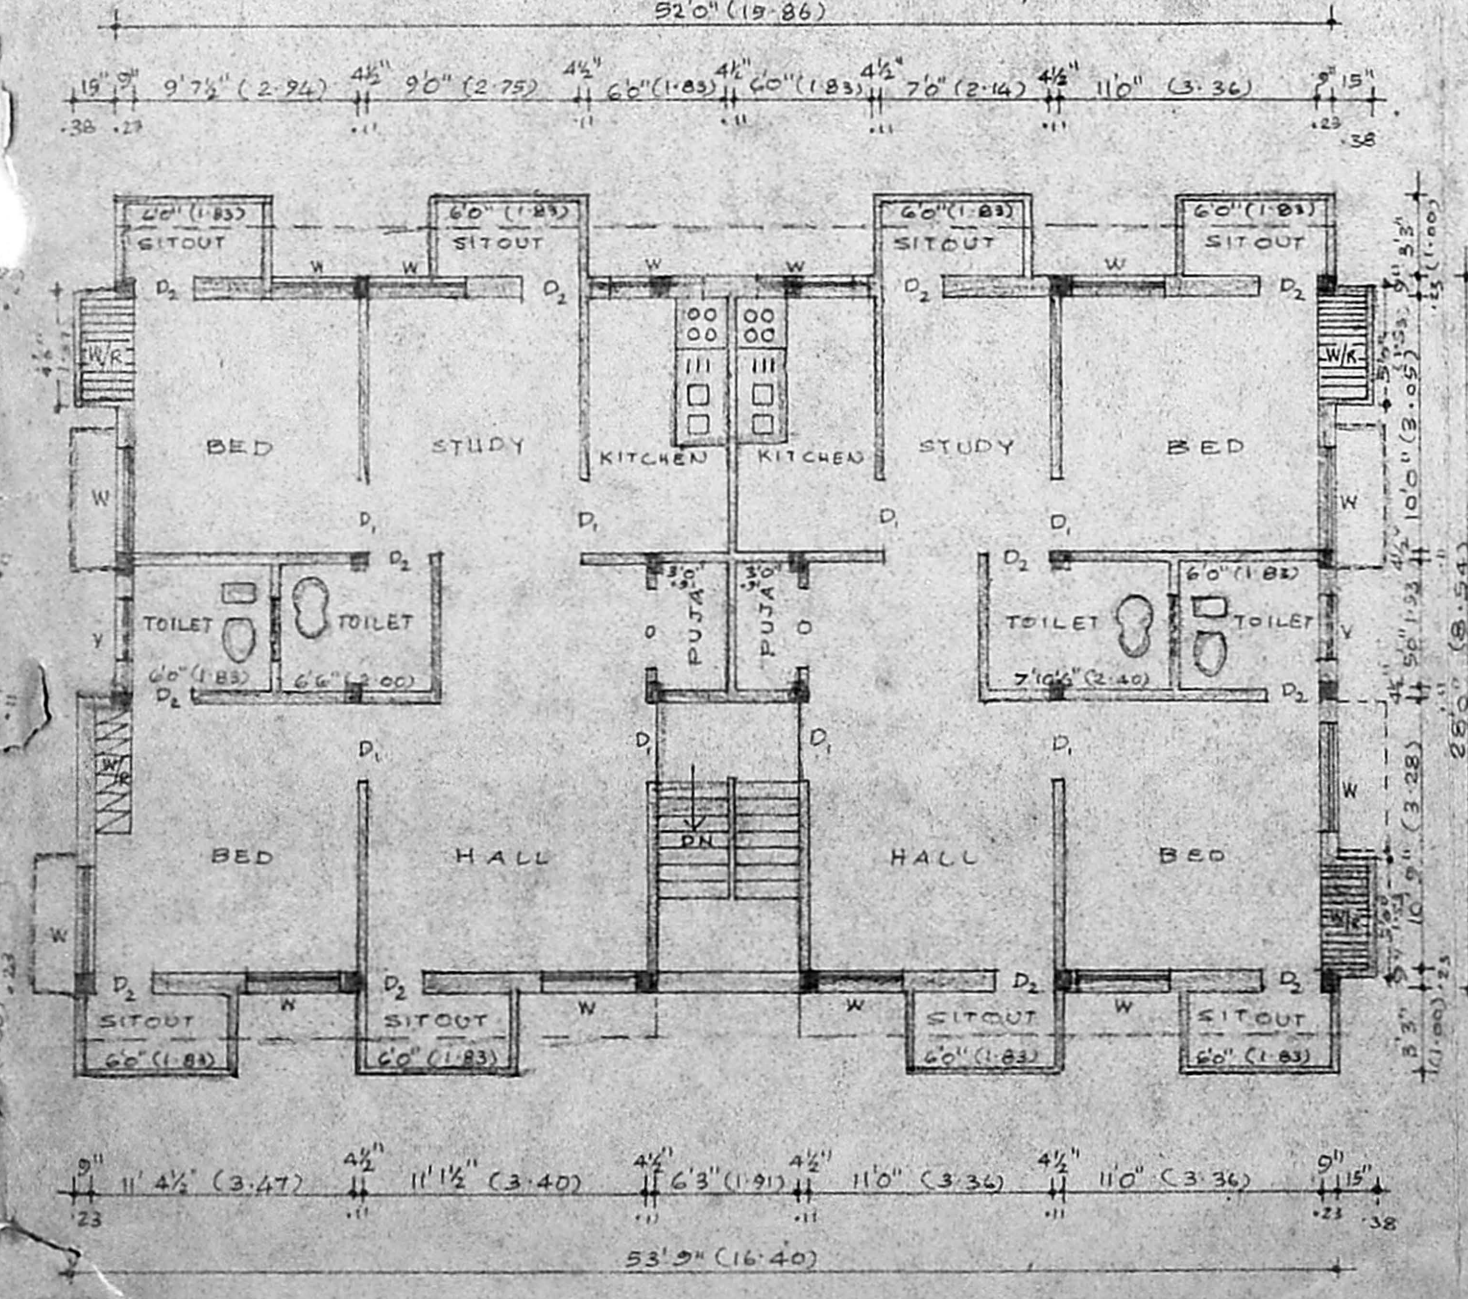

FIRST FLOOR PLAN.

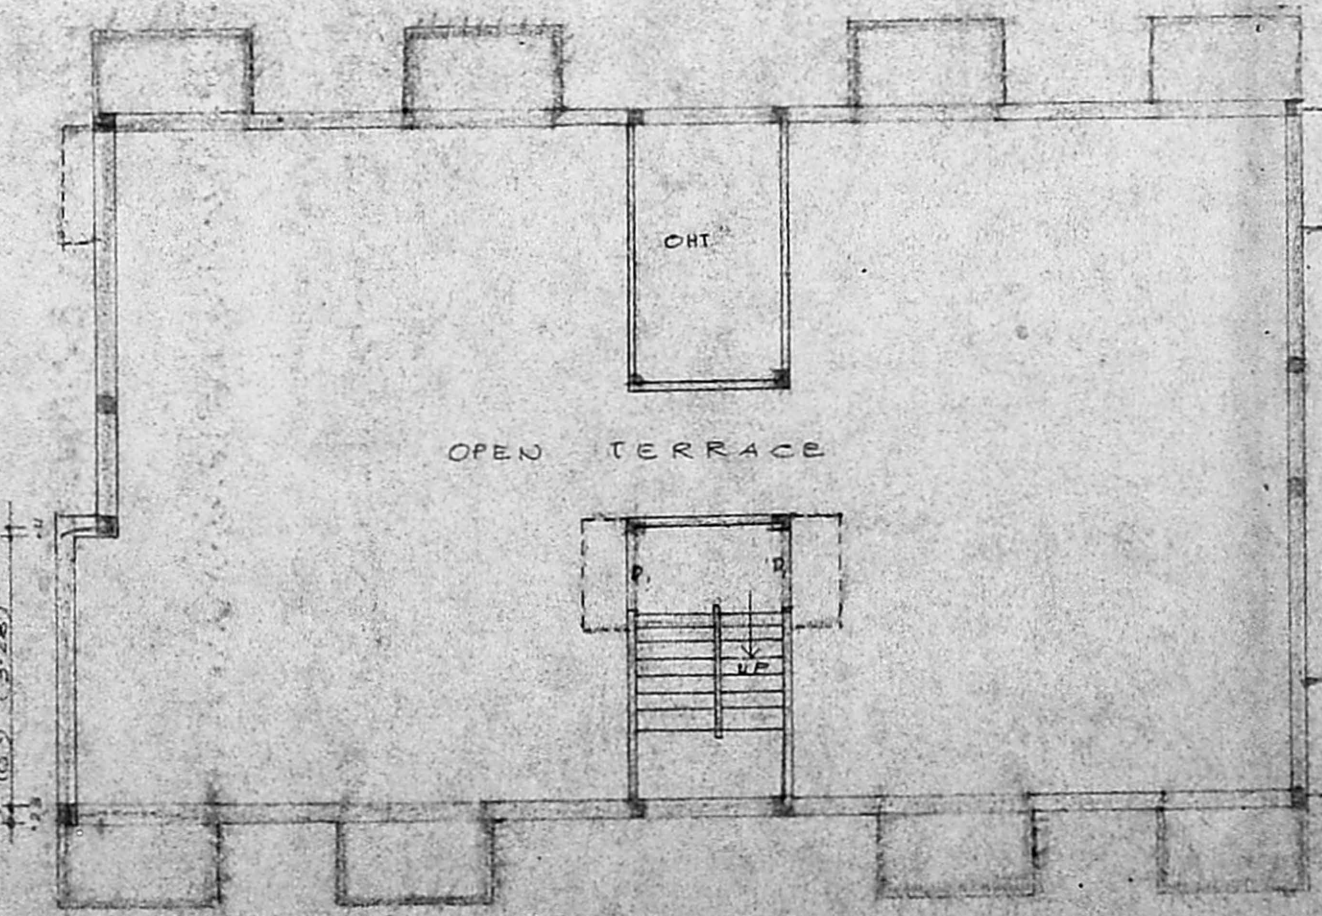

TERRACE FLOOR PLAN.

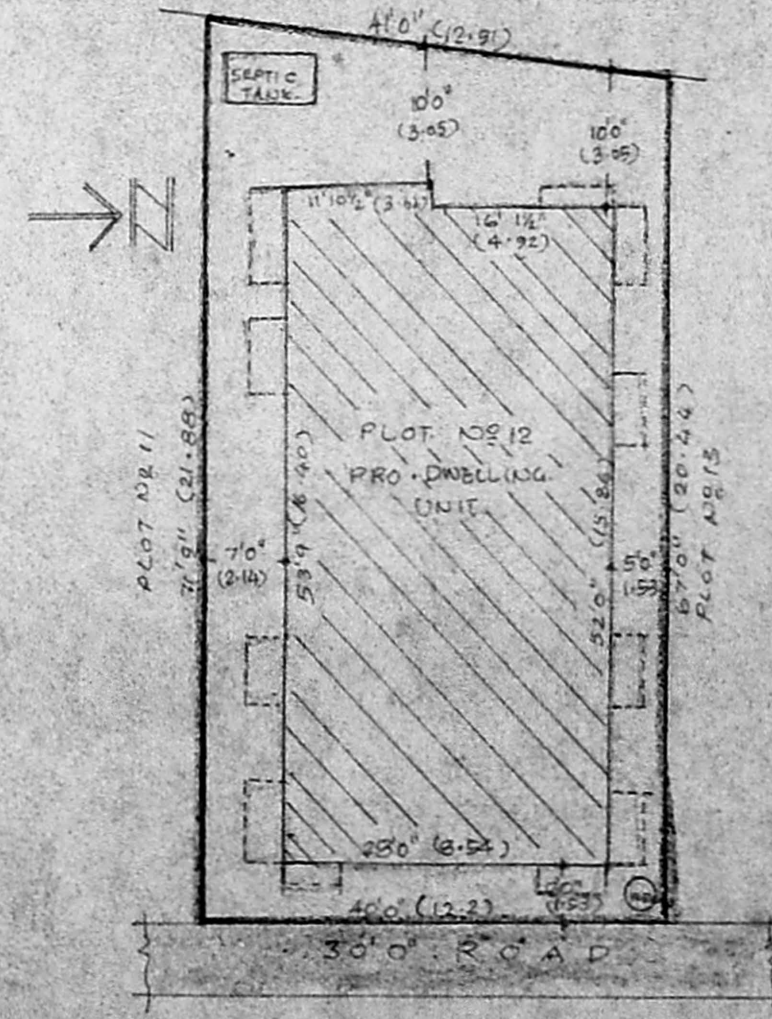

SITE PLAN
SCALE: 1:200 (1"=80')

PLAN SHOWING THE PROPOSED CONSTRUCTION OF THE DWELLING UNITS AT PLOT NO 12 IN S.NO 182 OF VIRUGAMBAKKAM "LAKSHMI NAGAR" SAIDAPET, CHENGLEPUT-MGRD LAYOUT APPD IN LPDM/DTP NO 128/72.
SCALE: 1:100 (1"=80')

S. Manarajam

OWNER.
P.A. HOLDER.

T.S. Balasundaram
 T.S. BALASUNDARAM, L.C.B.
 (P.E.) Registered Engineer in Charge M.C.C.
 Class 1. Licenced No. 450
 CORPORATION OF MADRAS,
 100, ELLIOTT ROAD,
 VELLALA TOWER, 1ST,
 MADRAS - 600 088.

LICENSED SURVEYOR.