




FRONT ELEVATION

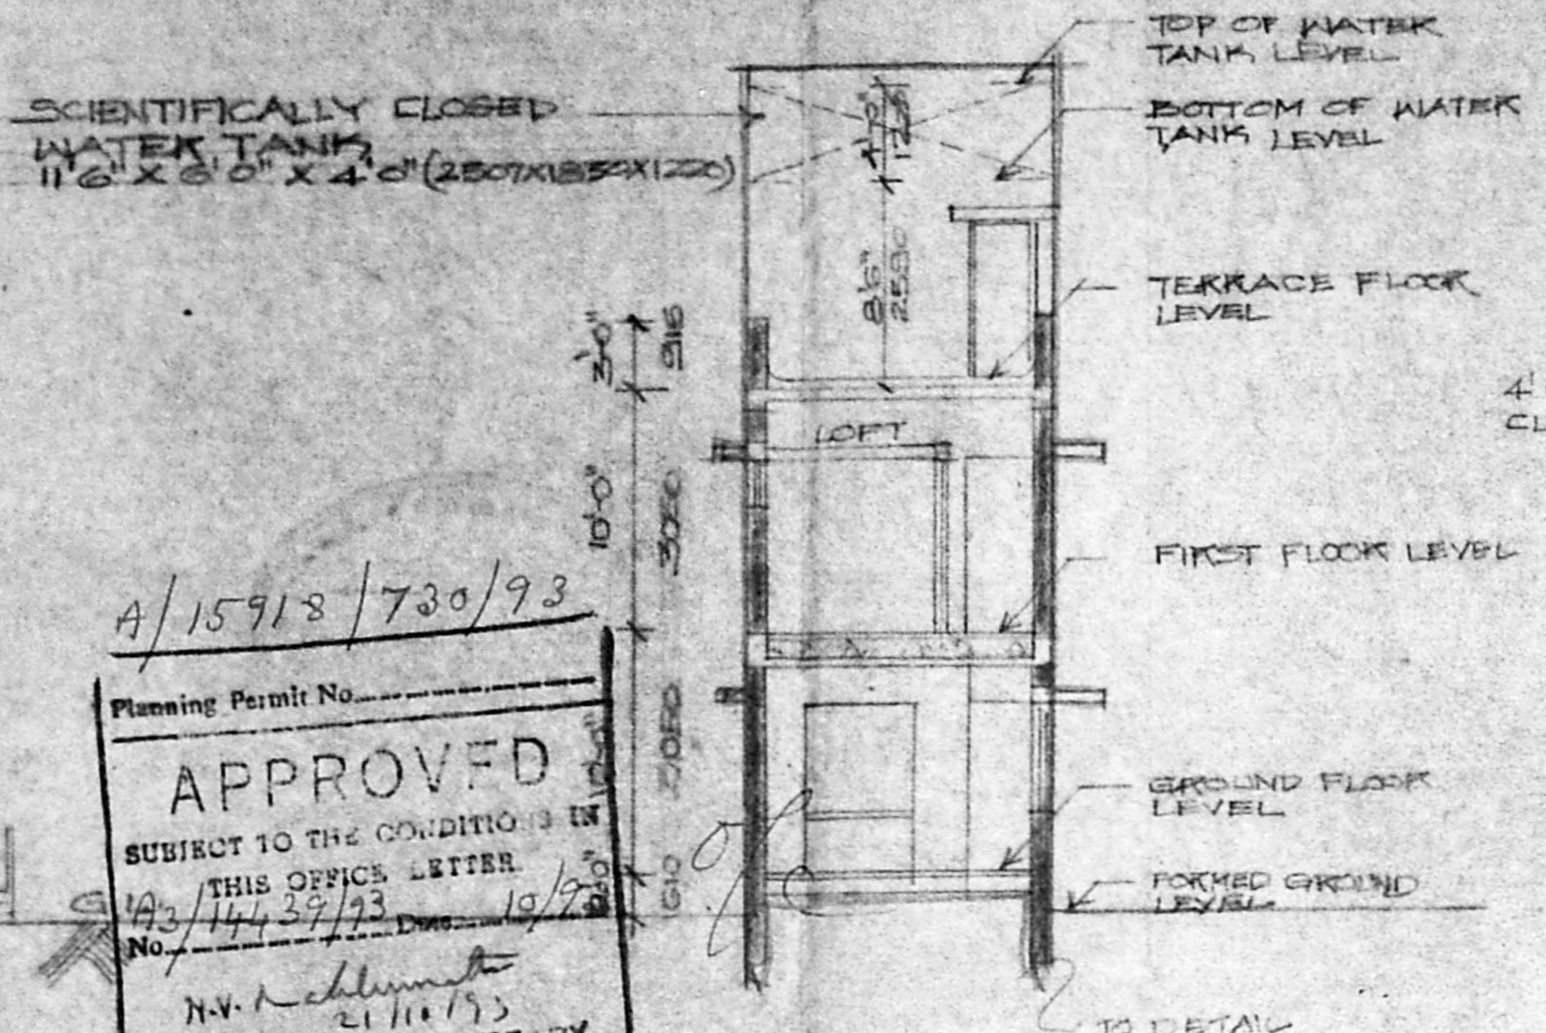


SECTION 'AB'

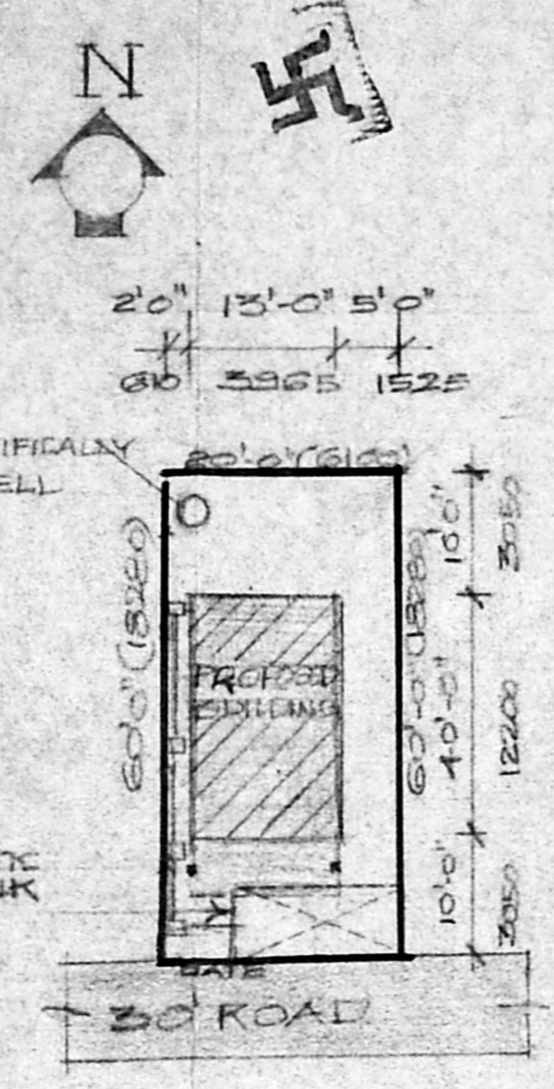


SITE PLAN SCALE 1" : 16'-0"

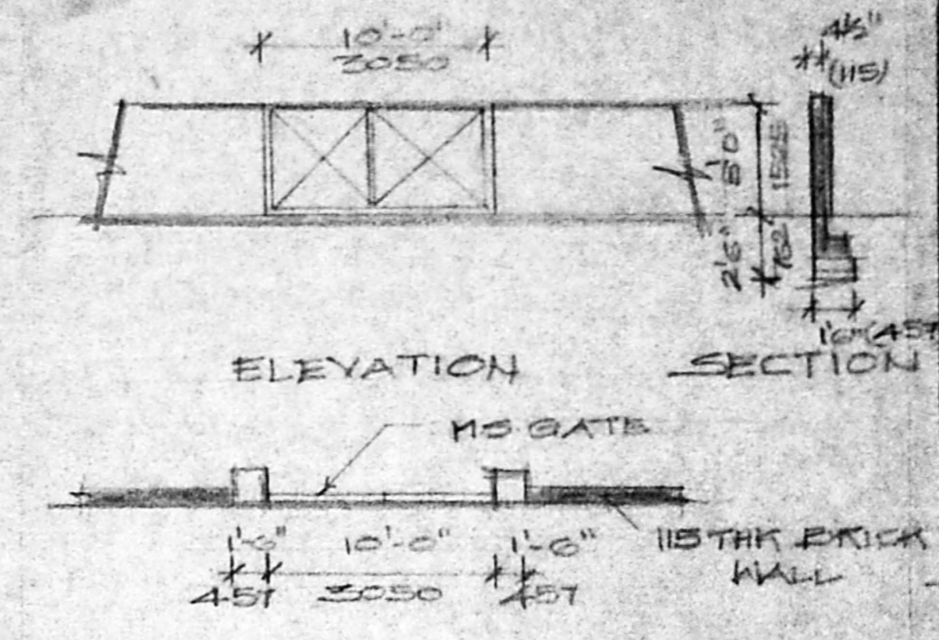

COMPOUND WALL & GATE DETAIL PLAN

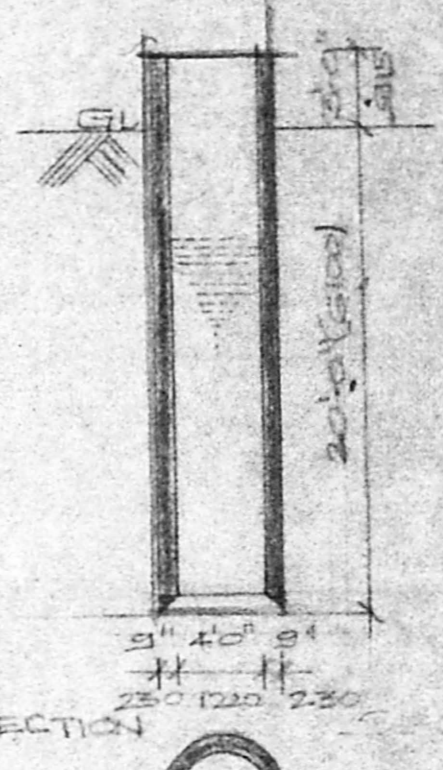

WELL DETAIL PLAN

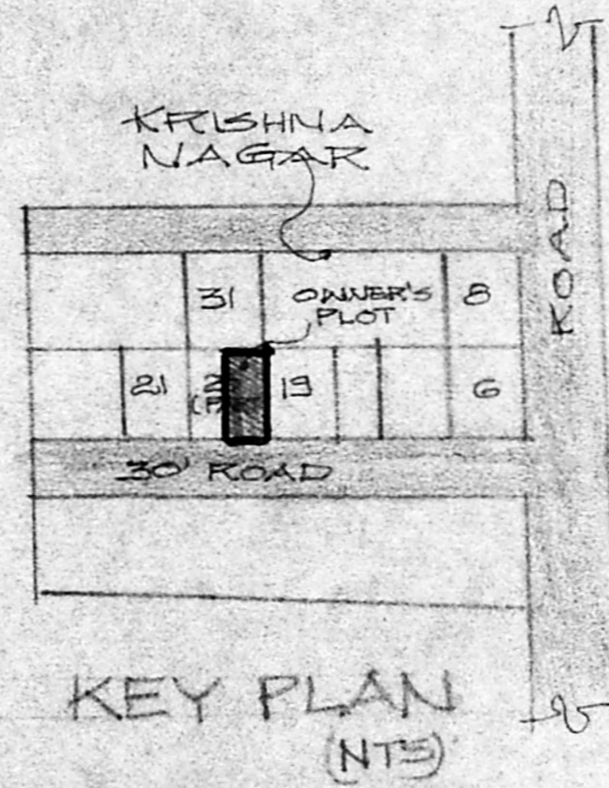

KEY PLAN (NTS)

Planning Permit No. **APPROVED**
 SUBJECT TO THE CONDITIONS IN THIS OFFICE LETTER
 No. 143/144/39/93 Date 19/9/93
 N.V. Reddy
 FOR MEMBER SECRETARY
 MADRAS METROPOLITAN
 DEVELOPMENT AUTHORITY
 MADRAS - 600 006.

SPECIFICATION
 FOUNDATION USING P.C.C. 1:4:4
 BED BLOCK WITH 5-W FOOTING
 SUPER STRUCTURE BRICKWORK
 C.M. 1:5 R.C.C. 1:2:4 FOR LINTELS
 BEAMS/SLABS ETC.
 SLAB R.C.C. 1:2:4 SLAB (FORM)
 FLOORING: MOSAIC FLOORING
 FINISH: INTERIOR PAINTED WITH
 OIL BOUND DISTEMPER EXTERIOR
 PAINTED WITH CEMENT PAINT
 WEATHERING COARSE BRICK JET
 LIME CONCRETE WITH PRESSEL
 JOINERY: BEST INDIAN T.M.
 G.WOOD/ALU

Security plan

SCHEDULE OF JOINERY
 10 MAN DOOR (TW) 28" x 70" 105 x 285
 21 FLUSH TYPE DOOR 28" x 81" 124 x 255
 12 "40" 24" x 70" 105 x 255
 12 W.W. FRAMED GLAZED
 WINDOW 60" x 40" 60 x 156
 12 "40" 40" x 40" 124 x 156
 12 KITCHEN WINDOW 40" x 30" 124 x 91
 12 VENTILATOR 24" x 20" 60 x 60
 12 WINDOW 16" x 40" 150 x 124



AREA STATEMENT

GROUND FLOOR	520	50.00
FIRST FLOOR	585	54.37
TOTAL AREA	1105	107.70
PLOT AREA	1200	111.52
F.S.I	0.92 TIMES	
PLOT COVERAGE	44%	



COLOUR CODE INDEX

PROPOSED	---
ROAD	---
BOUNDARY LINE	---
SEWAGE LINE	---


BOUNDRY
 (S. SAIPRASAD)
S. Saiprasad
 (MRS. SUEHADRA SAIPRASAD)
 OWNER'S SIGNATURE
 PROPOSED A RESIDENCE
 AT PLOT NO: 80 (PART)
 IN SURVEY NO 79 1/2 (PART)
 NEW SURVEY NO 80 (PART)
 KRESHNA NAGAR
 VIRUGAMBAKKAM
 MADRAS 52

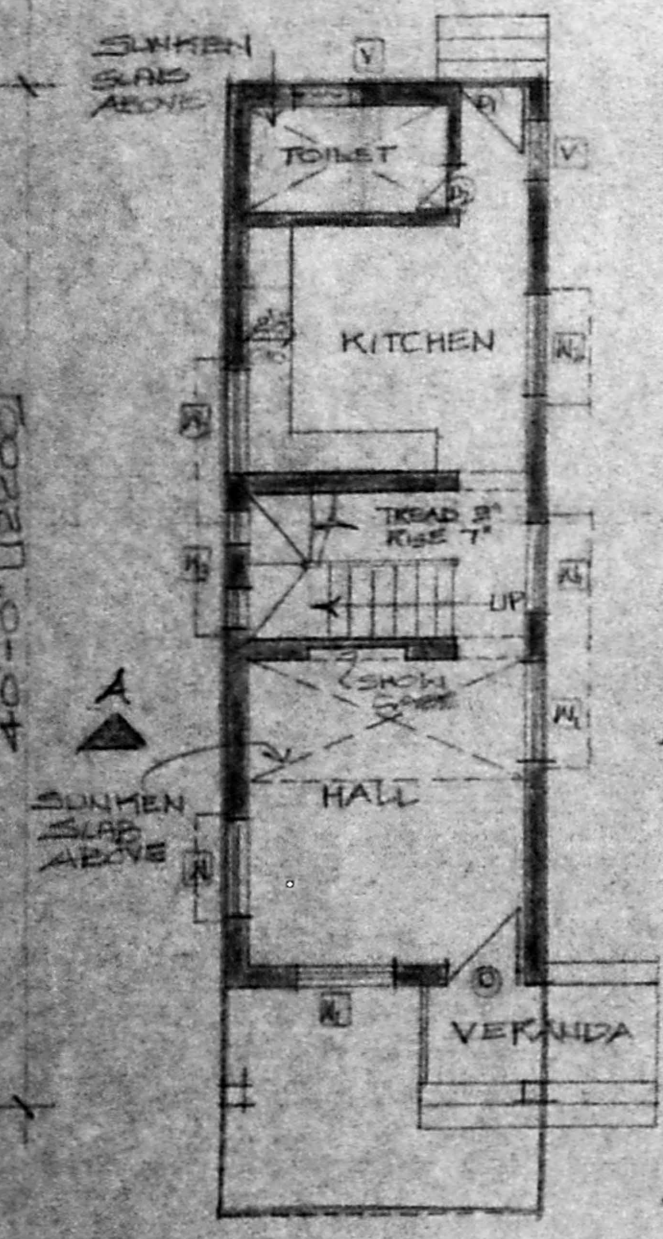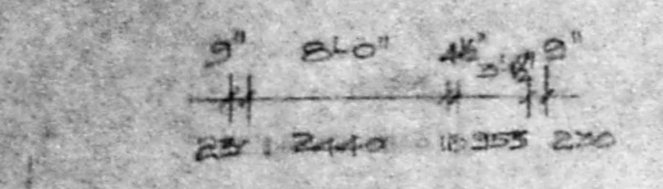


GROUND FLOOR PLAN

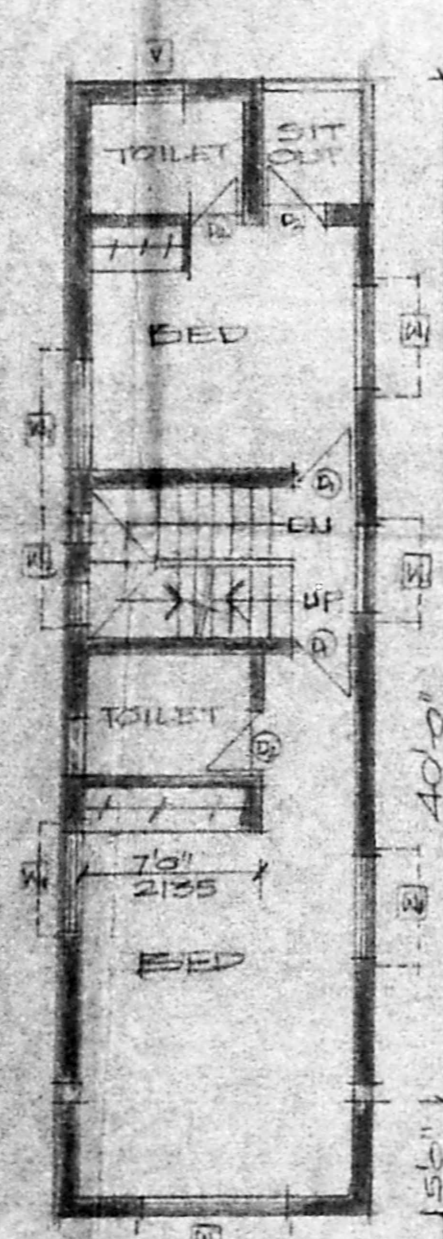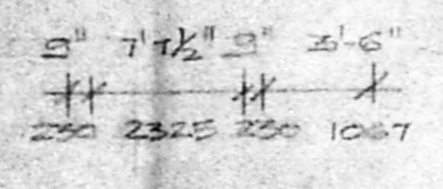


FIRST FLOOR PLAN

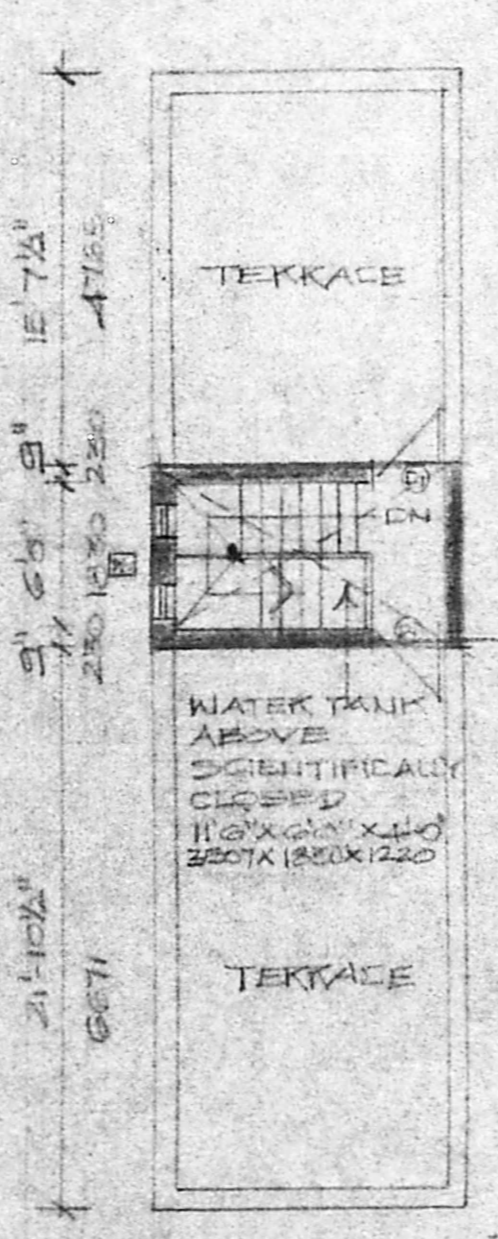


TERRACE FLOOR PLAN

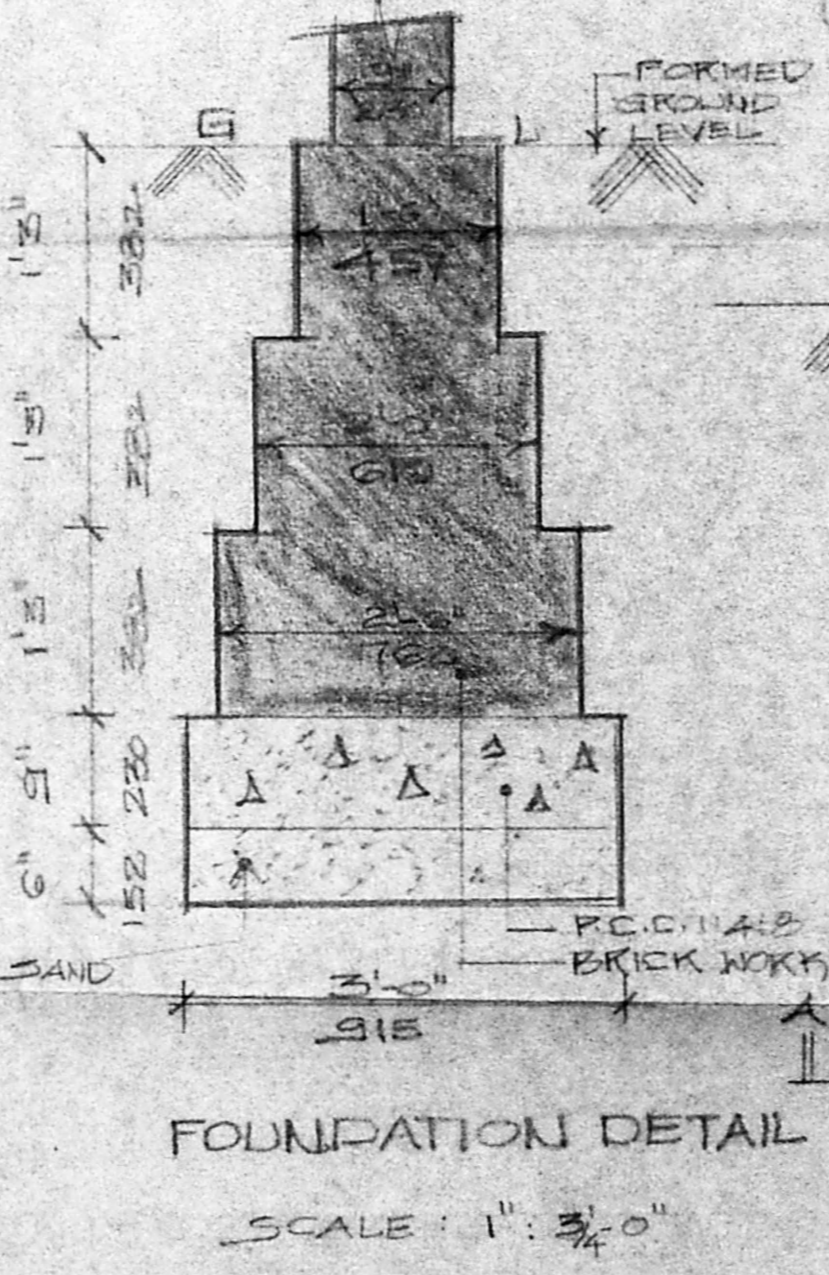

FOUNDATION DETAIL SCALE 1" : 3/4"

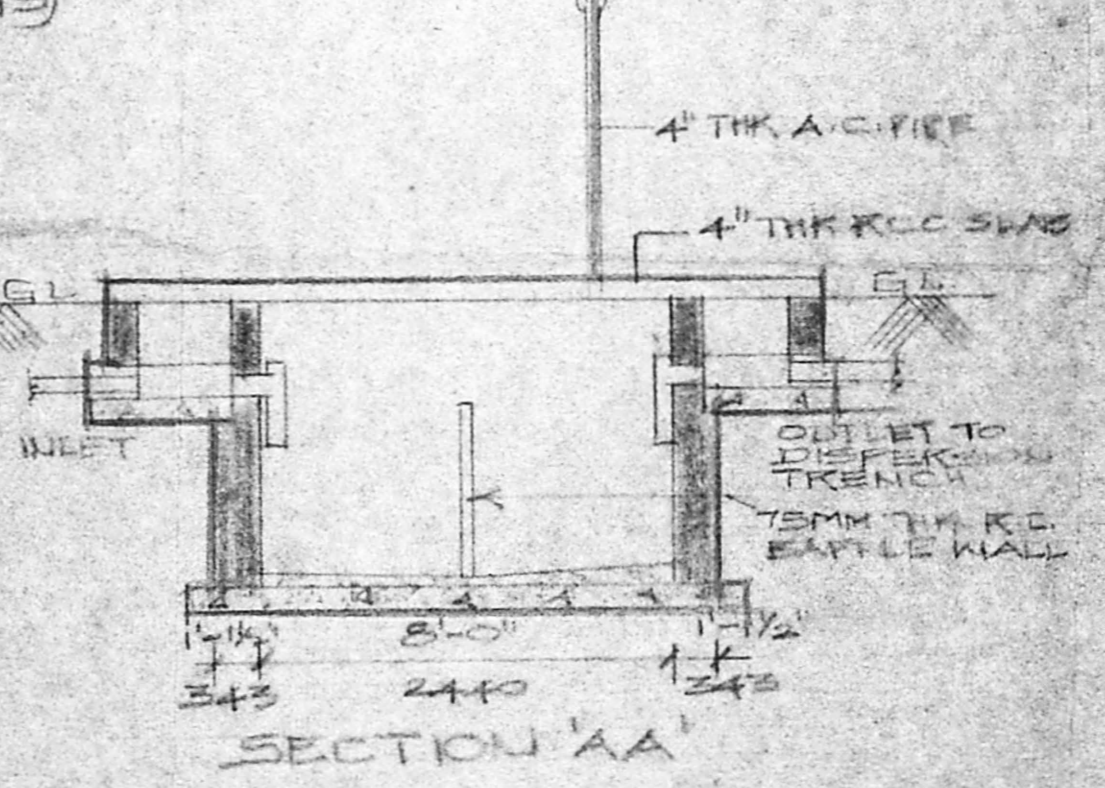

SECTION 'AA'

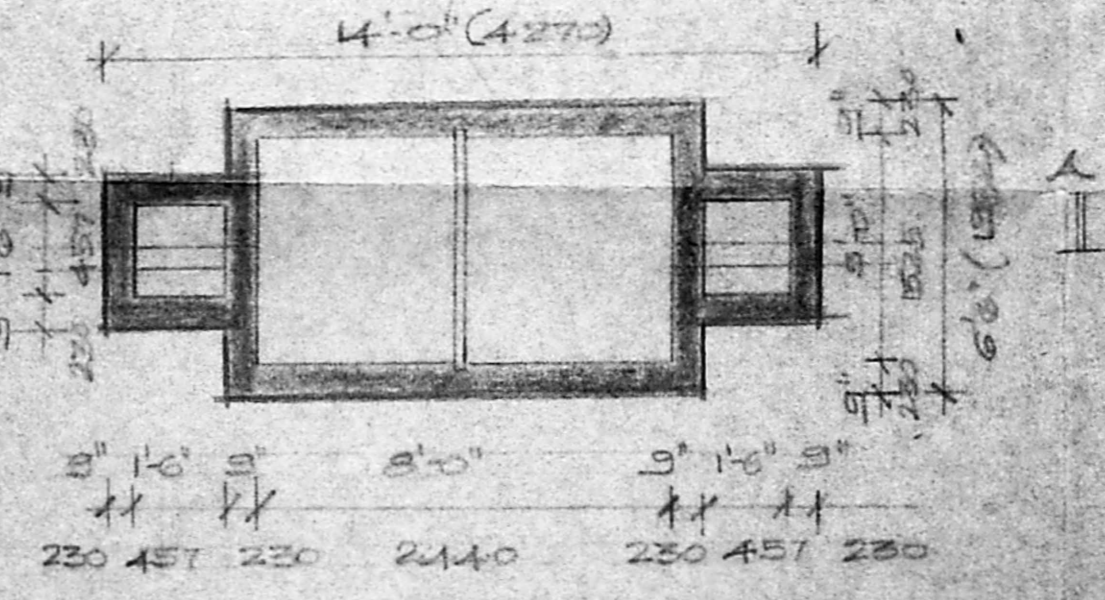

PLAN OF SEPTIC TANK

GROUND FIRST FLOOR PLAN
 SITE, TERRACE FLOOR PLAN
 KEY PLAN, ELEVATION, SECTION
 GATE, SEPTIC TANK, WELL
 DETAIL
 SCALE 1:100 DATE 15-6-93

B. S. Radhakrishnan
B. S. RADHAKRISHNAN
 CONSULTING CIVIL ENGINEER
 LICENSED SURVEYOR CLASS-I
 CORPORATION OF MADRAS.
 PLOT NO 52 FLOOR 10/10/10
 VELACHERY, A.C. S.

LICENCED SURVEYOR