



FRONT ELEVATION

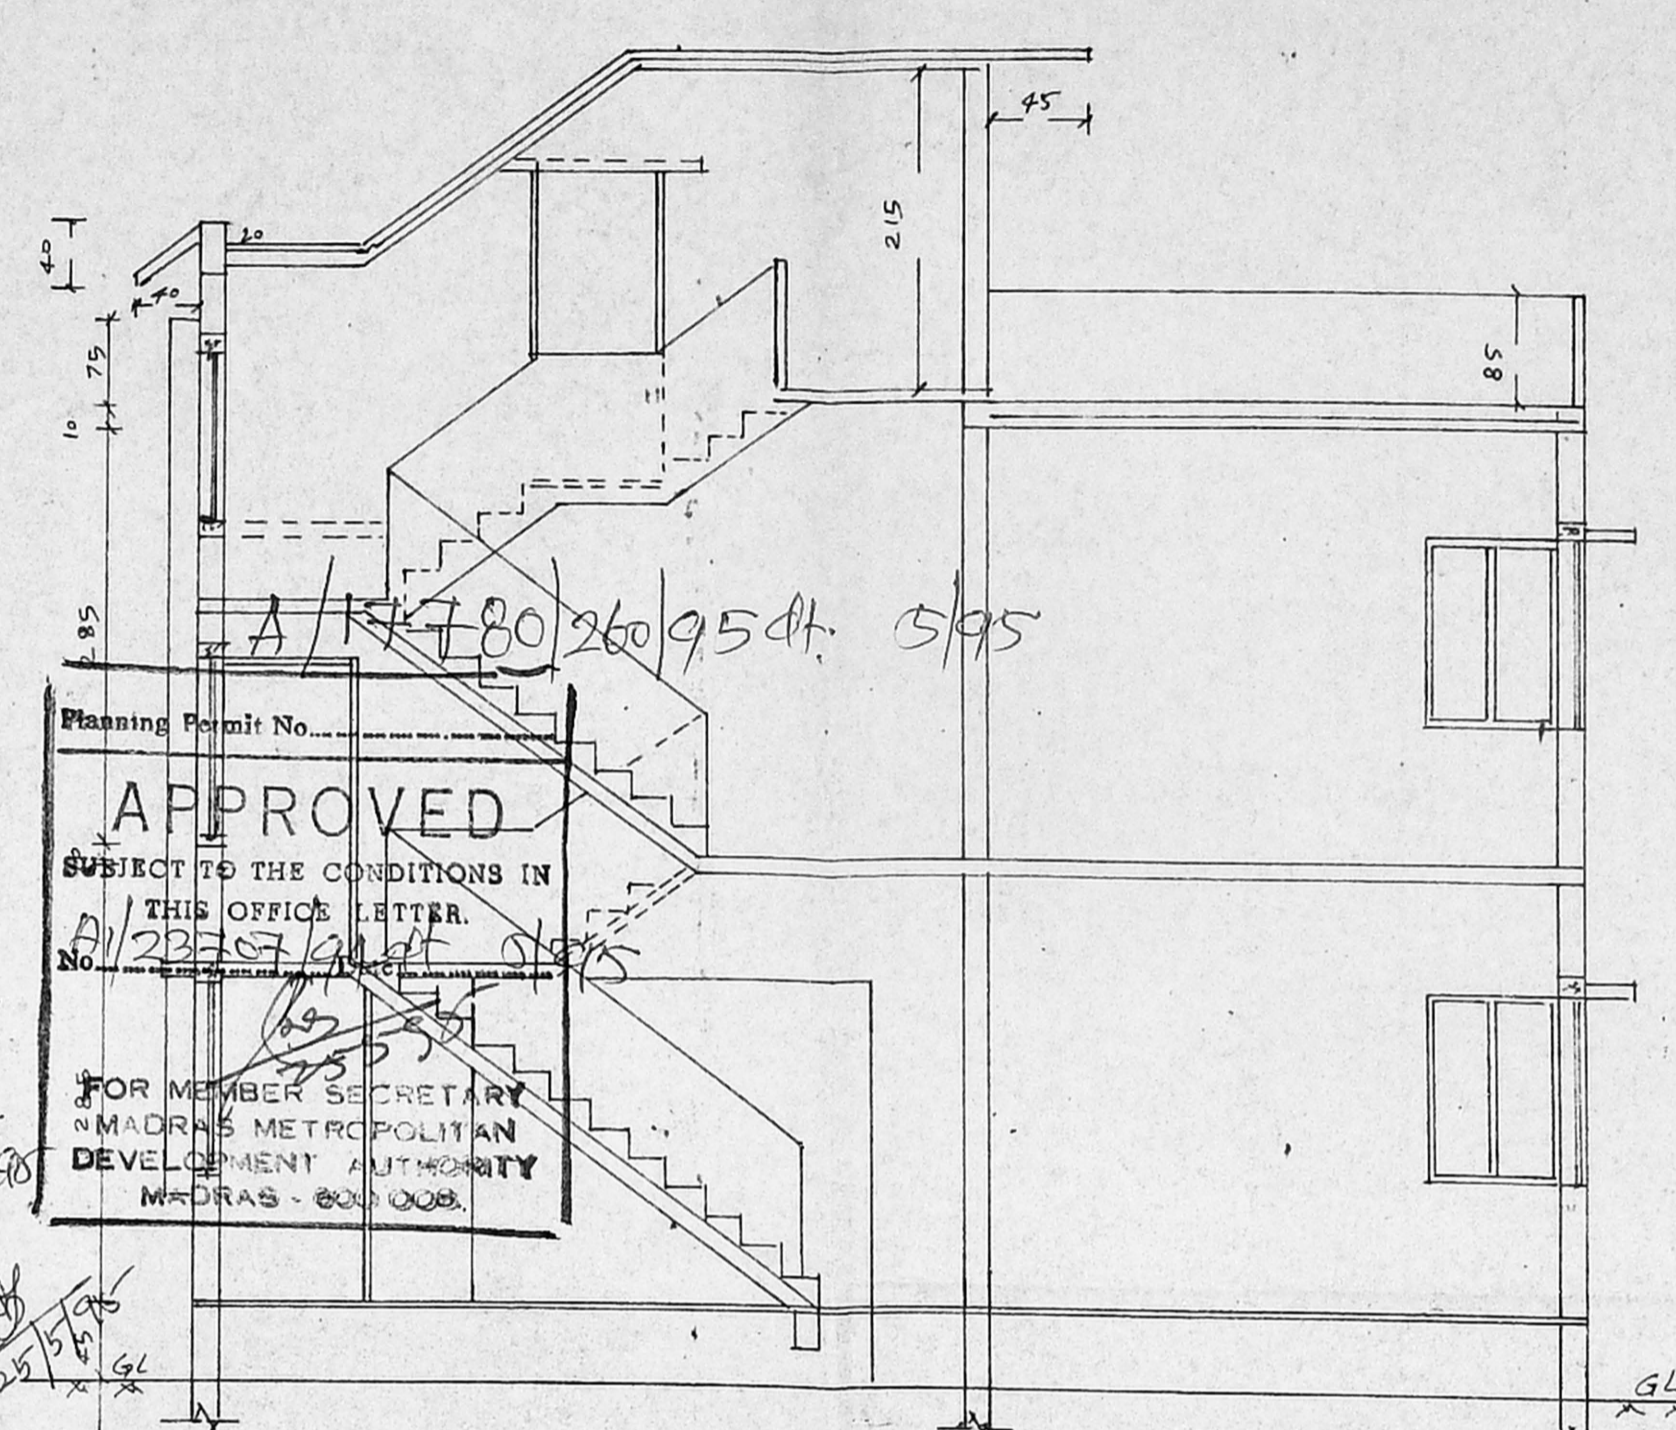


APPROVED  
SUBJECT TO THE CONDITIONS IN  
THIS OFFICE LETTER  
No. 22367/1954  
FOR MEMBER SECRETARY  
MADRAS METROPOLITAN  
DEVELOPMENT AUTHORITY  
MADRAS - 600005

A.C. CORRUGATED SHEET ROOFING  
M.S. ANGLES 5 X 5 CM.  
G.I. GUTTER 19 X 23


PROPOSED WALL  
IN B.W. 1:5

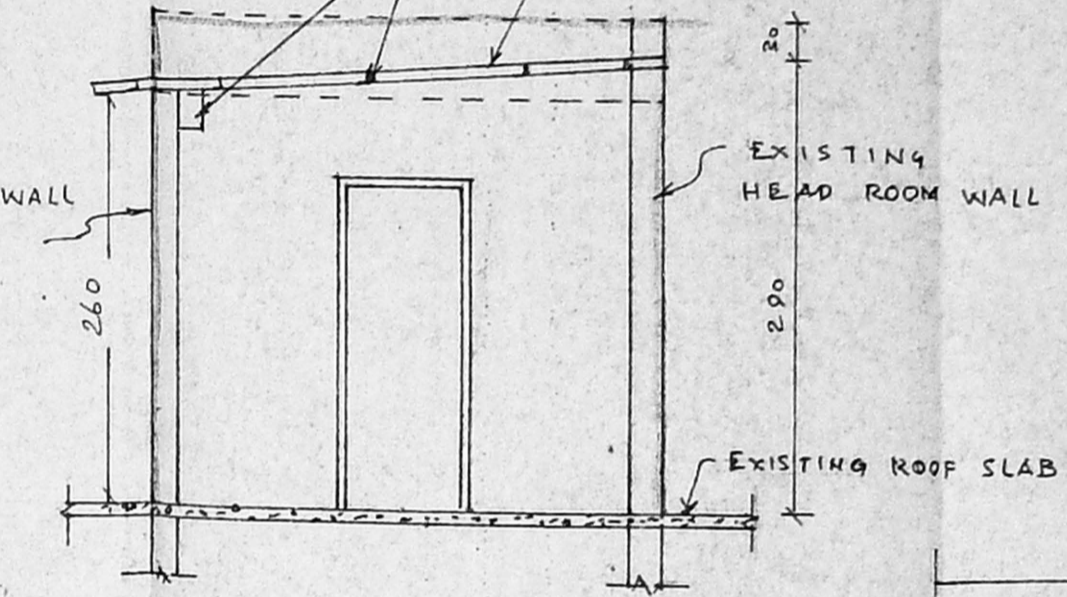

SECTION ON 'BB' IN  
SECOND FLOOR

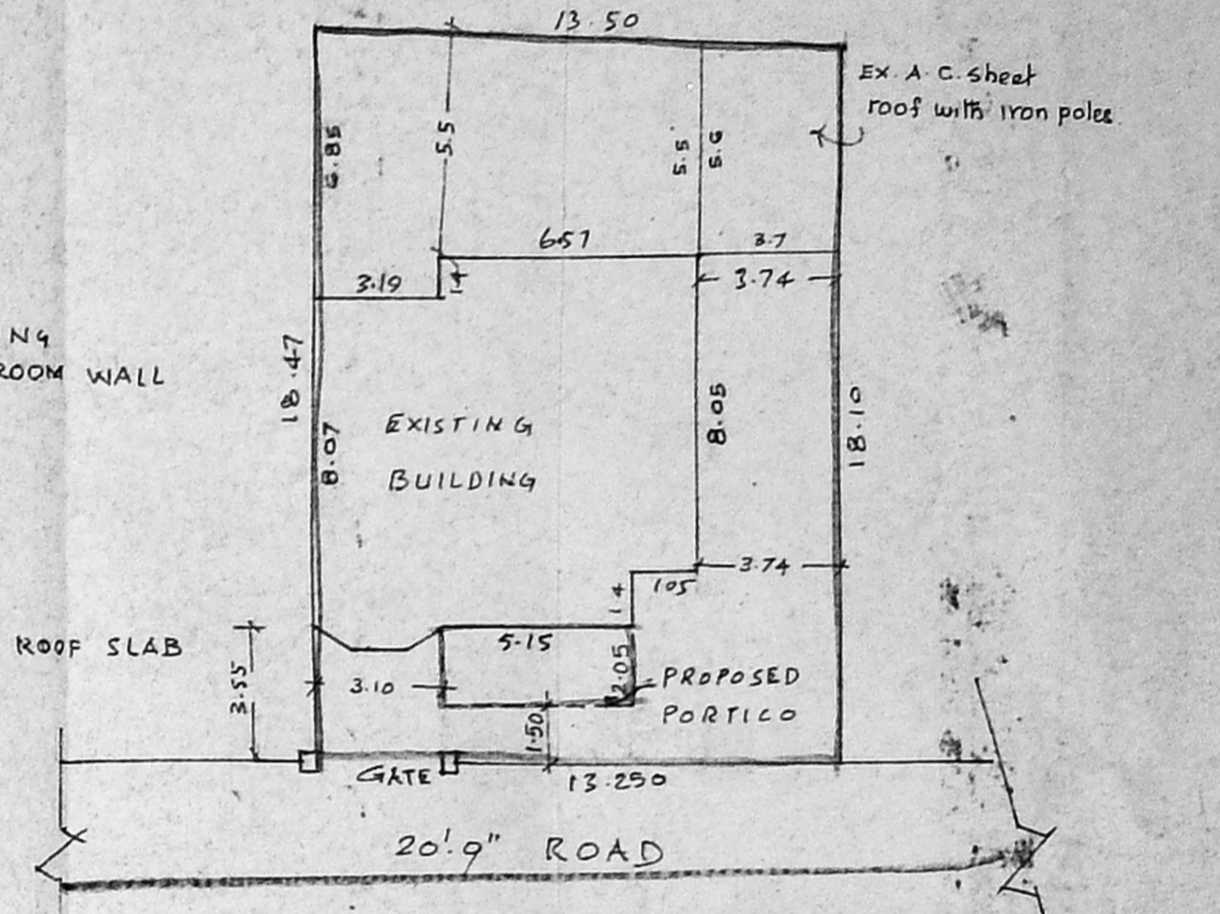


SITE PLAN OF BLOCK NO. T-70B IN  
T.N.H.B. LAY-OUT OF TWIN TYPE HOUSING  
M.I.G. BLOCK AT BEASANT NAGAR. SCALE 1:200

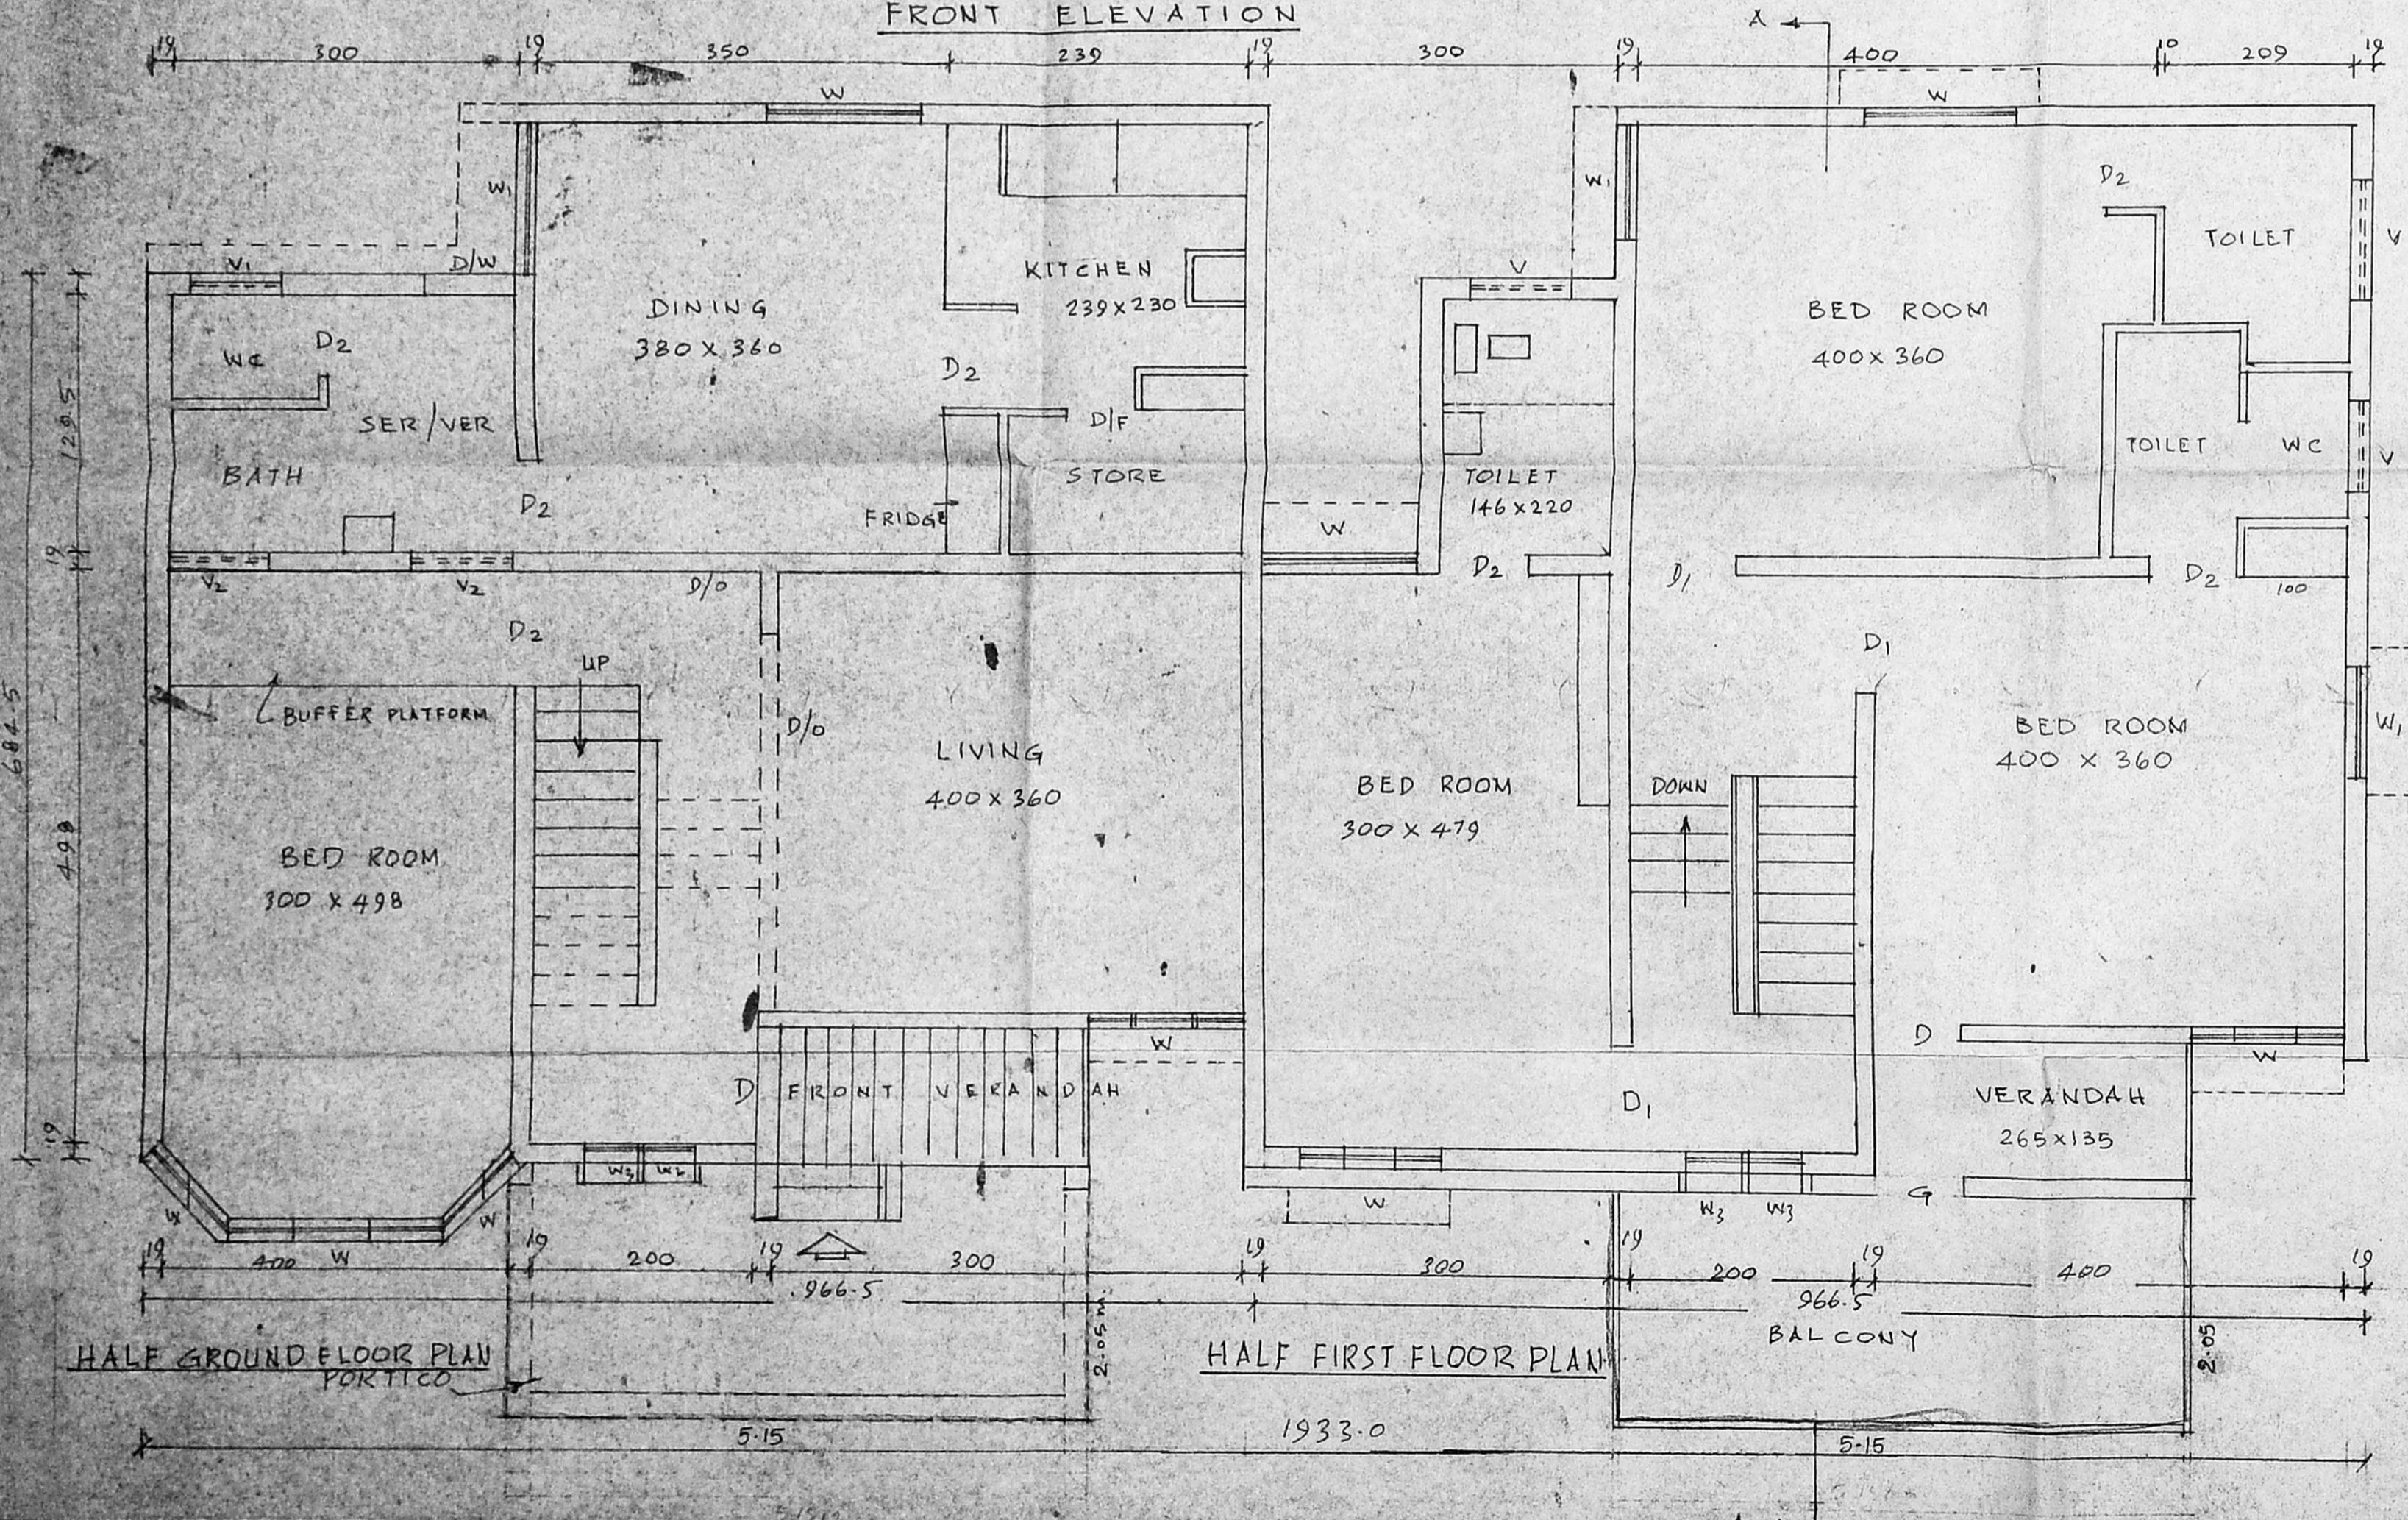

HALF GROUND FLOOR PLAN  
PORTICO

HALF FIRST FLOOR PLAN

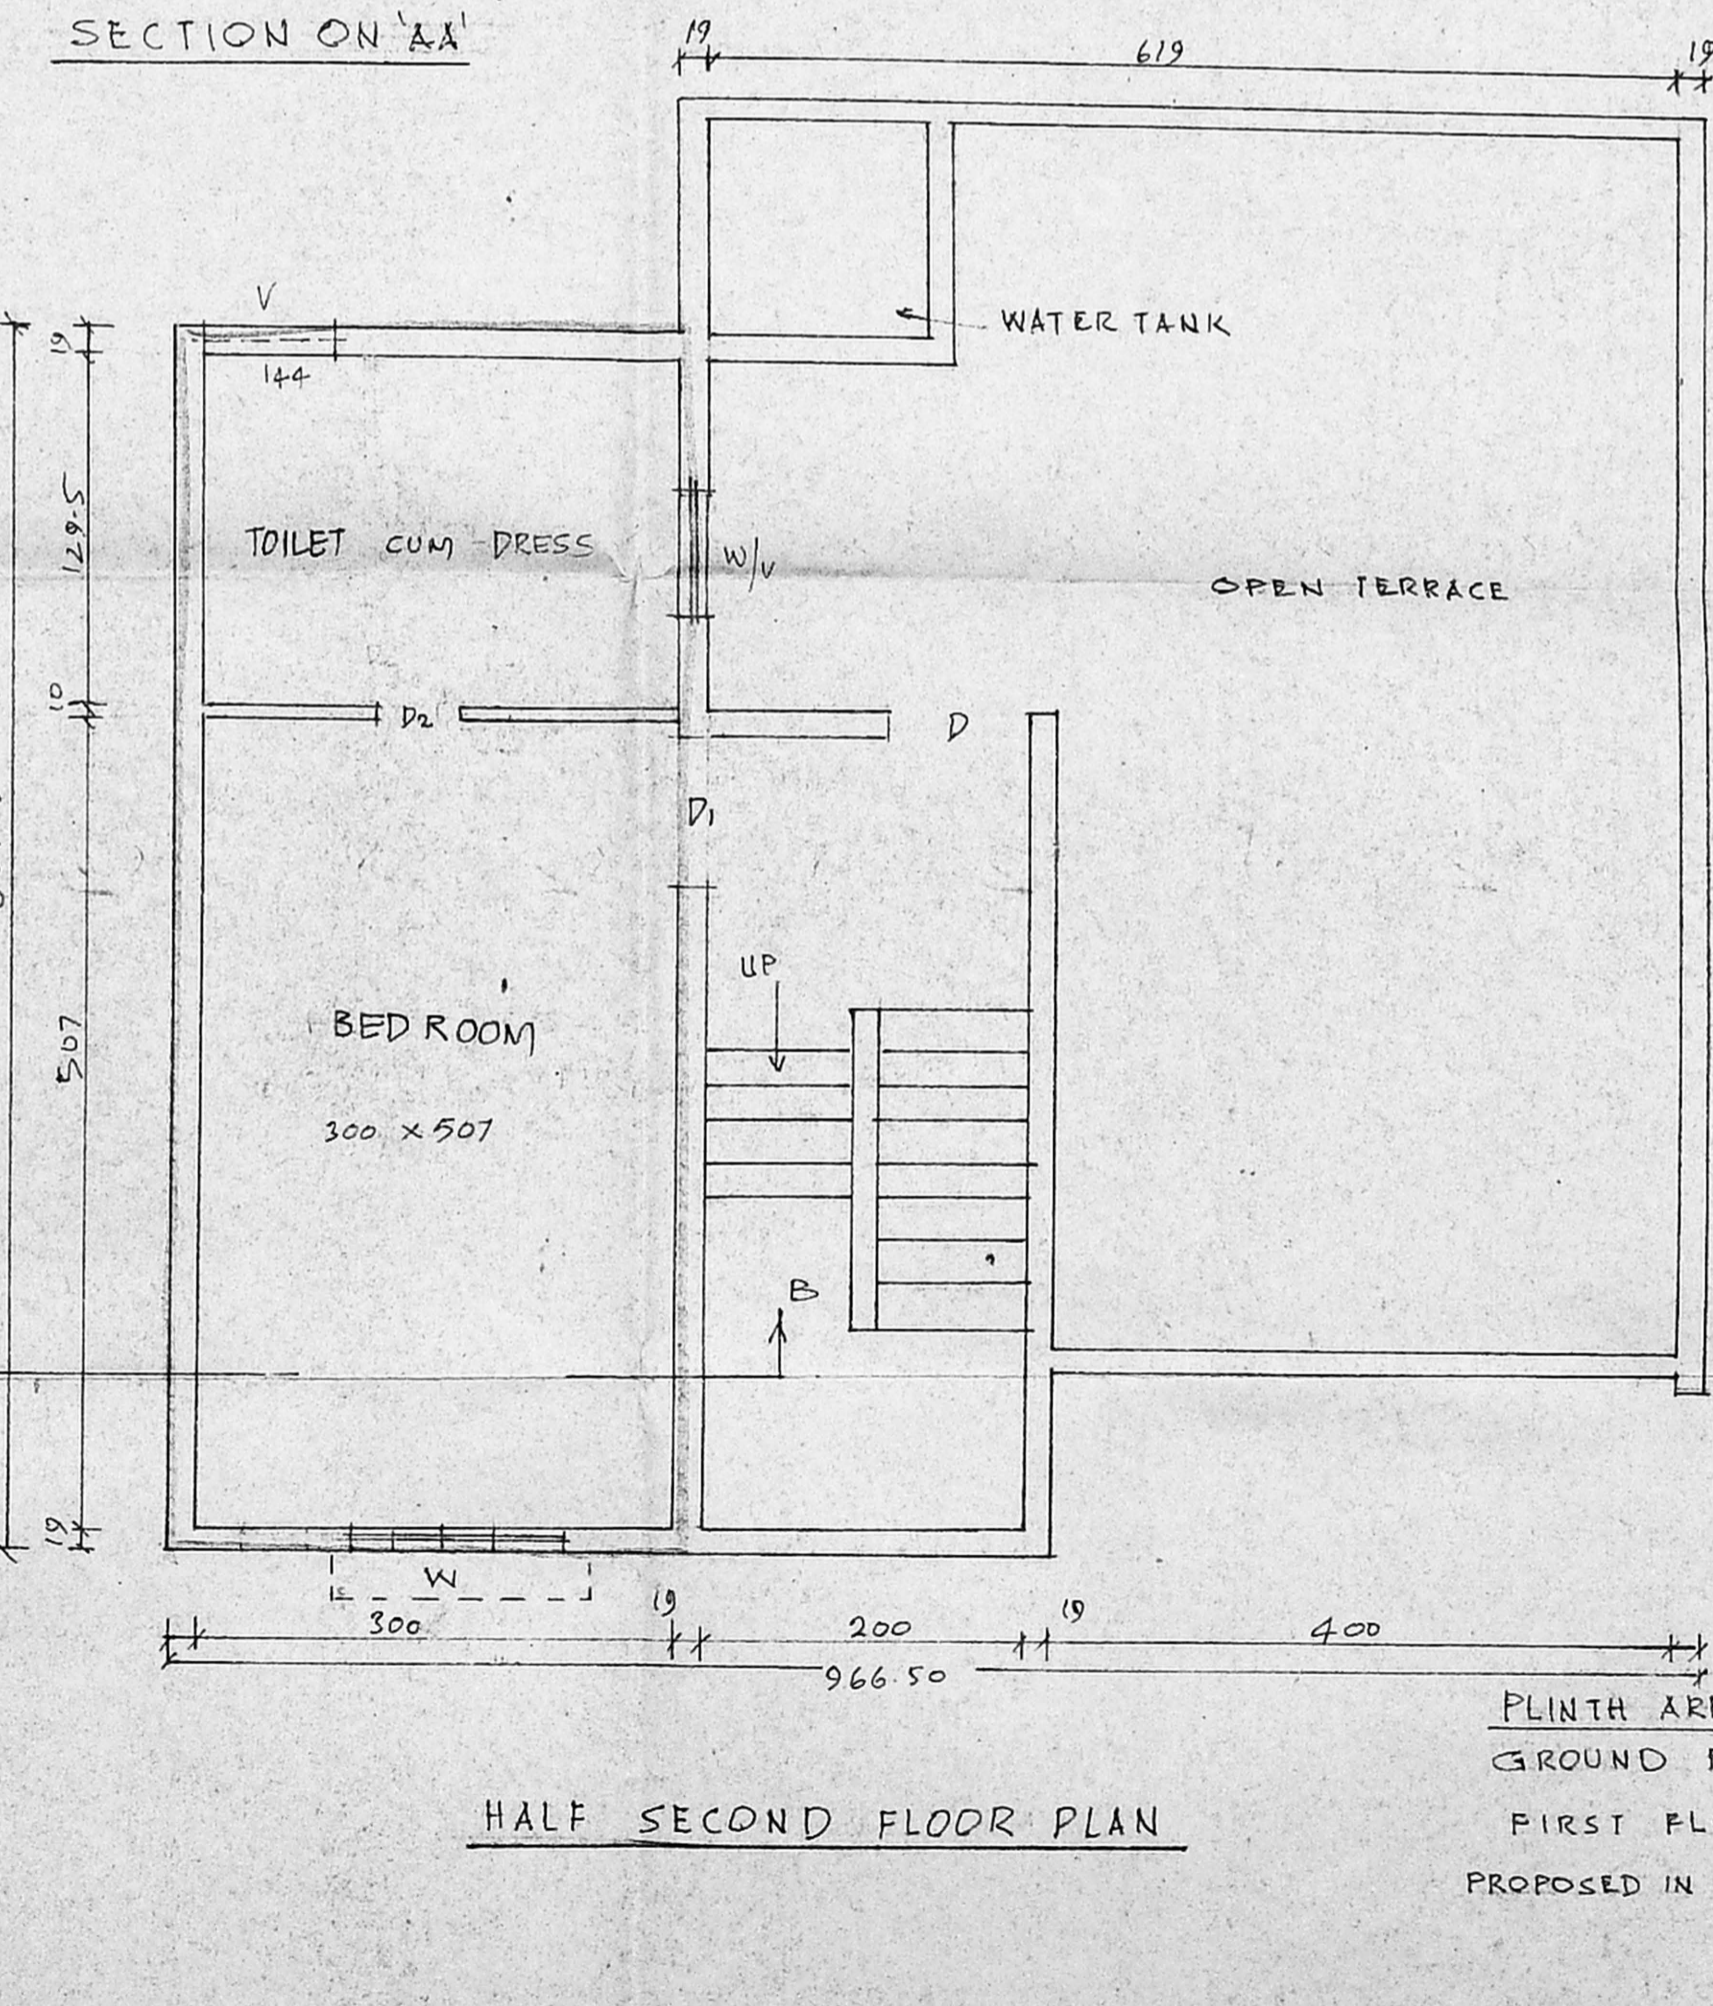

HALF SECOND FLOOR PLAN

NOTES

- ALL DIMENSIONS ARE IN CENTIMETRES
- D/F IN STORE RM TO HAVE DOOR FRAME ONLY LEAVING THE SHUTTER AS CHOICE THE SPACE ABOVE DOOR TO HAVE FIXED WOODEN 'X' METAL 3/2" X 1/2" WITH 1/2" BARS
- SPECIAL SUN SHADES TO BE PROVIDED FOR WINDOWS ON WESTERN SIDE IN BED RM
- THIS DRG. SUPER SIDES DRG. HB 12/77 AND HB 13/77 OF HUDCO CELL
- THIS WALL THICKNESS MAY BE MODIFIED BASED ON THE NATURE OF MASONRY WALL PROPOSED FOR CONSTRUCTION

SCHEDULE OF JOINERY

D	DOOR	100 X 200
D <sub>1</sub>	DOOR	90 X 200
D <sub>2</sub>	DOOR	75 X 200
D/W	DOOR CUM WINDOW	75 X 200 & 47.5 X 120
D/O	OPENING	270 X 200
D/O	OPENING	100 X 200
W	WINDOW	132.5 X 120
W <sub>1</sub>	WINDOW	90 X 120
W <sub>2</sub>	WINDOW	90 X 105
V	VENTILATOR	90 X 90
V <sub>1</sub>	VENTILATOR BELOW ROOF	90 X 47.5
V <sub>2</sub>	VENTILATOR (DOUBLE FRAMED)	90 X 47.5
W <sub>3</sub>	WINDOW	47.5 X 120

COLOUR INDEX

- EXISTING
- PROPOSAL
- ROAD
- BOUNDARY

PLINTH AREA	
GROUND FLOOR	79.5 M <sup>2</sup>
FIRST FLOOR	76.3 M <sup>2</sup>
PROPOSED IN F-F. BALCONY	15.70 M <sup>2</sup>
S.F.	17.10 M <sup>2</sup>

PLAN SHOWING THE PROPOSED ADDITIONS TO THE EXISTING BUILDING IN GROUND FLOOR AND FIRST FLOOR AT BLOCK NO. T-70 B OF BEASANT NAGAR HOUSING BOARD

M.I.G. BLOCK, MADRAS-600035. APPROVED DRAWING BY C.E., T.N.H.B., MADRAS. VIDE S.D. NO. 38/78.

SCALE: 1:50.

OWNER

Er. K. VENUGOPAL, Rd. A.E.E. CORPORATION OF MADRAS  
Civil & Sanitary Engineering Consultant  
Licensed Surveyor, Class-1 No. 320  
Licensed Plumber, Class-1 Metro Water  
Sanitary No. .... Water Supply No. ....  
3, Madhavaram Street, Mangalamkalam - 600 035  
Lic. No. 123456789  
LICEN. REGR. SURVEYOR