

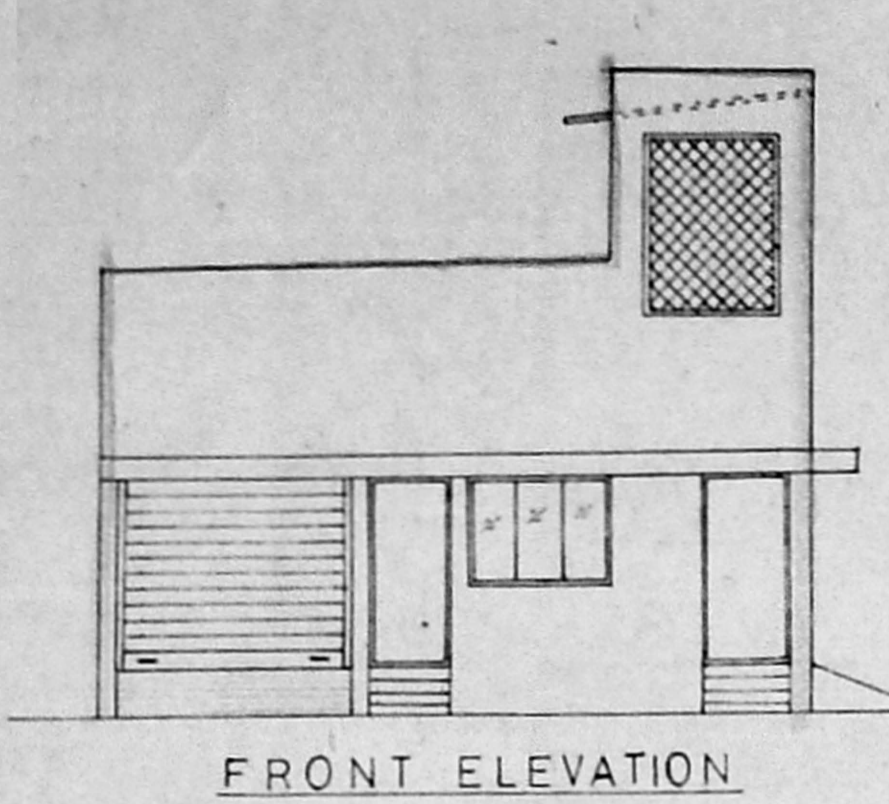


PROPOSED CONSTRUCTION OF OFFICE CUM GODOWN AT PLOT NO. B.6 AT MADHAVARAM BUS AND TRUCK TERMINAL IN S NO. 787 PT. & 788 PT. OF MADHAVARAM VILLAGE - CHENGAI M.G.R. DIST.

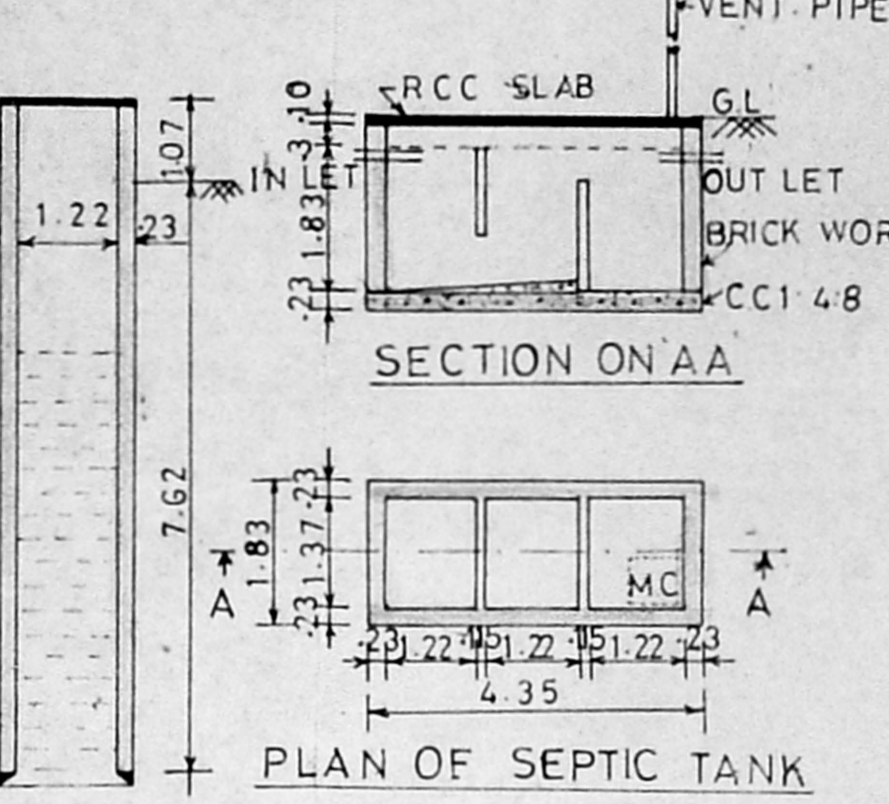


FRONT ELEVATION

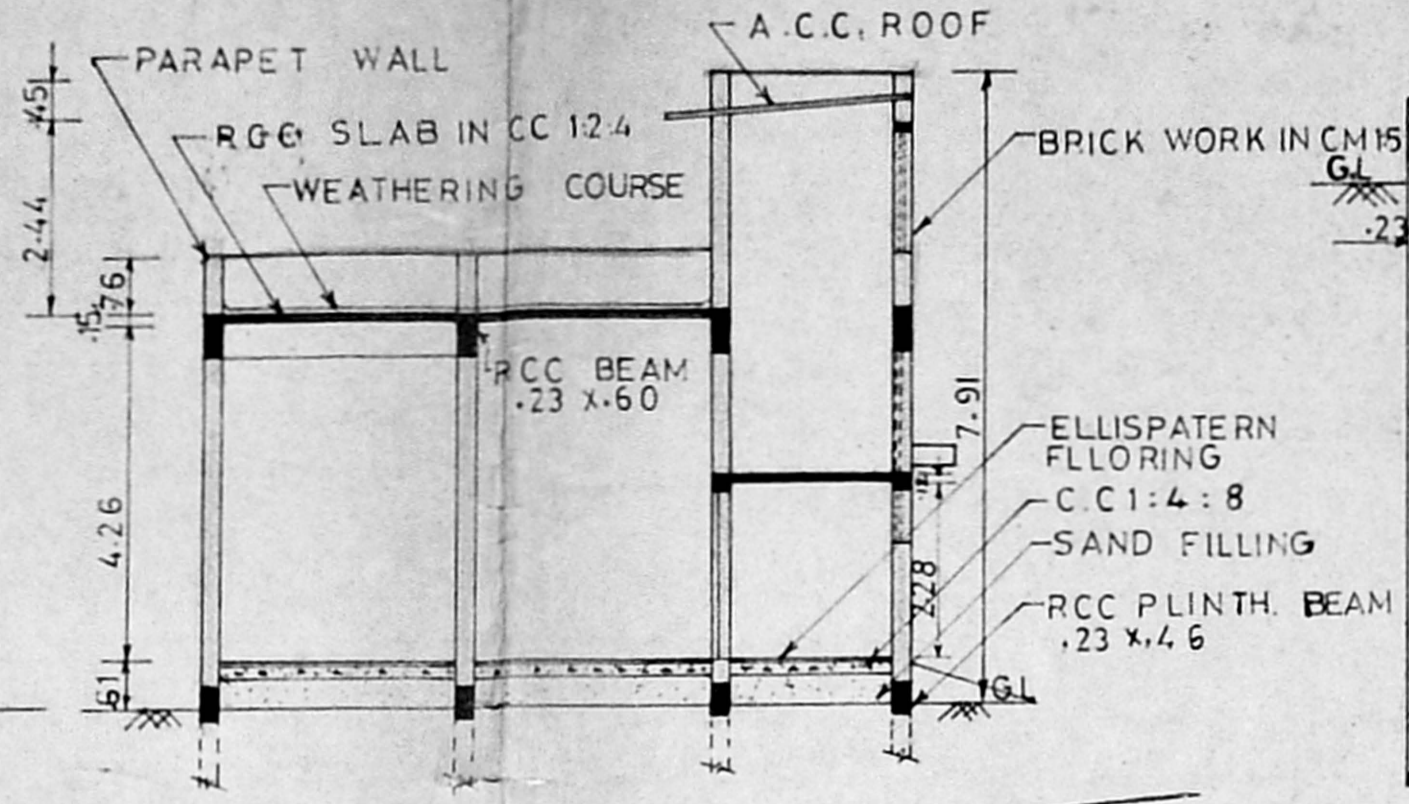


SECTION ON AA

PLAN OF SEPTIC TANK

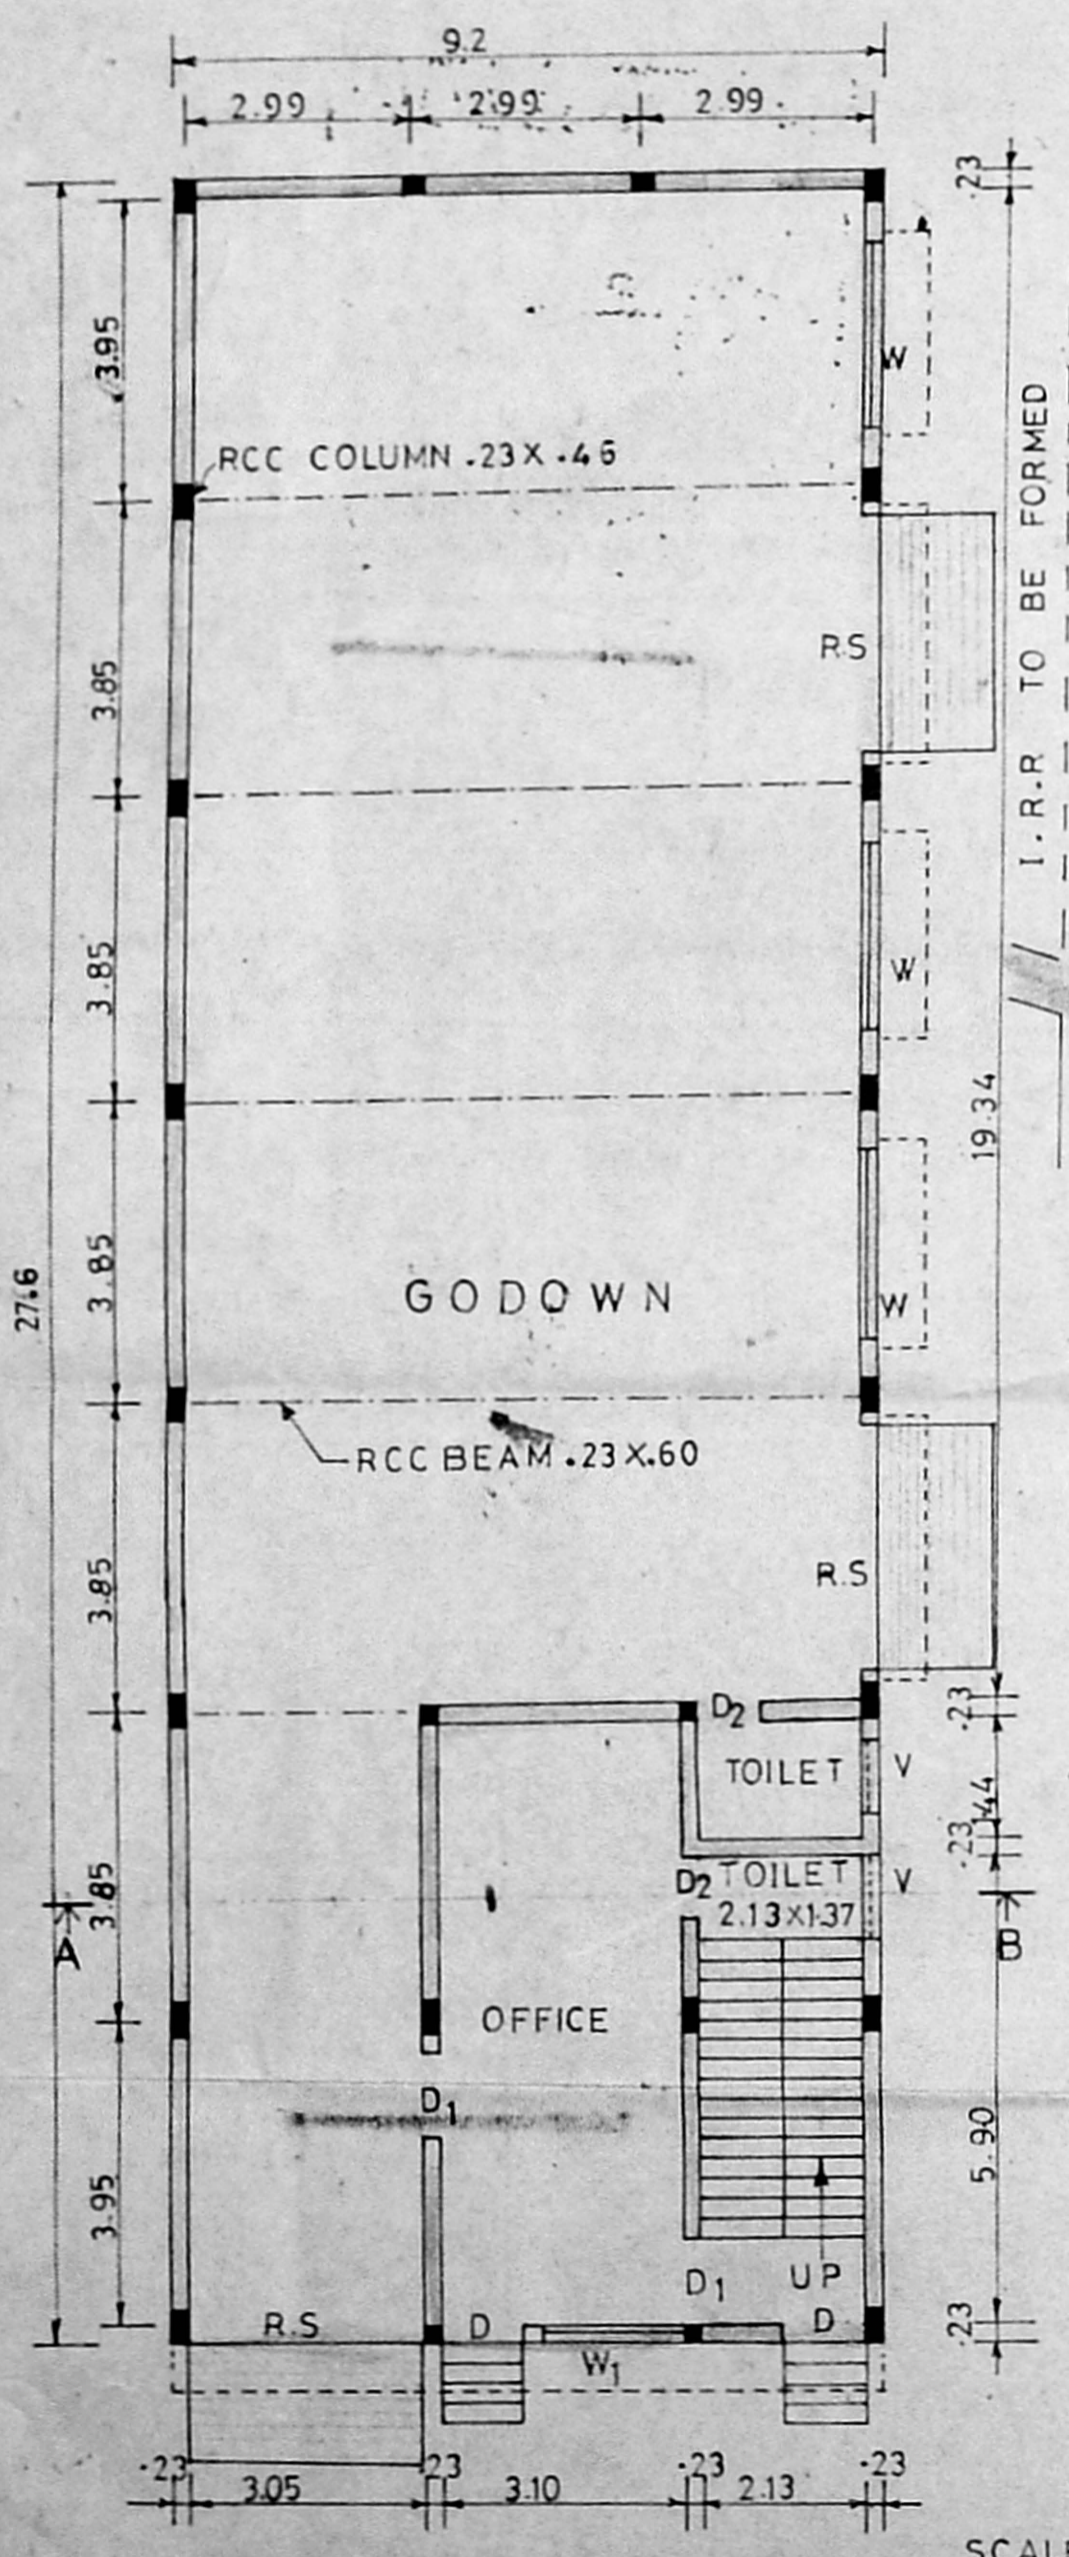

GROUND FLOOR PLAN

SCALE 1:100

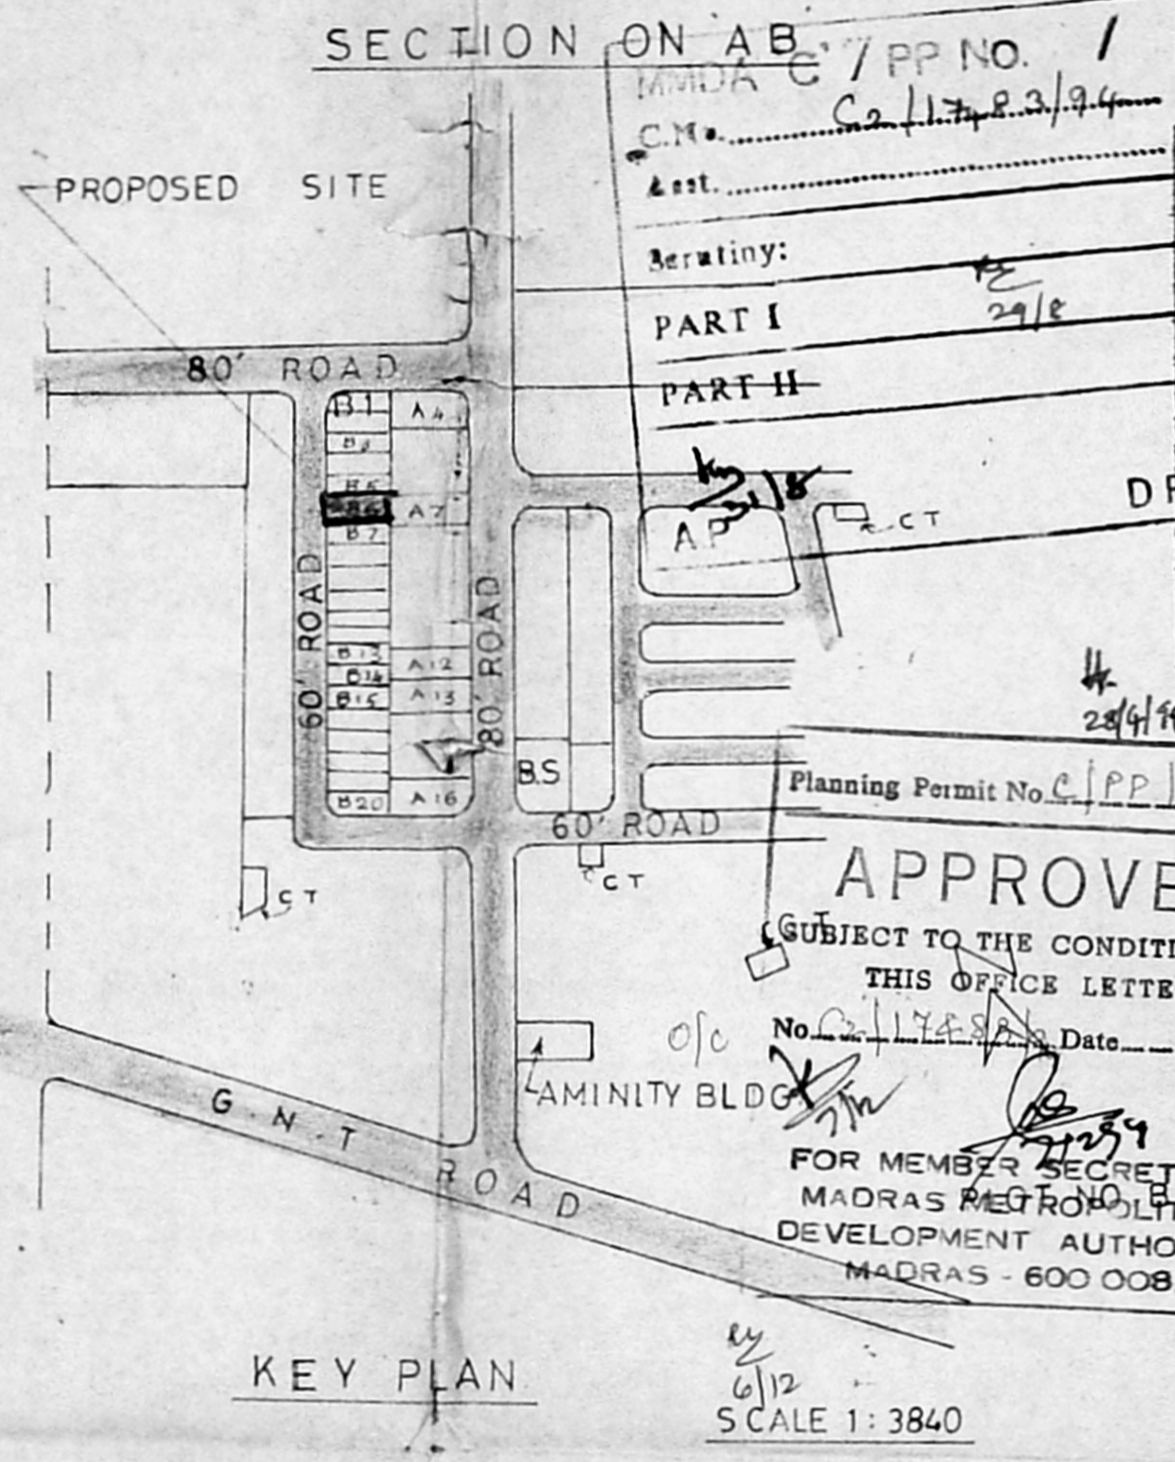


KEY PLAN

SCALE 1:3840

N.O.C. - ISSUED
 VIDE FILE NO: M1/360/94
 DATED: 1-6-94
 LADS DN. 3
 FOR CHIEF EXECUTIVE OFFICER
 M.M.D. MADRAS 600 OOB.


APPROVED
 SUBJECT TO THE CONDITIONS IN THIS OFFICE LETTER.
 FOR MEMBER SECRETARY
 MADRAS METROPOLITAN
 DEVELOPMENT AUTHORITY
 MADRAS - 600 OOB

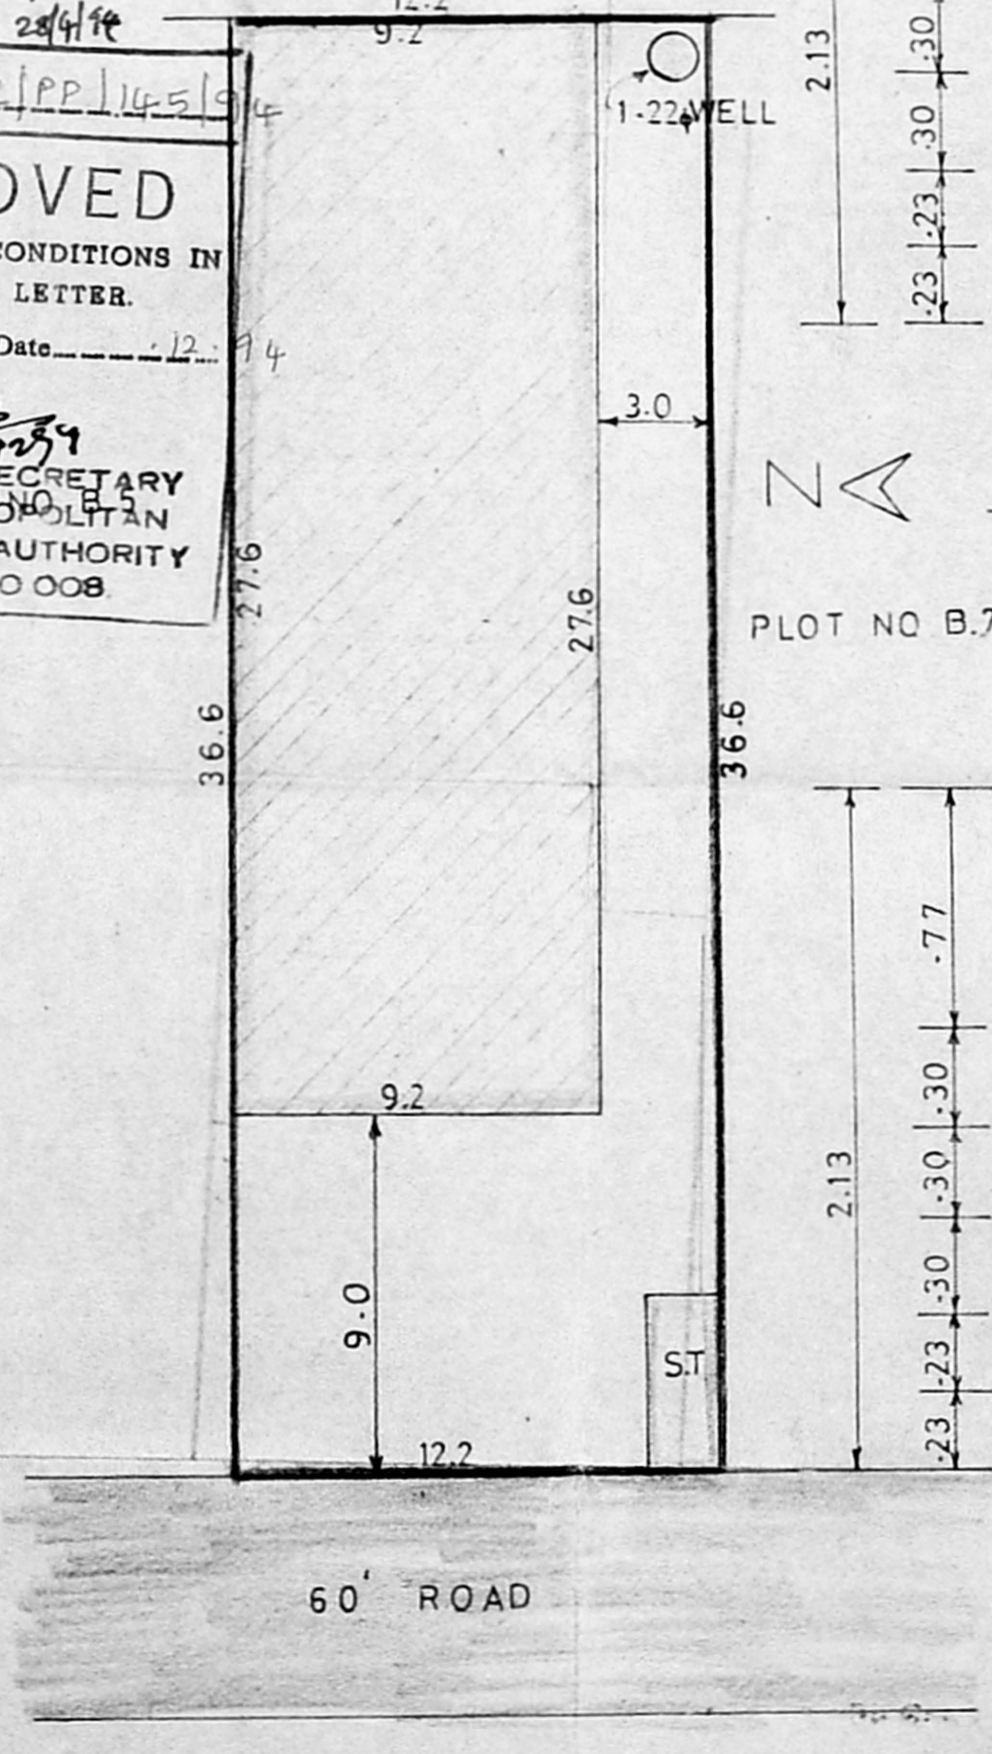


SITE PLAN

SCALE 1:200

ALL DIMENSIONS ARE IN METRES

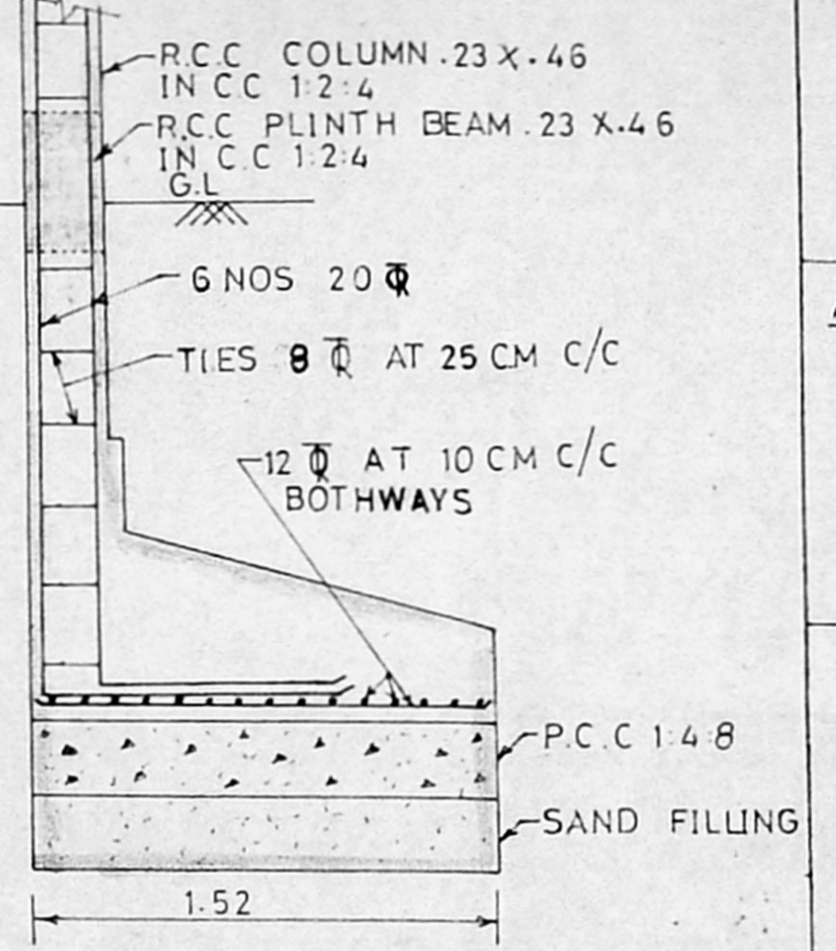

COLUMN L' TYPE FOUNDATION

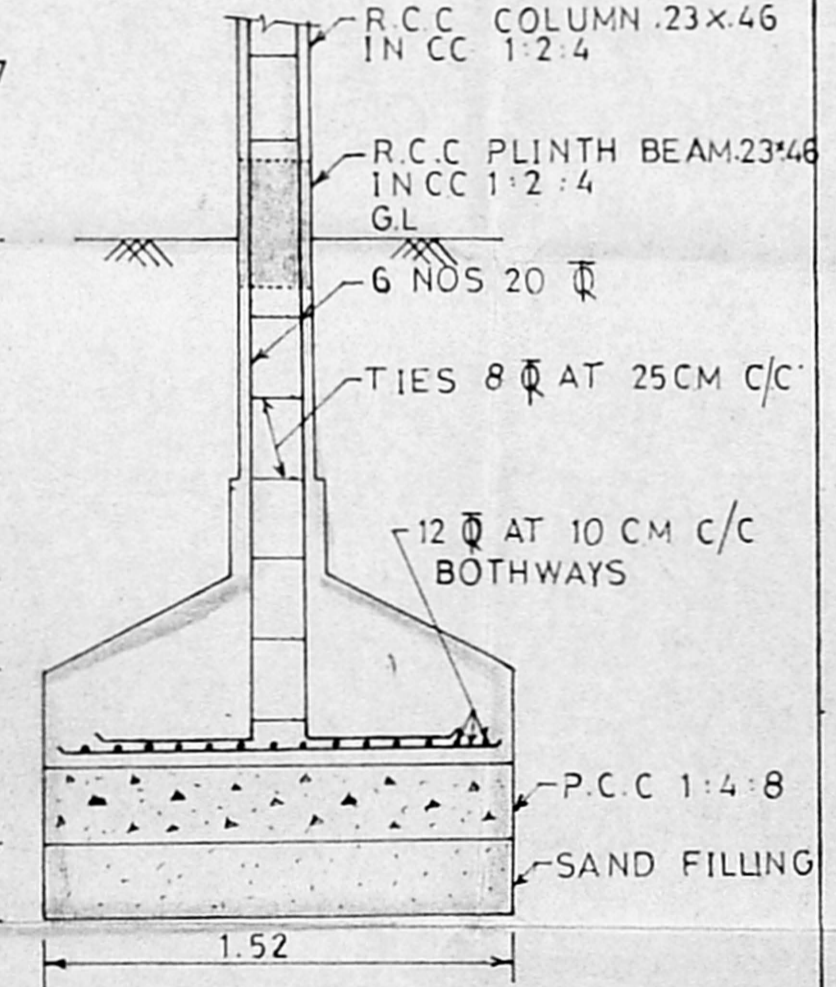

COLUMN FOUNDATION

JOINERY DETAILS:

R.S. ROLLING SHUTTER	3.05 x 2.44
D - DOOR	1.07 x 2.44
D1 - DOOR	1.07 x 2.13
D2 - DOOR	0.76 x 2.13
W WINDOW	2.44 x 1.37
W1 WINDOW	1.83 x 1.37
V VENTILATOR	0.91 x 0.61
J R C C JALLY	1.07 x 1.53
J1 R C C JALLY	1.83 x 0.91
J2 R C C JALLY	1.83 x 2.13

AREA STATEMENT:

PLOT AREA	446.52 SQ.m
PROPOSED BUILDING	253.92 SQ.m
PLOT COVERAGE	57%
F.S.I	0.57

COLOUR INDEX:

PROPOSED WORK	[Color Box]
ROAD	[Color Box]
SITE BOUNDARY	[Color Box]



For NEW AMAR GOODS CARRIERS
 K. Venugopal, Rtd. A.E.E.
 Civil & Sanitary Engineering Consultant
 Licensed Surveyor, Class-I No: 32
 Licensed Plumber, Class-I Metro
 Sewerage No: Water Supply No:
 3, Neelakandan Street, Madhavaram, Chennai - 600 034
 LICENCED SURVEYOR