

SECOND FLOOR PLAN

A/19254/634/95
B/B

Planning Permit No. ~~8/19/95~~

APPROVED


SUBJECT TO THE CONDITIONS IN THIS OFFICE LETTER

No. ~~A/19465/95~~ 28/9/95

W. M. ...

FOR MEMBER SECRETARY
MADRAS METROPOLITAN
DEVELOPMENT AUTHORITY
MADRAS - 600 008.

27/9/95

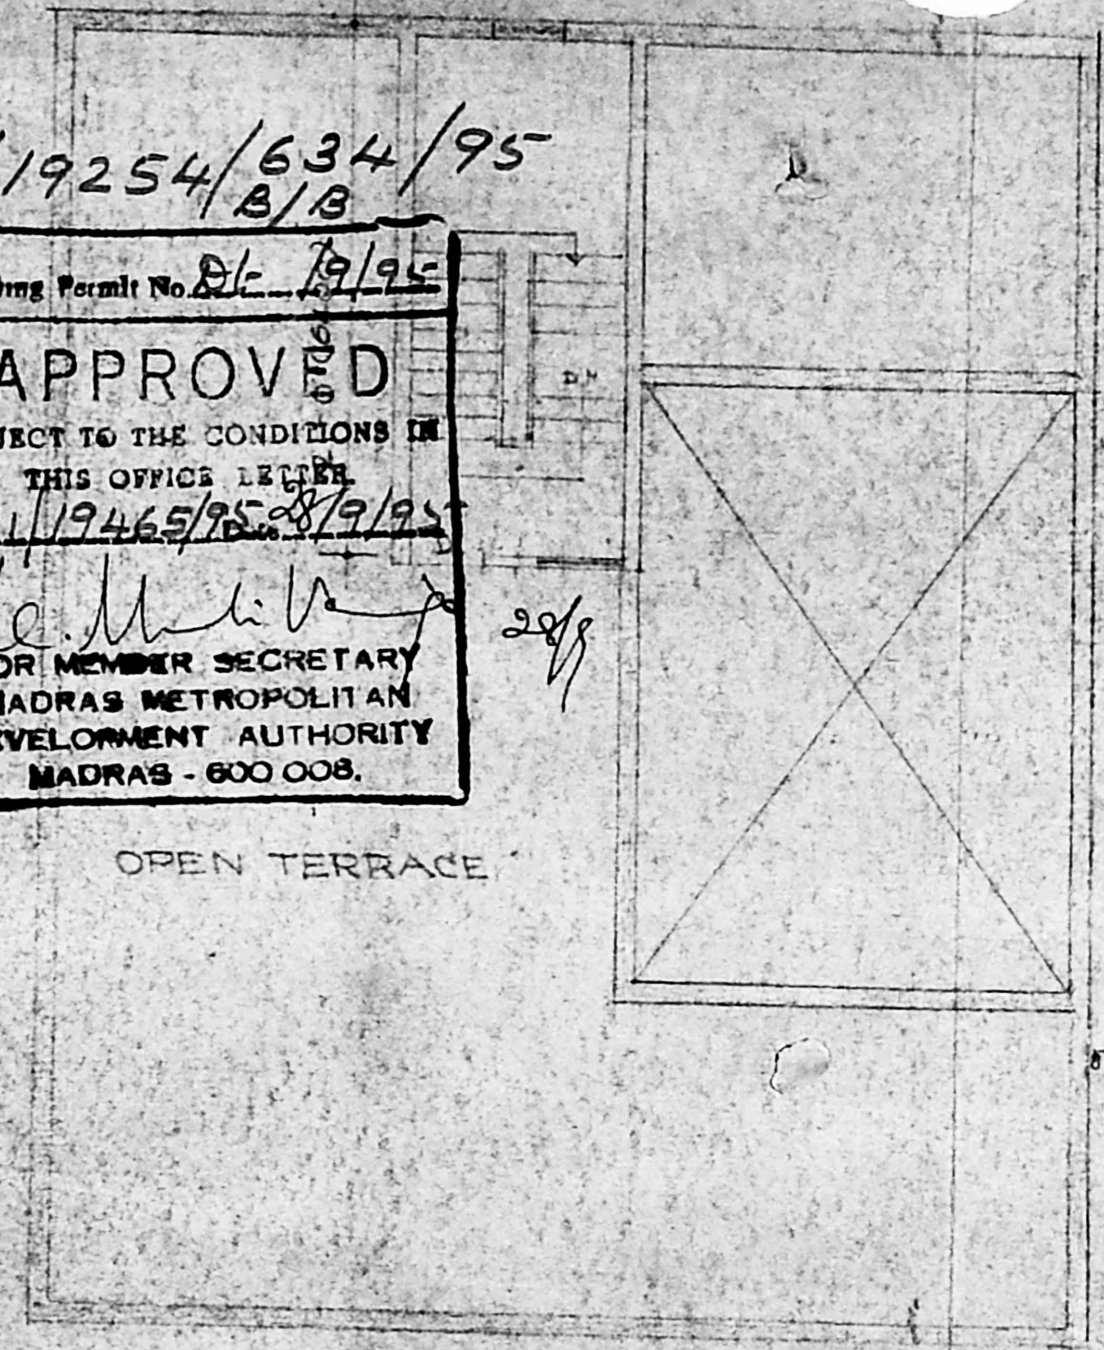

OPEN TERRACE

Security plan
A/145/95



11/3/95

OWNERS

S. DEVARAJANARI BA AJAA
CHARTERED ARCHITECT
7/1, CENOTAPH ROAD, MADRAS. 18.

DRAWING NO. 7/66 SCALE 1/8" = 1'-0" (1:110)

DATE - 14-11-94

PROPOSED FLATS IN PLOT
NO 16B, CASAMAJOR ROAD,
EGMORE, MADRAS.
RS. NO 415/18.

SURVEYORS
LICENSE NO. 14 B
CLASS I.

S. Aravindan
ARCHITECT