



FRONT ELEVATION

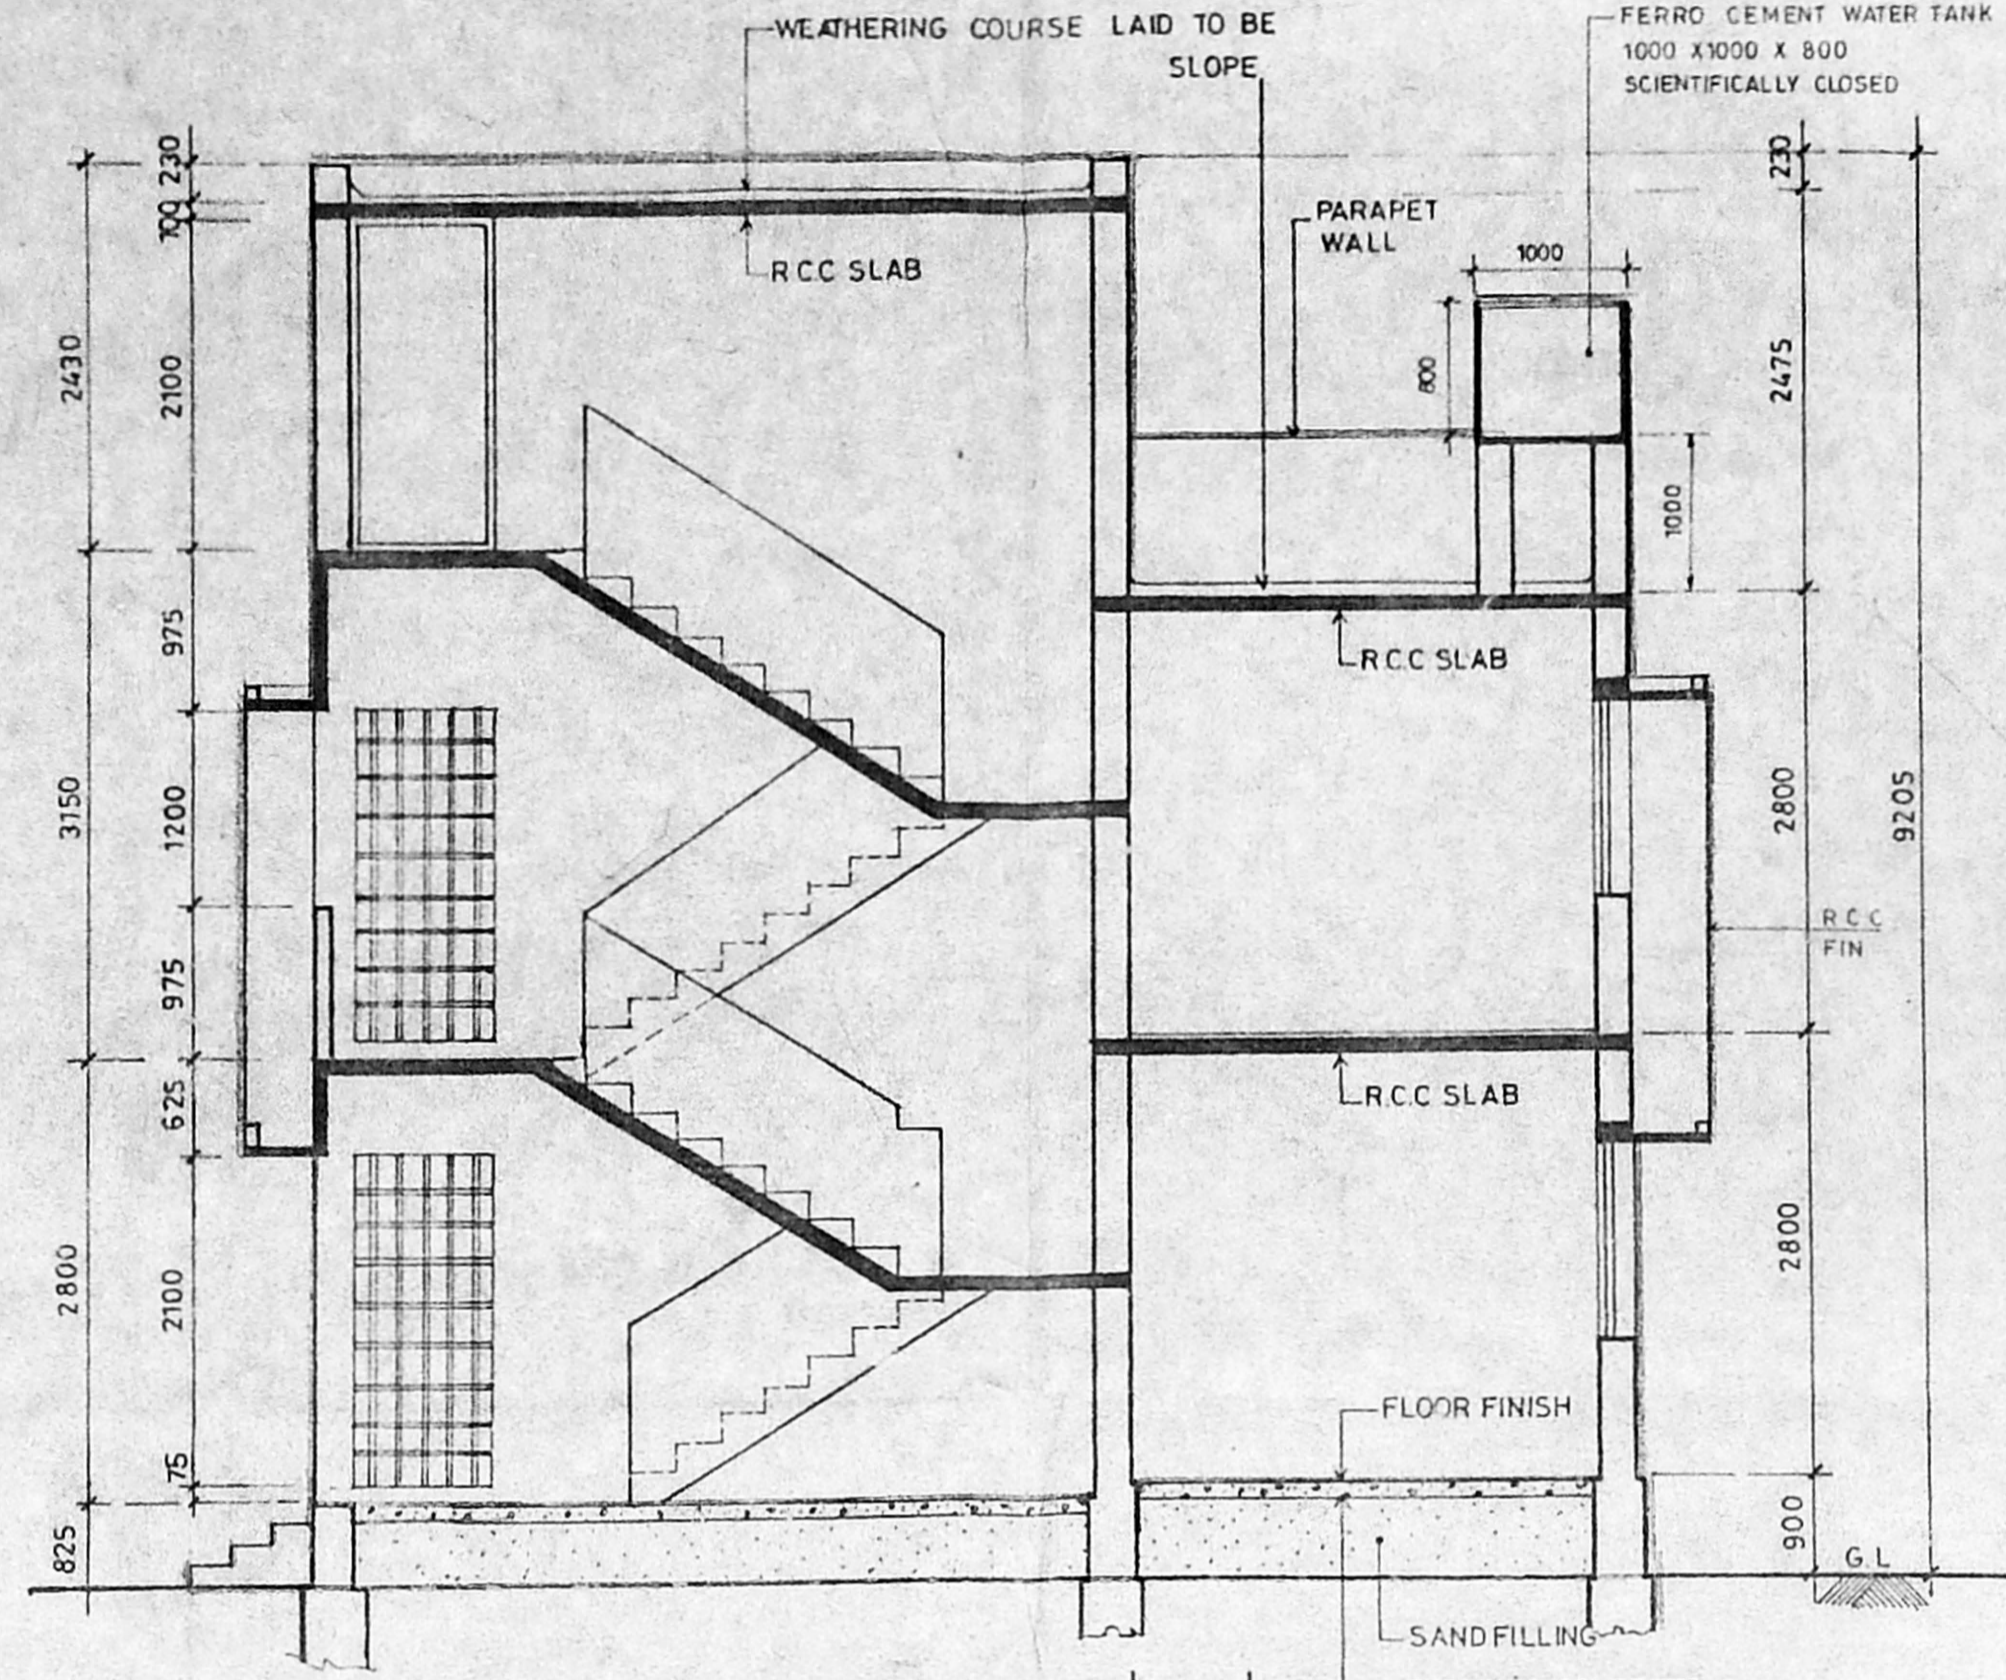


SECTION - A A

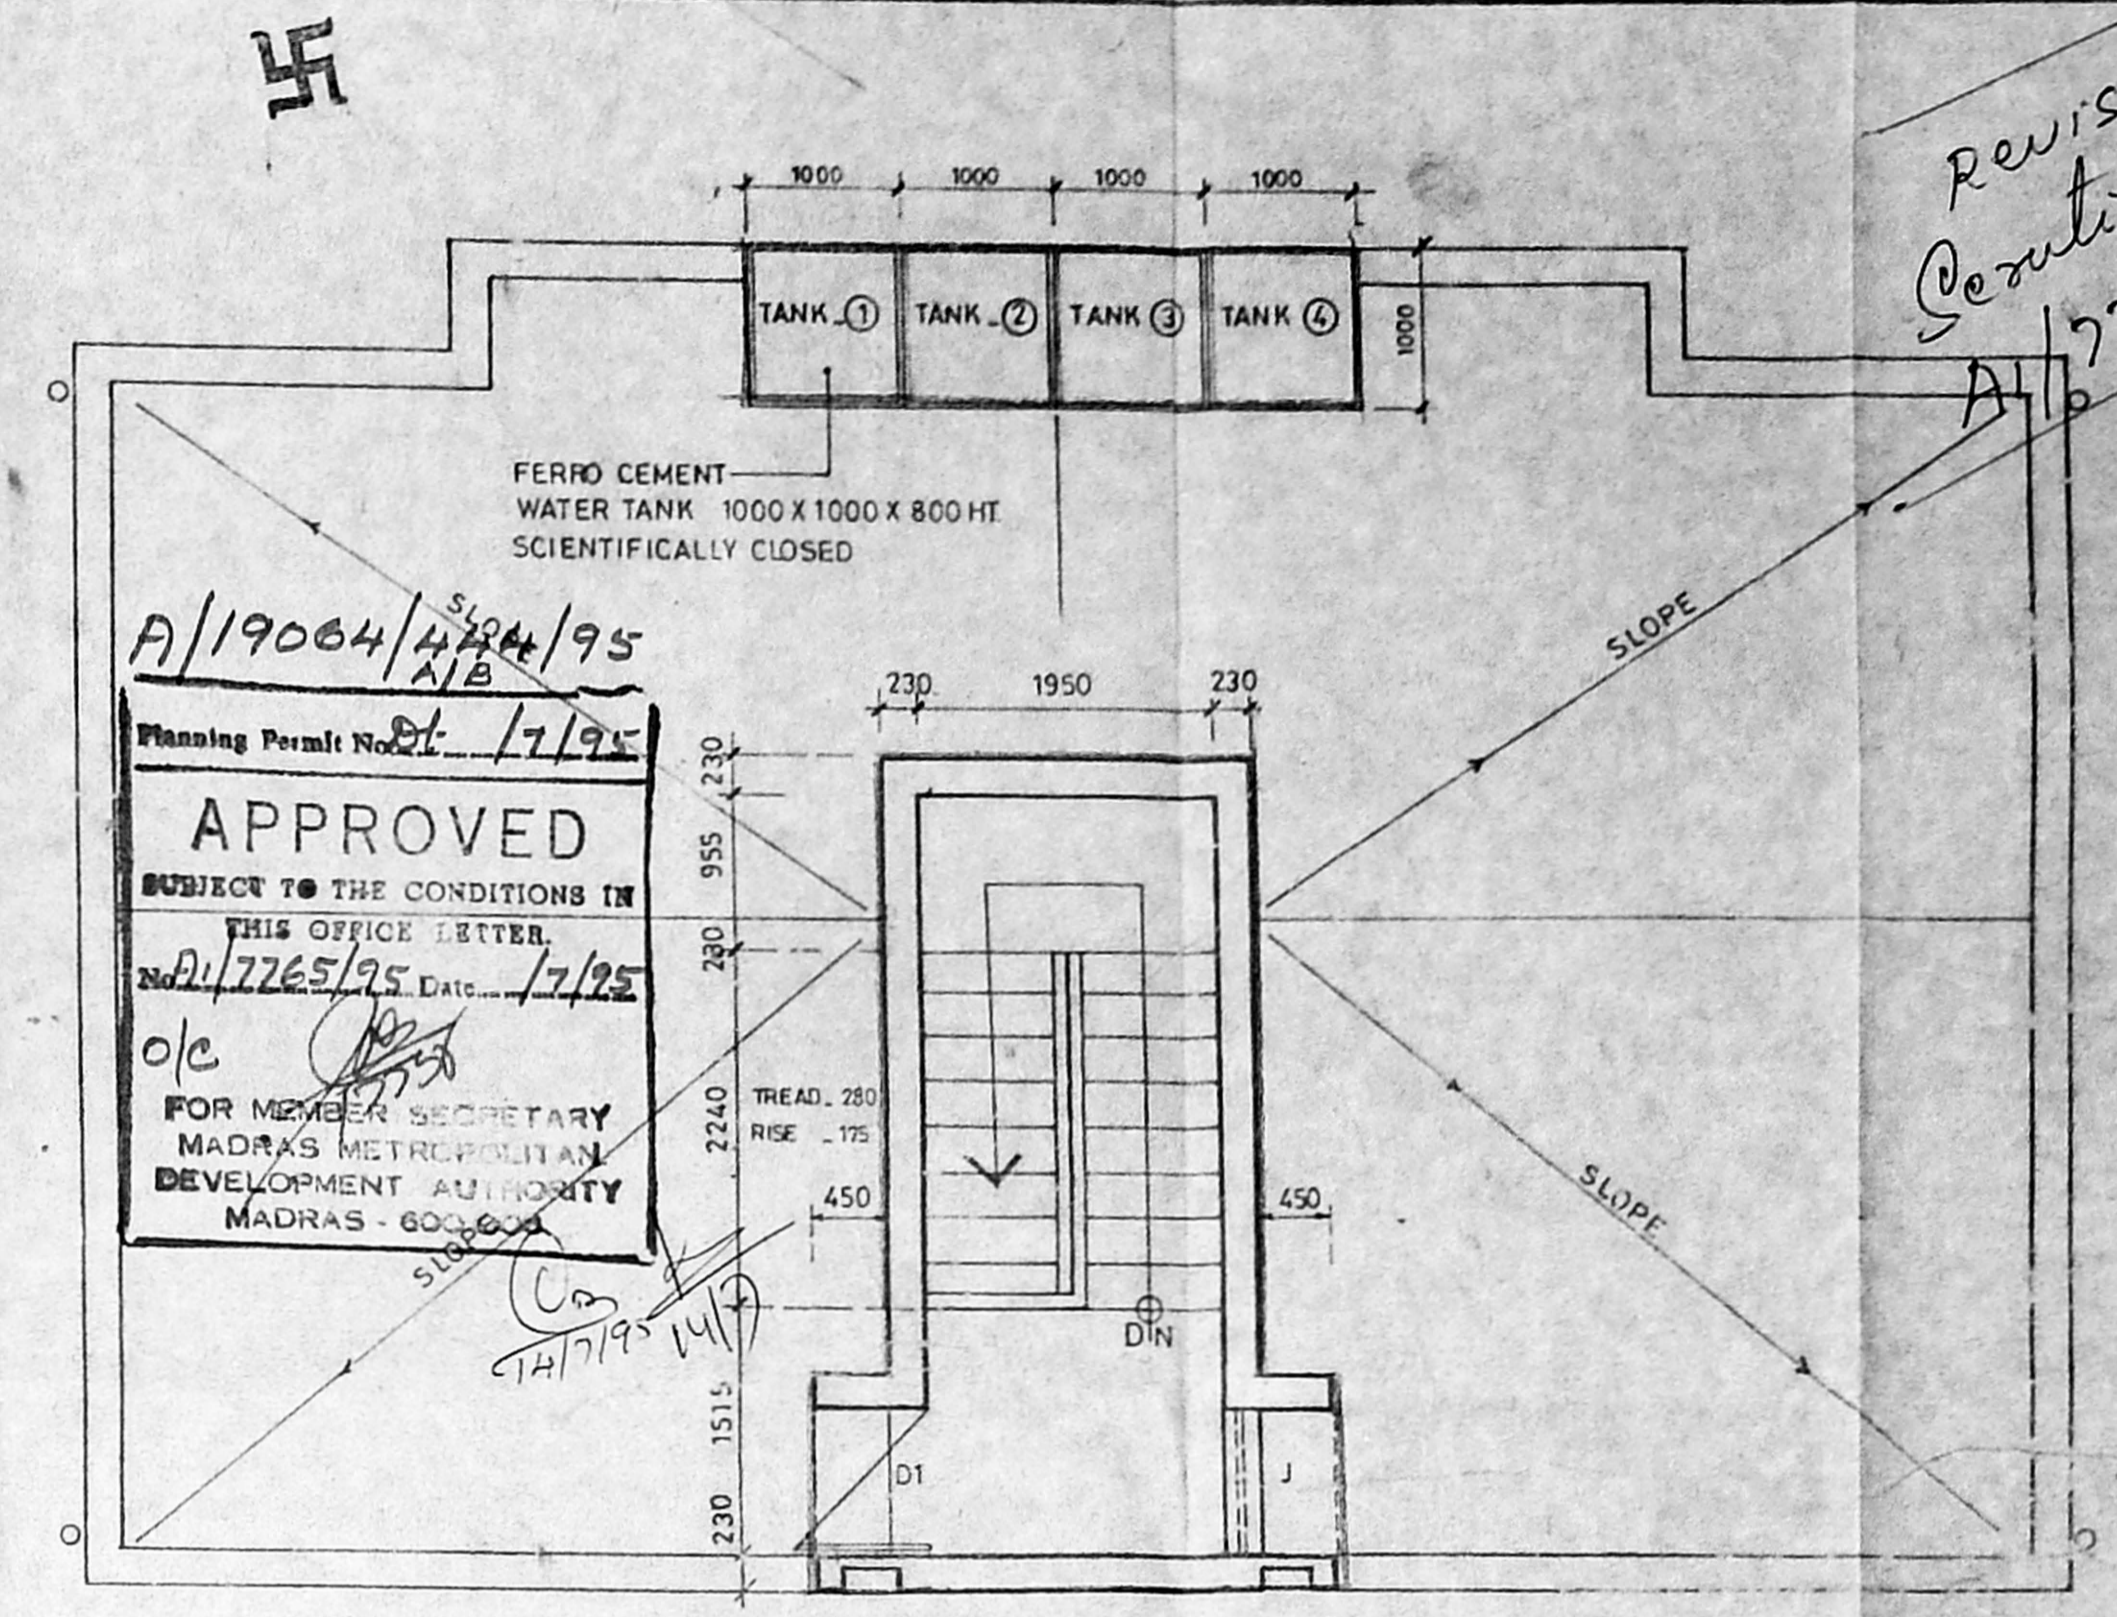


TERRACE PLAN

A/19064/484/95  
 Planning Permit No. 17/95  
**APPROVED**  
 SUBJECT TO THE CONDITIONS IN THIS OFFICE LETTER.  
 No. 17265/95, Date: 17/95  
 o/c  
 FOR MEMBER SECRETARY  
 MADRAS METROPOLITAN  
 DEVELOPMENT AUTHORITY  
 MADRAS - 600 004


Revised  
 Counting plan  
 A/17265/95  
 14/7/95

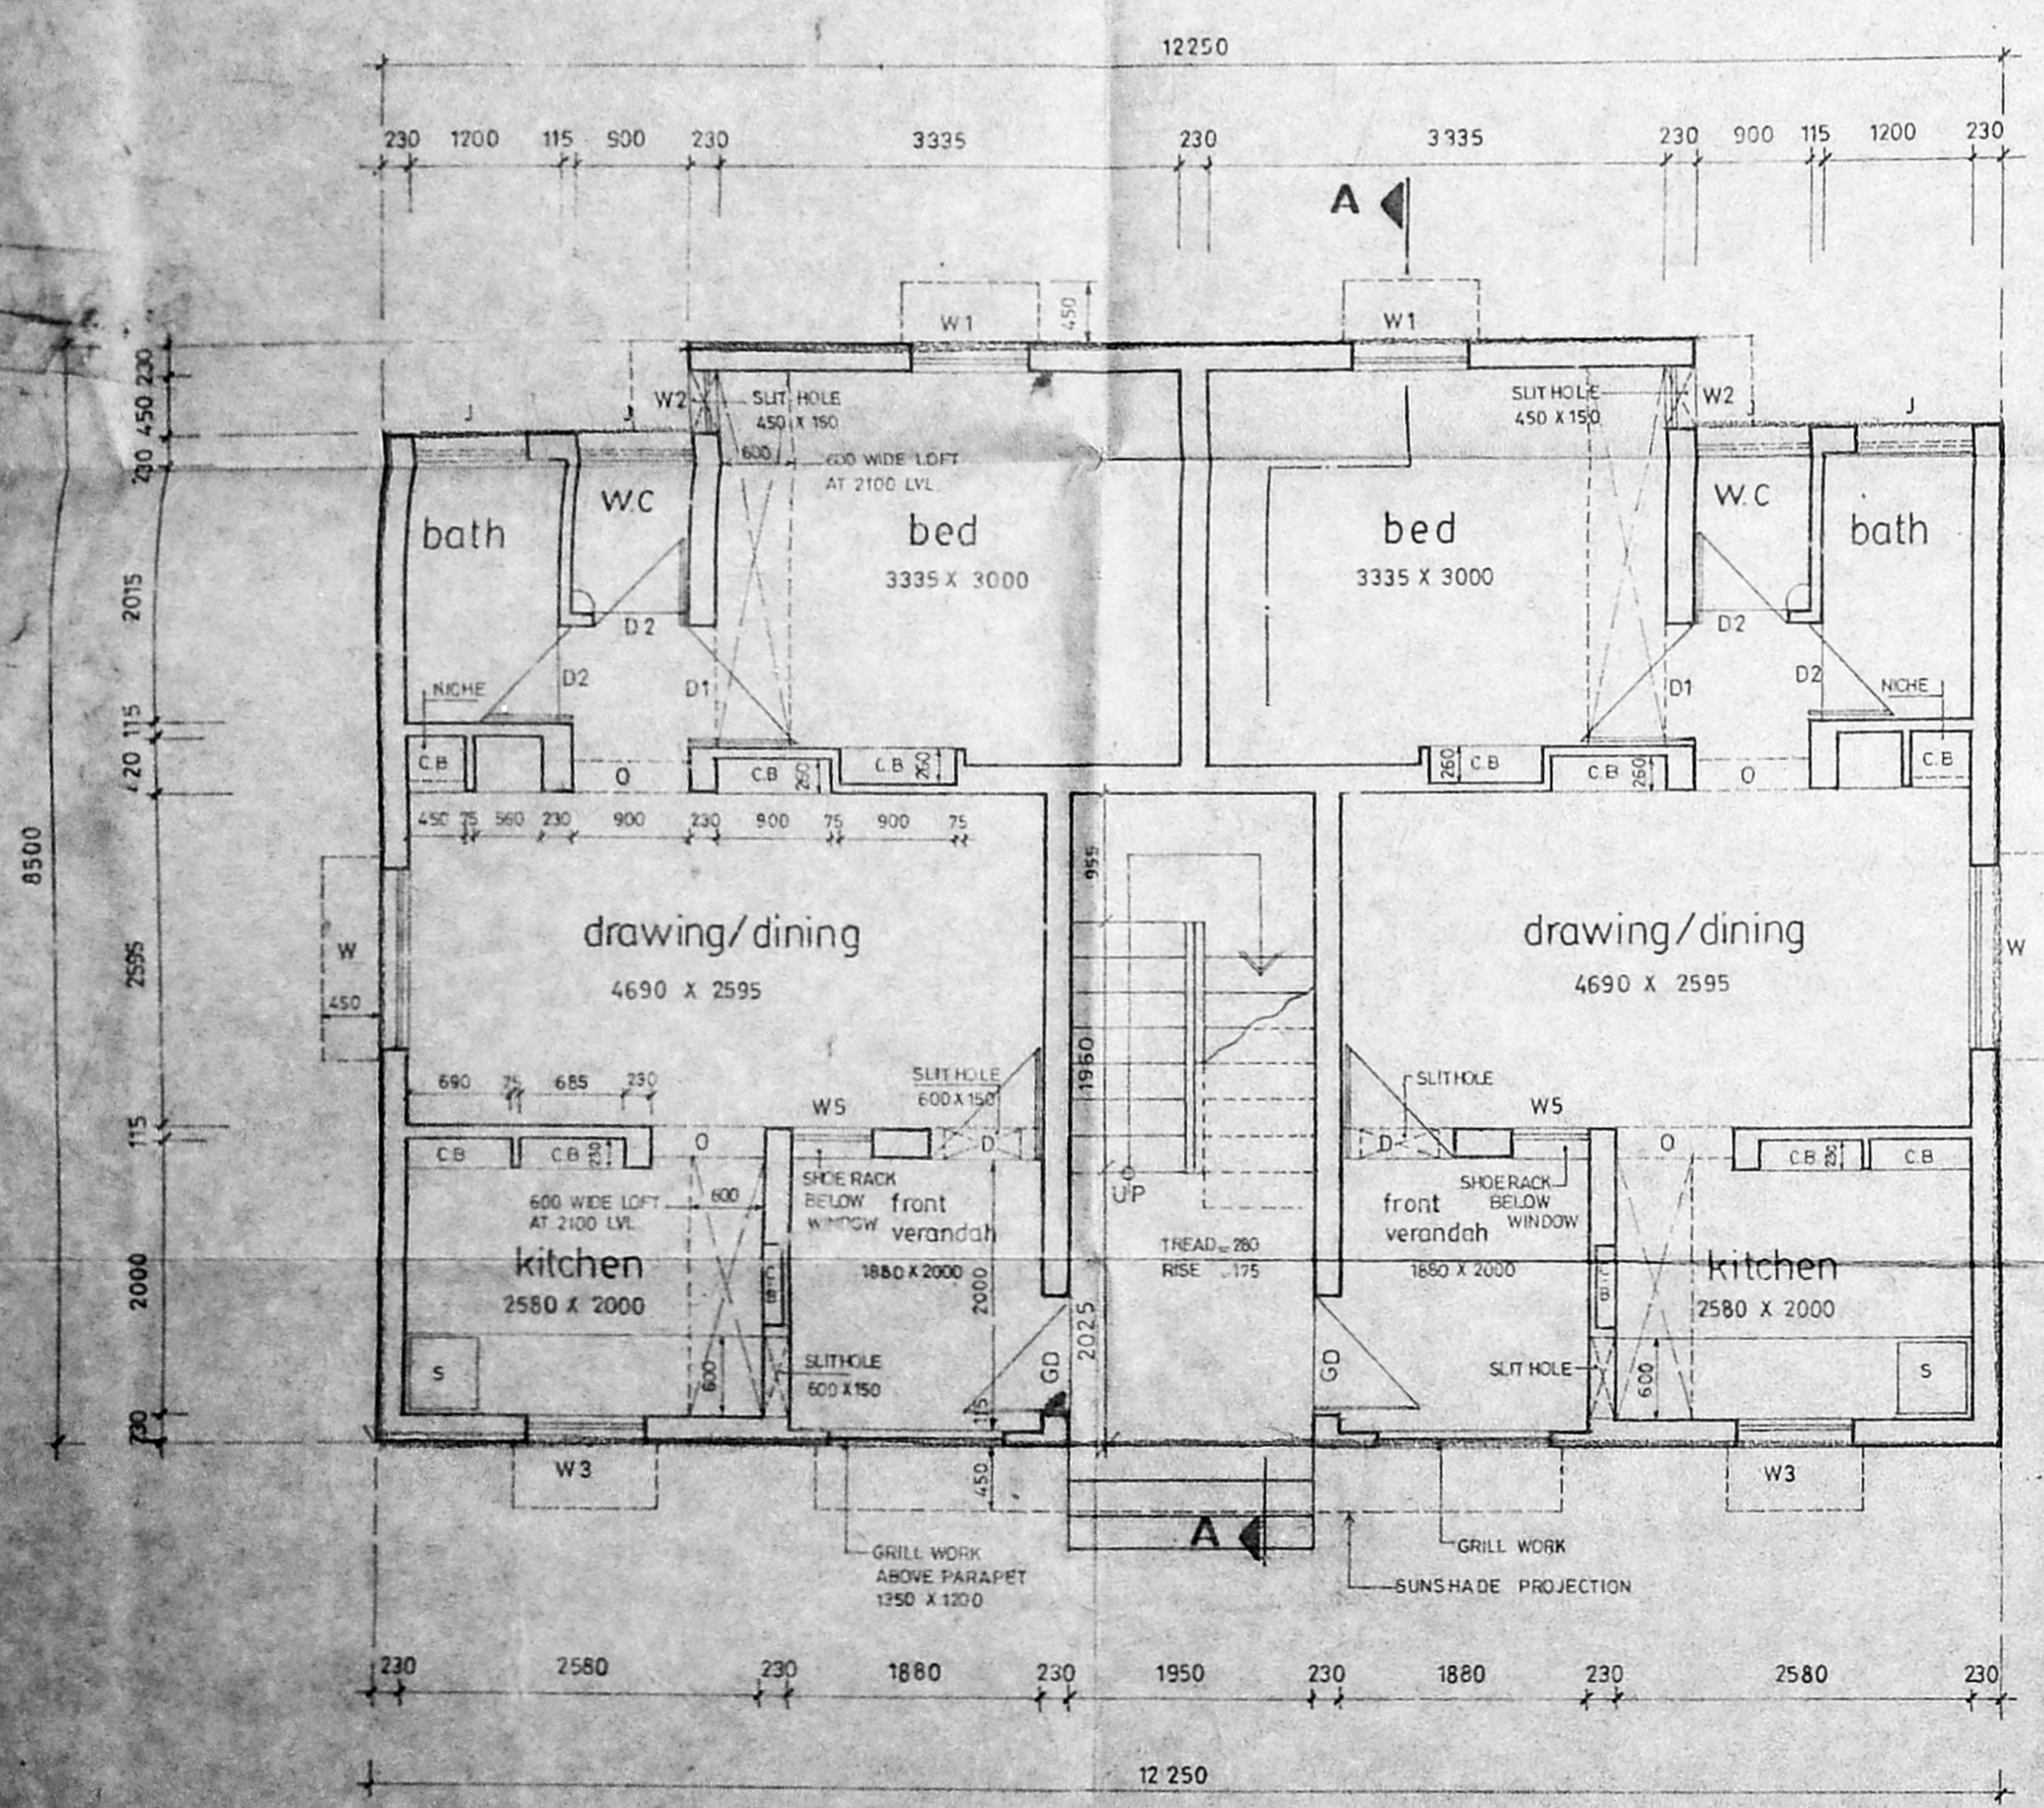

GROUND FLOOR PLAN

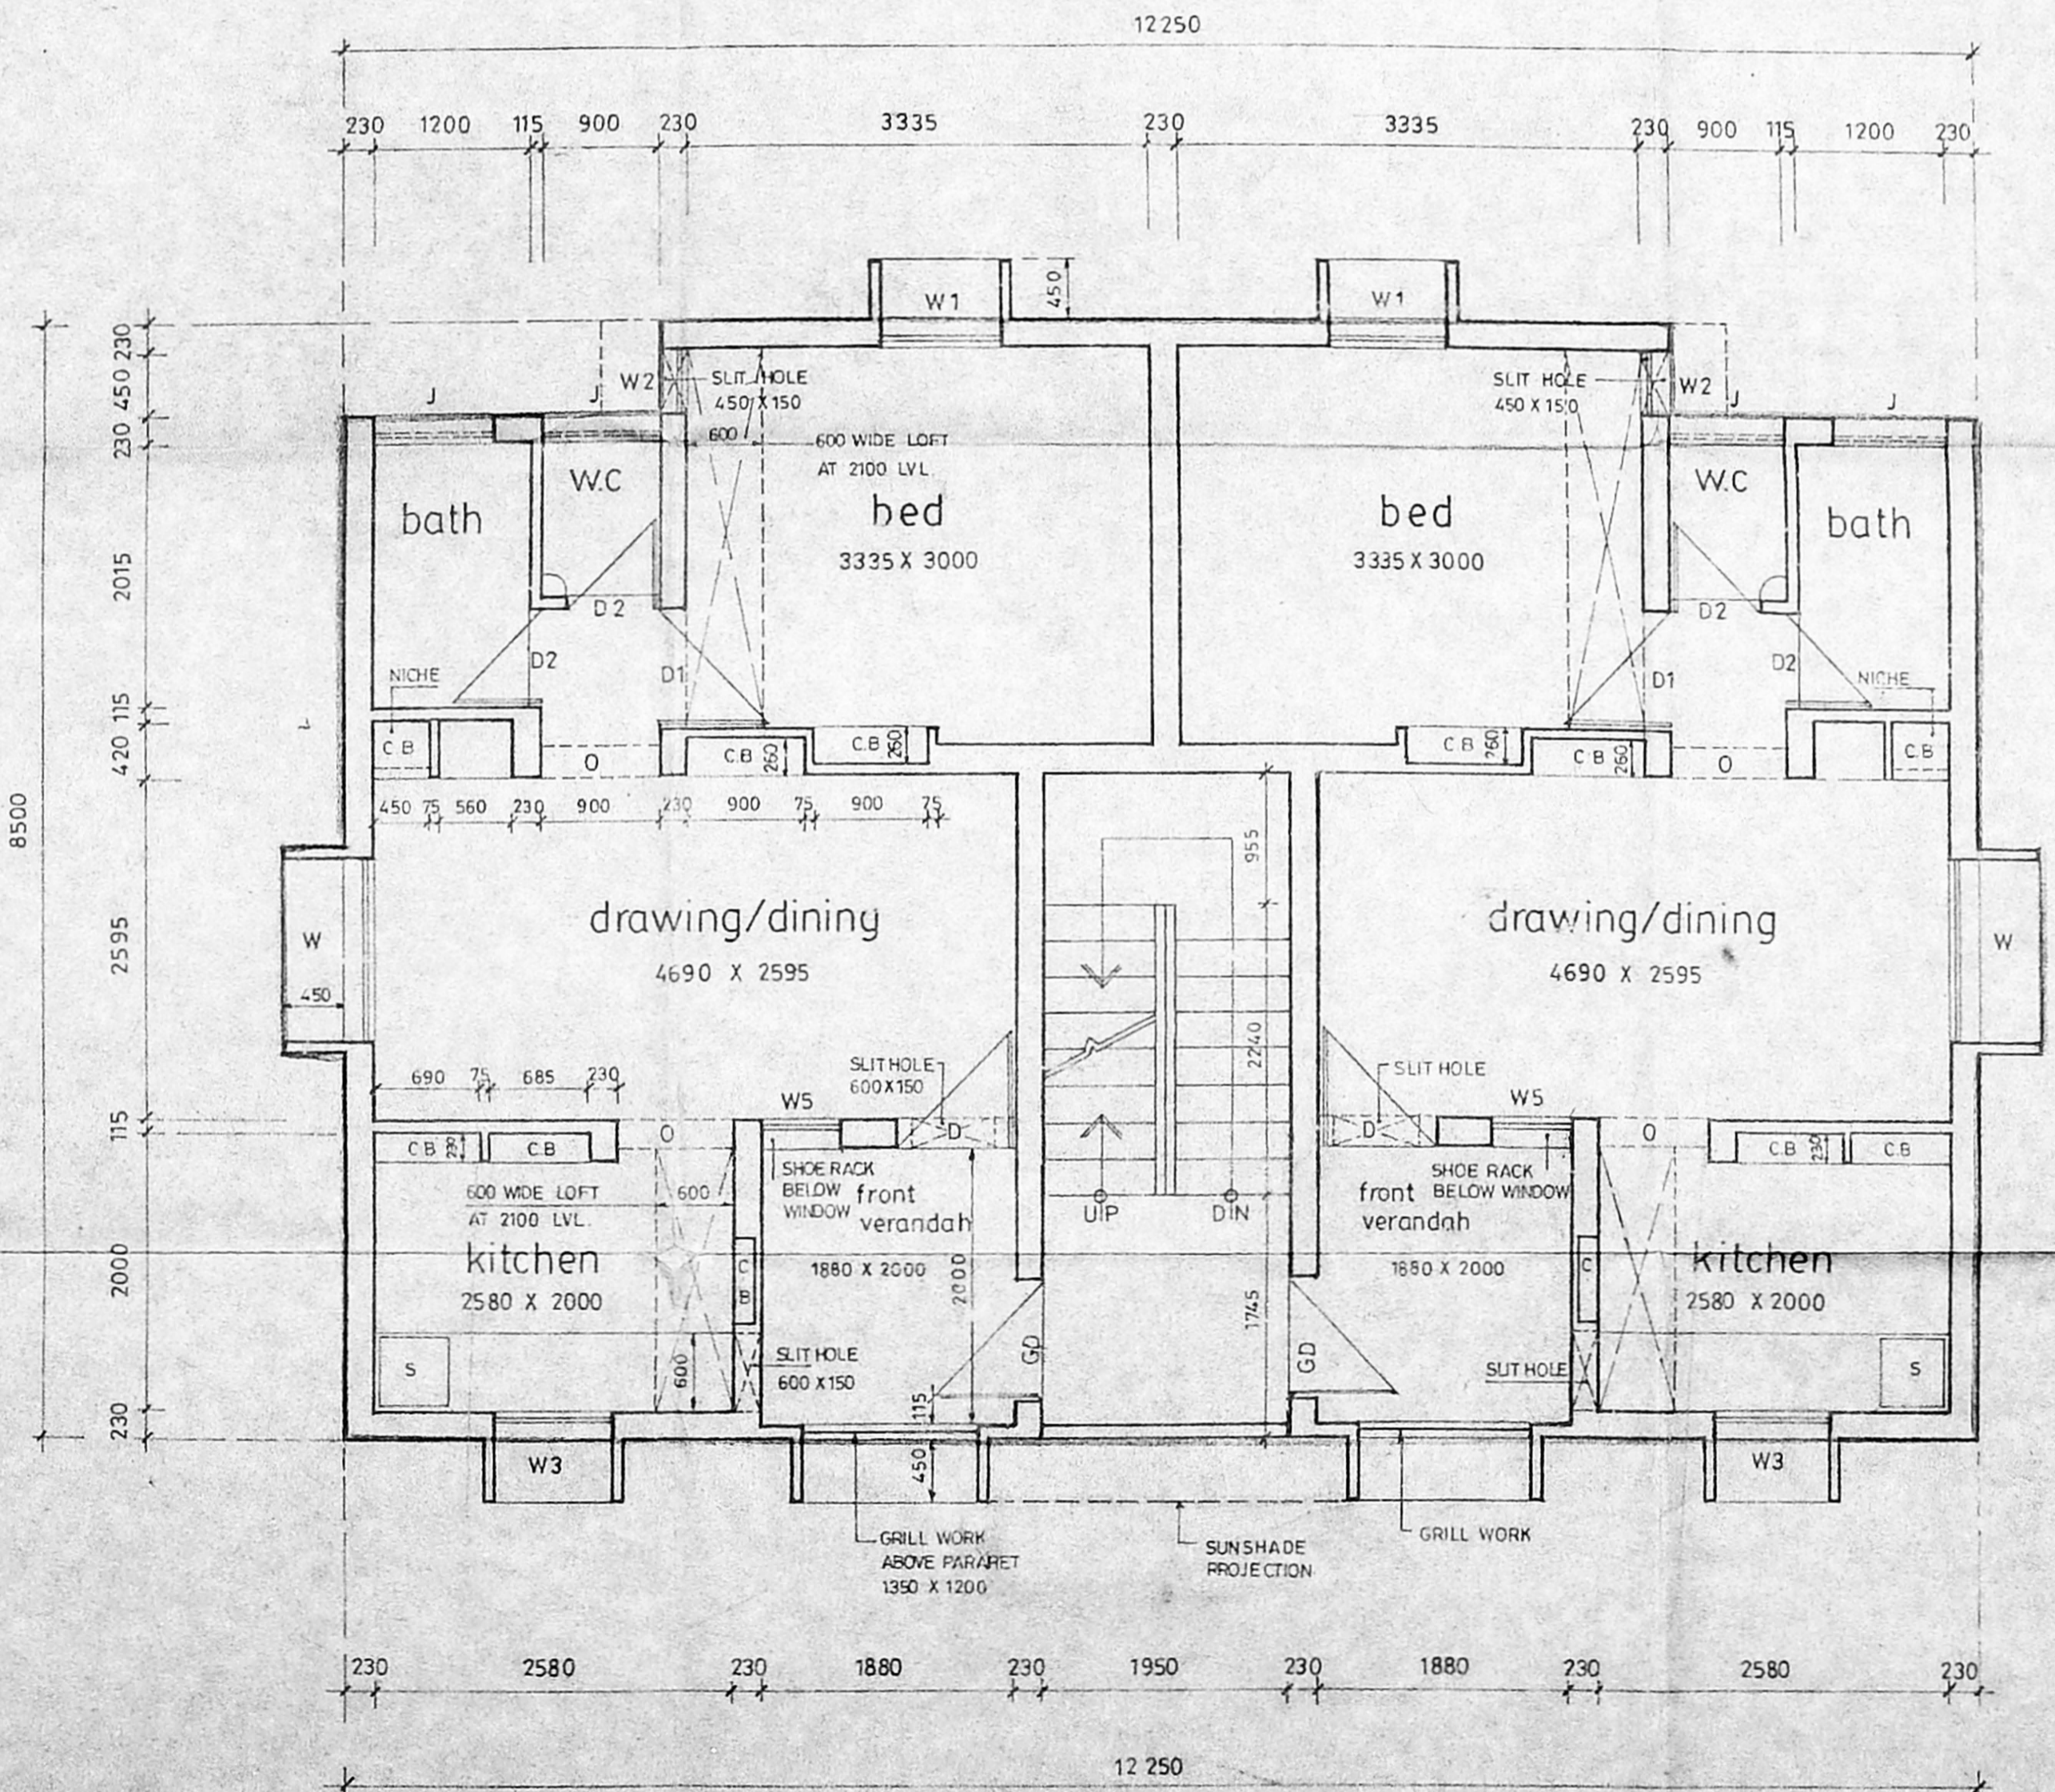

FIRST FLOOR PLAN

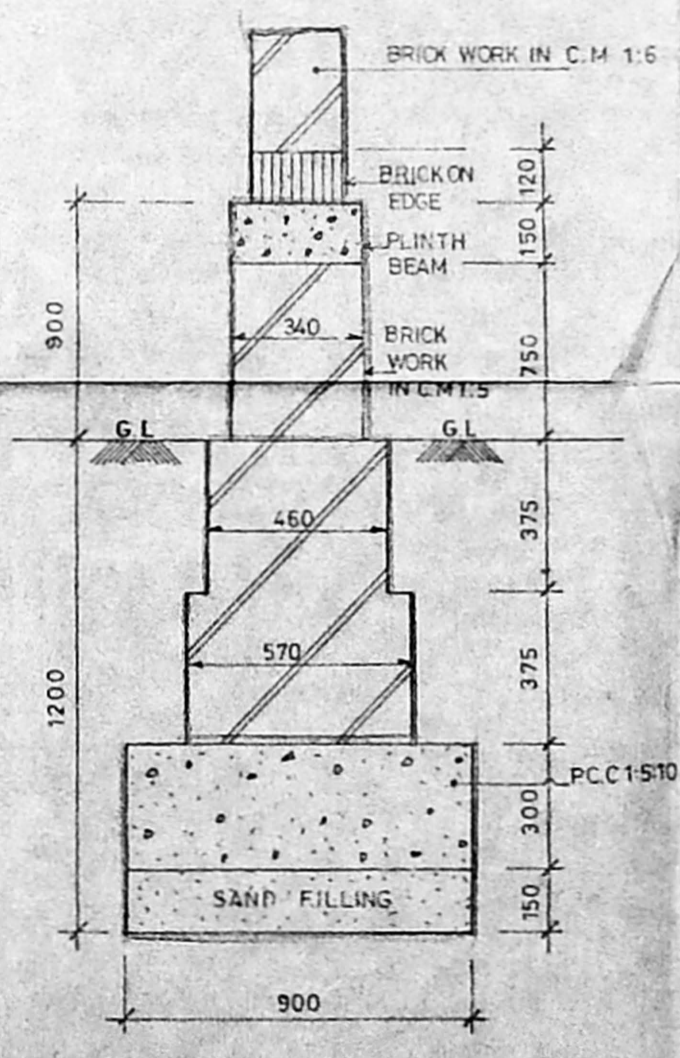

FOUNDATION DETAIL

SCHEDULE OF JOINERY		
D	DOOR	900 X 2100 RCC FRAME T.W PANELLED SHUTTER
D1	DOOR	900 X 2100 RCC FRAME, MARINE PLY
D2	DOOR	700 X 2100
W	WINDOW	1350 X 1200 STEEL WINDOW
W1	WINDOW	900 X 1200
W2	WINDOW	450 X 1200
W3	WINDOW	900 X 1050
J	JALLY	900 X 600
O	OPENING	900 X 2100
W5	WINDOW	600 X 1200 STEEL WINDOW

AREA		
PLINTH AREA:		
GROUND FLOOR	100.80 M <sup>2</sup>	OR 1084.00 SQ. FT.
FIRST FLOOR	100.30 M <sup>2</sup>	OR 1084.00 SQ. FT.
PER UNIT INCLUDING 1/2 STAIRS	50.40 M <sup>2</sup>	OR 542.00 SQ. FT.
PER UNIT EXCLUDING 1/2 STAIRS	45.60 M <sup>2</sup>	OR 491.00 SQ. FT.

TAMILNADU POLICE HOUSING CORPORATION  
 NO. 1, WHITES ROAD MADRAS - 14.

PROPOSED DWELLING IN PLOT NO. 7 IN S.NO. 141/1 Part OF MADURAVOYAL VILLAGE, SAIDAPET TALUK, CHENGAI - M.G.R. DISTRICT.

DRAUGHTSMAN  
 ASST. ARCHITECT  
 ASST. EXECUTIVE ENGINEER  
 CHIEF ENGINEER

SCALE: 1:50


S.D.  
 1/94




A/19064/444/95  
B/B

Planning Permit No. DT 12/95  
**APPROVED**  
SUBJECT TO THE CONDITIONS IN  
THE PLAN  
No. A1/7765/95 12/95  
*etc*  
FOR MEMBER SECRETARY  
MADRAS METROPOLITAN  
DEVELOPMENT AUTHORITY  
MADRAS - 600 008.

14/7/95

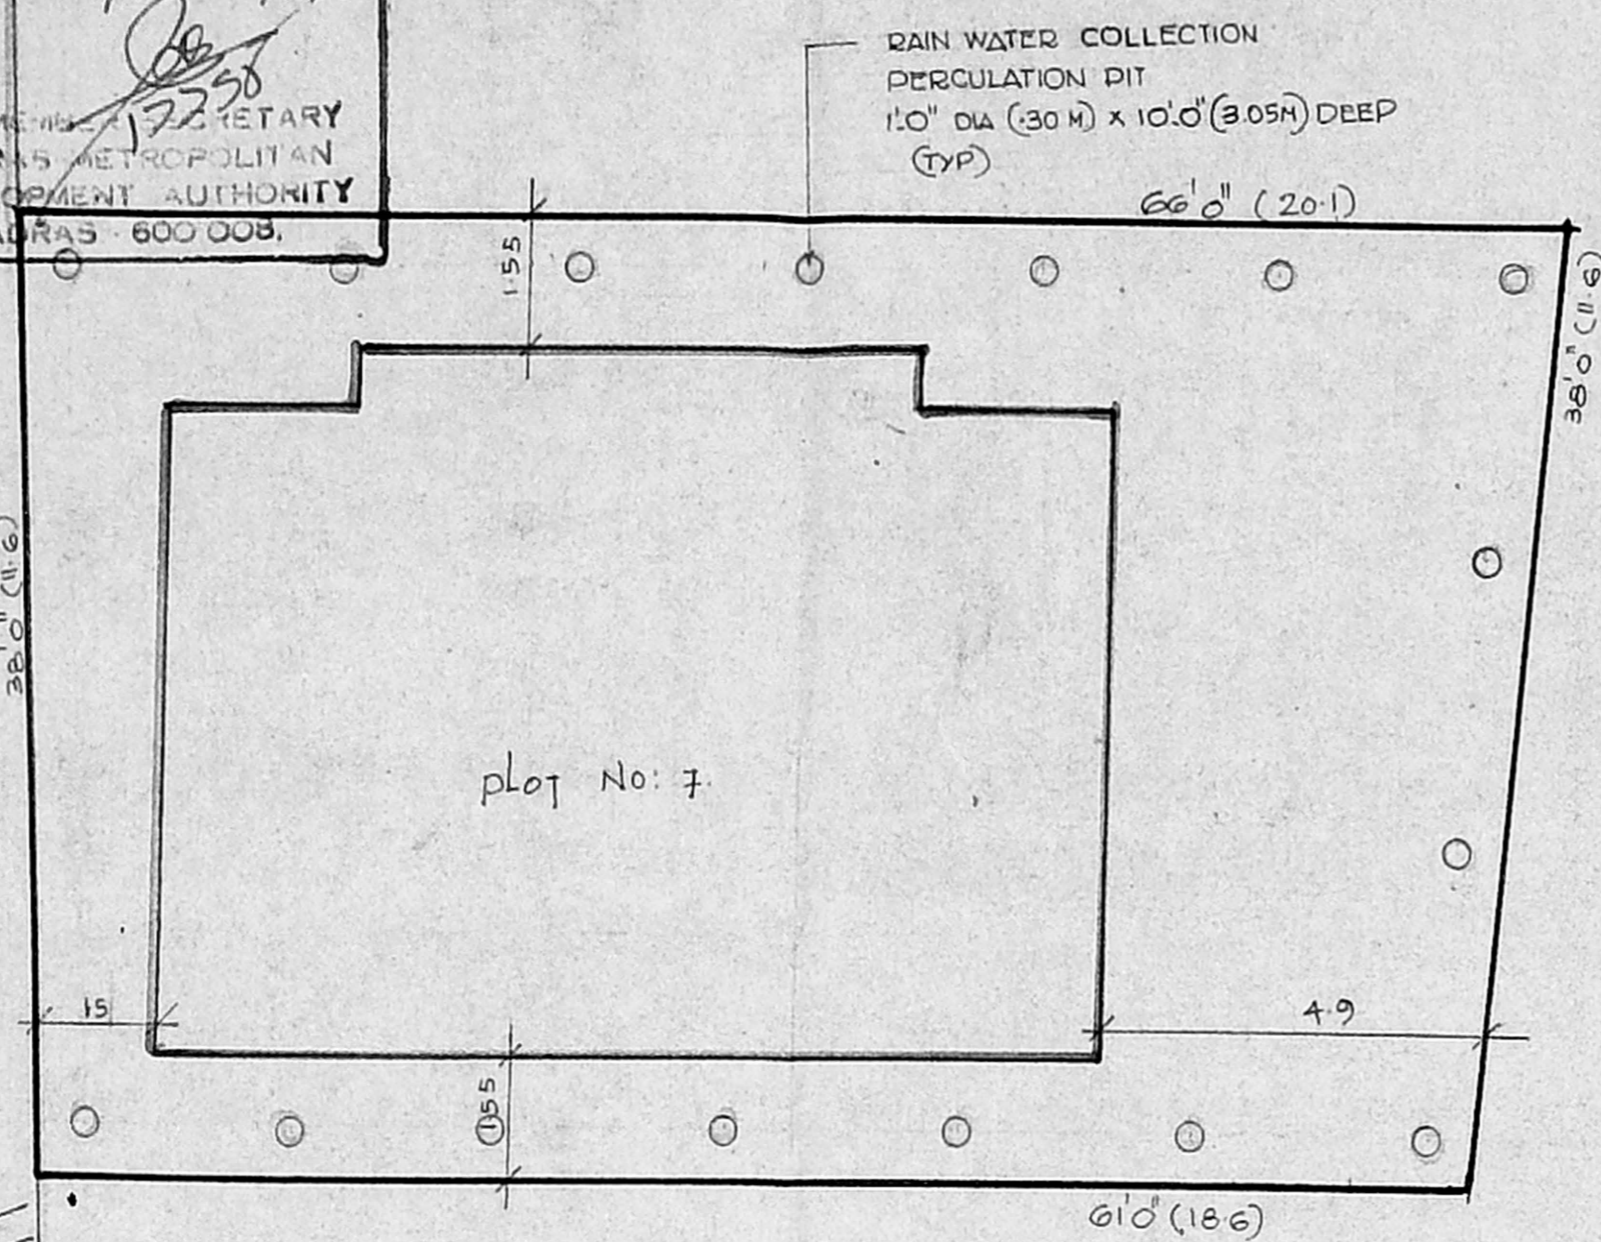


SITE PLAN

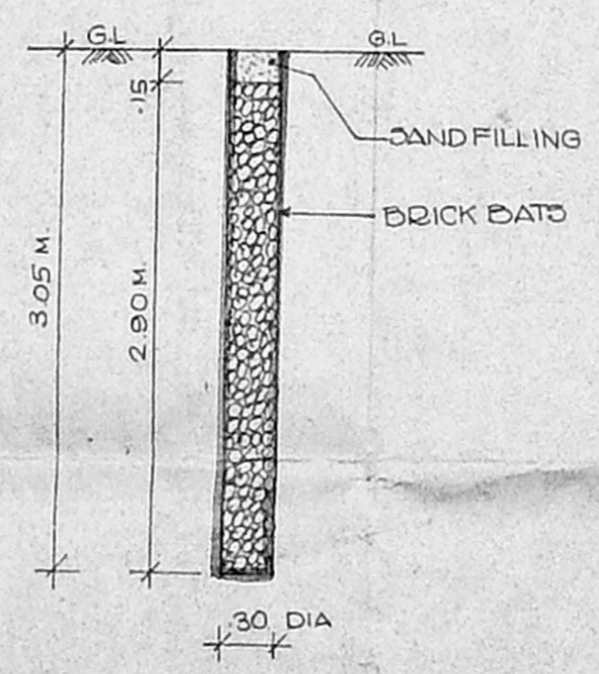

DETAIL OF RAIN WATER  
PERCOLATION PIT


COLOUR CODE REFERENCE

PROPOSED	
ROAD	
BOUNDARY	

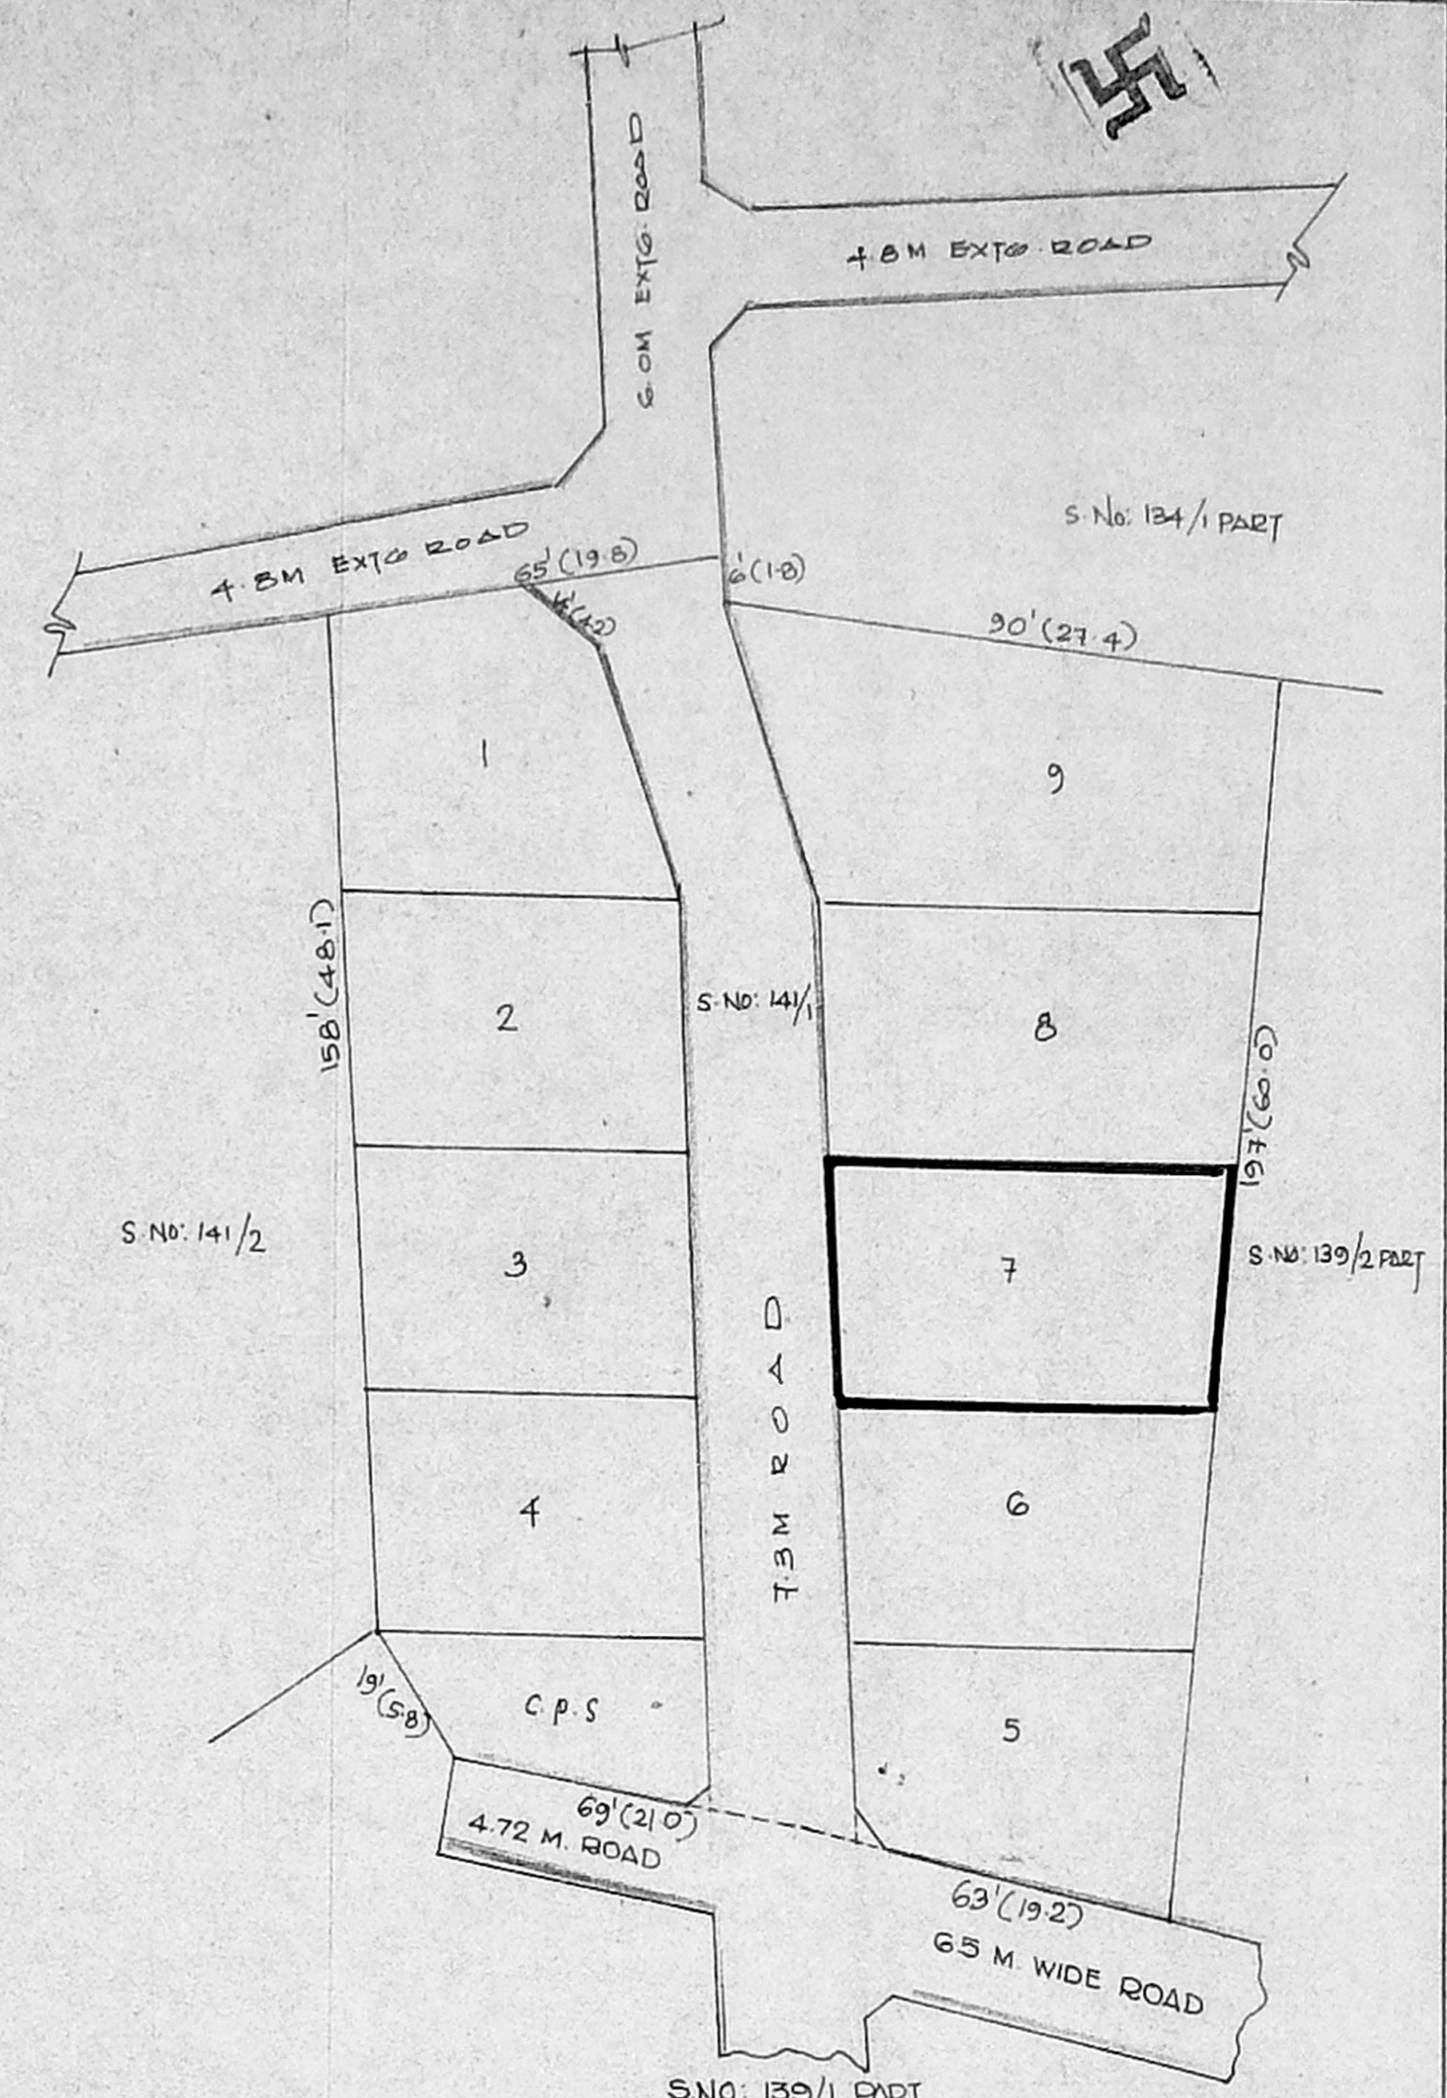

LAYOUT PLAN (SCALE: 1"=33'0")

(MMDA APPROVED LAYOUT L2/567/94 DT: 8.8.94)

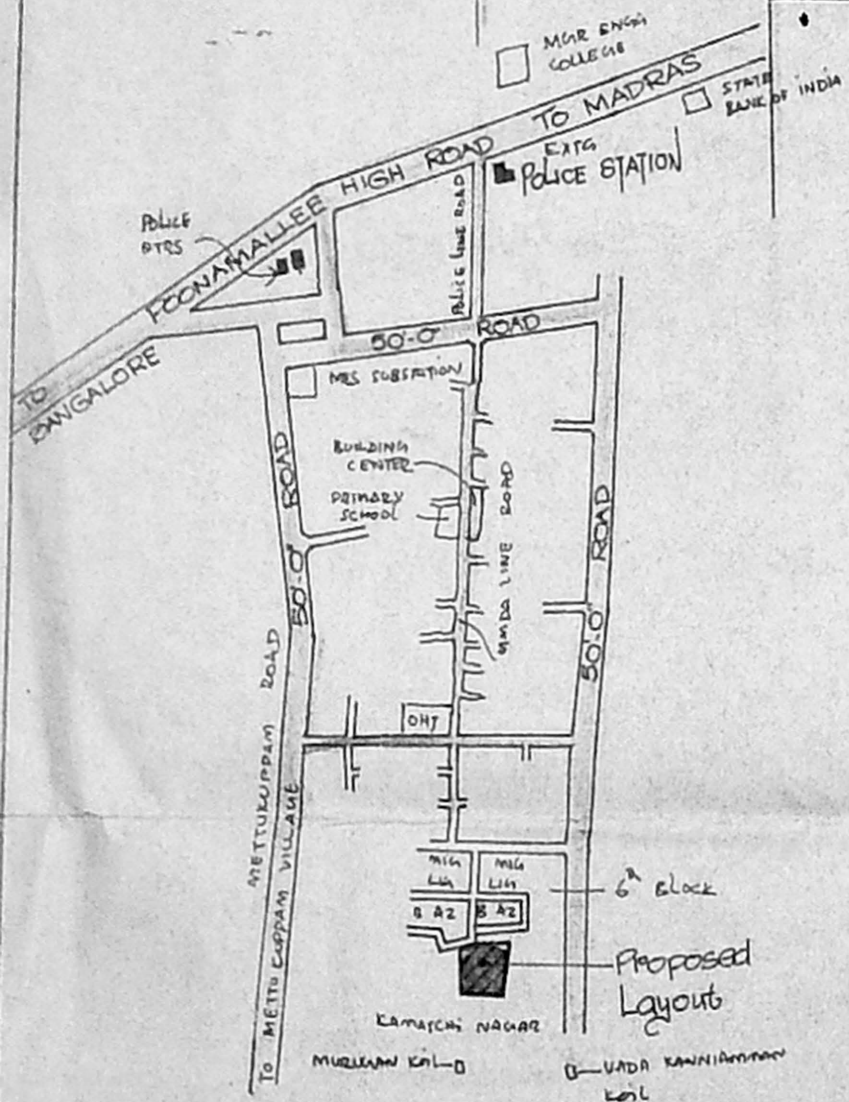

KEY PLAN  
(NOT TO SCALE)

ASST. DRAUGHTS MAN	PROPOSED DWELLING	
<i>Vandana</i> 2/9/94 ASST. ARCHITECT	AT PLOT NO: 7 IN	
<i>Shiv</i> ASST. EXE. ENGINEER	S.NO: 141/1 PART OF MADURAVOYAL VILLAGE SAIDAPET TALUK CHENGAI - M.G.R. DISTRICT	
<i>Arumugam</i> 12/9 CHIEF ENGINEER	SCALE: 1:100	 S.P 63/7/94
TAMILNADU POLICE HOUSING CORPORATION		
NO: 1 WHITES ROAD MADRAS - 600 014		