
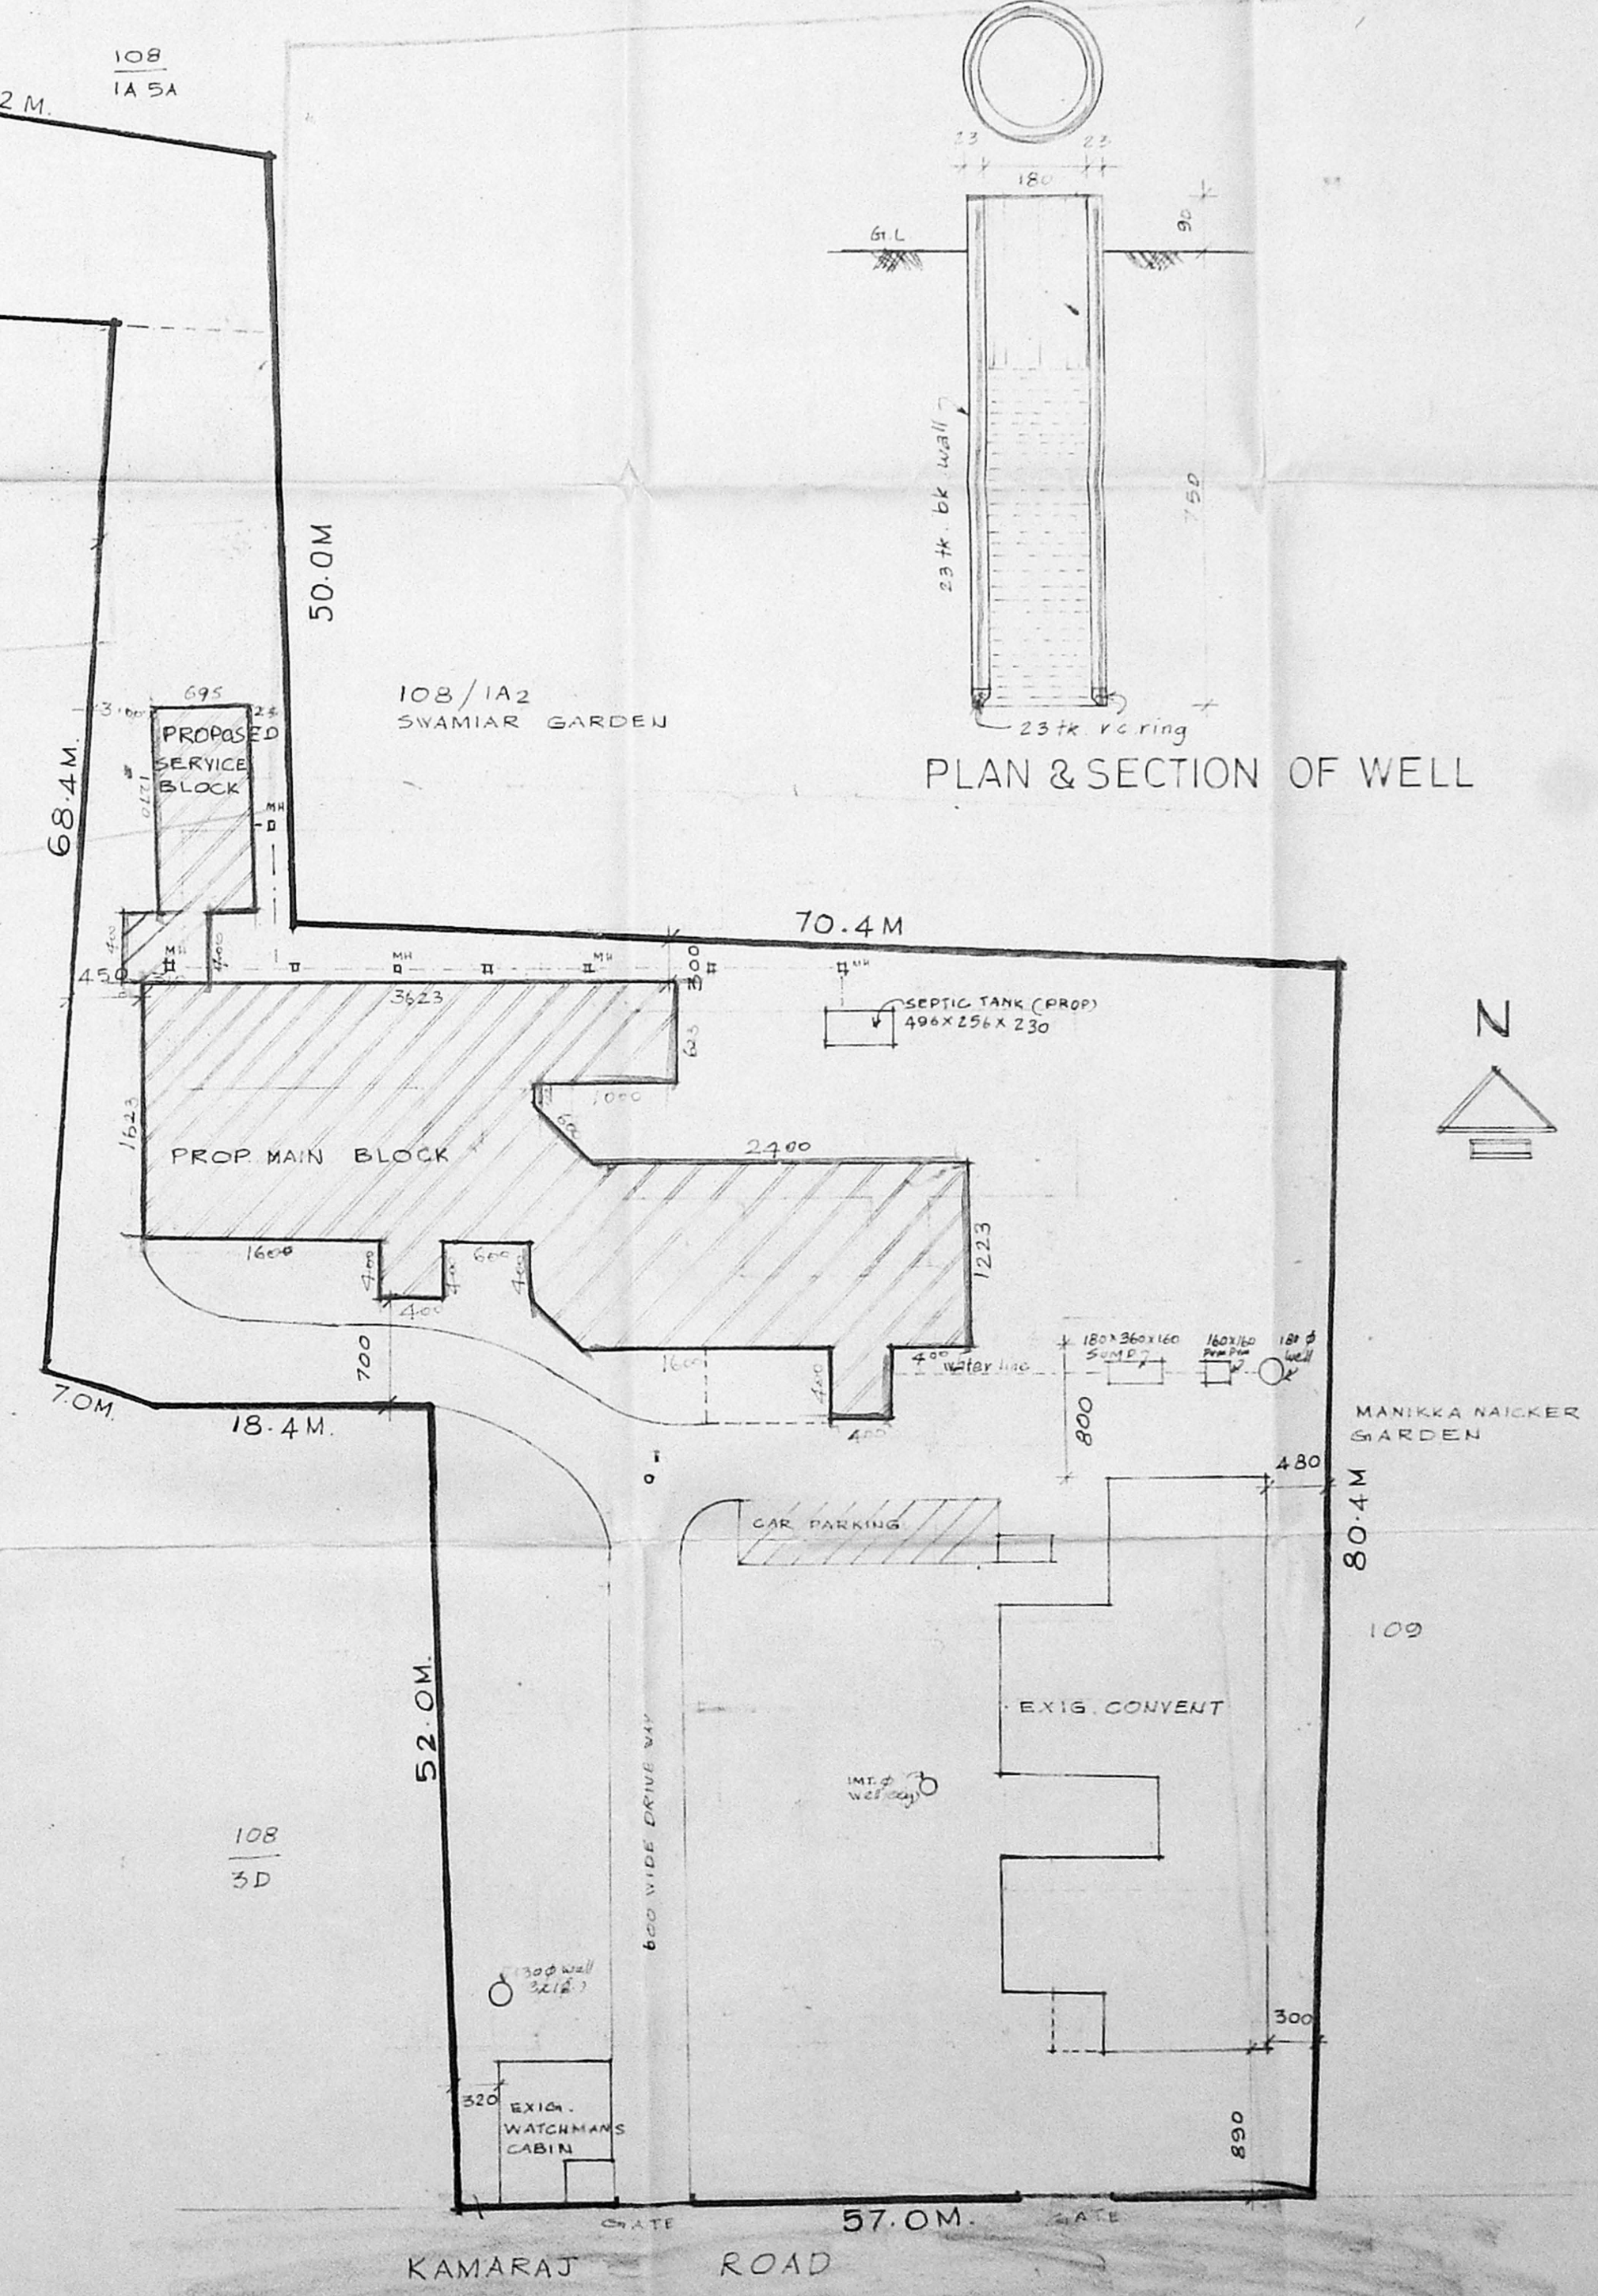
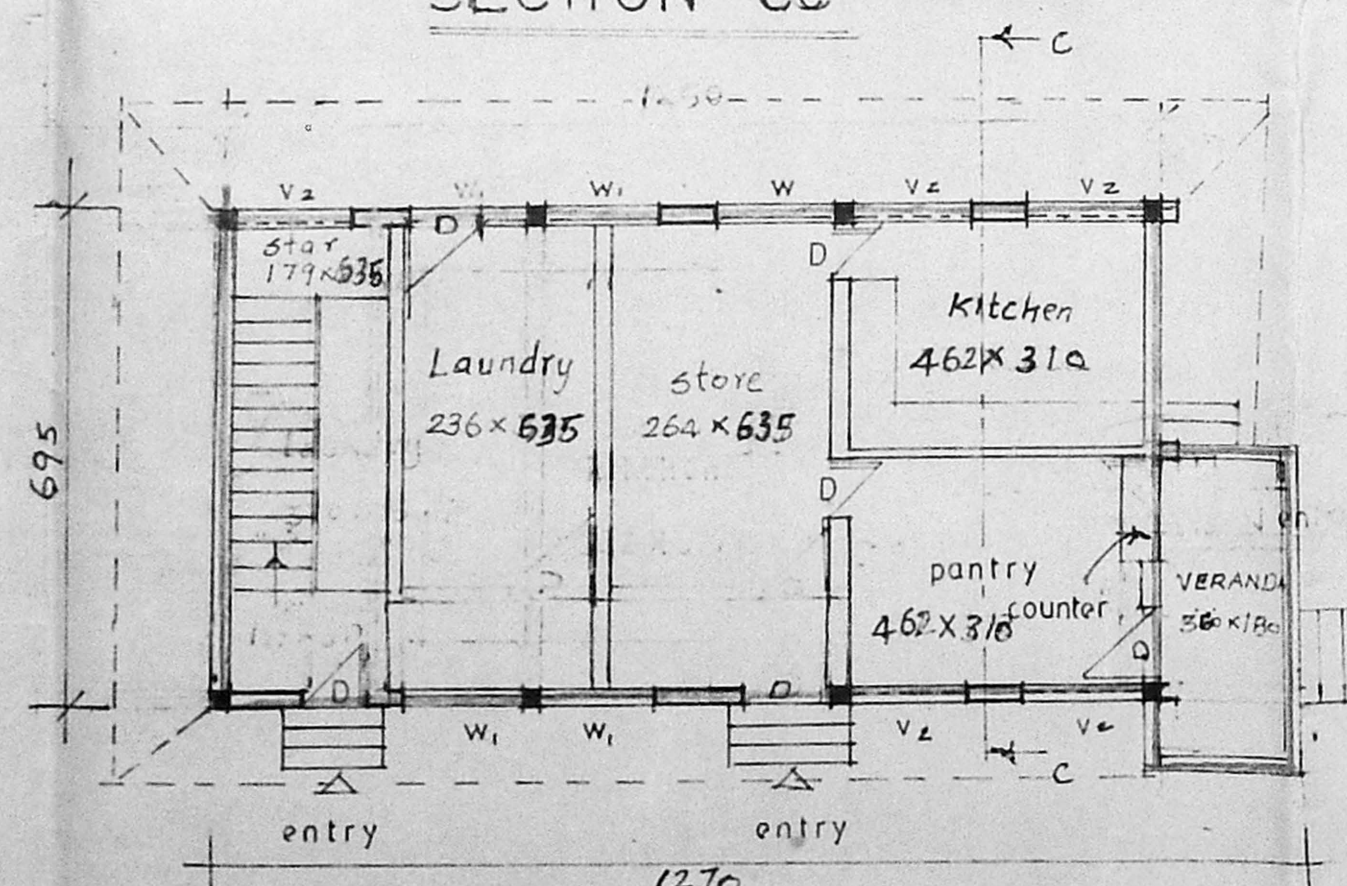
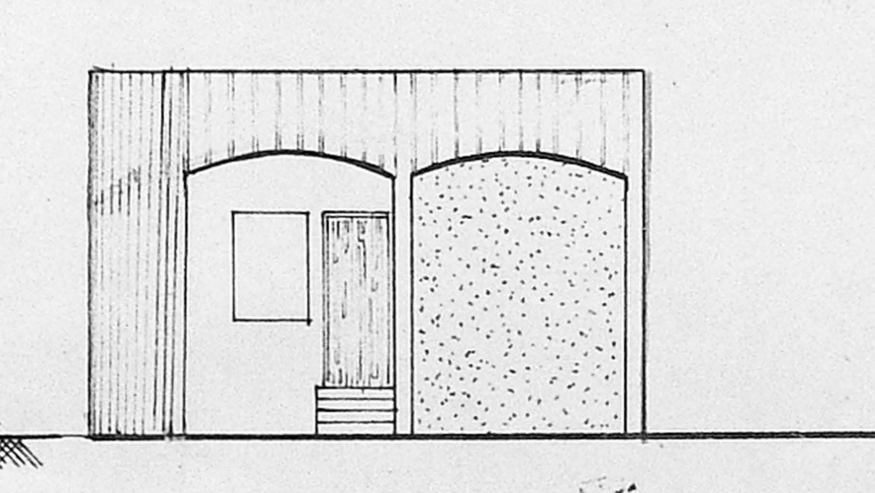
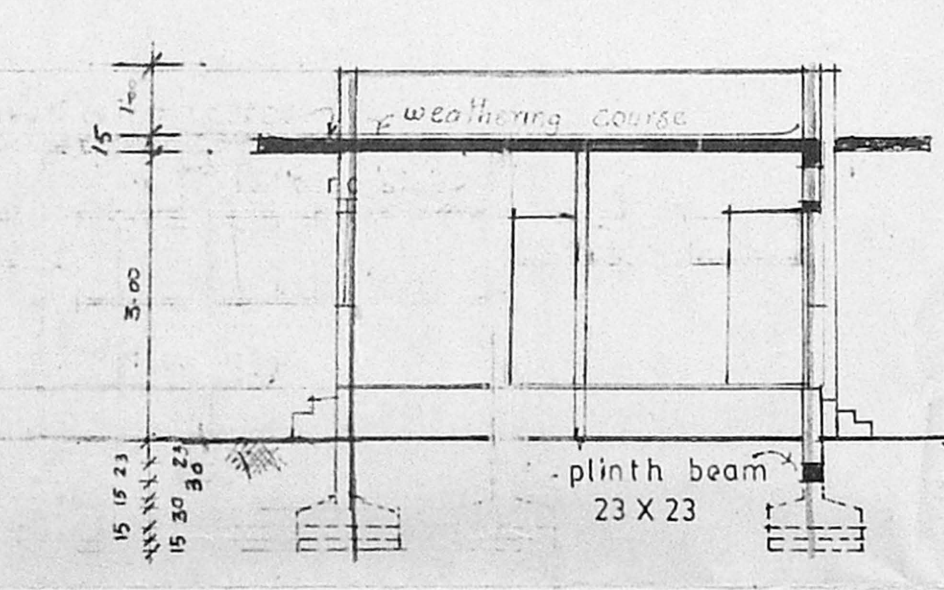


APPROVED
 SUBJECT TO THE CONDITIONS IN THIS OFFICE LETTER.
 No. C/113/15/195 Date: 1.12.1955
 FOR MEMBER SECRETARY
 MADRAS METROPOLITAN
 DEVELOPMENT AUTHORITY
 MADRAS - 600 008.

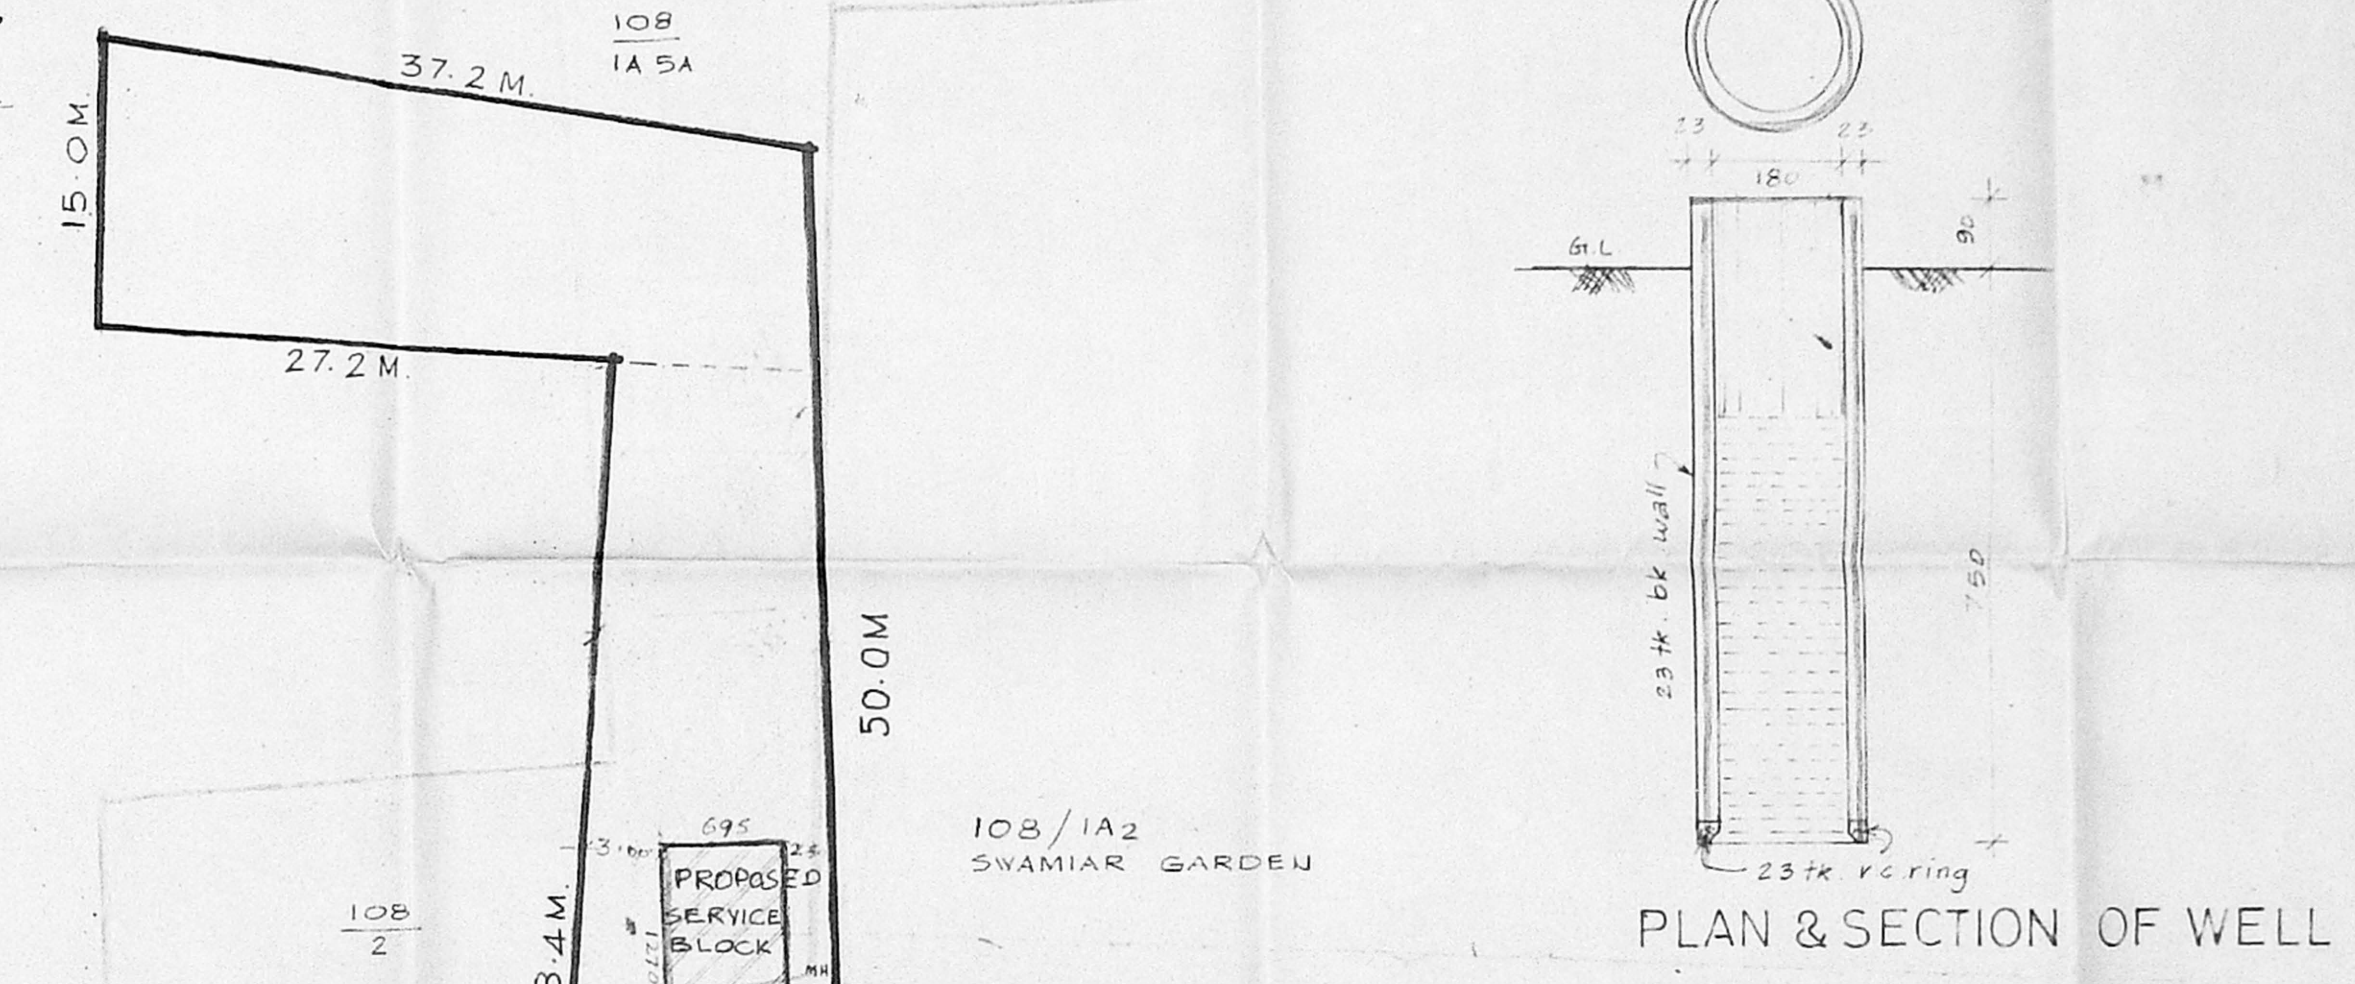

AREA DETAIL (For Coverage)
 AREA OF PLOT = 5450 sq.m
 Area of exis. convent (ground) = 486.00 sq.m
 Area of exis. u.cabin (ground) = 58.00 sq.m
 Area of prop. hospital (ground) = 980.00 sq.m
 Area of service block (ground) = 63.00 sq.m
 TOTAL COVERAGE = 1607.00 sq.m
 PLOT COVERAGE USED = 29.7%
 For P.S.I. 47

Area of exis. blocks = 1024.00 sq.m
 Area of prop. blocks = 7664.62
 TOTAL AREA = 3791.12 sq.m

JEEVODHAYA
 HOSPITAL FOR MEDICALLY
 TERMINATED PATIENTS AT
 R.S. Nos. 108/1A5B, 108/1B, 108/1C
 AT MATHUR, MADRAS.


ALL DIMENSIONS IN CM
 SCALE 1:100
 ARCHITECT

GROUP CONSULTANCY
 School of Architecture
 & Planning
 ANNA UNIVERSITY

ENGINEER JANAKIRAMAN B.E., M.E., M.T.P.
 CONSULTANT ENGINEER, PLANNER & VALUER
 LICENSED SURVEYOR (N.C.S.) PLUMBING LIC. ENGR.
 No. 68/78 CLASS I CORPORATION OF MADRAS
 Metro Water, Ambattur
 18, Lake View Road, Rattur, Madras 60
 (Phone 418479)

R.P. Plans
25/9/90

275

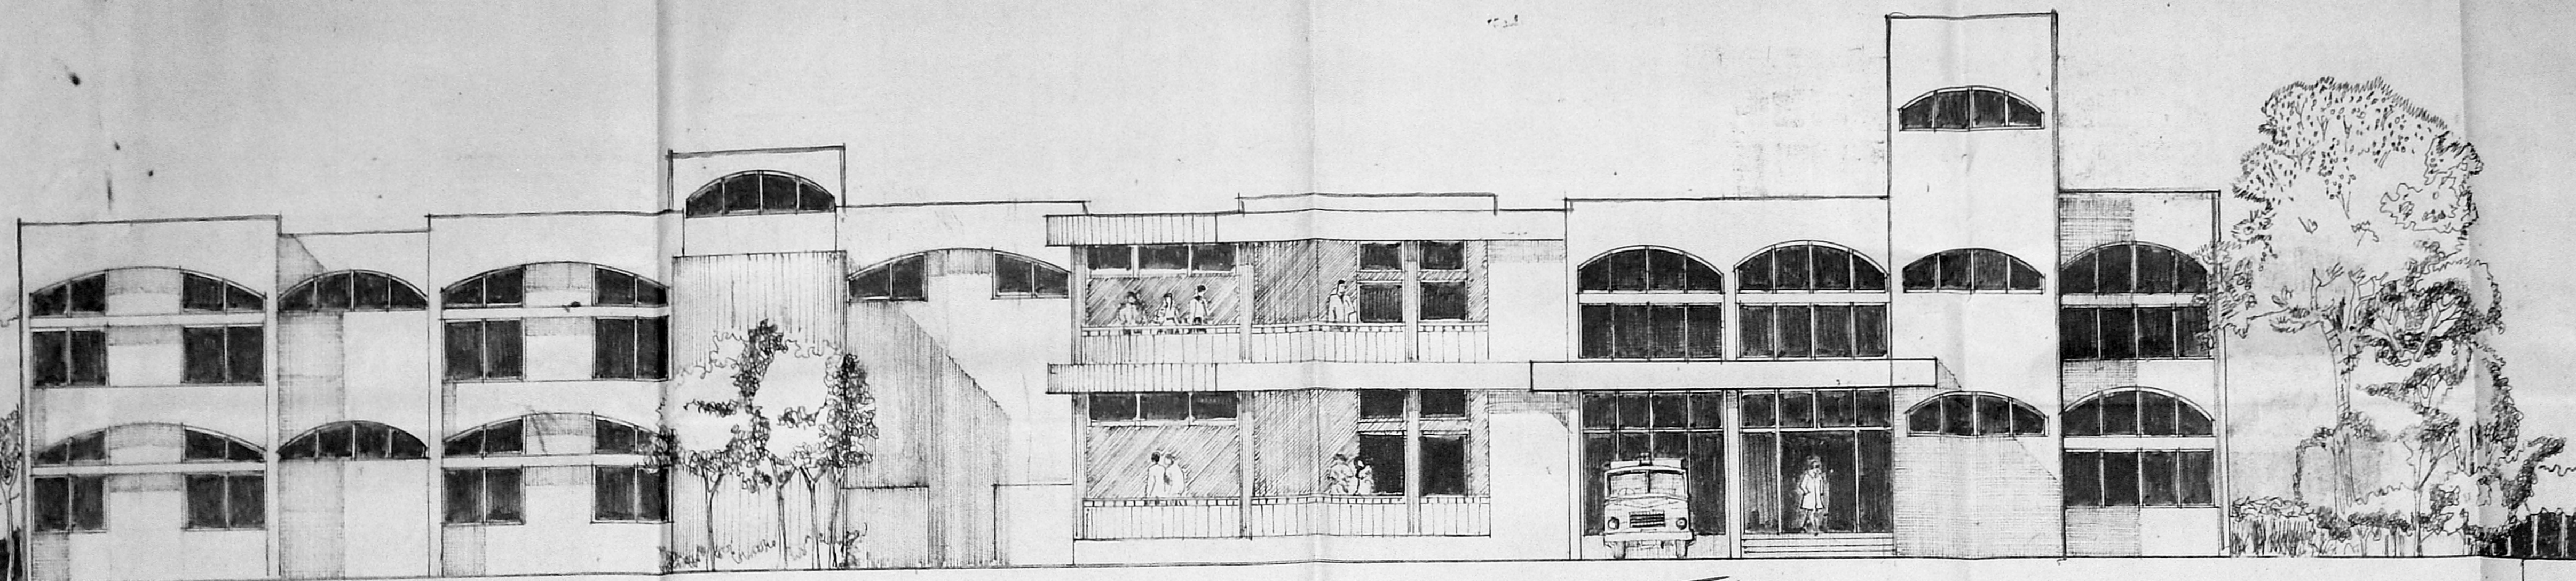

FRONT ELEVATION


Planning Permit No. C.P.P. 148 B/E 95
APPROVED
 SUBJECT TO THE CONDITIONS IN THIS OFFICE LETTER.
 No. C.P. 131 45 95 Date: 1.10.95
 FOR MEMBER SECRETARY
 MADRAS METROPOLITAN
 DEVELOPMENT AUTHORITY
 MADRAS - 600 008.

SCHEDULE OF JOINERY

| | | |
|-----------------|-------------------------------|-----------|
| d ₃ | two door with three shutter | 221 X 244 |
| d | " " single " | 100 X 244 |
| d ₂ | " " " " | 80 X 244 |
| sd | sliding door | 377 X 336 |
| sd ₁ | " " " | 183 X 244 |
| w | tw window with glazed shutter | 183 X 154 |
| w ₁ | " " " " | 122 X 154 |
| w ₂ | " " " " | 377 X 154 |
| v | tw. louvered ventilator | 377 X 91 |
| v ₁ | " " " " | 122 X 91 |
| v ₂ | " " " " | 152 X 91 |


REFERENCE

- proposed bldg. shown thus [Symbol]
- exig. road shown thus [Symbol]
- prop. sewer line shown thus [Symbol]
- prop. water line shown thus [Symbol]
- prop. boundary line [Symbol]
- exig. bldg. shown thus [Symbol]

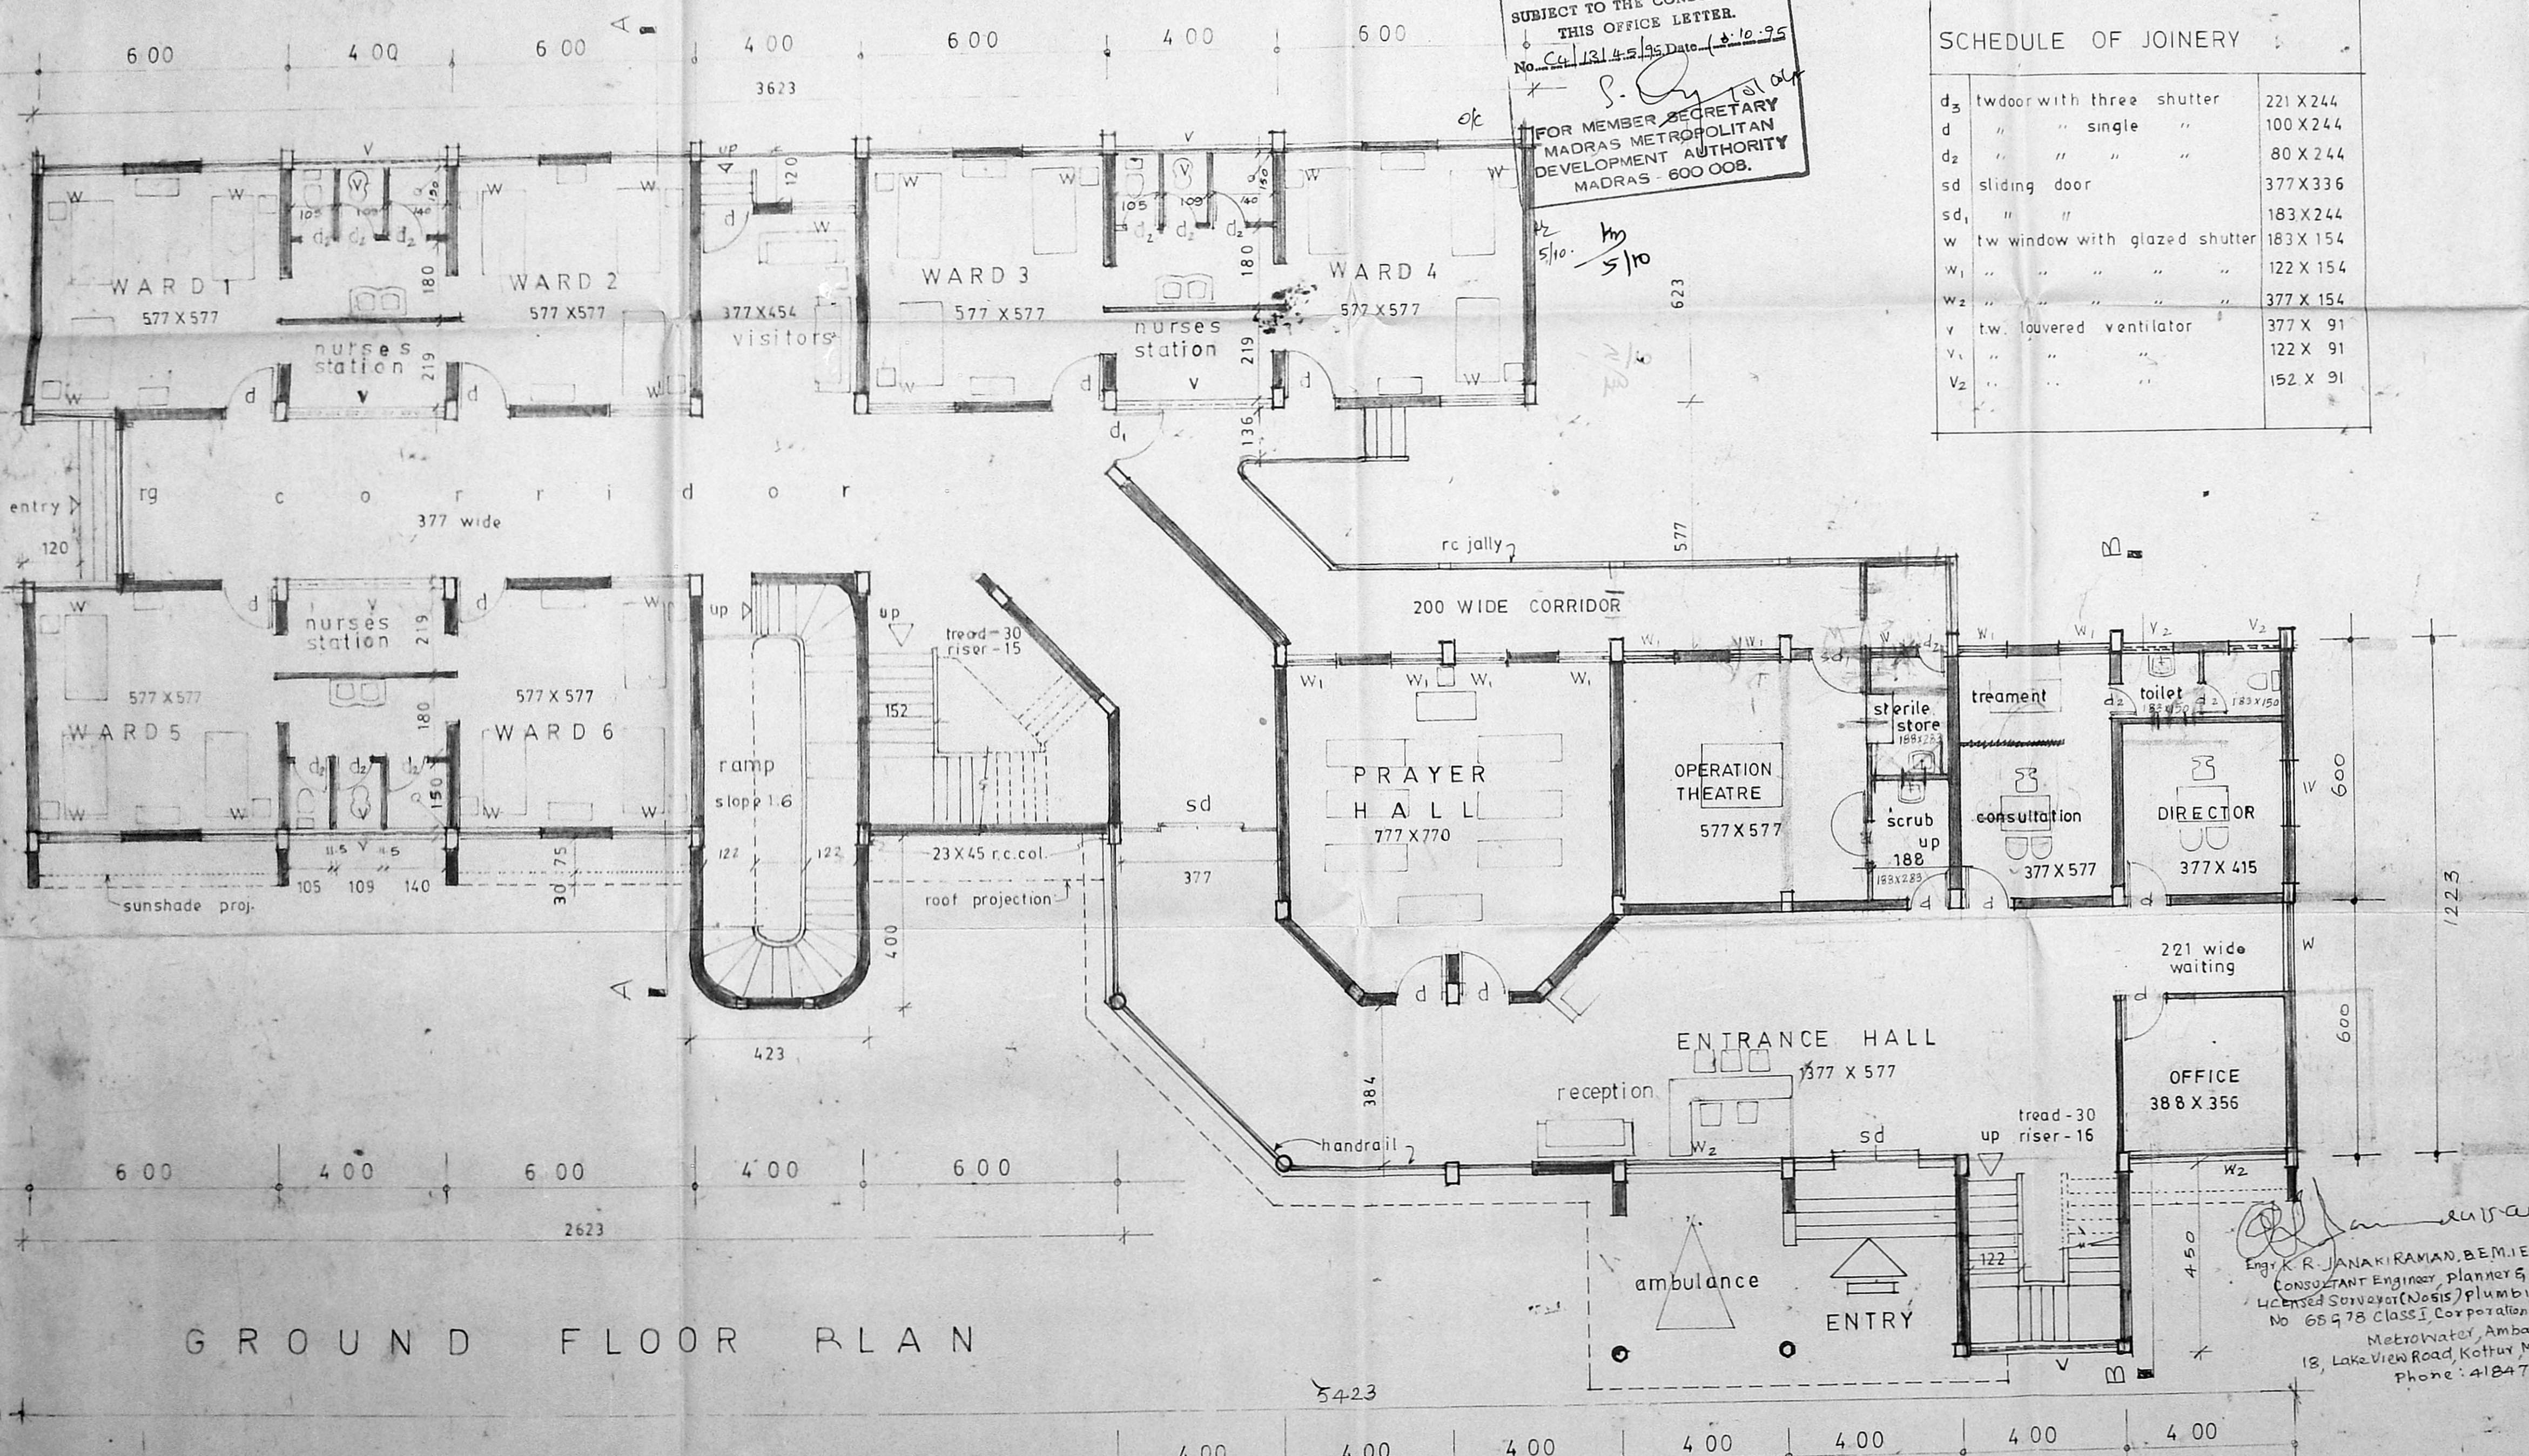

GROUND FLOOR PLAN

JEEVODHAYA
 HOSPITAL FOR MEDICALLY
 TERMINATED PATIENTS AT
 R.S. NOS. 108/145B, 108/3E &
 108/1B AT MATHUR MADRAS

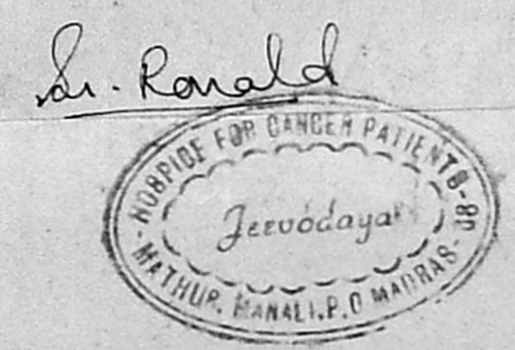

ALL DIMENSIONS IN CM
 SCALE 1:100

ARCHITECT

Engr. K. R. JANAKIRAMAN, B.E., M.P.
 CONSULTANT Engineer, Planner & Valuer
 LICENSED Surveyor (Nosis) Plumbing Lic. Engr.
 No. 65-78 CLASS I Corporation of Madras,
 Metrowater, Ambattur,
 18, Lake View Road, Kottur, Madras-85
 Phone: 4184791

GROUP CONSULTANCY
 SCHOOL OF ARCHITECTURE & PLANNING
 ANNA UNIVERSITY, MADRAS.

