


(REVISED)
 PLAN SHOWING THE
 PROPOSED CONSTRUCTION
 OF RESIDENTIAL BUILDING
 AT PLOT NO: 11, ELANGO
 ADIGAL STREET, PADMANBHA
 NAGAR, T.S. NO: 45 BLACK
 NO: 1, PULIYUR VILLAGE,
 MADRAS-99.

CORPORATION OF MADRAS

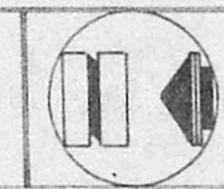

SCALE: 1:8'-0" (1:100)

AREA DETAILS

SITE EXTENT : 3600 SQFT 334.57 SQM
 GROUND FLOOR : 2128 SQFT 197.77 SQM
 FIRST FLOOR : 2128 SQFT 197.77 SQM
 TOTAL FLOOR : 4256 SQFT 395.54 SQM
 F.S.I. 120 PLOT COVERAGE 60%.

SCHEDULE OF JOINERY

R/S	ROLLING SHUTTER	9'-0" x 9'-0"
D	DOOR	3'-3" x 7'-0"
DI	DOOR	3'-0" x 7'-0"
D2	DOOR	2'-6" x 6'-6"
W	VINDOW	4'-0" x 4'-6"
WI	VINDOW	3'-6" x 4'-6"
V	VENTILATOR	3'-0" x 2'-0"
VI	VENTILATOR	2'-0" x 1'-6"


COLOUR INDEX

- PRO CONSTRUCTION
- EXISTING ROAD
- SITE BOUNDARY


OWNER (X. RAMALINGAM)

(Signature)
 Mr. K. VENUGOPAL Rtd. A.B.E.
 CORPORATION OF MADRAS
 Civil & Sanitary Engineering Consultant
 Licensed Surveyor Class-1 No: 320
 Licensed Plumber Class-1 Metro Water
 Saurange No. ... Water Supply No. ...
 3-Neelakandan St. Nungambakka (Chokke Area)
 Backdoor, cup water, etc. for see. Saurang
 MADRAS-600034.


LICENCED SURVEYOR

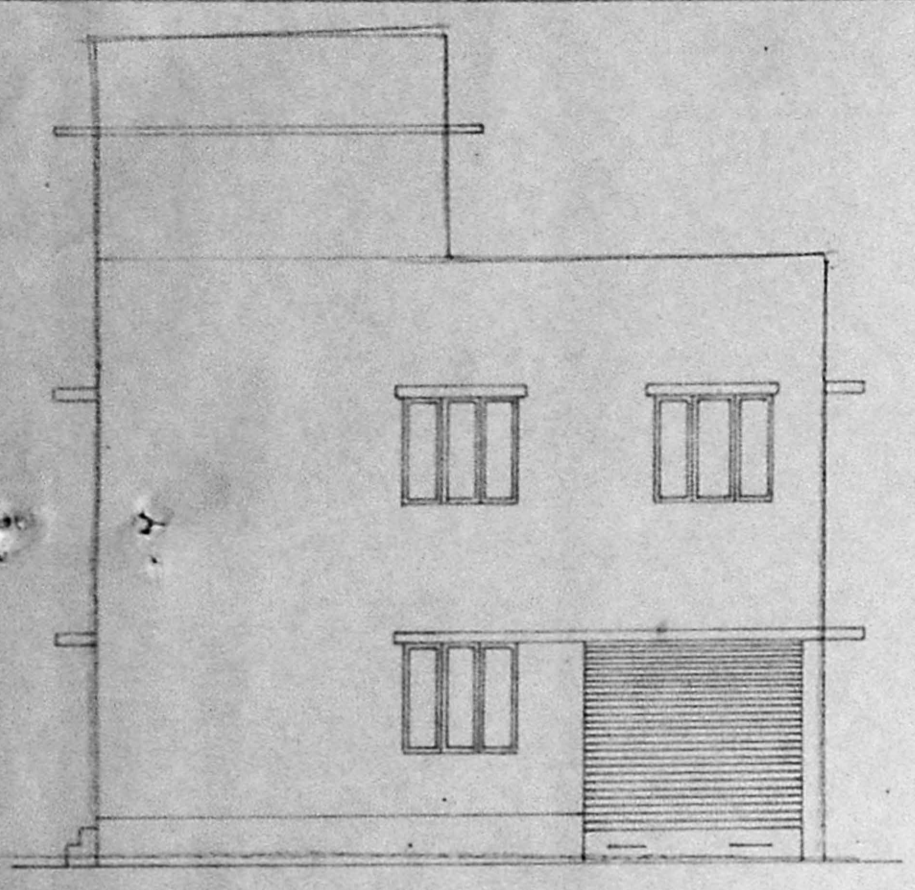


FRONT ELEVATION

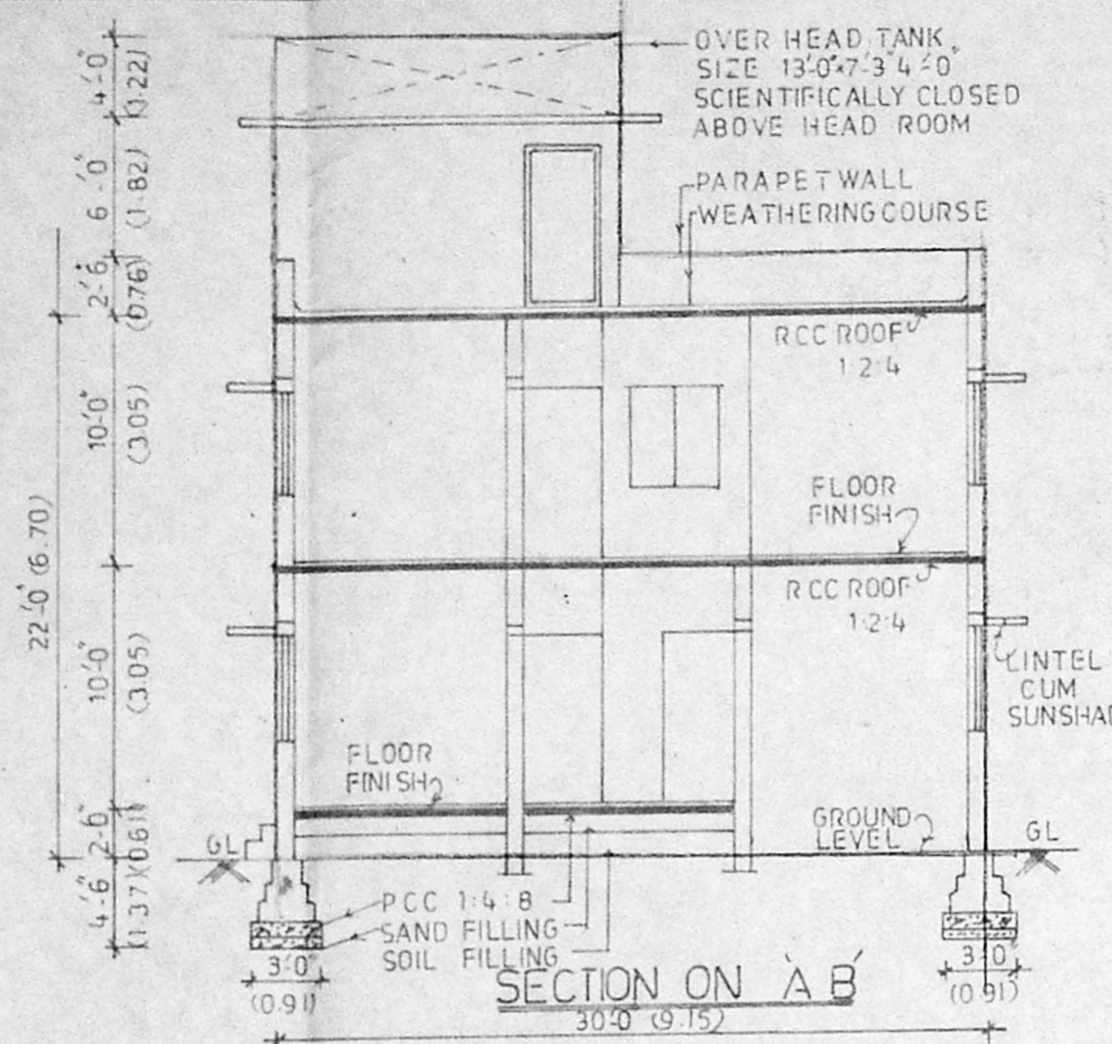

SECTION ON A-B

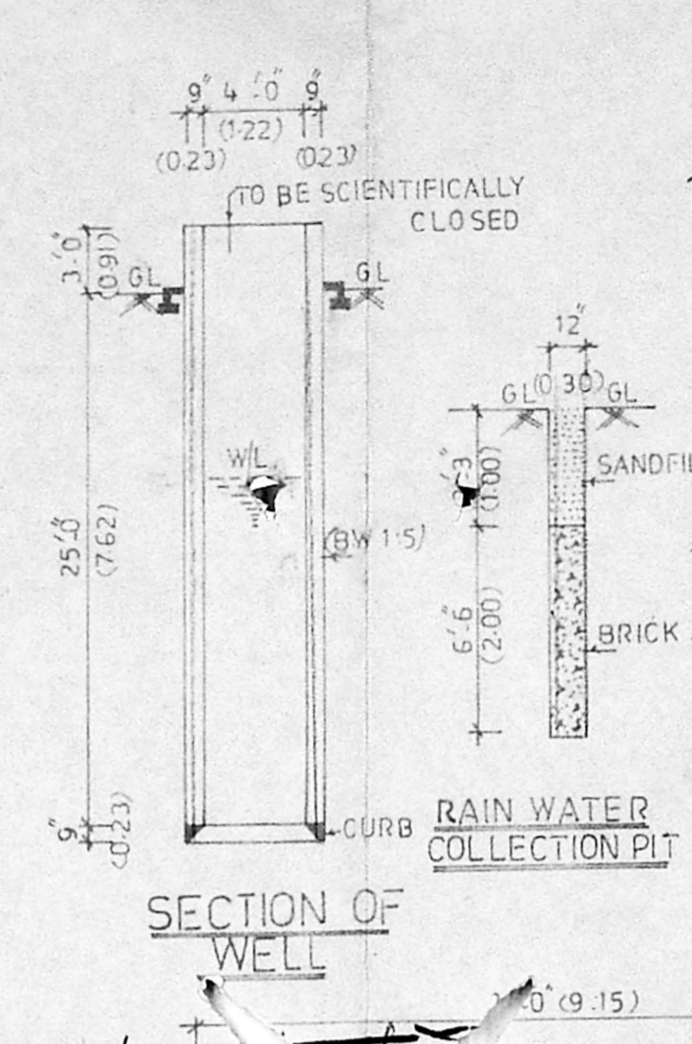


SECTION OF WELL

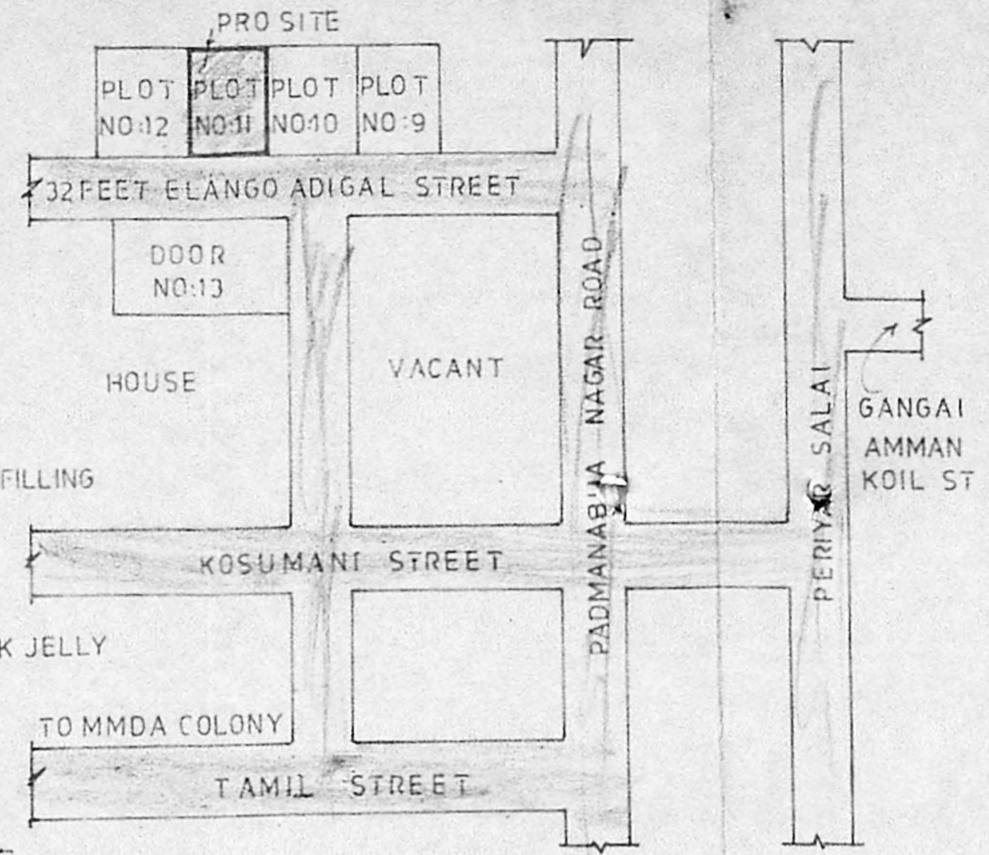


KEY PLAN
(NOT TO SCALE)


A/20536/22/96
 Planning/Permit No. ...
APPROVED
 SUBJECT TO THE CONDITIONS IN
 THIS OFFICE LETTER.
 No. A/12581/96 ... 21-8-96
(Signature)
 FOR MEMBER SECRETARY
 MADRAS METROPOLITAN
 DEVELOPMENT AUTHORITY
 MADRAS - 600 008.

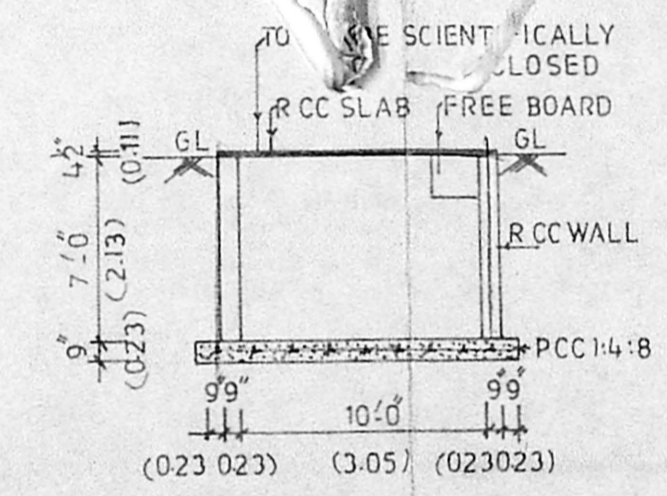


SECTION OF SUMP

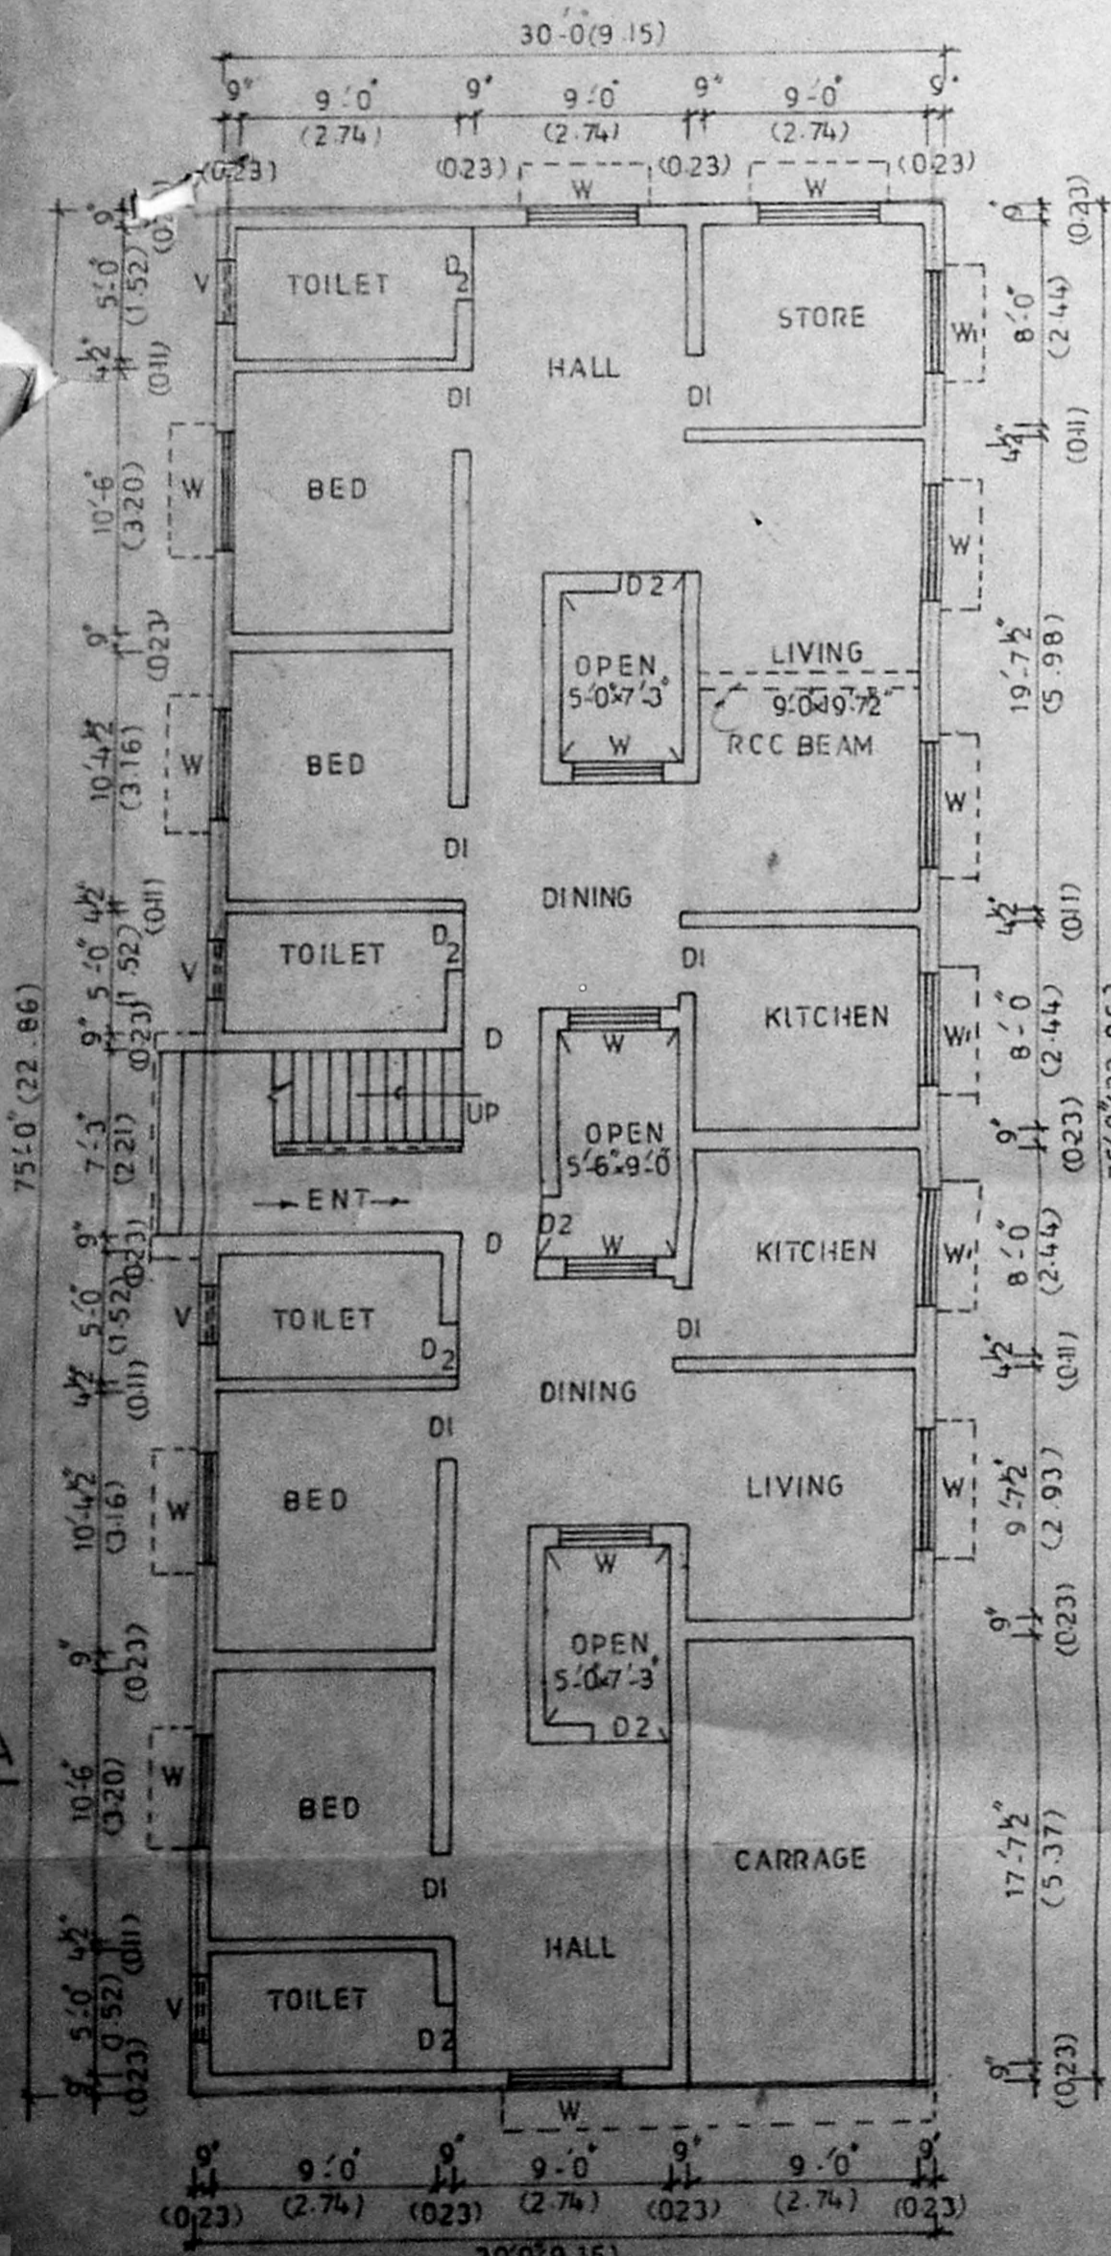


GROUND FLOOR PLAN

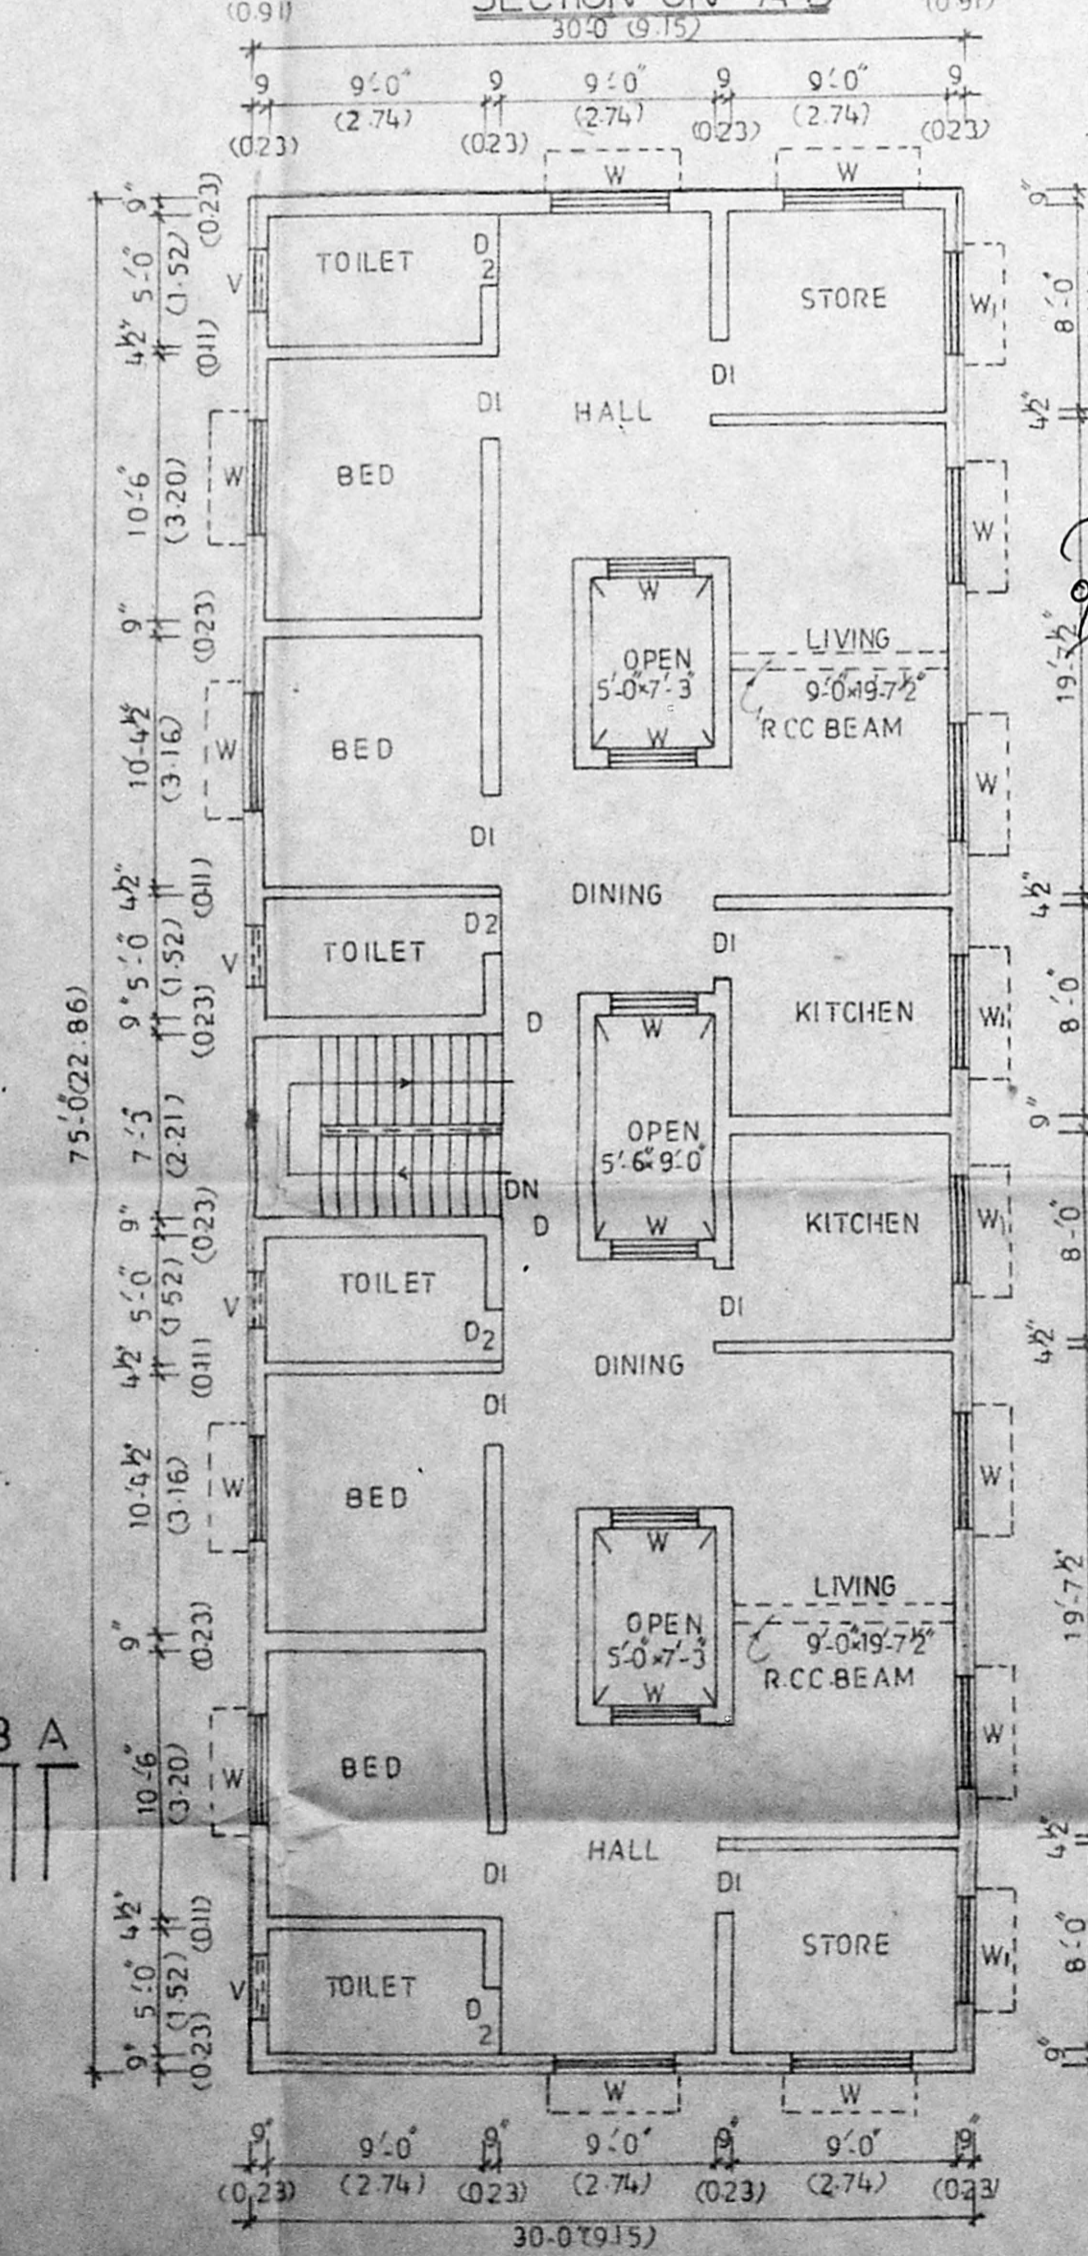

FIRST FLOOR PLAN

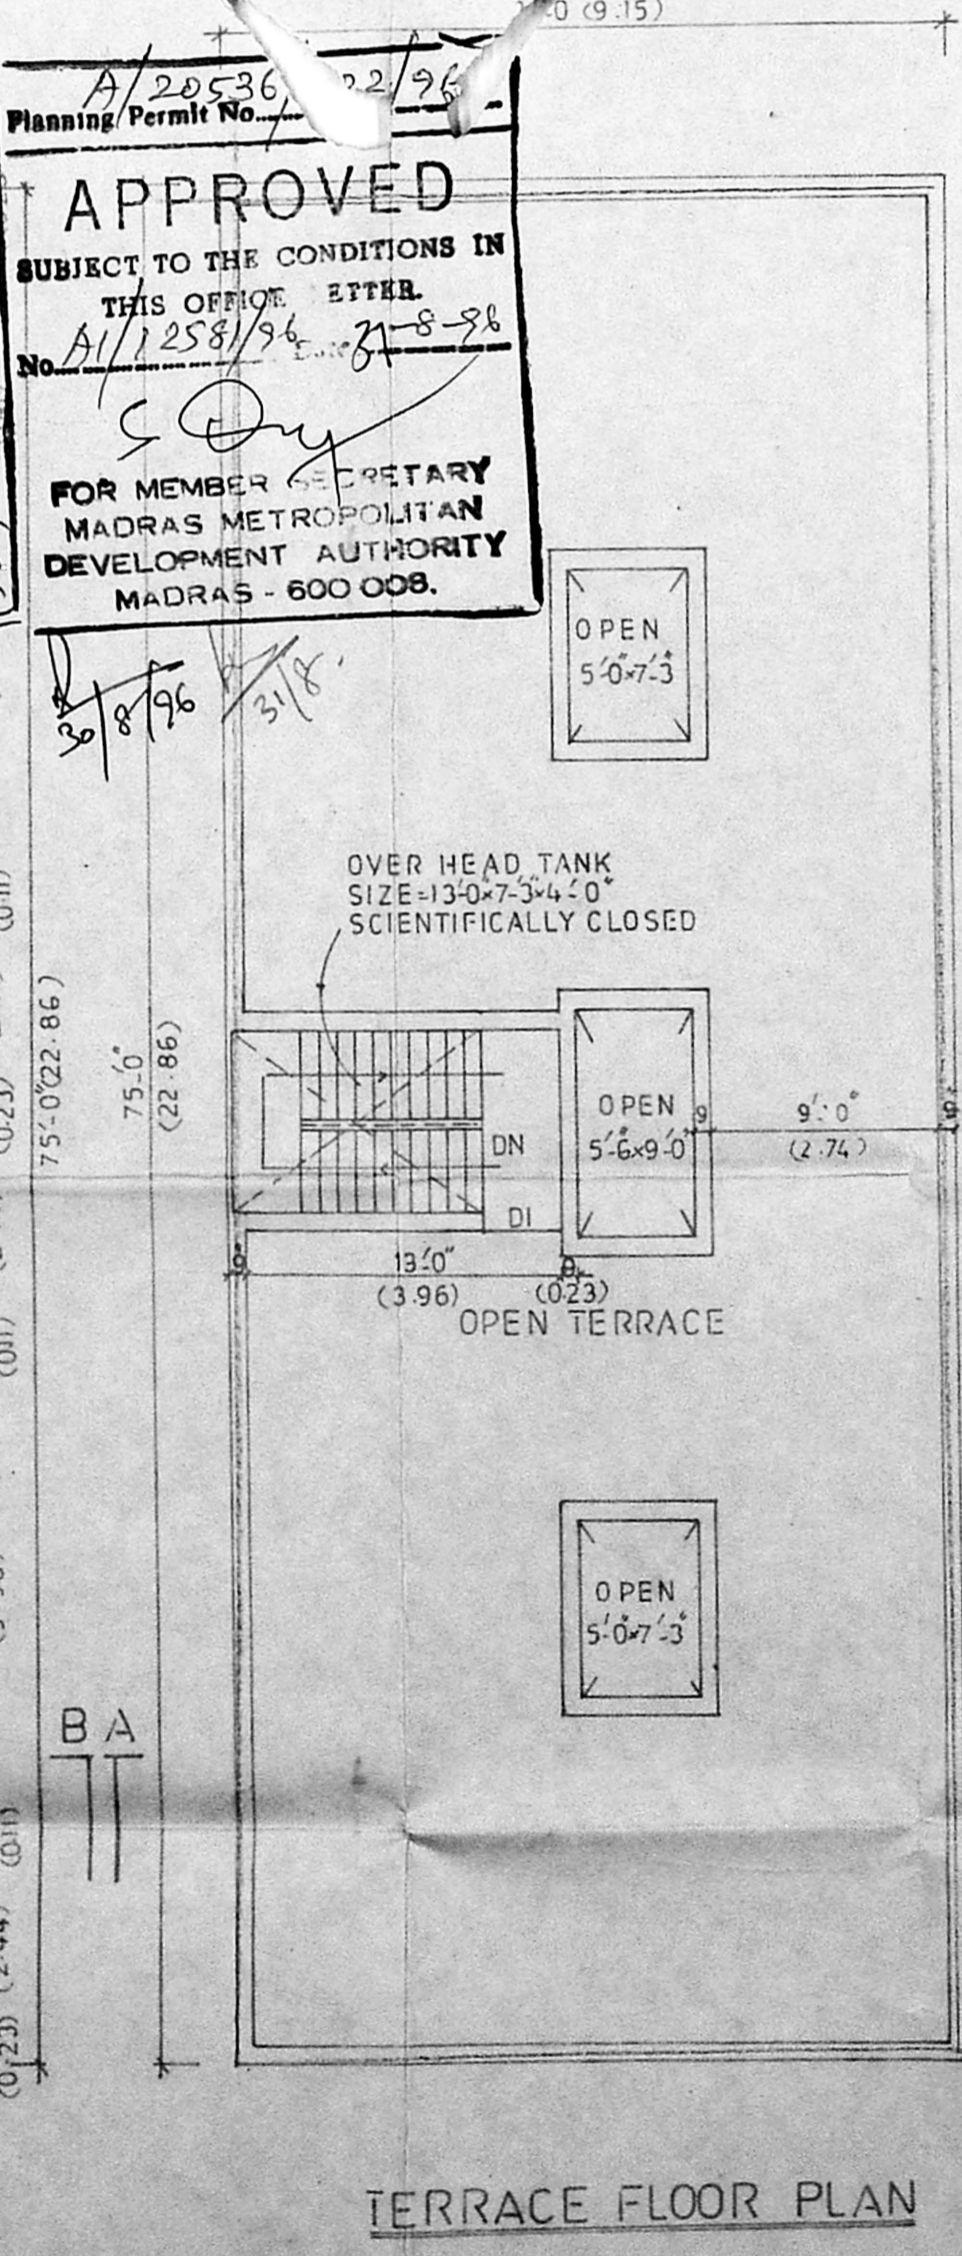

TERRACE FLOOR PLAN

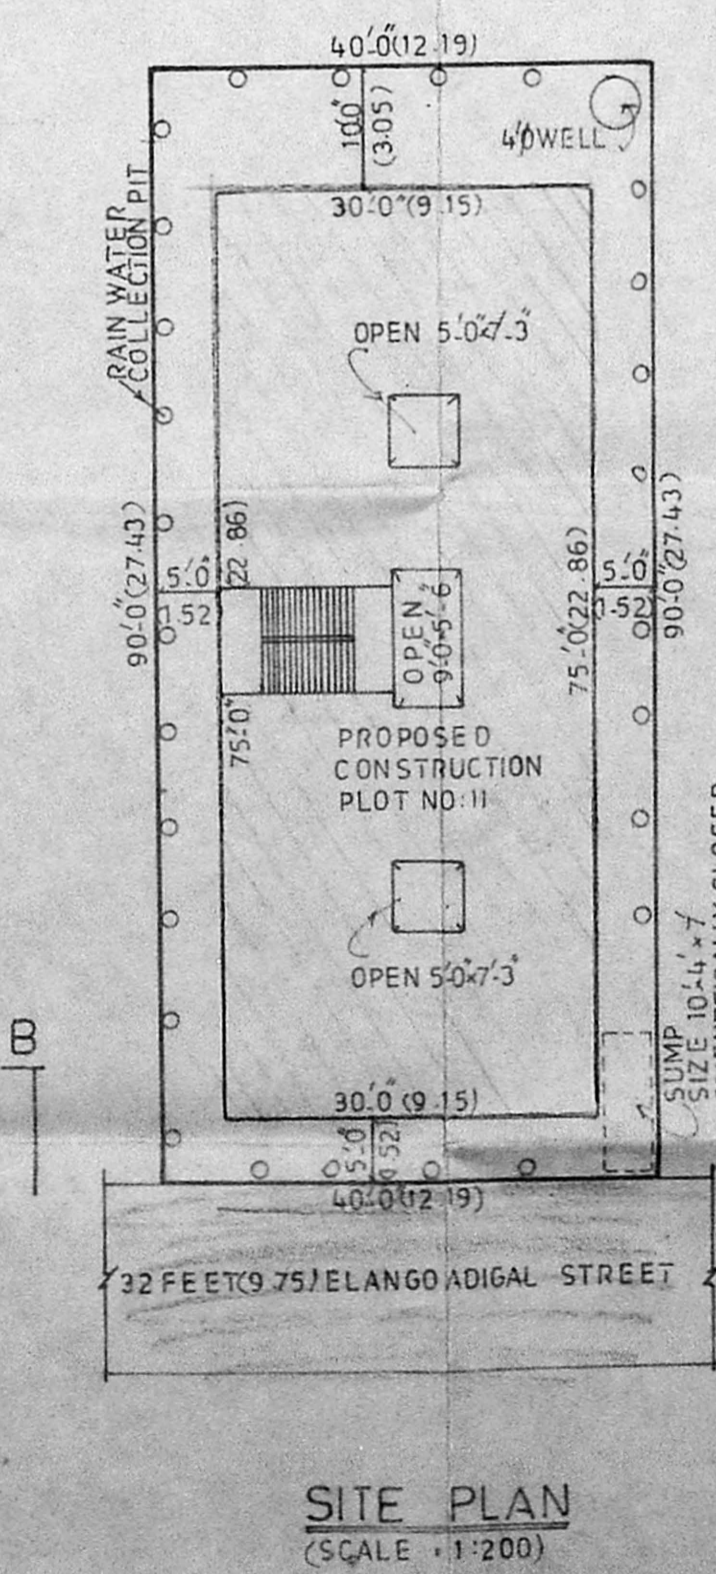

SITE PLAN
(SCALE: 1:200)