



PLOT No: 9A

- SPECIFICATION**
- 1 ALL WALLS ARE LOAD BEARING WALLS
 - 2 BRICK WORK IN CM 15 ARE IN UPPER STRUCTURE AND BRICK IN CM 15 ARE IN FOUNDATION
 - 3 R.C.C. 1:2:4 MIX USING 20MM METAL FOR LINTEL SUNSHADE LOFT AND ROOF SLAB, PLINTH BEAM, COL.
 - 4 PLASTERING IN CM 1:4 FOR WALL ON BOTH SIDES
 - 5 PLASTERING IN CM 1:3 FOR CEILING LOFT & SUNSHADE
 - 6 ALL THE DOORS ARE T.W. FRAME WITH FLUSH SHUTTERS
 - 7 WINDOWS ARE IN STEELCASEMENT AND GLASS SHUTTERS
 - 8 VENTILATORS ARE IN GLASS LOUVERS
 - 9 PAINTING CEMENT PRIME FOR WALLS INTERNAL EXTER
 - 10 PAINTING ENAMEL PAINT FOR JOINERY & STEEL WINDOW
 - 11 FLOOR FINISHING WITH GRAY MOSAIC TILES W/SKIRTING
 - 12 R.C.C. 1:4:8 USING 40 MM METAL FOR FLOORING CONSOLIDATING AND RAMMING WELL
 - 13 RIVER SAND FILLING BELOW R.C.C. CONSOLIDATING WITH WATER AND RAMMING WELL
 - 14 WEATHER PROOFING COURSE AS PER A.D.S.S.
 - 15 TOILET FLOORING AND DADO IN CERAMIC TILES

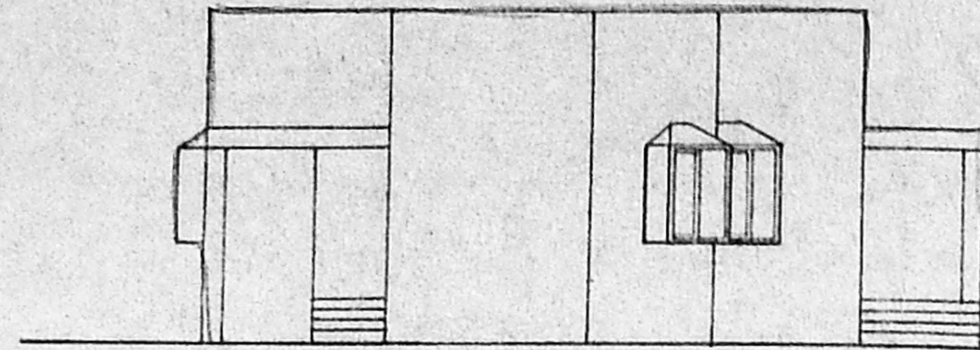

FRONT ELEVATION

PARAPET WALL 0.23THK
 WEATHERING COURSE
 10mm THK RCC ROOF SLAB
 LINTEL CUM SUNSHADE
 0.23 THK. BRICK WALL

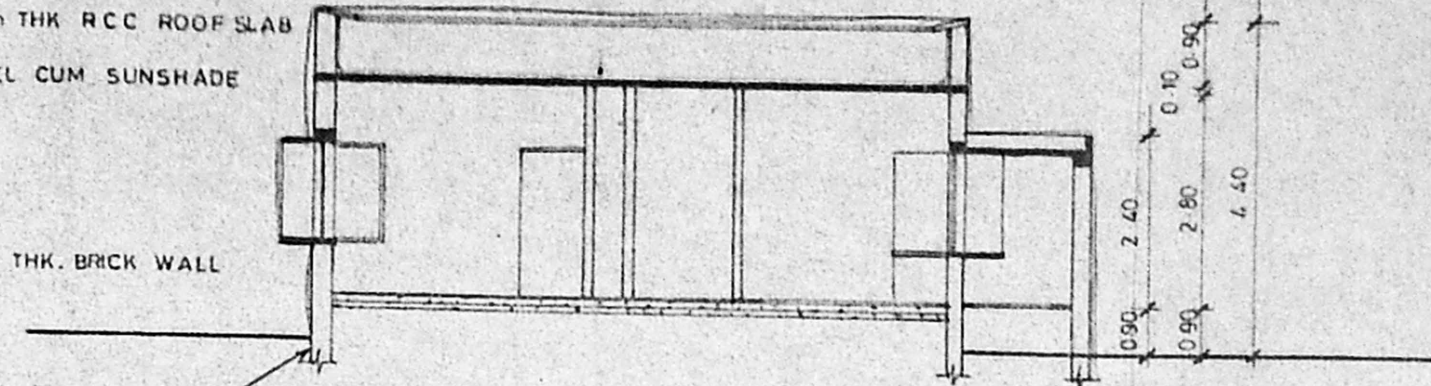

REFER THE FOUNDATION DETAIL

SECTION B-B

A/24055/640/96
 Planning Permit No.
APPROVED
 SUBJECT TO THE CONDITIONS IN THIS OFFICE LETTER.
 No. A/25343/96 Date 21.12.96
 FOR MEMBERS SECRETARY
 SINTOX TANK 200 LITERS
 MADRAS METROPOLITAN DEVELOPMENT AUTHORITY
 MADRAS - 600 008.

SCHEDULE OF JOINERY

SL NO	DESCRIPTION	SIZE IN M
D	T.W. FRAME FLUSH SHUTTERS	1.20 x 2.10
D1	DO	1.05 x 2.10
D2	DO	0.90 x 2.10
D3	DO	0.75 x 2.10
W	STEEL CASEMENT WITH GLASS SHUTTERS	1.60 x 1.35
W1	DO	1.20 x 1.35
W2	DO	0.90 x 1.35
W3	DO	0.90 x 1.20
V	VENTILATOR	0.90 x 0.60
V1	DO	0.50 x 0.50

AREA STATEMENT

PLOT AREA : 12.6 x 15.45 = 195.30 Sq. m

	SQ. M	SQ. FT.
HOUSE AREA	73.5	790.74
PORCH AREA	5.92	63.69
TOTAL	79.42	854.43

ALL DIMENSIONS ARE IN METERS

COLOUR INDEX


PROPOSED BOUNDARY

R.C.A.D. SEWER LINE


WATER LINE

PROPOSED PLAN OF AIRMEN SAILORS HOUSING AT MADAMBAKKAM VILLAGE IN SAIDAPET TALUK CHENGAI M.G.R. DISTRICT IN S.No. 764/192

DRN BY: SM Divakar DATE: 6-8-96
 SCALE: 1:100
 OWNER:
 (NHS Manian)
 Commander
 Project Director
 D.G. AFNH, NEW DELHI
 ARCHITECT

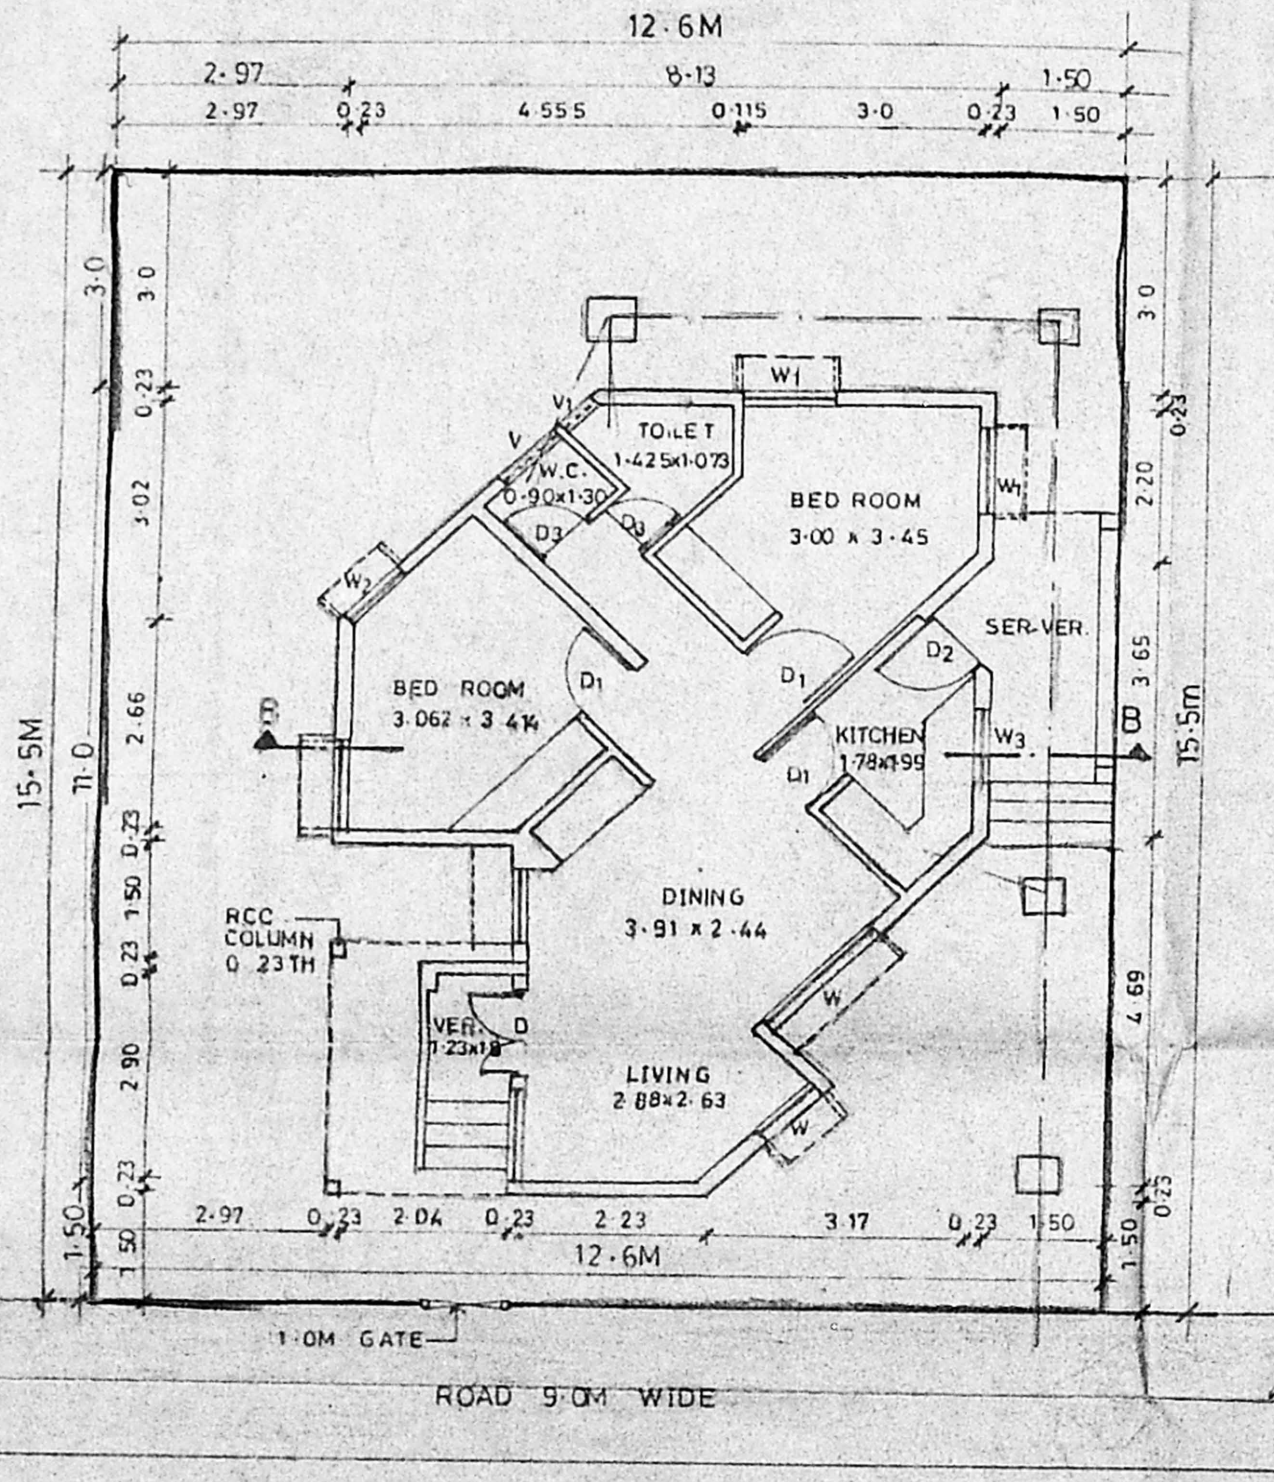

GROUND FLOOR PLAN

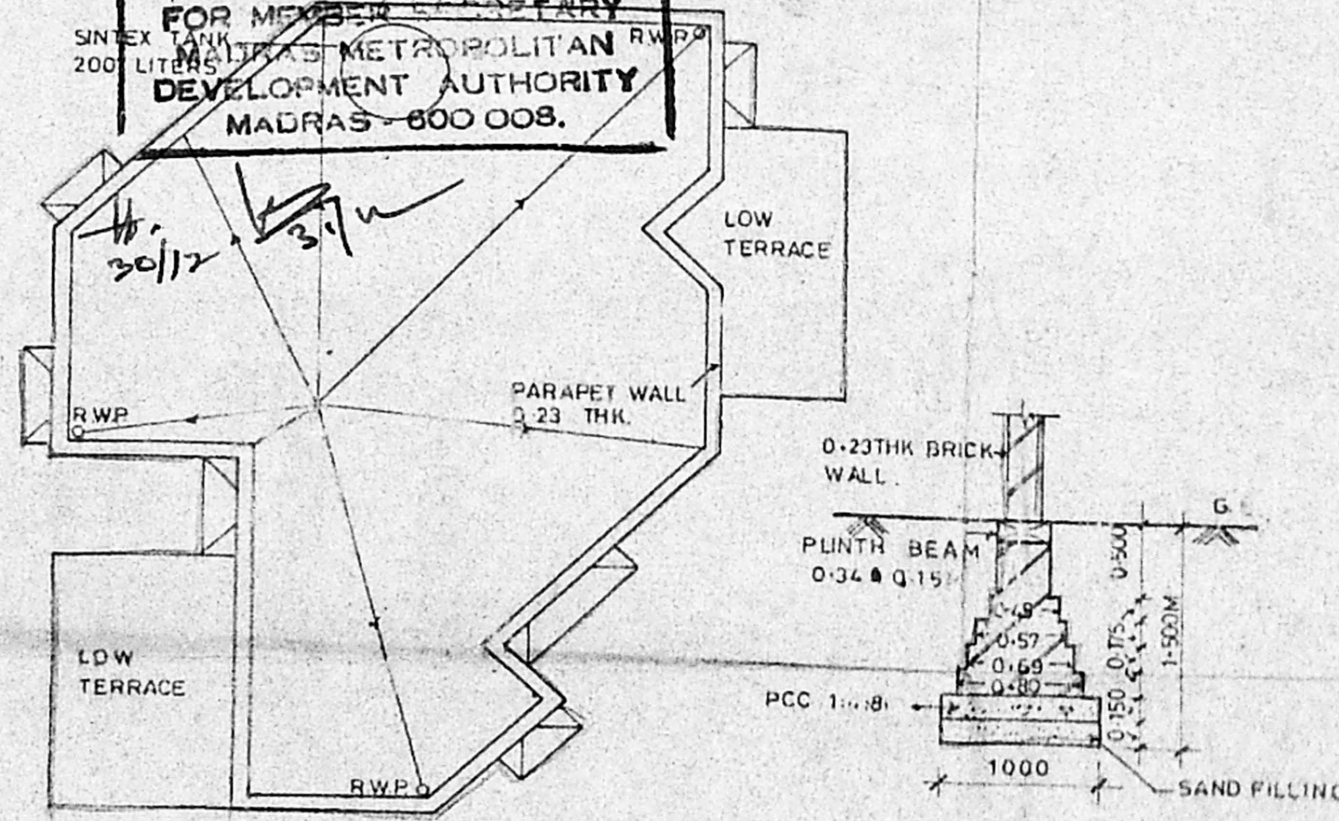

TERRACE PLAN