

PROPOSED BUILDING FOR HIGHER SECONDARY SCHOOL AT S.NO: 404/2A, B9C, 413/1 TO 7, 414/1, 415/VILLAGE NO: 78, POONTHANDALAM DHARWAST, SRIPERUMPUDY TALUK, CHENGAI M.G.R. DISTRICT, MADRAS 44.

ok R. Plans
5/1/95
Site plan

AREA STATEMENT		
LAND AREA	SQ. FT	SQ. M
1. LAND AREA	104,298.28	96,997.91
BLOCK A		
GROUND FLOOR	18,853	1754
FIRST FLOOR	19,178	1784
SECOND FLOOR	19,502	1814
BLOCK B		
GROUND FLOOR	18,853	1754
FIRST FLOOR	19,178	1784
SECOND FLOOR	19,502	1814
BLOCK C		
GROUND FLOOR	18,853	1754
FIRST FLOOR	19,178	1784
SECOND FLOOR	19,502	1814
TOTAL BUILT UP AREA	1,72,599	16056
PLOT COVERAGE	5.79%	
F.S.I.	0.17	

APPLICANT:
K. Mahalingam

LICENSED BUILDING SURVEYOR:
W. S. Srinivasan

Dr. K. VENUGOPAL, B.E., A.M.I.E.
CORPORATION OF MADRAS
Civil & Sanitary Engineering Consultant
Licence Surveyor, Class-I No. 330
Licence Plumber, Class-I Metro Water
Sewerage No. Water Supply No.
8, Nallandam Street, Nungambakam (Lake Road)
Office of Corporation Bldg Higher Secondary School
MADRAS - 600 034

Block : A, B & C

SHEET NO : 7

SCALE 1:1000 DATE : 31.07.95







COLOUR CODE INDEX:

1. BOUNDARY	●
2. PROPOSAL	■
3. ROAD	○
4. SEWER LINE	—




DRAWN : K. PREMALATHA


NOTE:
ALL DIMENSIONS ARE IN METRE.

Architects
VIJAY ASSOCIATES,
17, Ramasamy St,
T. Nagar, MADRAS 17
PH 4345635

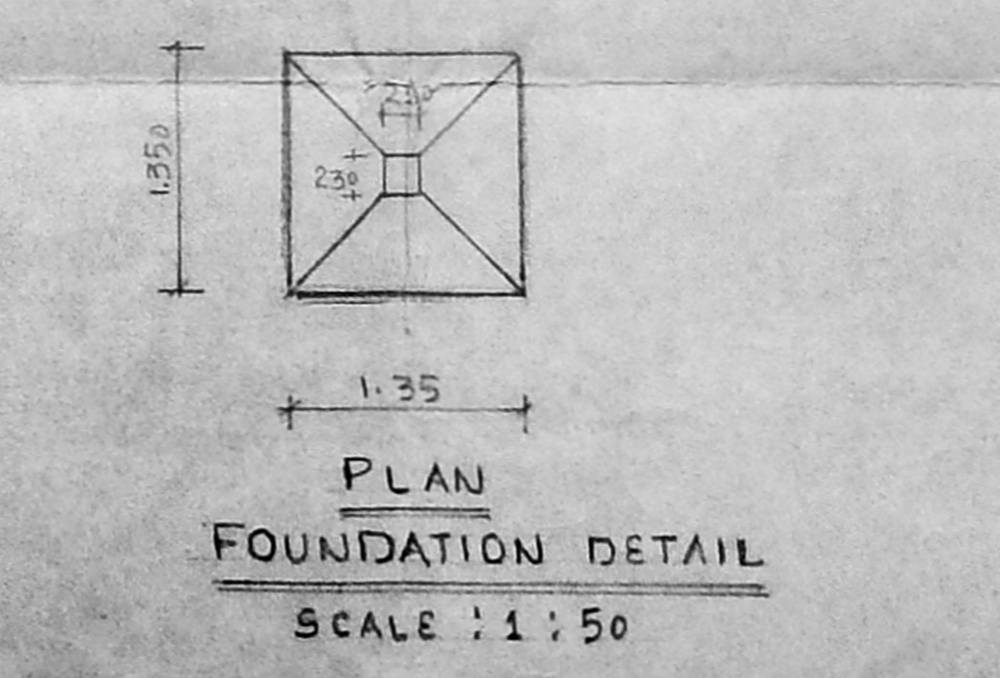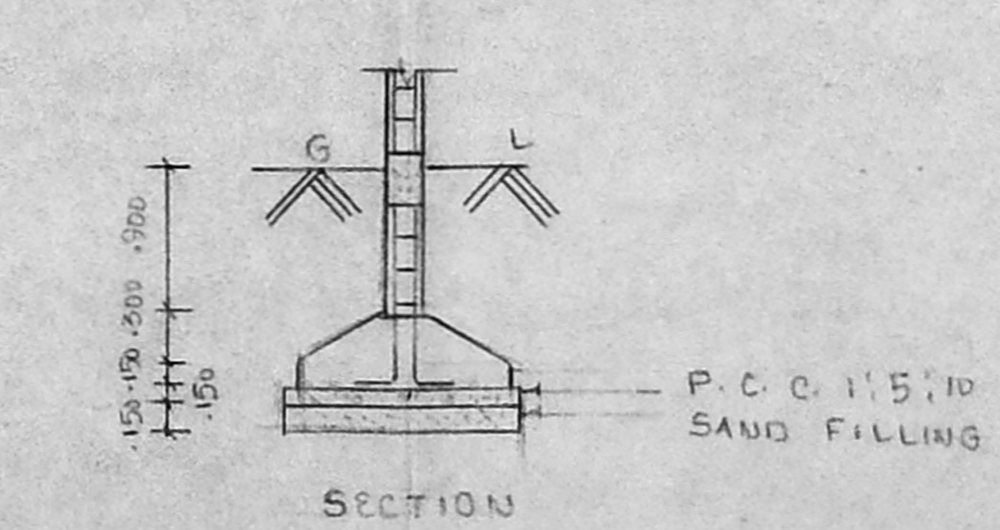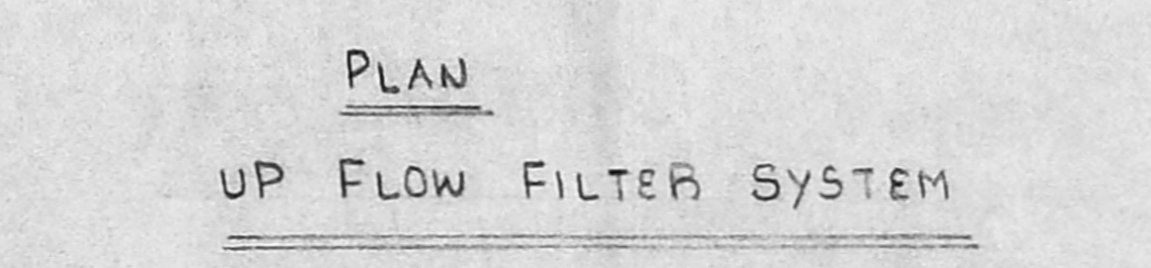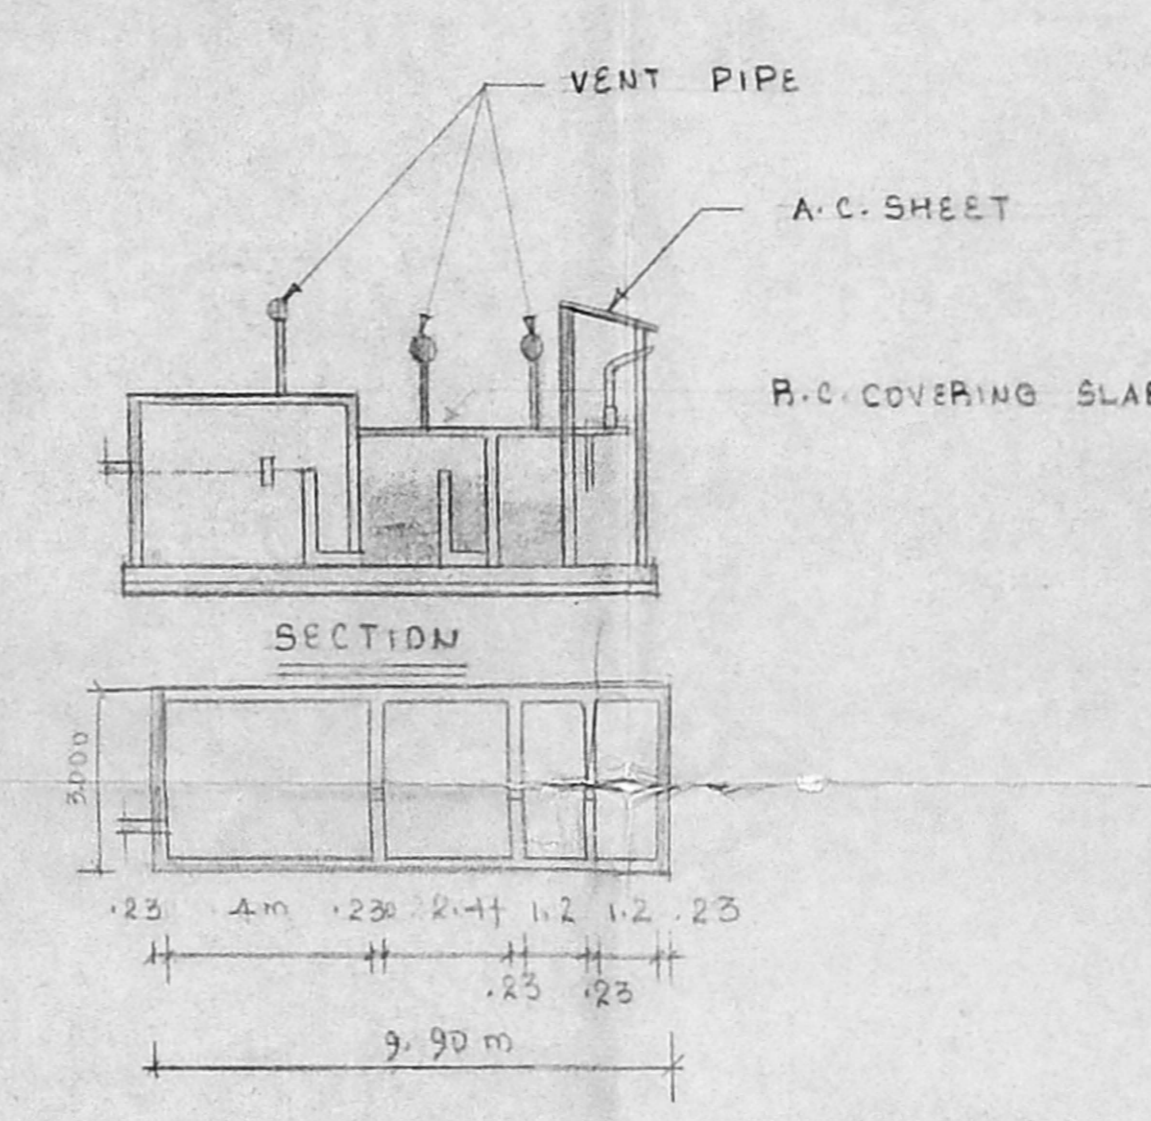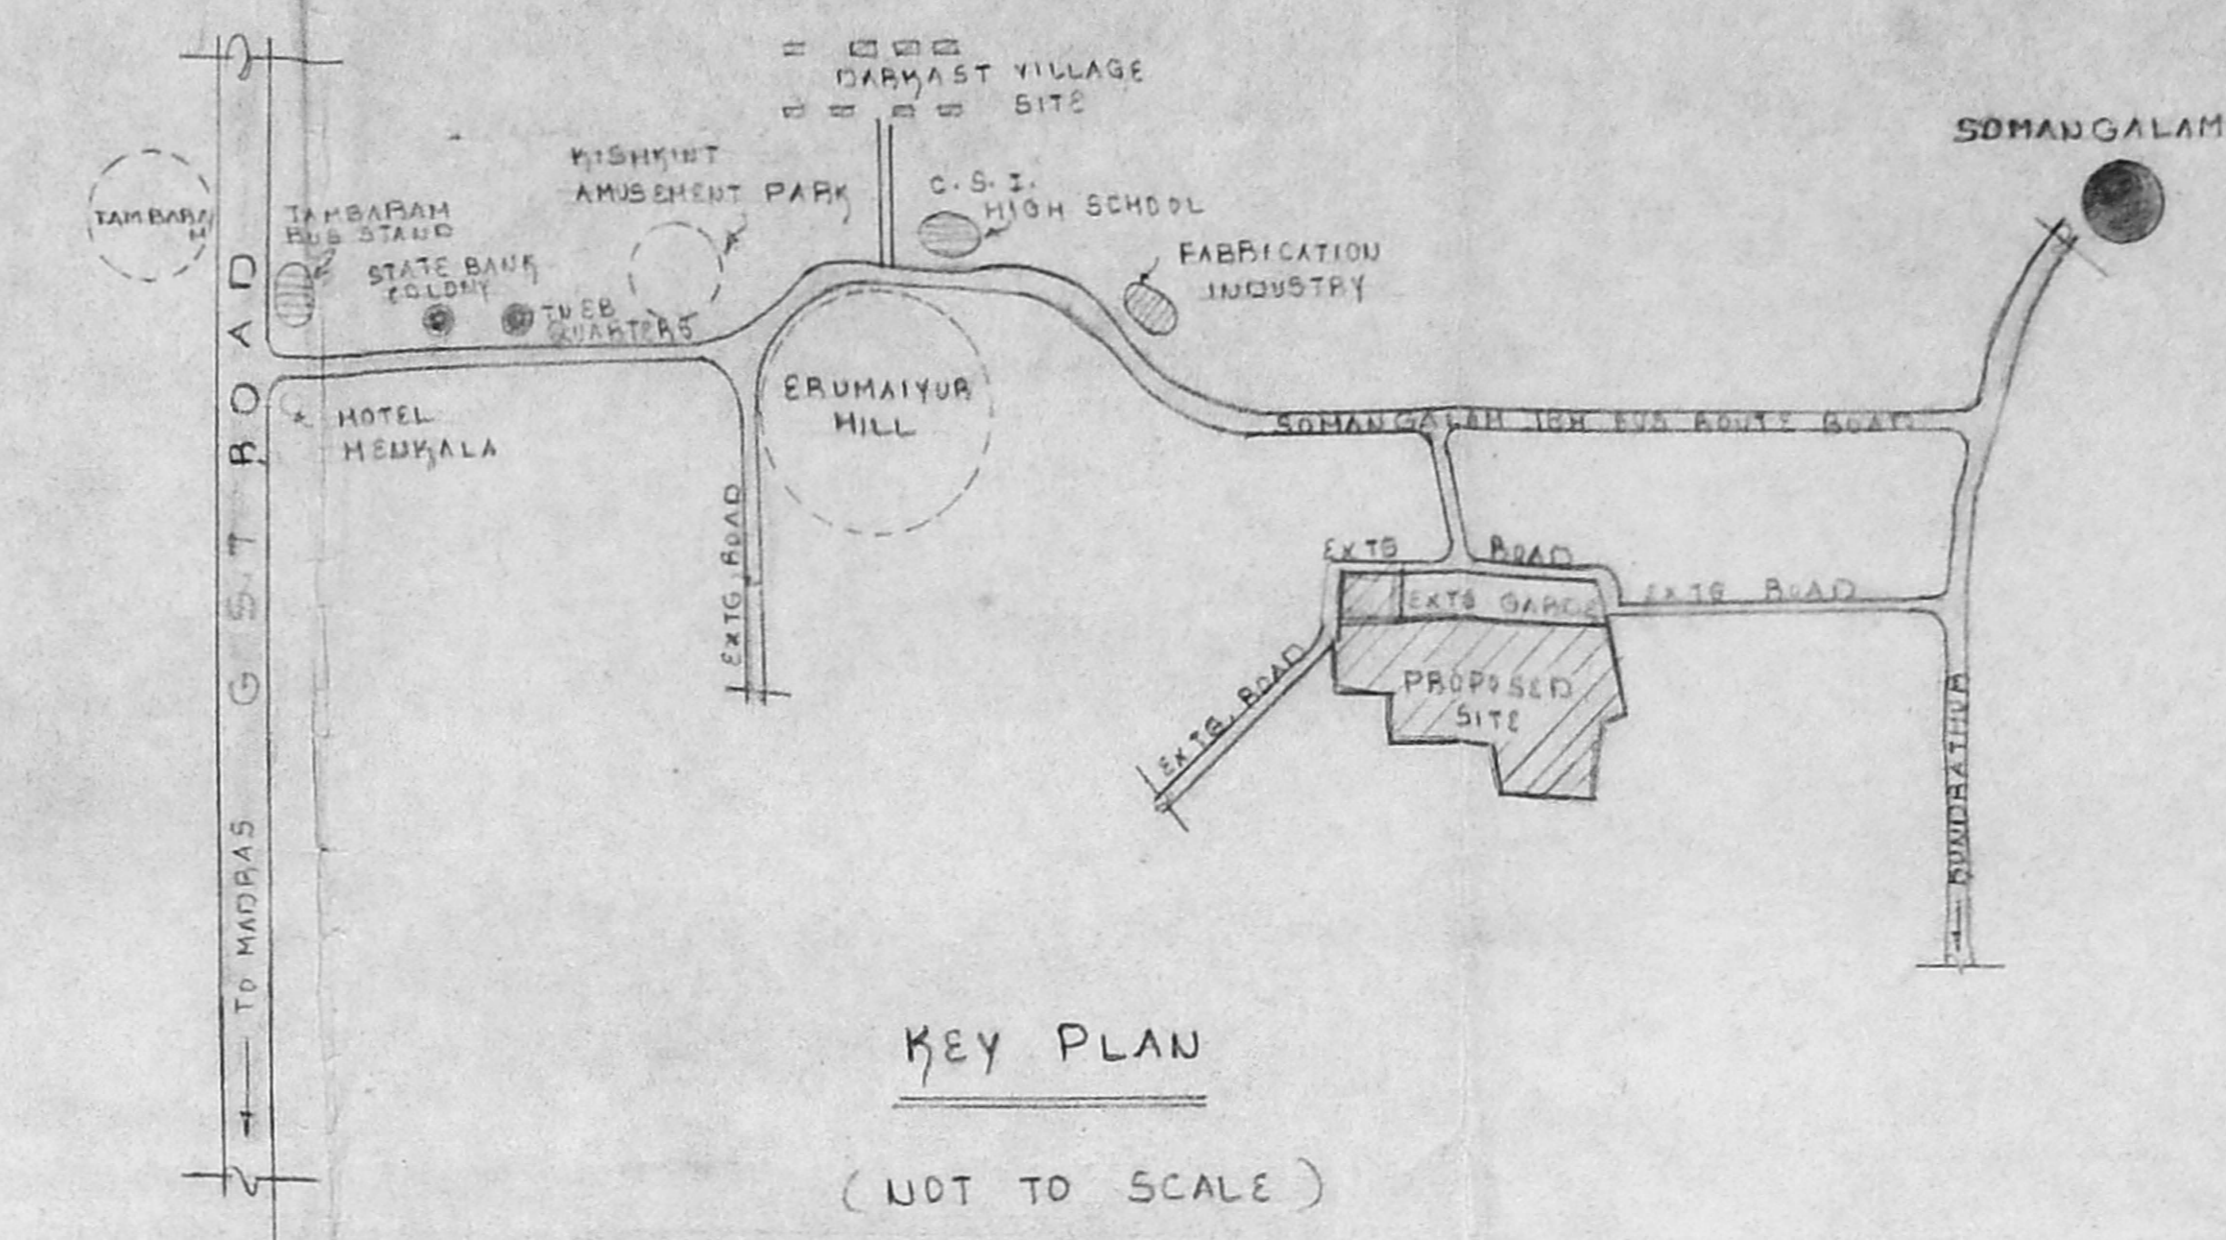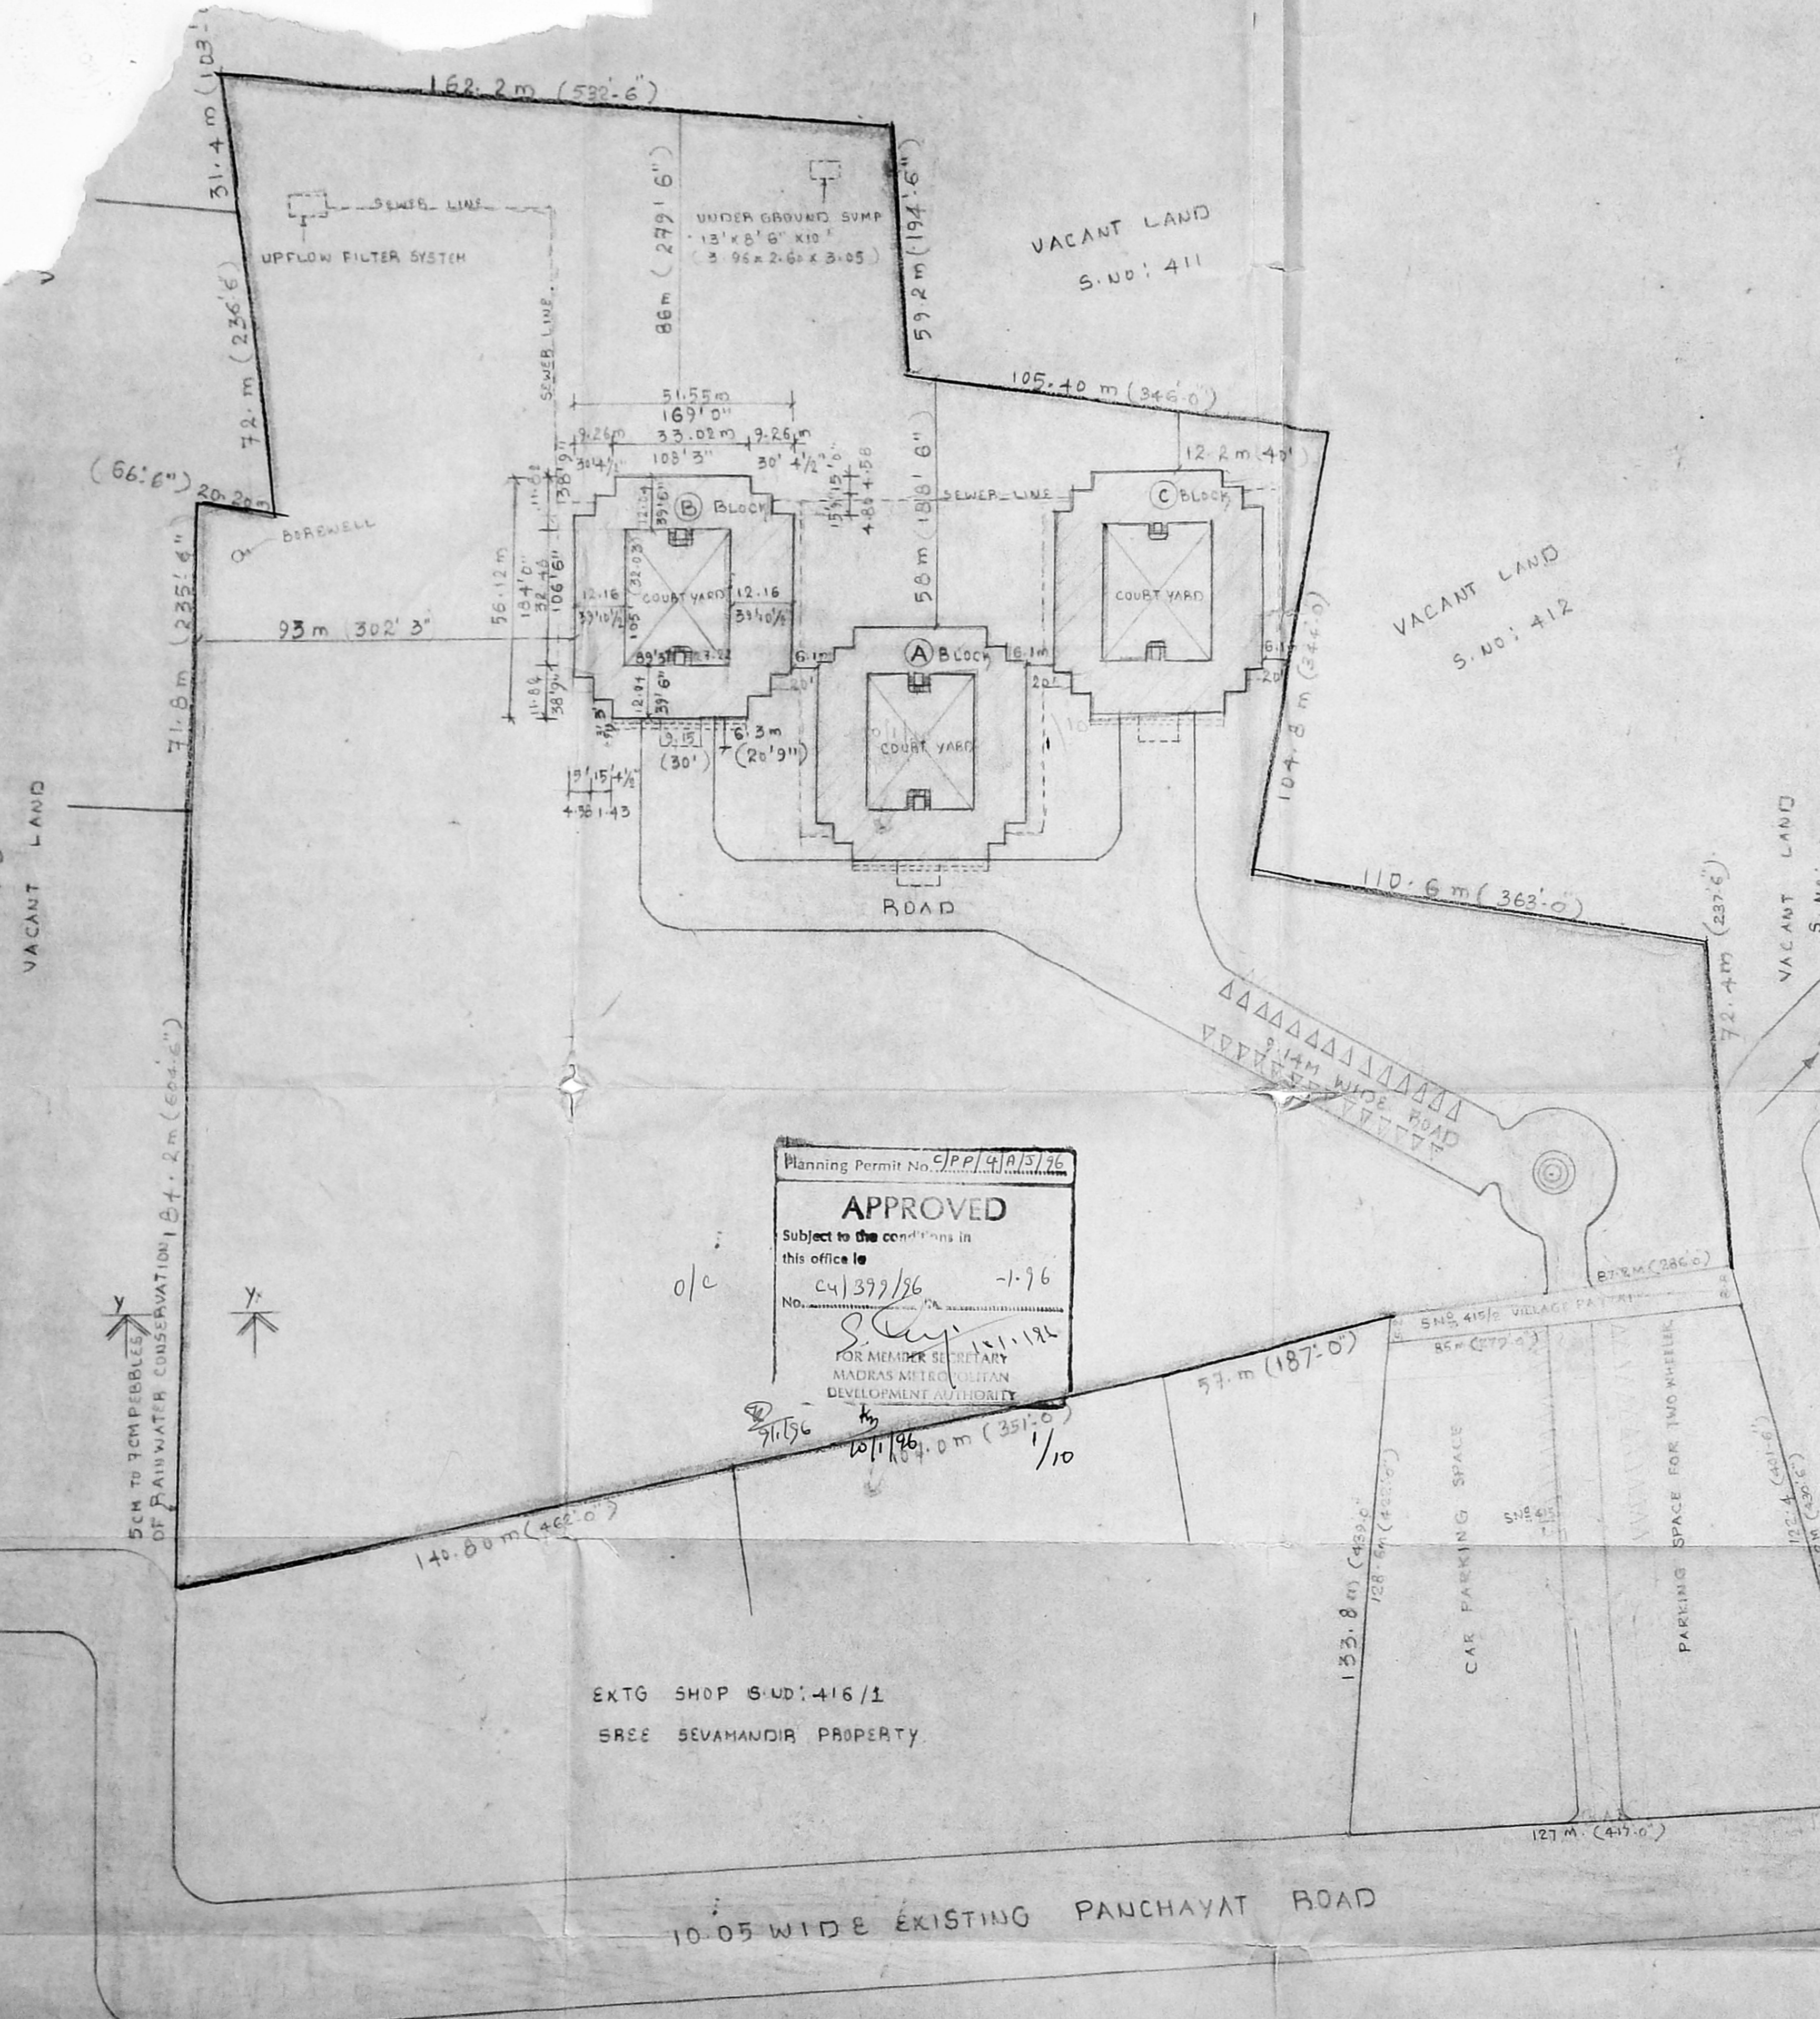

SITE PLAN
SCALE : 1:1000

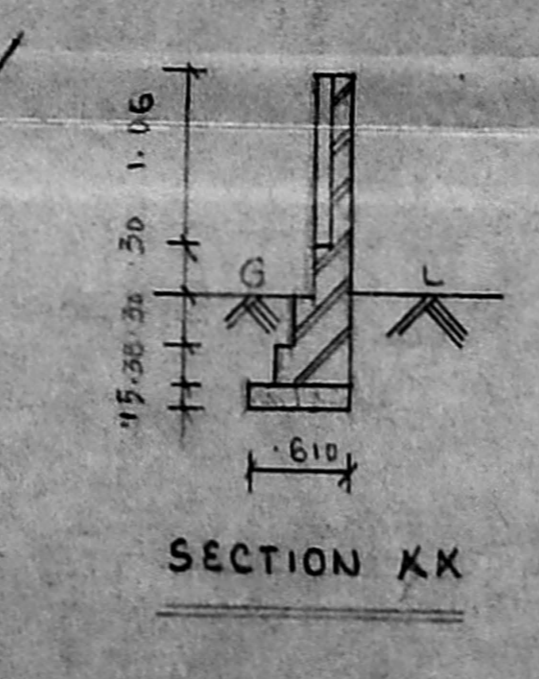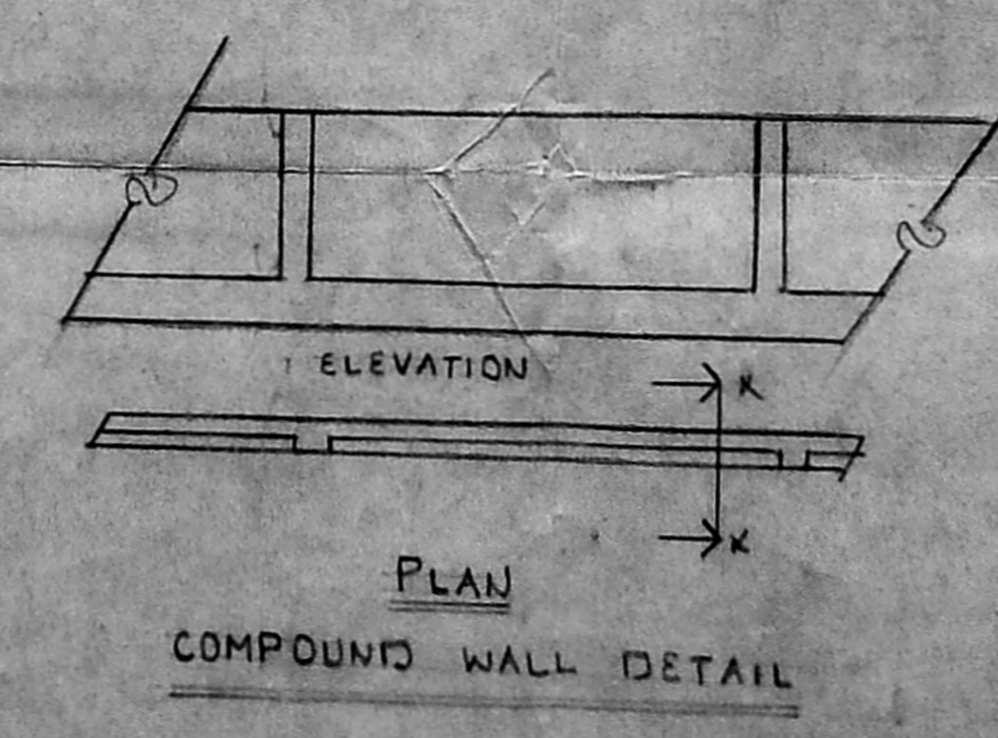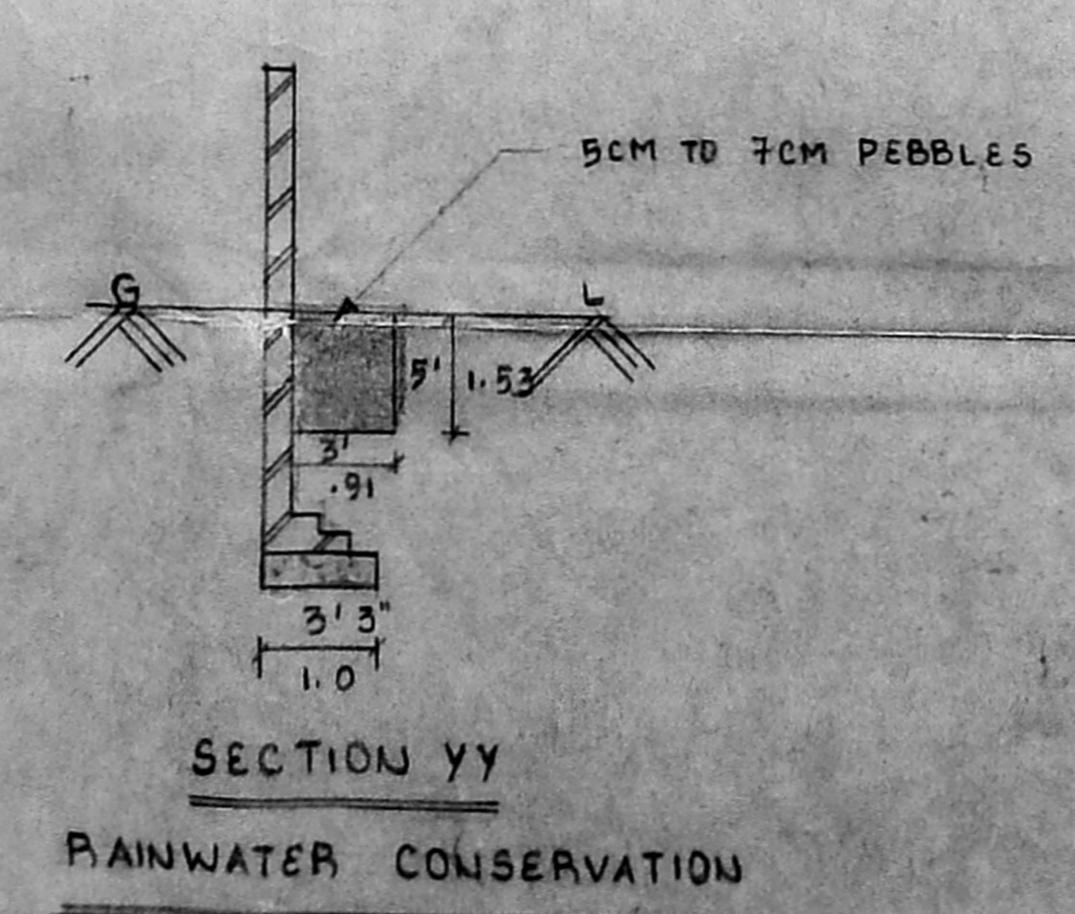

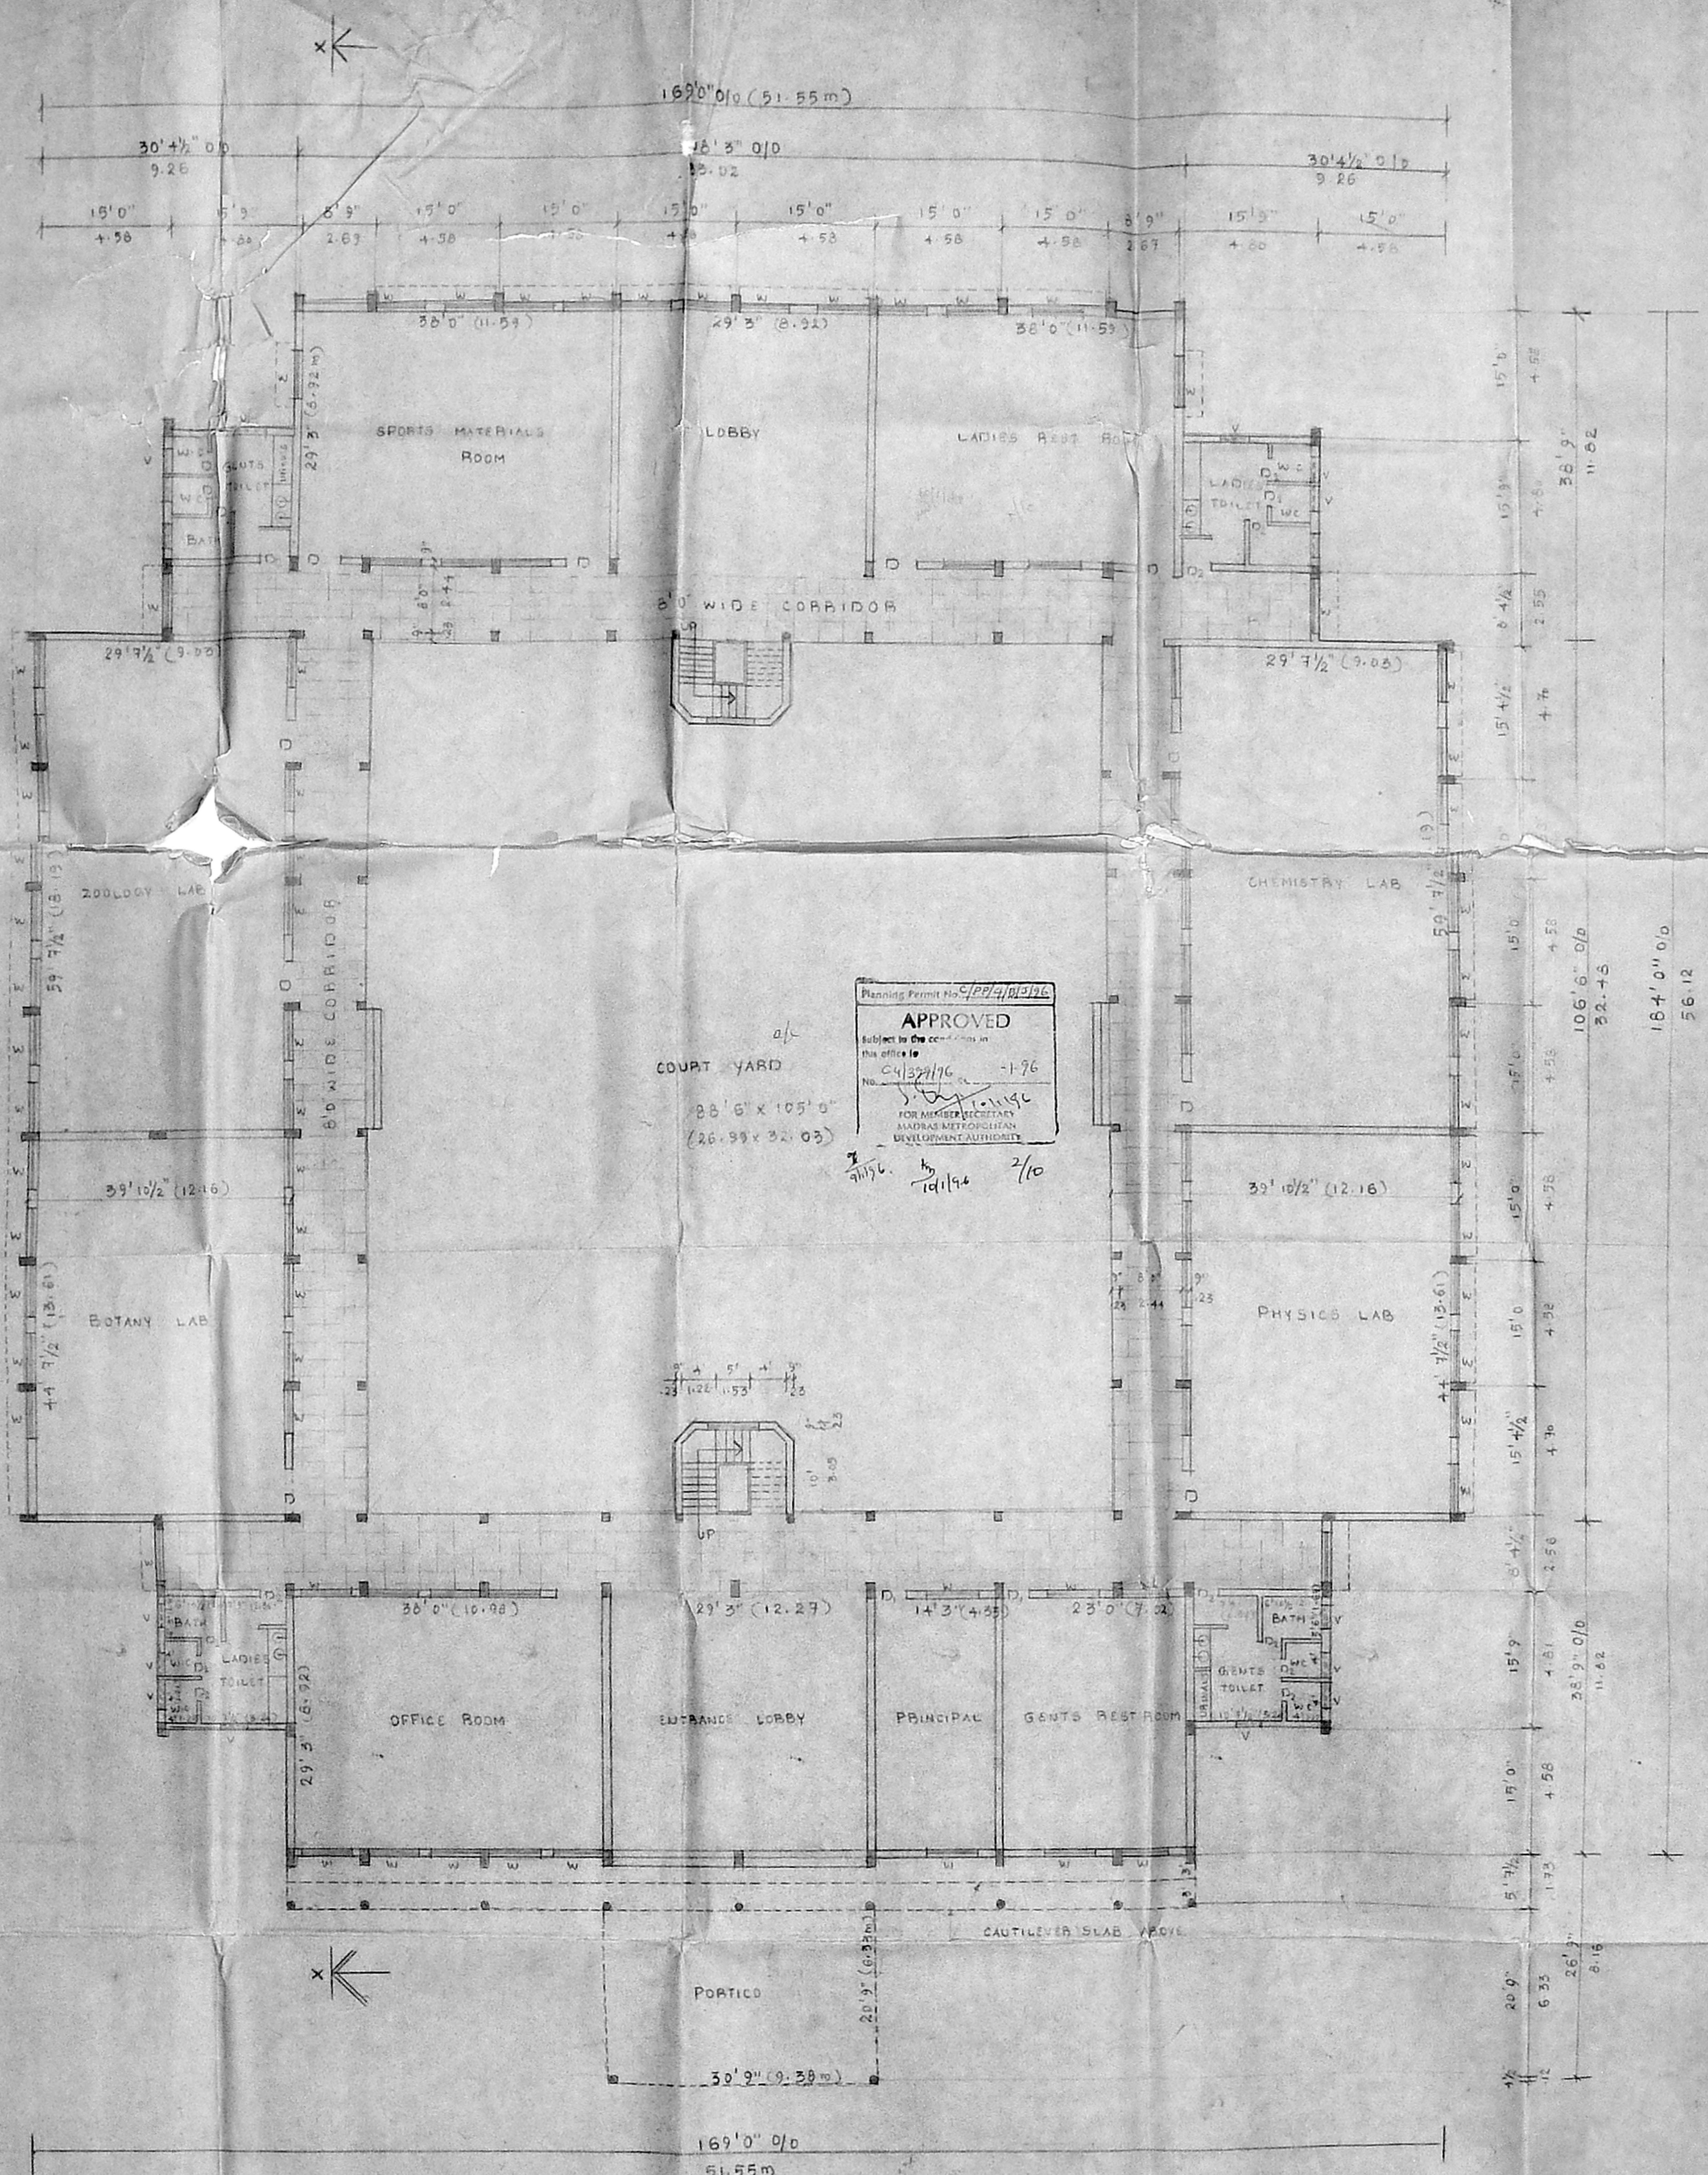

GROUND FLOOR PLAN

PLAN SHOWING THE PROPOSED BUILDING FOR HIGHER SECONDARY SCHOOL AT S NO 1404/2A, B.C.E. 413/1 TO 7, 414/1, 415/VILLAGE N/18 POONTHADALAM, MADRAS DISTRICT, MADRAS STATE, FOR MR.

Planning Permit No. CP/4/102196
APPROVED
 Subject to the conditions in this office file
 No. CP/4/102196 - 1-96
 FOR MEMBER SECRETARY
 MADRAS METROPOLITAN DEVELOPMENT AUTHORITY

COURT YARD
 28'6" x 105'0"
 (26.99 x 32.03)

SCHEDULE OF JOINERIES

NO	PARTICULARS	SIZE IN SFT	SIZE IN FT
1	DOOR	4'0" x 7'0"	1.22 x 2.14
2	DI	3'0" x 7'0"	0.91 x 2.14
3	DI	2'8" x 7'0"	0.76 x 2.14
4	WINDOW	6'0" x 4'0"	1.83 x 1.22
5	VENTILATOR	3'0" x 2'0"	0.91 x 0.61

- OUTLINE SPECIFICATIONS
- FOUNDATION: R.C.C. FRAMED STRUCTURE
 - SUPER STRUCTURE: 3" TH BRICKWORK IN CH. 1 CM AND 4 1/2" TH BRICKWORK IN CH. 1 CM
 - R.C.C. WORK: FOR LINTELS, SLAB, COLUMNS, SUNSHADES, ETC.
 - PLASTERING: FOR WALLS IN CH. 1.5 CM AND CEILING IN CH. 1 CM
 - JOINERIES: ALL DOORS & WINDOWS ARE OF COUNTRY WOOD
 - FLOORING: MOPAN FLOORING
 - PAINTING: TWO COATS OF ENAMEL PAINT OVER ONE COAT OF PRIMER
 - WEATHERING COURSE: IN SILE USING L.M. AND TOP FINISHED WITH PRESSED TILES USING CH. 1 CM


APPLICANT:
K. Mohan Kumar

LICENSED BUILDING SUPERVISOR
[Signature]
 Dr. K. VENUGOPAL, B.E., A.M.A.
 CORPORATION OF MADRAS
 Civil & Sanitary Engineering Consultant
 Licensed Surveyor, Class I No. 28
 Licensed Plumber Class-I Metro Water
 License No. ... Water Supply No. ...
 2, Ambalambadi Street, Madhavaram, Laxmi Nagar
 Madras - 600 024

COLOUR CODE INDEX
 PROPOSAL

SCALE: 1" = 8'0" DATE: 20.07.95
 BLOCK: A SHEET NO: 1
 DRN: K. PREMALATHA

Architects,
 VIJAY ASSOCIATES,
 17, Ramasamy St,
 T. Nagar, Madras 17

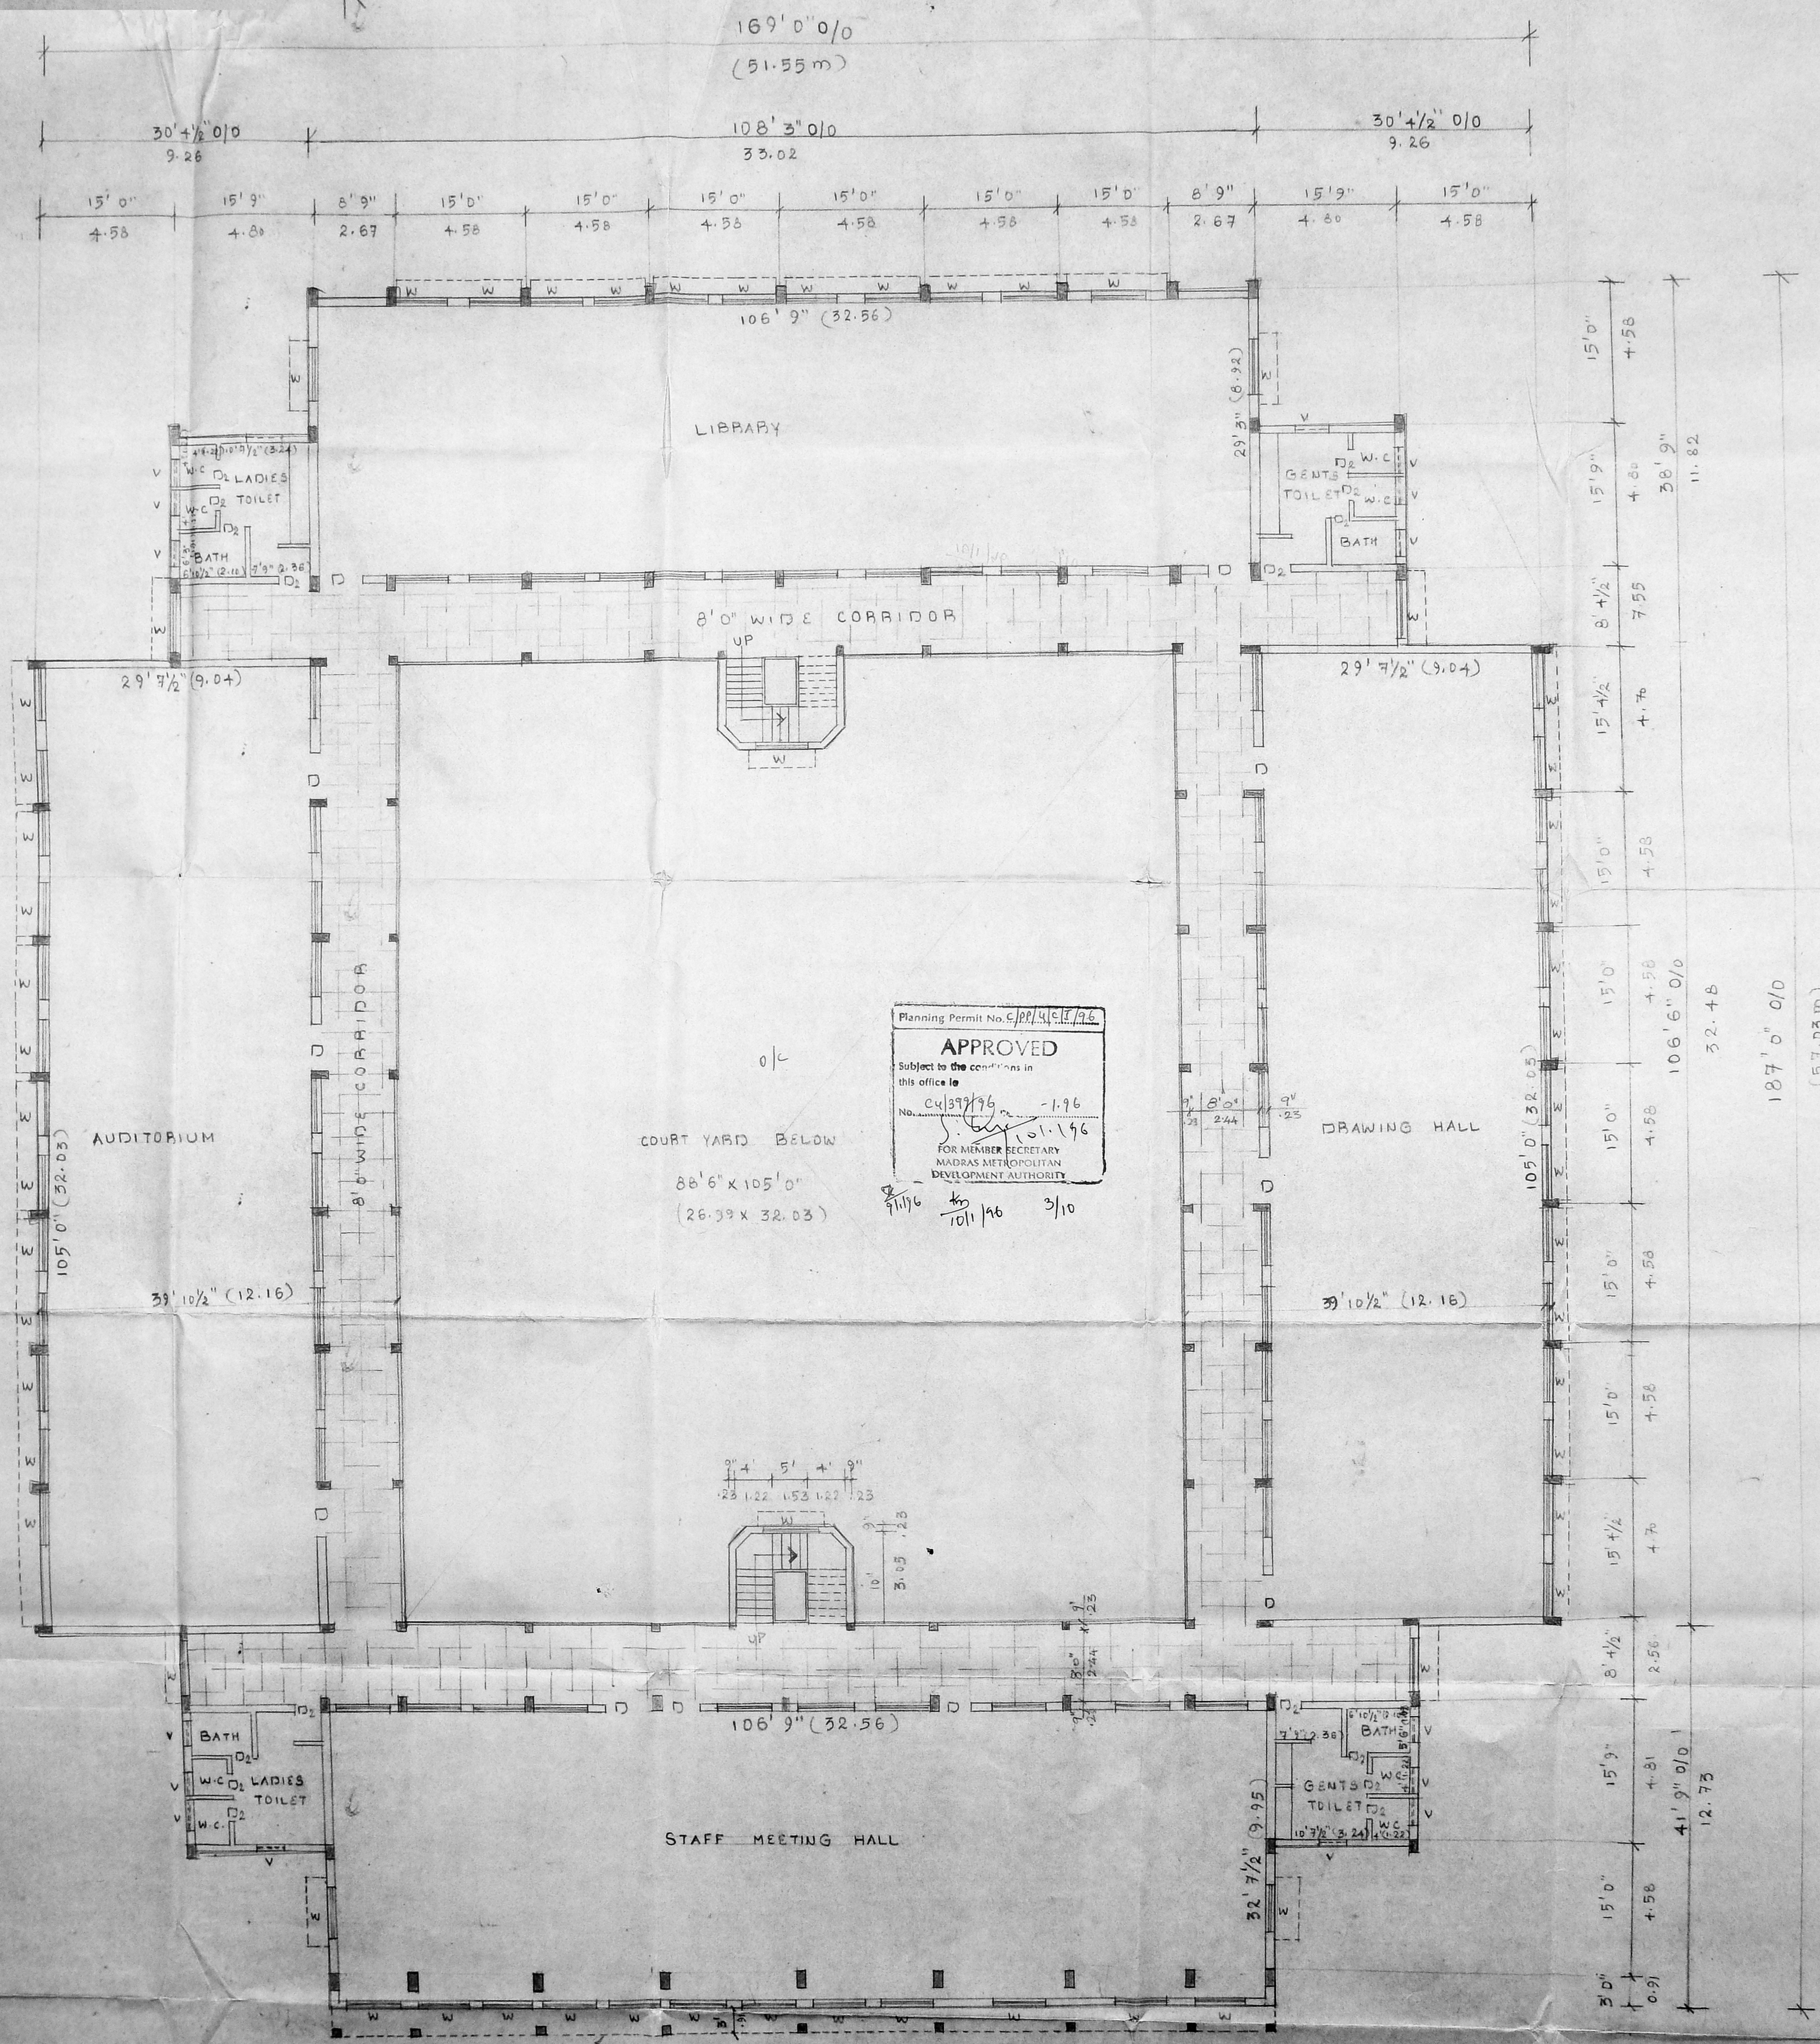

Planning Permit No. C/PP/44/E/26
APPROVED
 Subject to the conditions in this office file
 No. C/37/96 -196
 10/11/96
 FOR MEMBER SECRETARY
 MADRAS METROPOLITAN
 DEVELOPMENT AUTHORITY
 9/11/96 to 10/11/96 2/10


PLAN SHOWING THE PROPOSED CONSTRUCTION OF HIGHER SECONDARY SCHOOL AT S-NO: 404/2A, B & C, 413/1 TO 7, 414/4, 415/VILLAGE NO: 78, POOTHADALAM DHARMAST. SRI PERUMPUUR TALUK, CHENGAI M.G.R. DISTRICT, MADRAS + + FOR MR.

APPLICANT:
K. Venugopal
 LICENSED BUILDING SURVEYOR
M. S. S.
 Dr. K. VENUGOPAL, Rtd. A.M.S.
 CORPORATION OF MADRAS
 Civil & Sanitary Engineering Consultant
 Licensed Surveyor, Class-I No. 28
 Licensed Plumber, Class-I Metro Water
 Sewerage No. Water Supply No.
 8, Baskin Street, Manipalpet (East) Area
 Madras - 600 034

COLOUR CODE INDEX	
1	PROPOSAL
BLOCK A	SHEET NO: 2
SCALE: 1" = 8'0"	DATE: 24.08.95
DRAWN: M. PREMALATHA	

Architects,
 VIJAY ASSOCIATES,
 17, Bamasamy St.

FIRST FLOOR PLAN

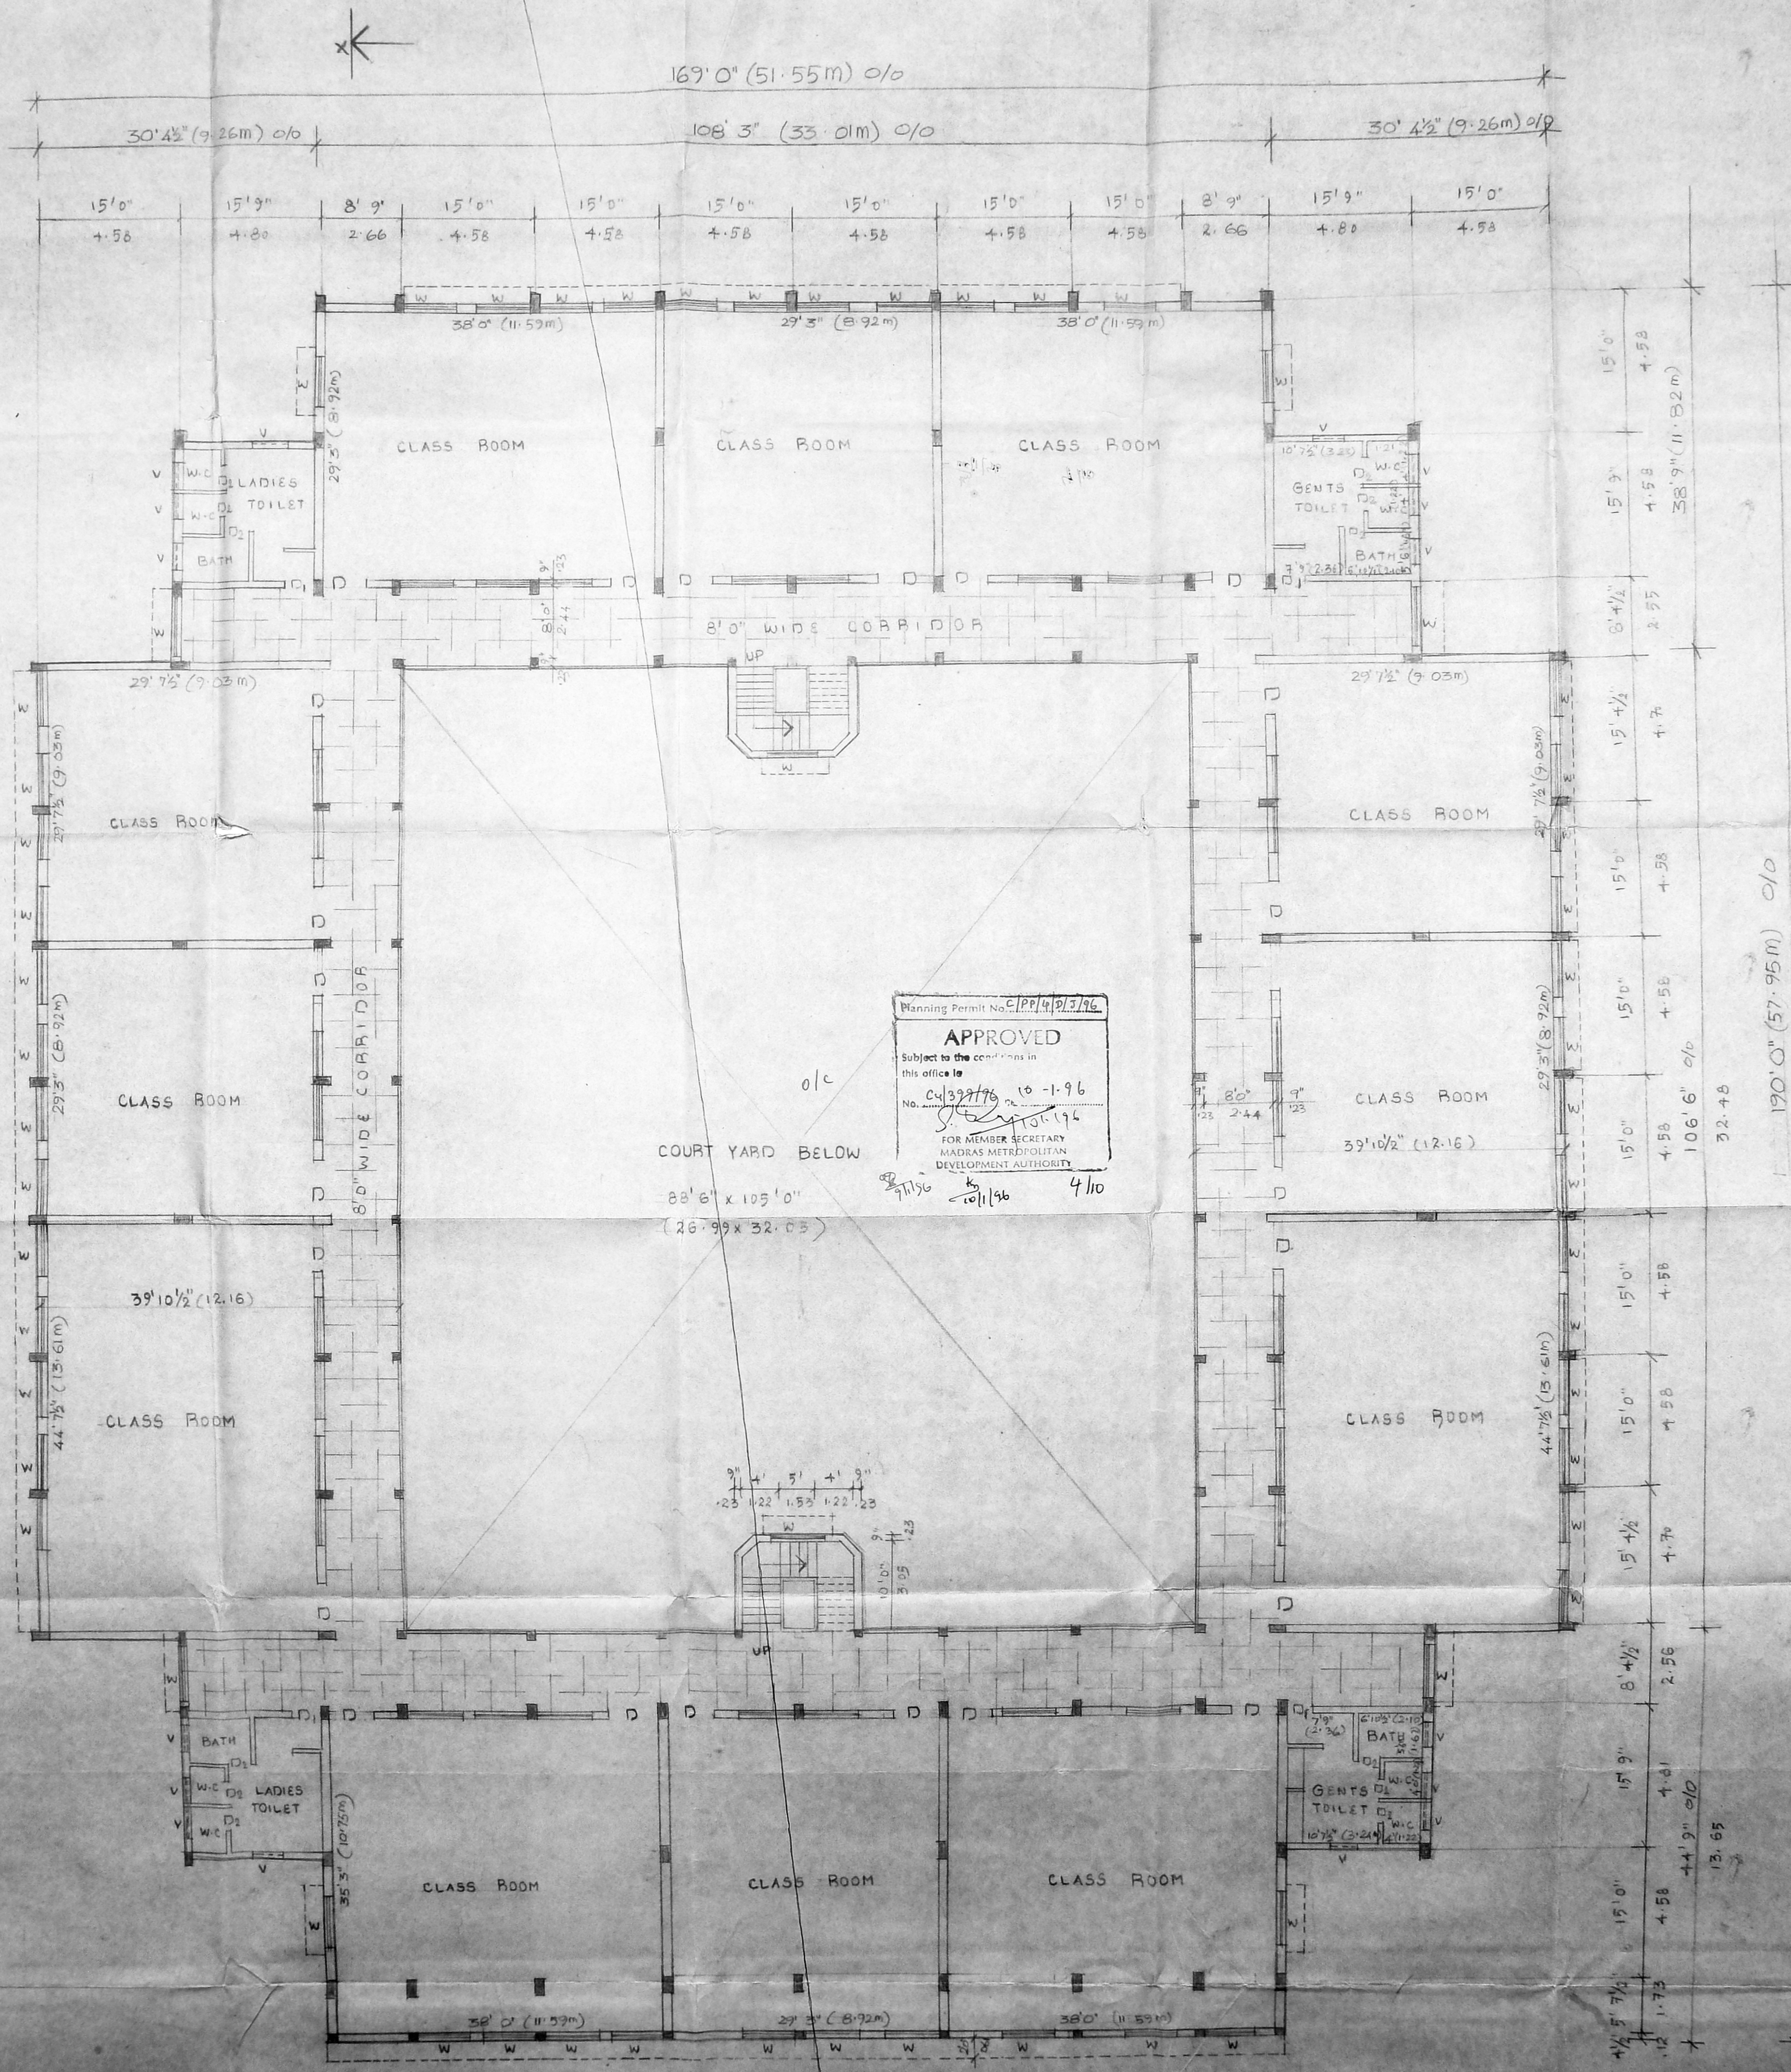

SECOND FLOOR PLAN

PLAN SHOWING THE PROPOSED CONSTRUCTION OF HIGHER SECONDARY SCHOOL AT S.NO: 404/2A, B.G.C, 4131107, 41411, 415/VILLAGE NO: 76, POOTHADALAM, DHARVAST, SRIPERUMPUOOR TALUK, CHENGAI M.G.B. DISTRICT, MADRAS 44 FOR MB.

APPLICANT:
K. Mohan Kumar

LICENSED BUILDING SURVEYOR:
M. Paul

Dr. K. VENUGOPAL, B.E., A.M.I.E.
 CORPORATION OF MADRAS
 Civil & Sanitary Engineering Consultant
 Licensed Surveyor, Class-I No: 320
 Licensed Planner, Class-I Metro Water
 Sewerage No. Water Supply No.
 B. Neelakandan Street, Madhavathala (Lake Area)
 Outside of Corporation City Limits, Secondary School,
 MADRAS - 600034


COLOUR CODE INDEX:
1 PROPOSAL: []

BLOCK : A SHEET NO: 3

SCALE : 1" = 8'0" DATE : 24-07-95

DRAWN : K. PREMALATHA,

Architects,
VIJAY ASSOCIATES,
 17, Ramasamy St,
 T. Nagar, Madras 17

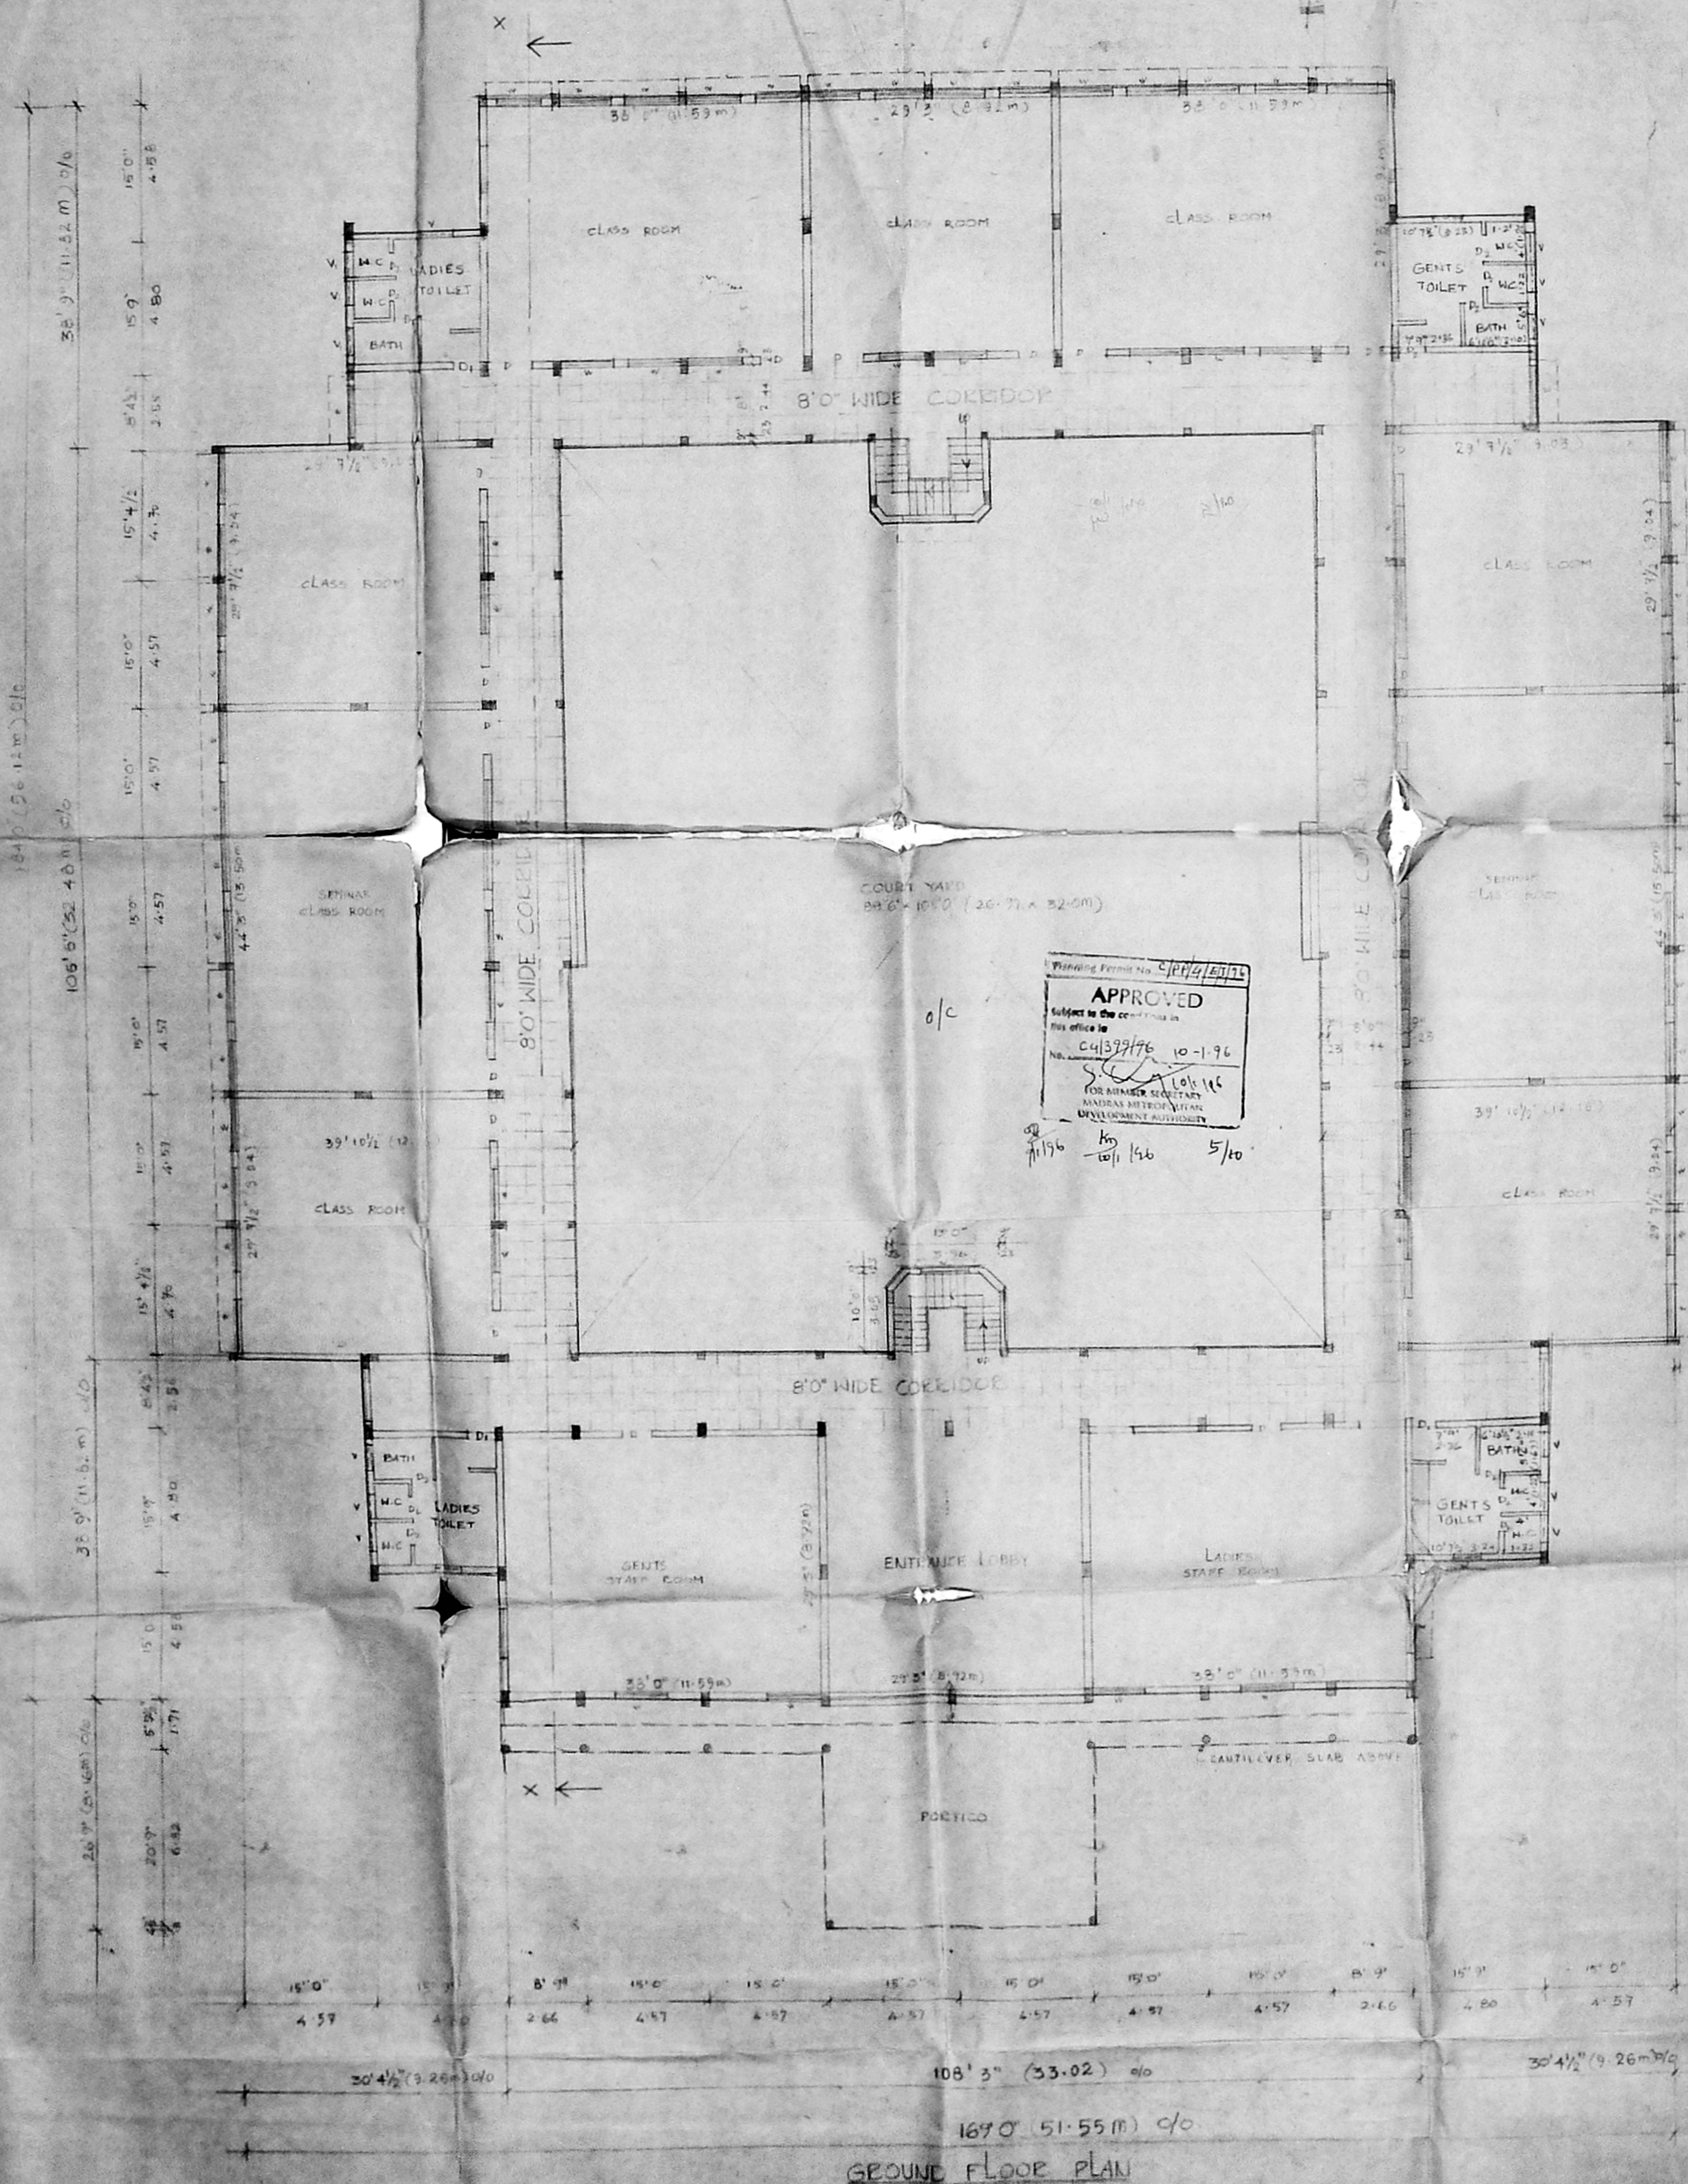

169'0" (51.55 m) o/c
GROUND FLOOR PLAN



PROPOSED BUILDING FOR HIGHER SECONDARY SCHOOL AT S. N. ROAD, P. A. R. E. W. S. I. T. O. (7/67/245/1) VILLAGE NO. 15 - P. S. N. T. T. T. D. D. H. A. S. T. S. I. P. E. C. U. M. P. U. V. E. T. A. L. W. C. H. E. N. G. A. I. M. G. R. DISTRICT MADRAS-44 FOR ME

Licensed Surveyor, Madras

M. Venigopal

Dr. K. VENIGOPAL, B.E., A.S.E.
 CORPORATION OF MADRAS
 Civil & Structural Engineering Consultant
 Licensed Surveyor, Class I No. 120
 Licensed Plumber, Class II, Street Water
 Sewerage No. ... Water Supply No. ...
 2, Venkateswara Street, S. N. T. T. T. D. D. H. A. S. T. S. I. P. E. C. U. M. P. U. V. E. T. A. L. W. C. H. E. N. G. A. I.
 MADRAS 400022

APPLICANT

K. Venigopal

BLOCK B & C

Color Index

Architects

Regional

ROAD

SEWER LINK

SHEET NO. 1

SCALE: 1" = 10' @ 1/100


DATE: 24-1-96

ARCHITECTS

VIJAY & ASSOCIATES

107, East Coast Road, Chennai-600 042

T. Nagar, Madras-400 017

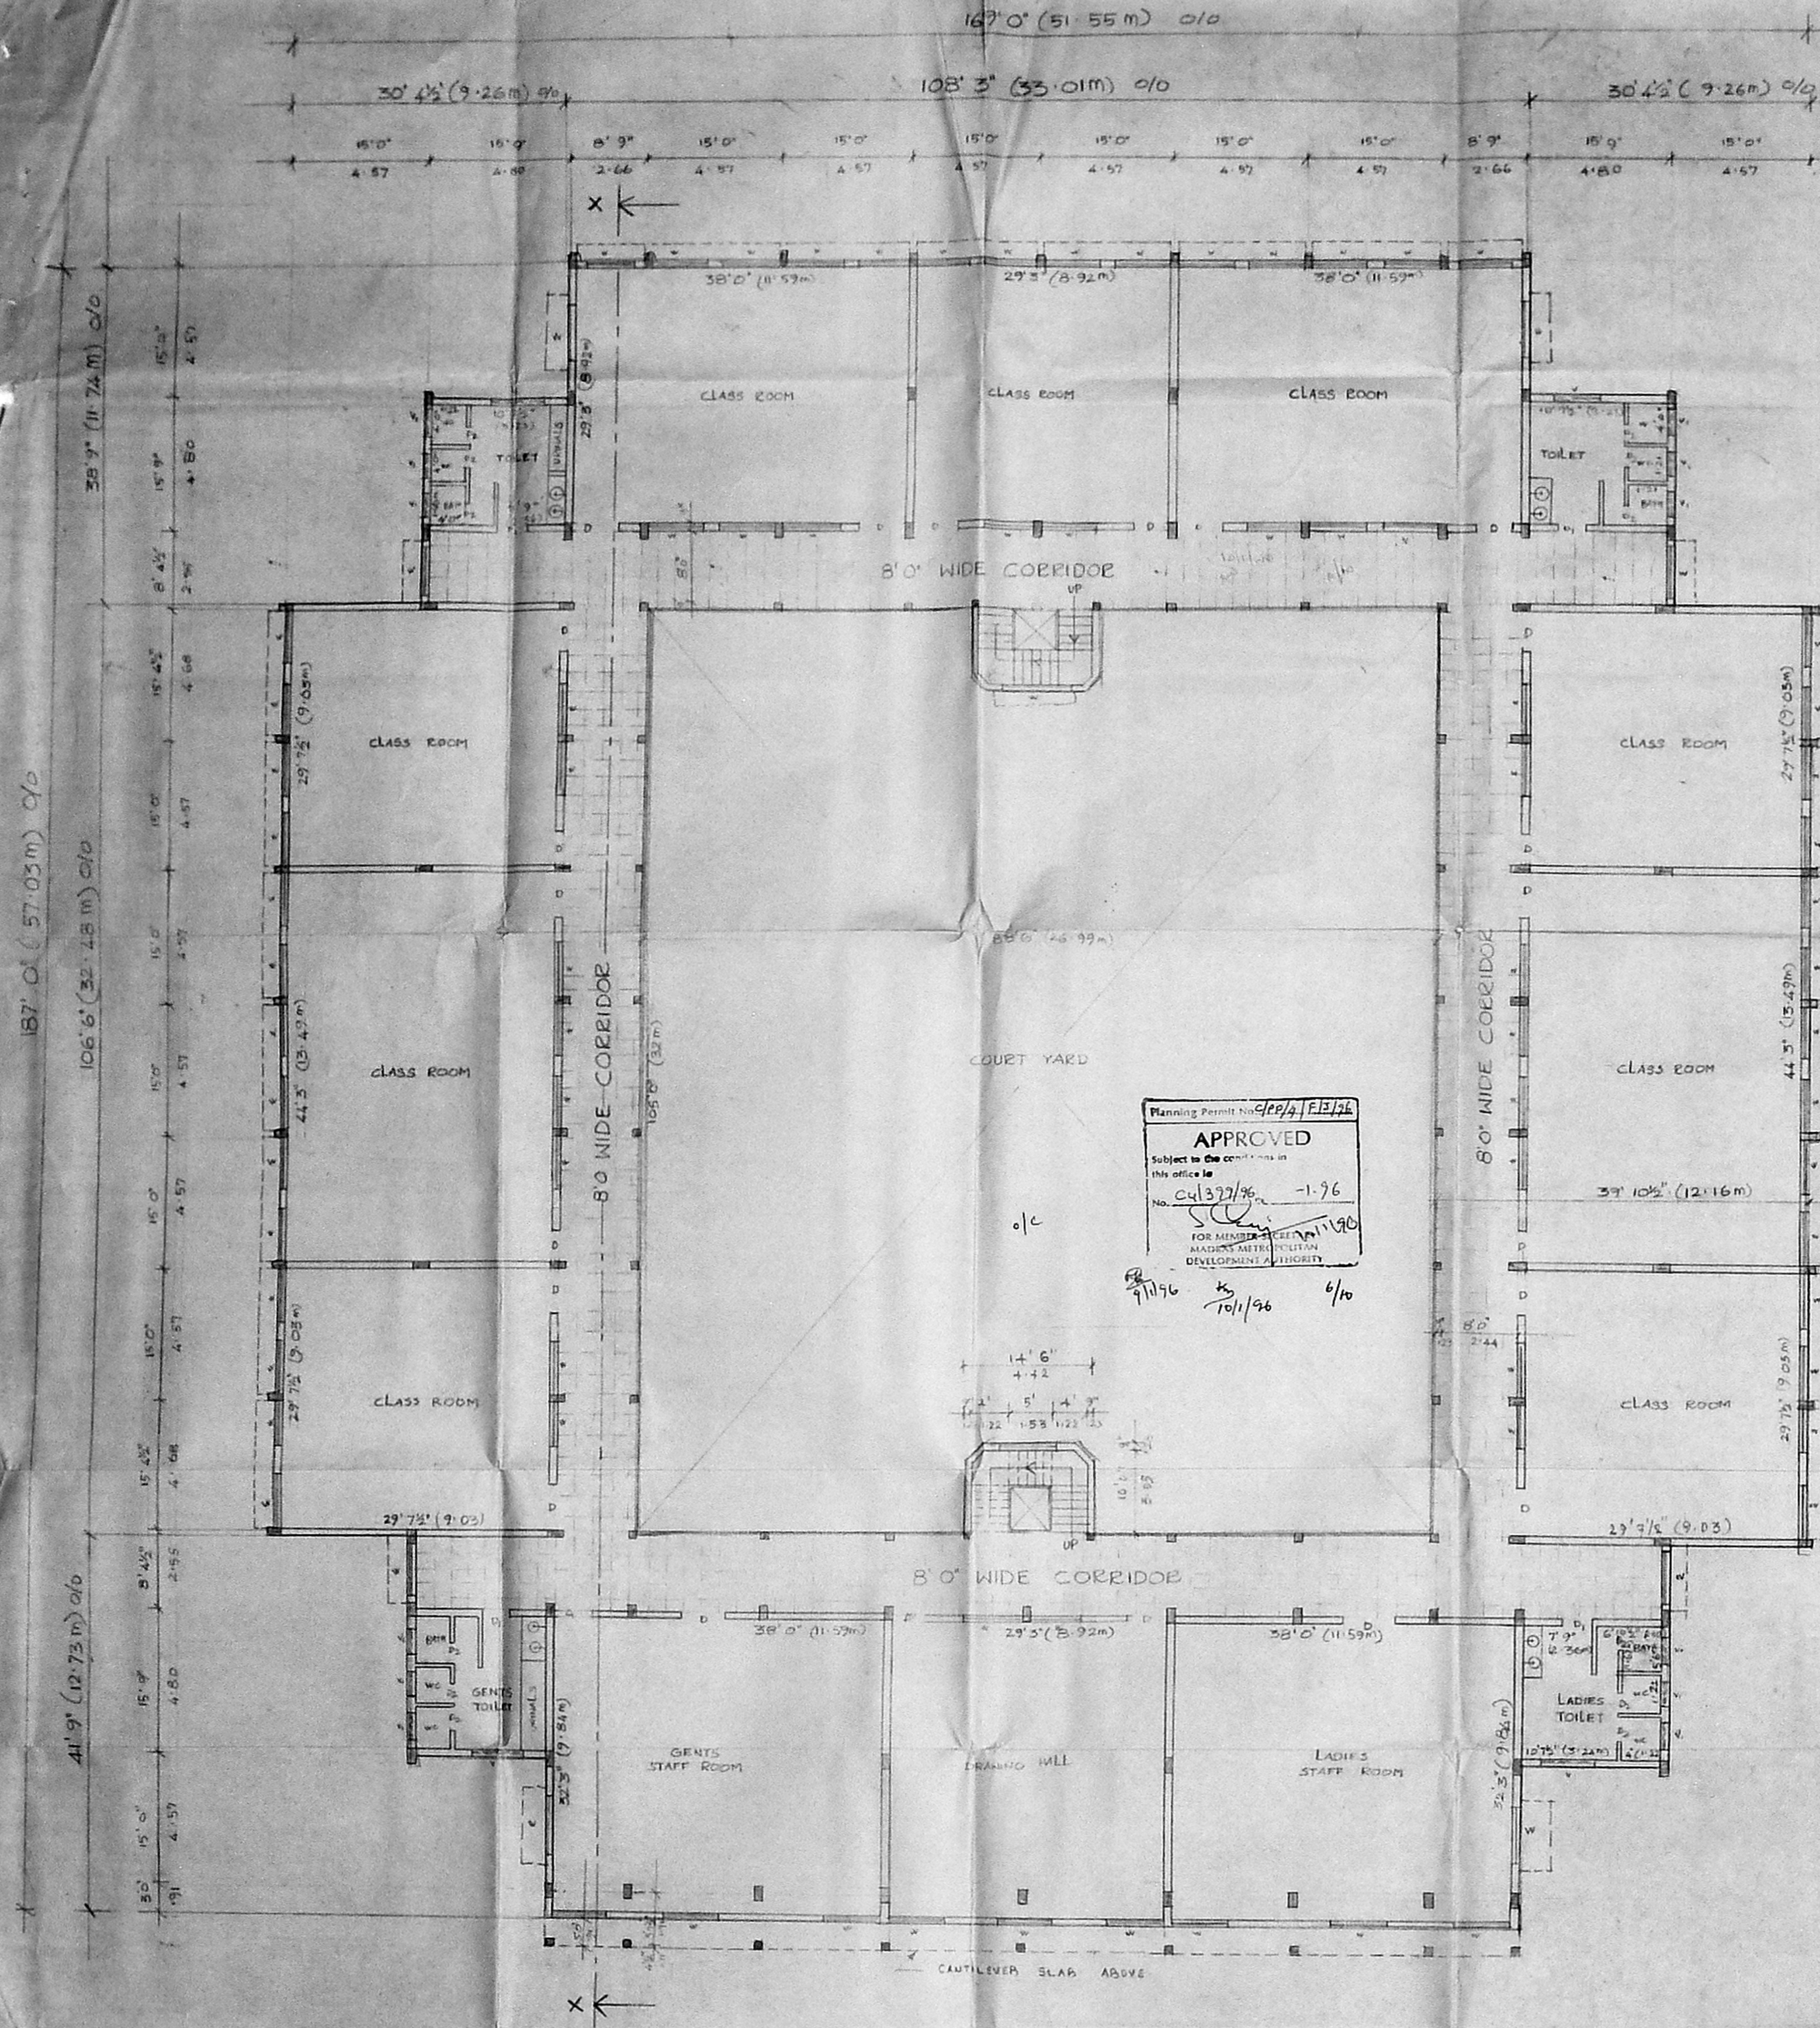

FIRST FLOOR PLAN

PROPOSED BUILDING FOR HIGHER SECONDARY SCHOOL AT S.NO 404/2A,B & C, 415/1 TO 7, 414/1, 415/2 VILLAGE NO 18, POONTHADALAM DHARMAST, SRIRAMPURU TALUK, CHANGAI M.G.R. DISTRICT, MADRAS-44 FOR MR.

LICENSED BUILDING SURVEYOR

Dr. K. VENUGOPAL, M.A., A.M.I.E.
 CORPORATION OF MADRAS
 Civil & Sanitary Engineering Consultant
 Licensed Surveyor, Class-I No. 328
 Licensed Plumber, Class-I Metro Water
 Sewerage No. Water Supply No.
 8, Madhavaram Street, Rampanthalam (East-44)
 Madras 600 024

APPLICANT
K. Venugopal

BLOCK B & C

COLOUR INDEX

BOUNDARY ○
 PROPOSAL ○
 ROAD ○

SHEET NO 2


DATE: 21.7.95 SCALE: 1/8" = 1'-00"

Architects
VIJAY & ASSOCIATES
 No 17 Ramasamy Street

169'0" (51.55m)

108'5" (33.01m) o/o

30'4 1/2" (9.26m) o/o

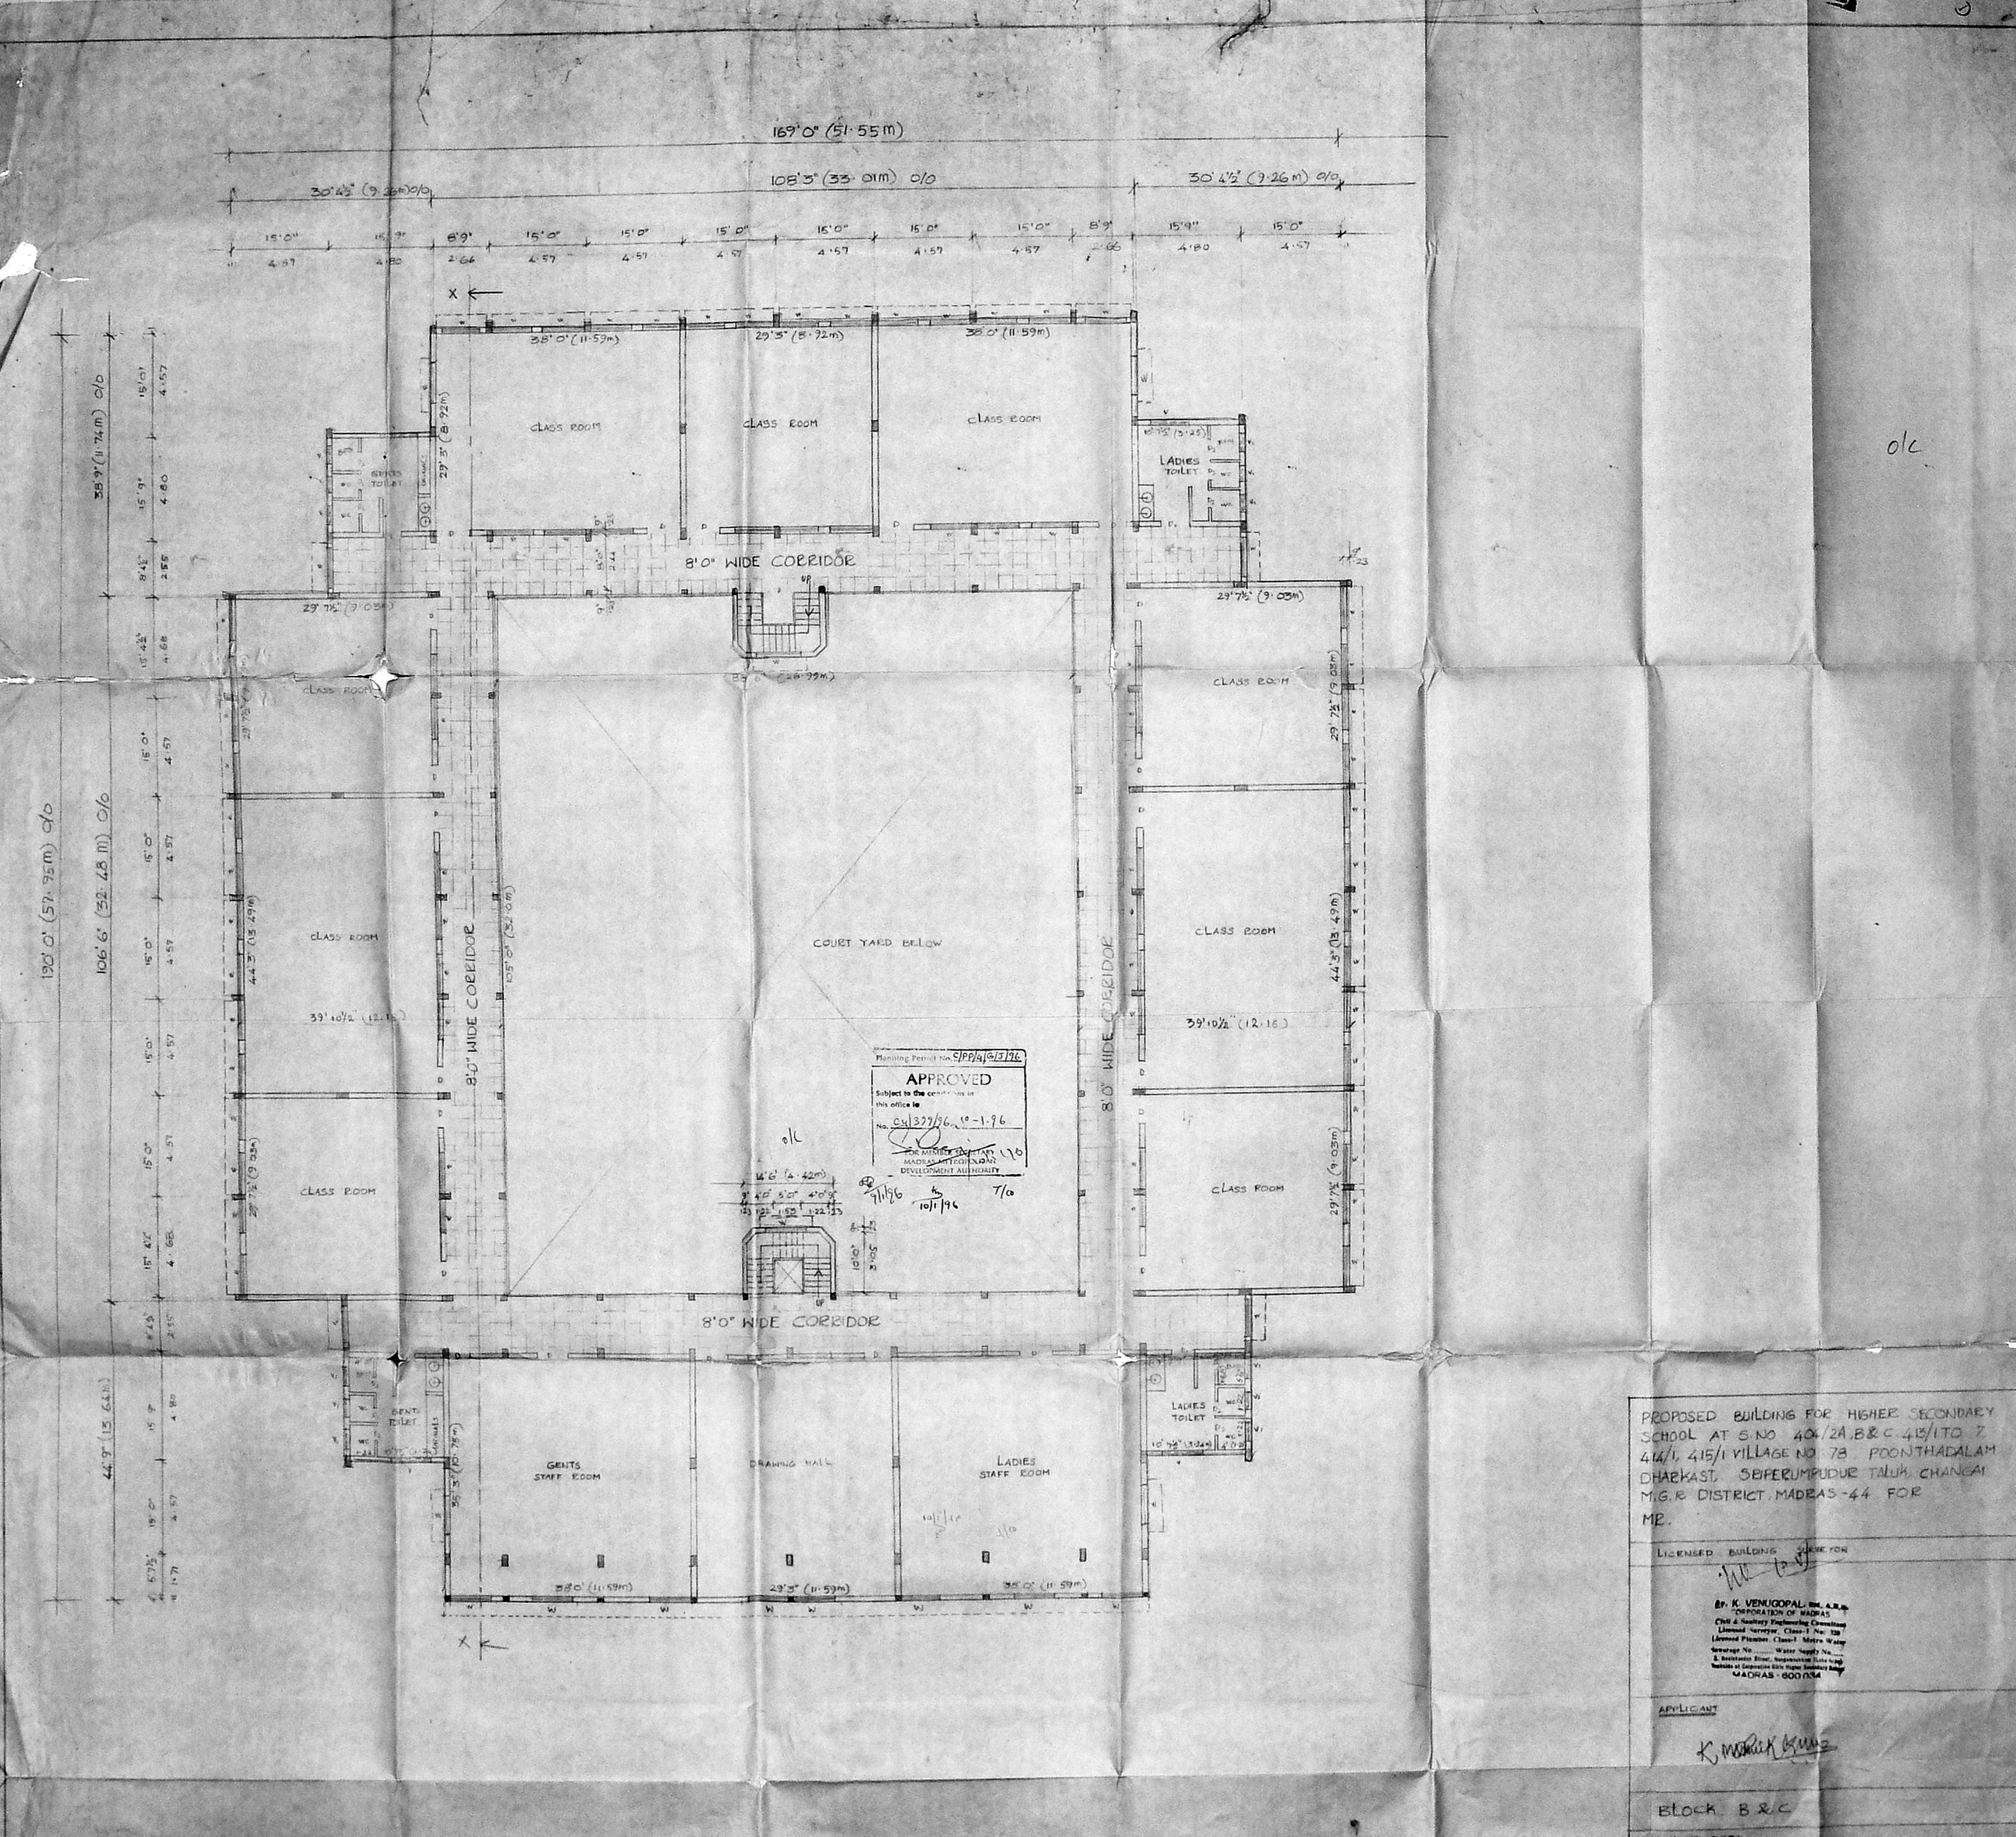

SECOND FLOOR PLAN

PROPOSED BUILDING FOR HIGHER SECONDARY SCHOOL AT S.NO 404/2A,B&C 4B/1 TO 2 404/1, 415/1 VILLAGE NO. 78 POONTHADALAM DHARAKAST, SIPHERUMPUR TALUK, CHANGAI M.G.R. DISTRICT, MADRAS-44 FOR MR.

LICENSED BUILDING SURVEYOR

K. Mohan Kumar
Dr. K. VENUGOPAL, M.A., A.R.C.
 CORPORATION OF MADRAS
 Civil & Sanitary Engineering Consultant
 Licensed Surveyor, Class-I No. 100
 Licensed Plumber, Class-I Metro Water
 Licence No. ... Water Supply No. ...
 2, Redhills Road, Madras-600 014
 Madras-600 014

APPLICANT

K. Mohan Kumar

BLOCK B & C

COLOUR INDEX

- BOUNDARY ○
- PROPOSAL ○
- ROAD ○
- SEWER LINE ○


SHEET NO: 3


SCALE 1" = 10' 1:100

DATE 22.9.75

Architects-

VIJAY & ASSOCIATES
 No. 17, Connaught Street,
 T. Nagar, Madras - 19


291

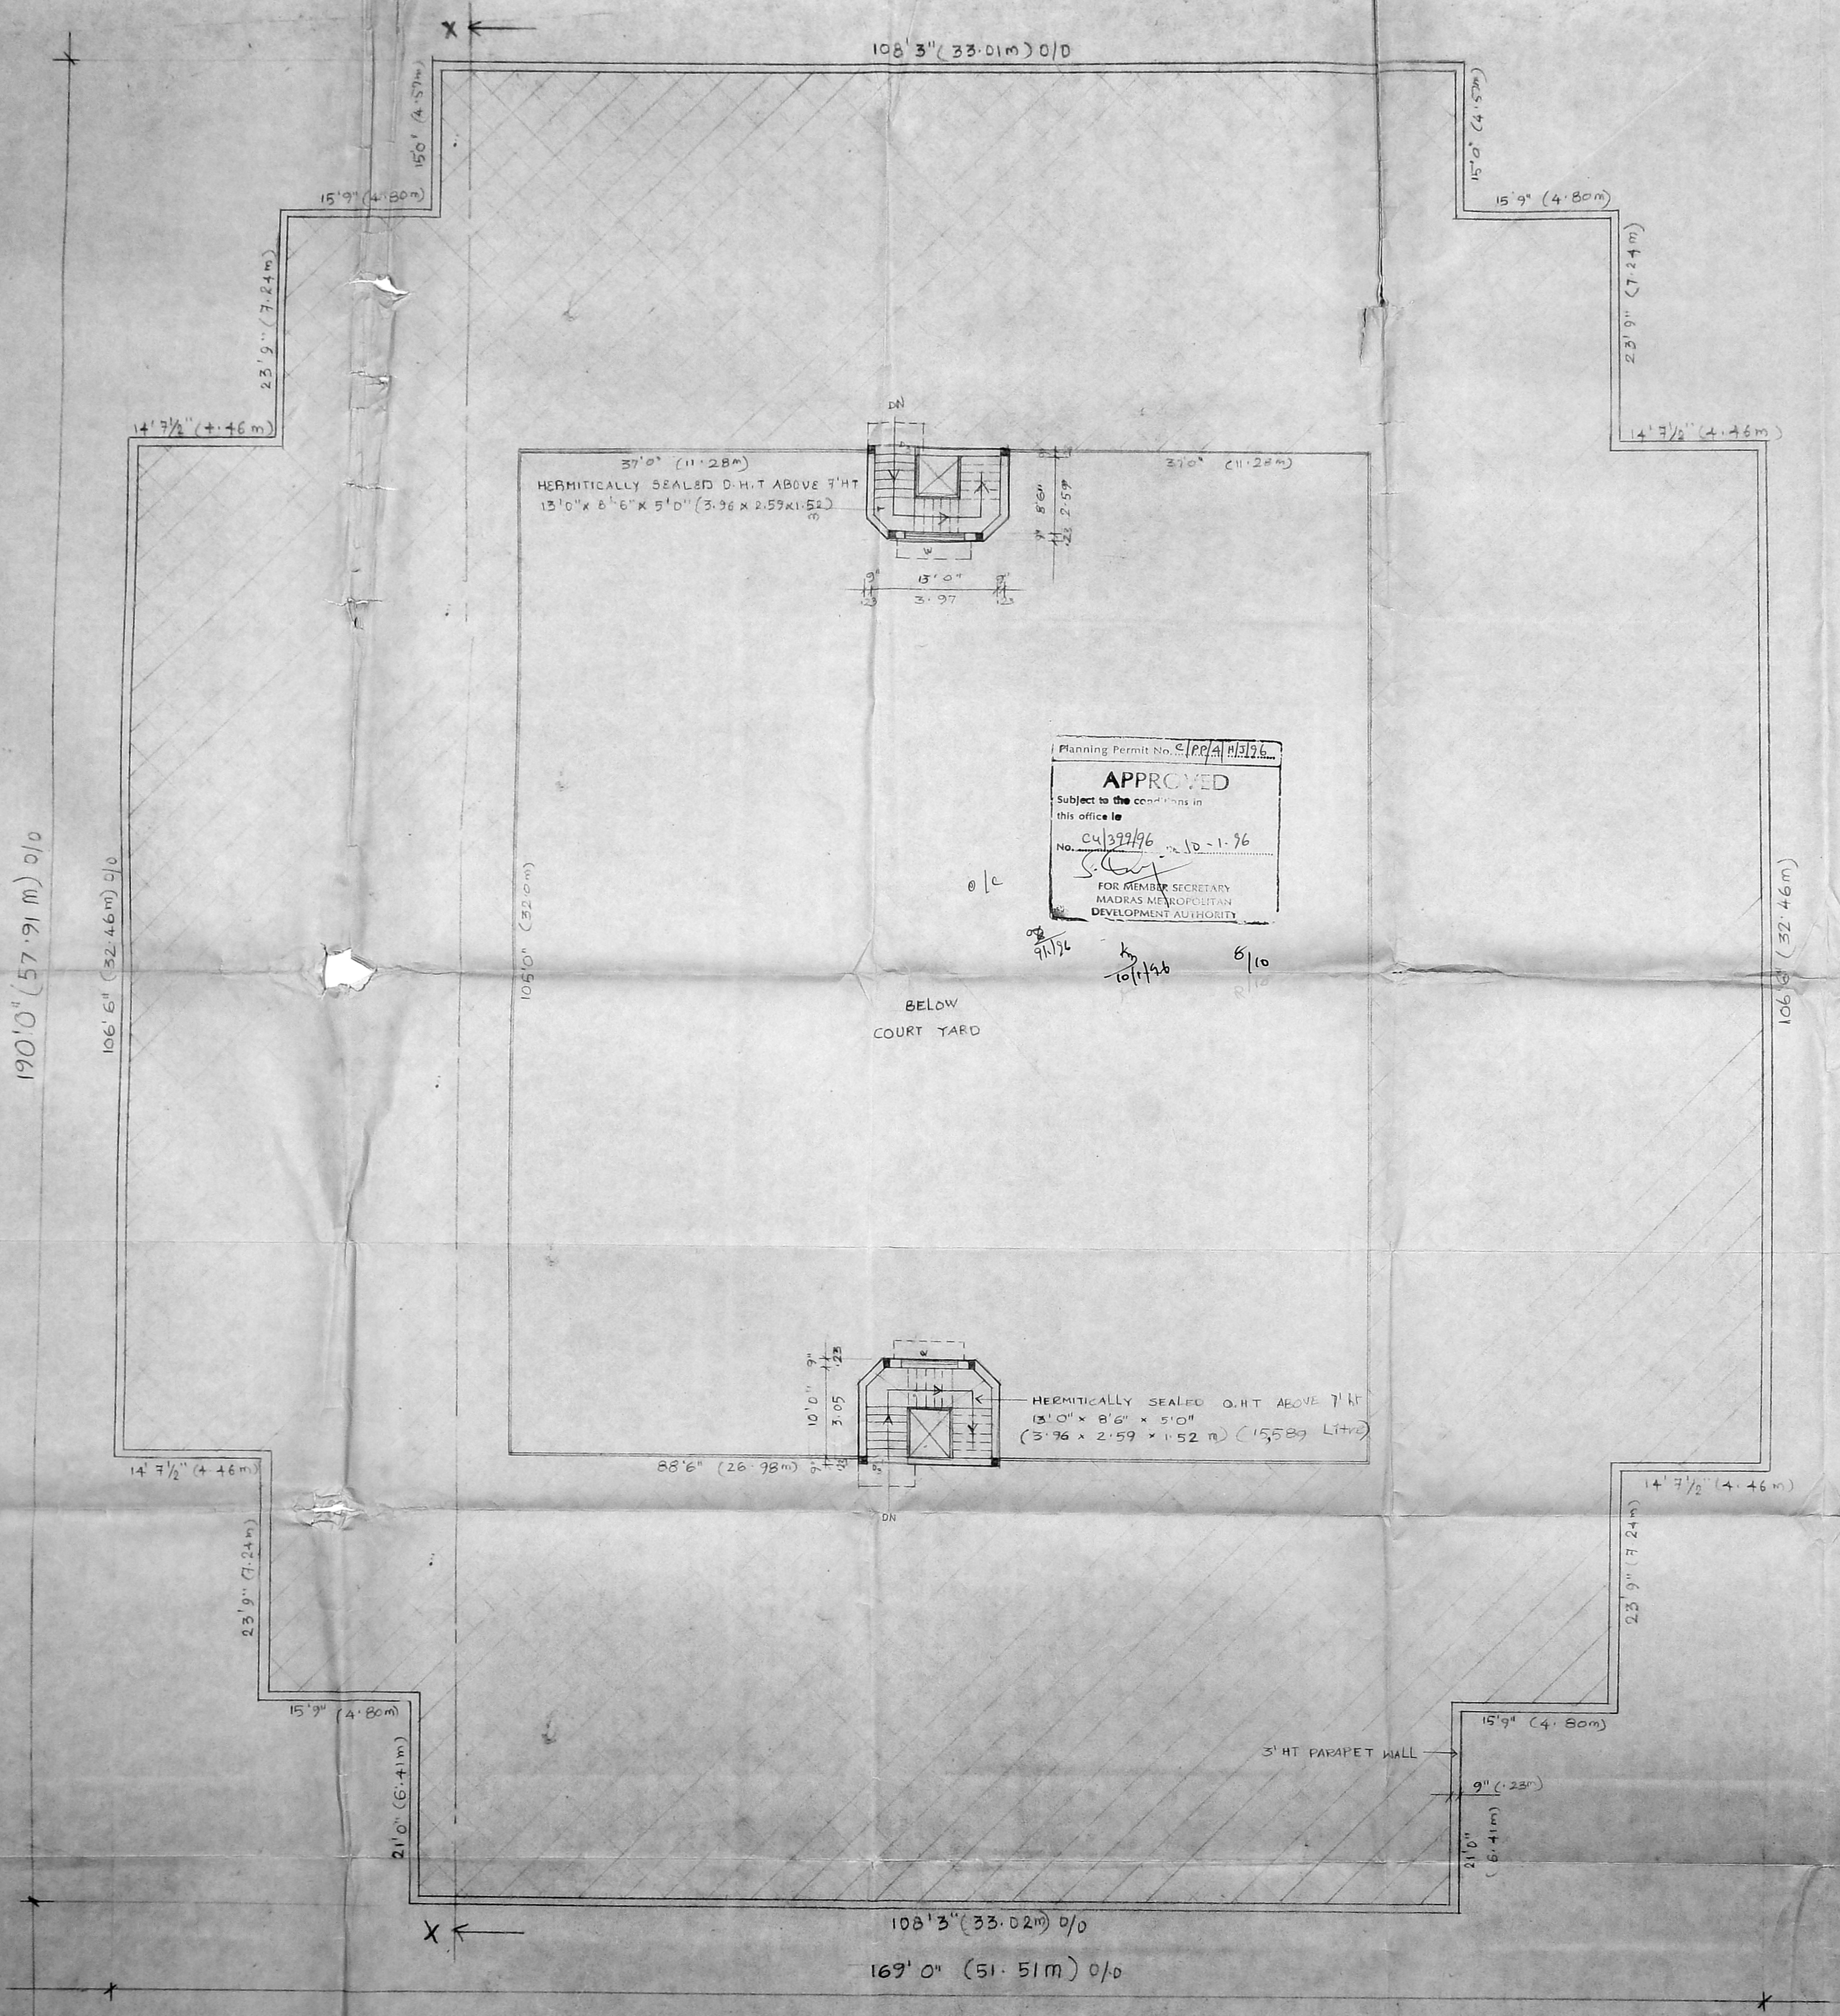
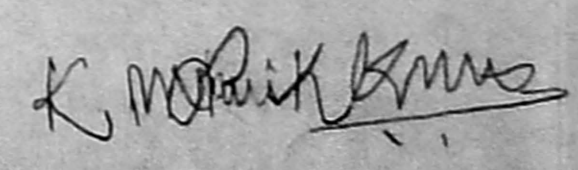


Planning Permit No. CP/PA/1336
APPROVED
 Subject to the conditions in this office
 No. C4/397/96 of 10-1-96
 S. [Signature]
 FOR MEMBER SECRETARY
 MADRAS METROPOLITAN
 DEVELOPMENT AUTHORITY

HERMITICALLY SEALED D.H.T ABOVE 7' HT
 13'0" x 8'6" x 5'0" (3.96 x 2.59 x 1.52 m) (15589 Litre)

PROPOSED BUILDING FOR HIGHER SECONDARY SCHOOL AT S.NO 404/2A, B & C, 413/1 TO 7, 414/1, 415/1 VILLAGE NO 78, POONTHADALAM DHARMAST, SRIPERUMPUDUR TALUK CHANGAI M.G.R. DISTRICT, MADRAS-44 FOR MR.

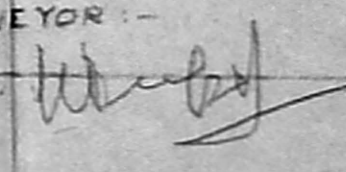LICENSED BUILDING SURVEYOR -

Dr. K. VENUGOPAL, R.S. A.M.S.
 CORPORATION OF MADRAS
 Civil & Sanitary Engineering Consultant
 Licensed Surveyor, Class-I No. 128
 Licensed Plumber, Class-I Metro Water
 Sewerage No. Water Supply No.
 B, Neelakandan Street, Neelakandan (Laka Area)
 Multiple of Corporation City Higher Secondary School
 MADRAS - 600 034


APPLICANT


BLOCK: A, B & C
 COLOUR INDEX :-
 BOUNDARY ○
 PROPOSED ○
 ROAD ○
 SEWER LINE ○

SHEET NO : 4
 SCALE : 1" = 8' 0" DATE : 24.7.95

architects -
VIJAY & ASSOCIATES
 NO 17 Ramasamy street,
 T. Nagar, Madras - 17

TERRACE FLOOR PLAN

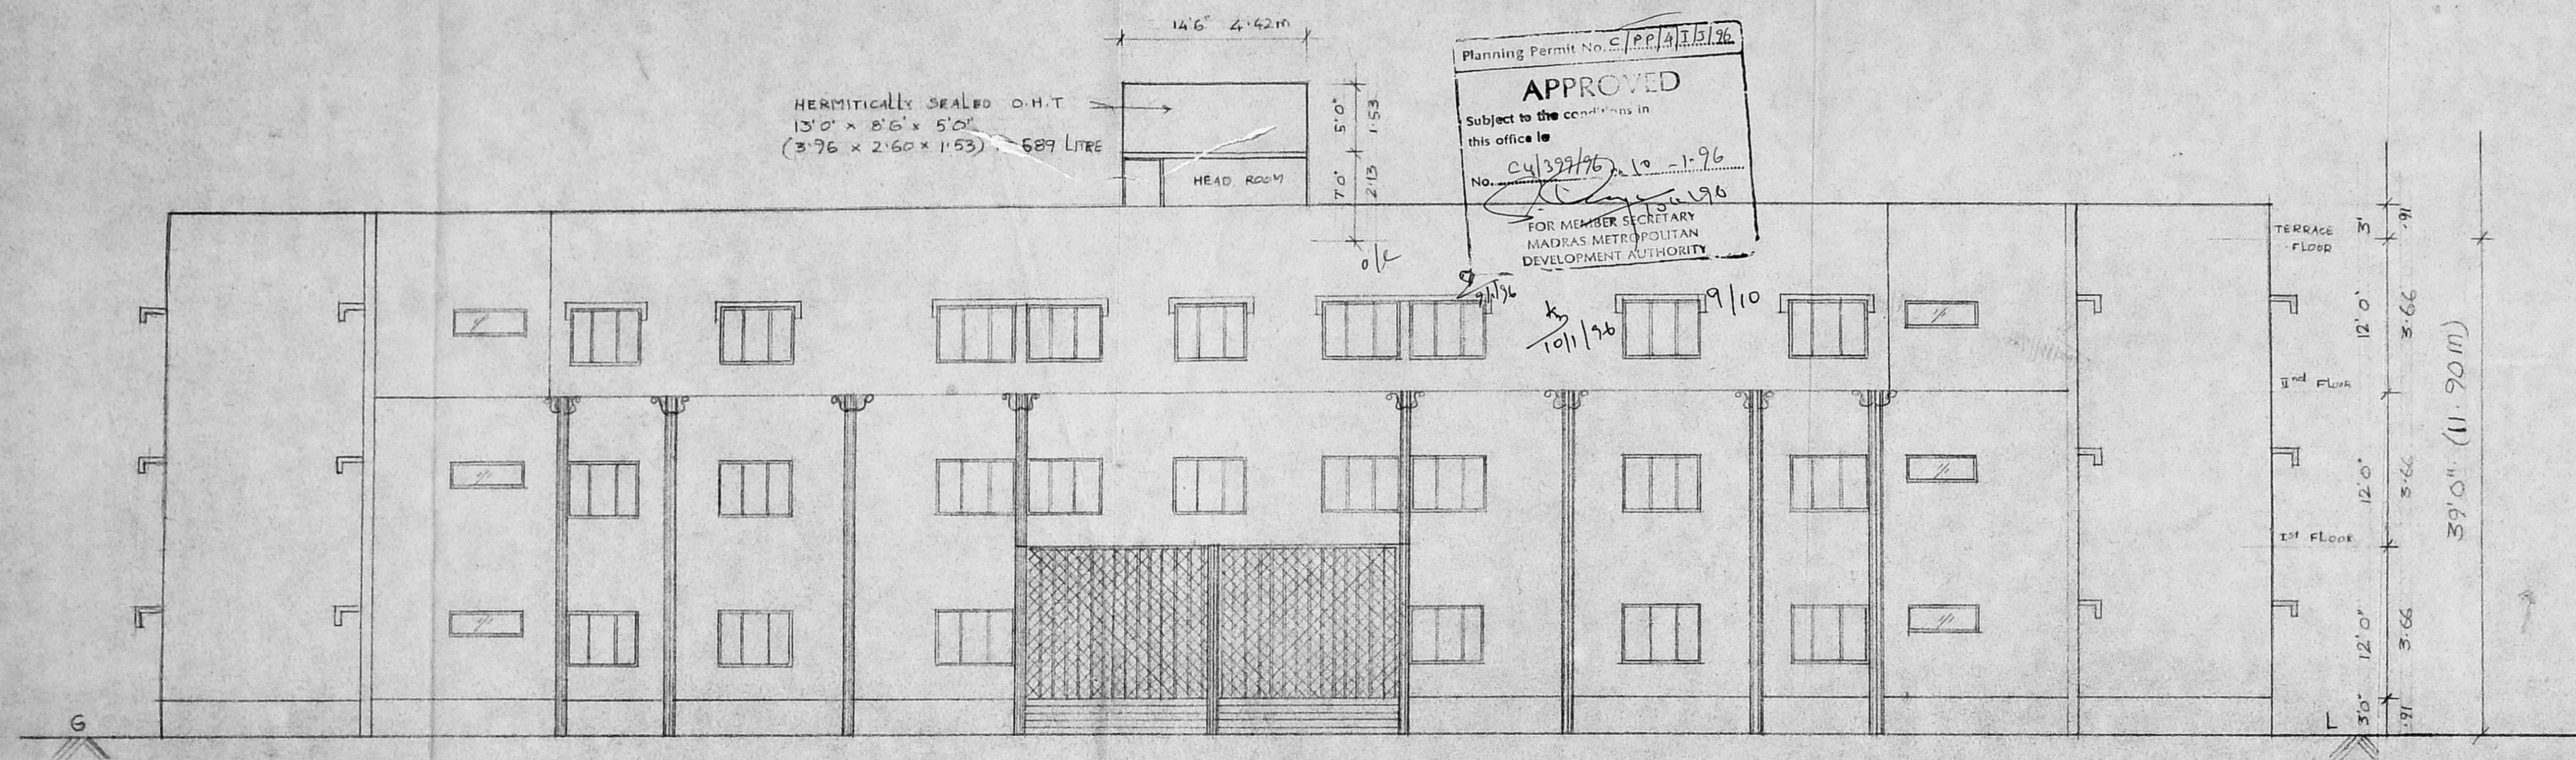

FRONT ELEVATION

PROPOSED BUILDING FOR HIGHER SECONDARY SCHOOL AT S.NO. 404/2A, B & C, 413/1 TO 7, 414/1, 415/1 VILLAGE NO. 78, POONTHADALAM-DHARKAST, SRIPERUMPUDUR TALUK, CHANGAI M.G.R. DISTRICT, MADRAS-44 FOR MR. 293 o/c

APPLICANT
K. Mohan Kumar

LICENSED BUILDING SURVEYOR
K. VENUGOPAL, Rtd. A.E.D.
CORPORATION OF MADRAS
Civil & Sanitary Engineering Consultant
Licensed Surveyor, Class-I No. 720
Licensed Plumber, Class-I Metro Water
Sewerage No. Water Supply No.
B. Neelakandan Street, Nungambakkam (Lake Area)
MADRAS - 600 034

BLOCK A, B & C

COLOUR INDEX
PROPOSED ●
BOUNDARY ○
ROAD ○
SEWER LINE ○

SHEET NO: 6

SCALE 1" = 8'0" DATE: 25. 7. 95

Architects:
VIJAY & ASSOCIATES
No. 17 Ramasamy Street,
T. Nagar Madras - 17.

PROPOSED BUILDING FOR HIGHER SECONDARY SCHOOL AT S.NO: 404/2A, 413/1TD 7, 414/1, 415/VILLAGE NO: 78, POONTHANDALAM - DHARAKASTI, SRIPERUMPUDUR TALUK, CHENGAI M.G.B. DISTRICT, MADRAS 44 FOR MR.

APPLICANT: *K. Mohan Kumar* o/c

LICENSED BUILDING SURVEYOR:

K. Venigopal
 Dr. K VENIGOPAL, I.A.S.
 CORPORATION OF MADRAS
 Civil & Sanitary Engineering Consultant
 Licensed Surveyor, Class 1
 Licensed Plumber
 Sewerage No. 10000 Water
 8, Neelakandan Street, Nungambakam
 Office of Corporation District Engineer, Madras 600 034
 MADRAS 600 034

BLOCK A, B. & C SHEET NO. 5

COLOUR CODE INDEX
 1. PROPOSAL


SCALE: 1" = 8' 0" DATE: 25.08.75

DRAWN: K.P.L.

Architects,
 VIJAY ASSOCIATES,
 17, Ramasamy ST,
 T. Nagar, Madras 17

- PARAPET WALL 3'0" HT
- WEATHERING COURSE
- R.C.C. ROOF SLAB IN 1:2:4 MIX
- R.C.C. COLUMN IN 1:2:4 MIX

Planning Permit No. *PP/4/33/96*
APPROVED
 Subject to the conditions in this office to
 No. *04399/96* of 10-1-96
[Signature]
 FOR MEMBER SECRETARY
 MADRAS METROPOLITAN
 DEVELOPMENT AUTHORITY

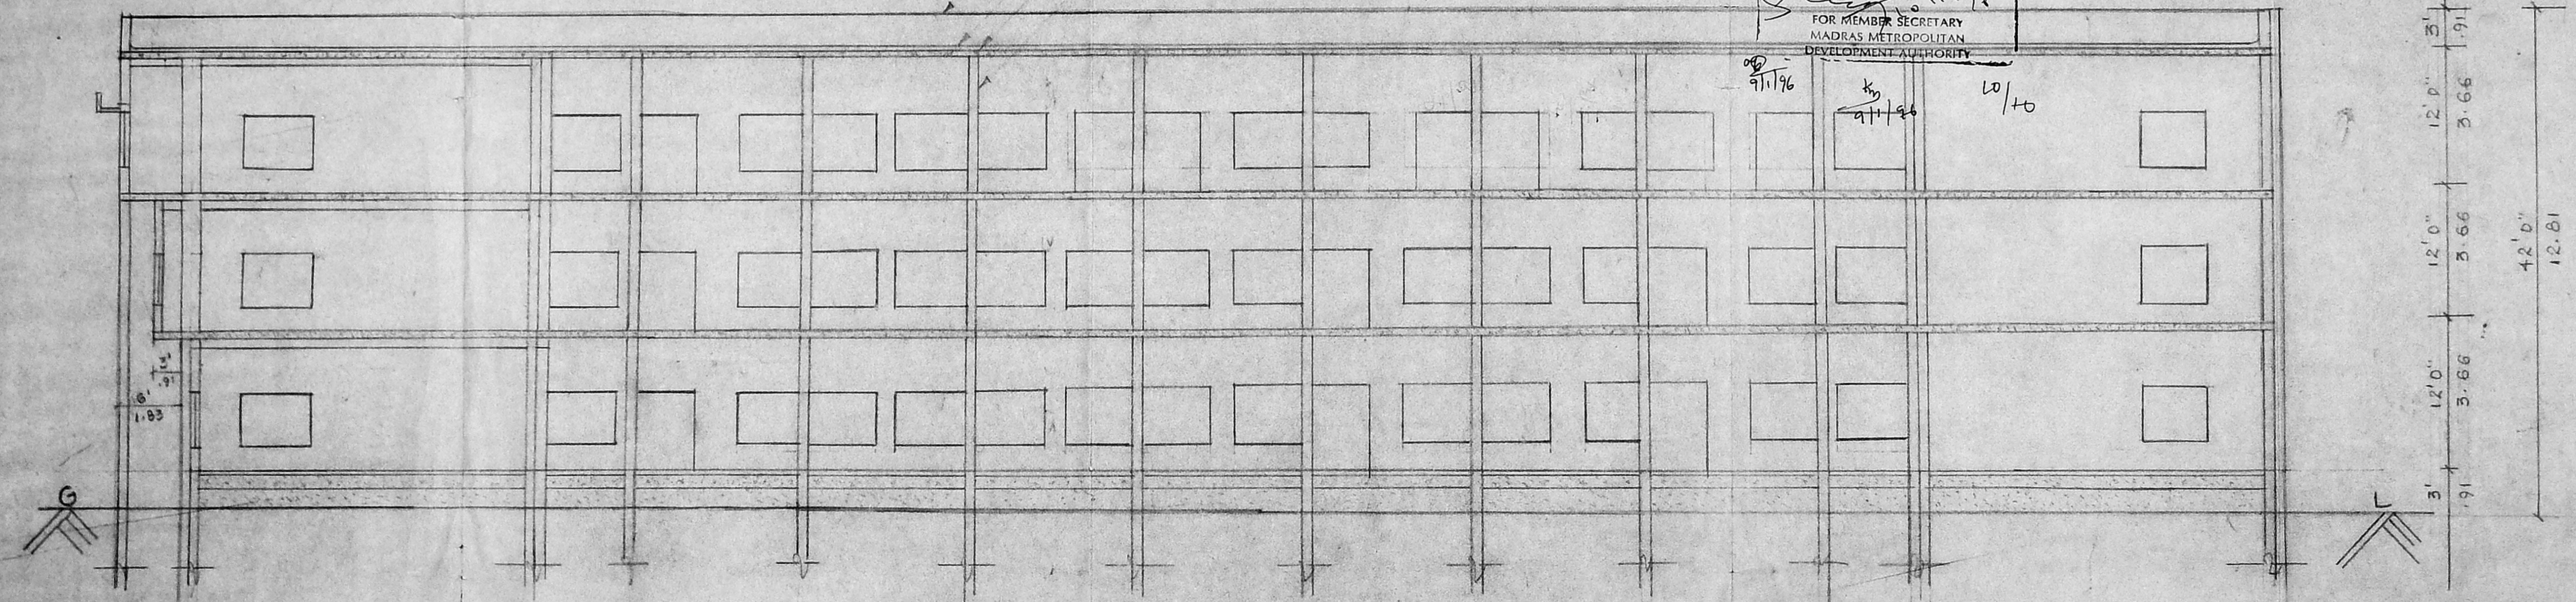

SECTION ON XX