

PLAN SHOWING THE PROPOSED CONSTRUCTION OF GODOWN CUM OFFICE BUILDING IN PLOT No. C-1, S.No. 776/1 PART AND 776/2 PART OF MADHAVARAM VILLAGE, AT MBTT COMPLEX SAIDAPET TALUK, CHENGAI M.G.R. DISTRICT. SCALE :- 1"=8'-0" (1:100)

JOINERY DETAILS

R/S ROLLING SHUTTER	3.05 X 2.44
D DOOR	1.22 X 2.13
D ₁ DOOR	0.91 X 2.13
D ₂ DOOR	0.76 X 2.13
W WINDOW	1.83 X 1.52
W ₁ WINDOW	1.22 X 1.52
V VENTILATOR	0.61 X 0.46
J R.C.C. JOLLY	0.91 X 1.83

COLOUR INDEX

PROPOSED


ROADS

SITE BOUNDARY


SEWER LINE

K.P.S. Kalyan Pillai
OWNER


W. Venugopal
CV. K. VENUGOPAL, Retd A.E.D.
CORPORATION OF MADRAS
Civil & Sanitary Engineering Consultant
Licensed Surveyor, Class-1, No. 120
Licensed Plumber, Class-1, Metro. Water
Sewerage No. Water Supply No.
8, Neelakandan Street, Nungambakkam (Lake) Road
Outside of Corporation Girls Higher Secondary School
LICENCE NO. 25/3/67

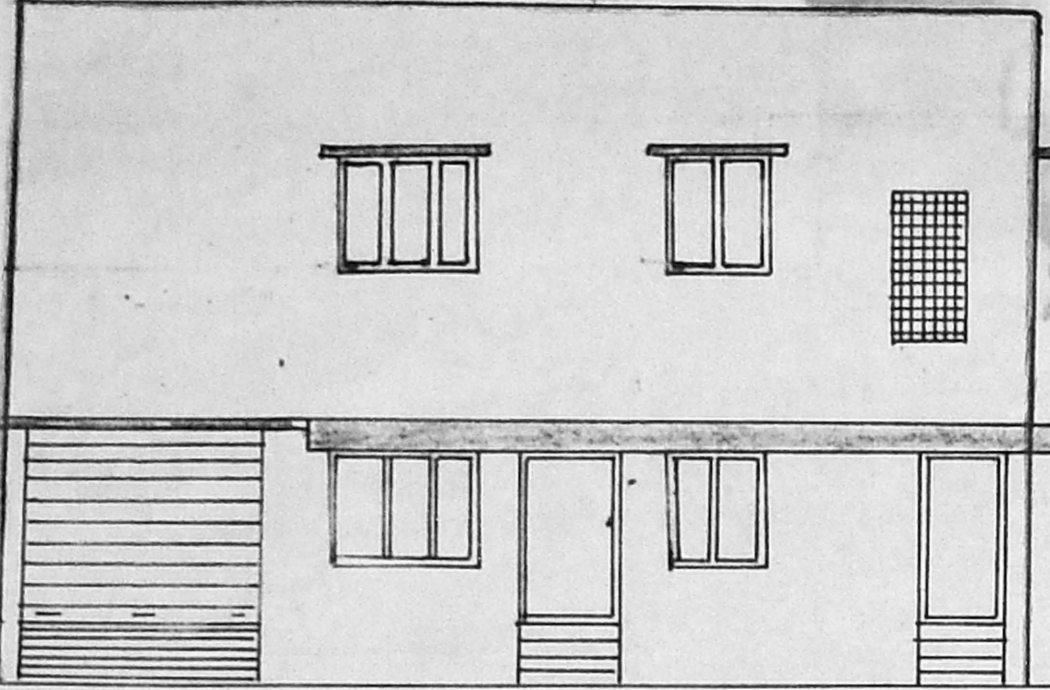


ELEVATION

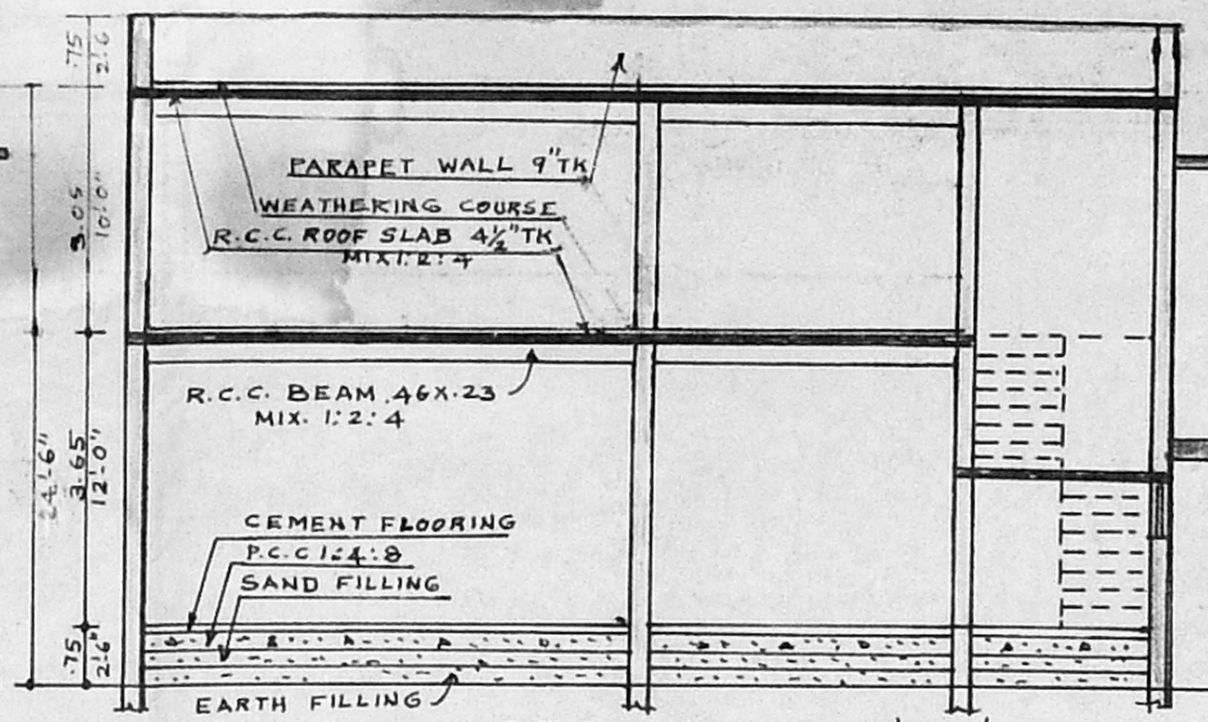


SECTION ON 'CD'

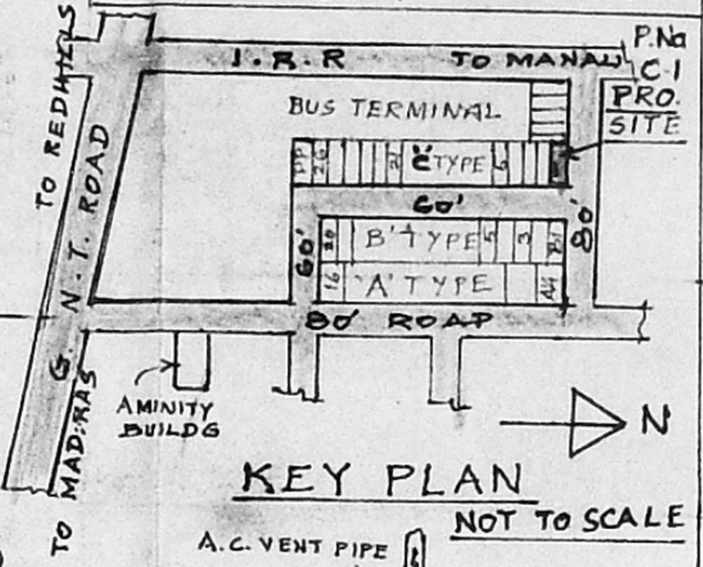


KEY PLAN NOT TO SCALE

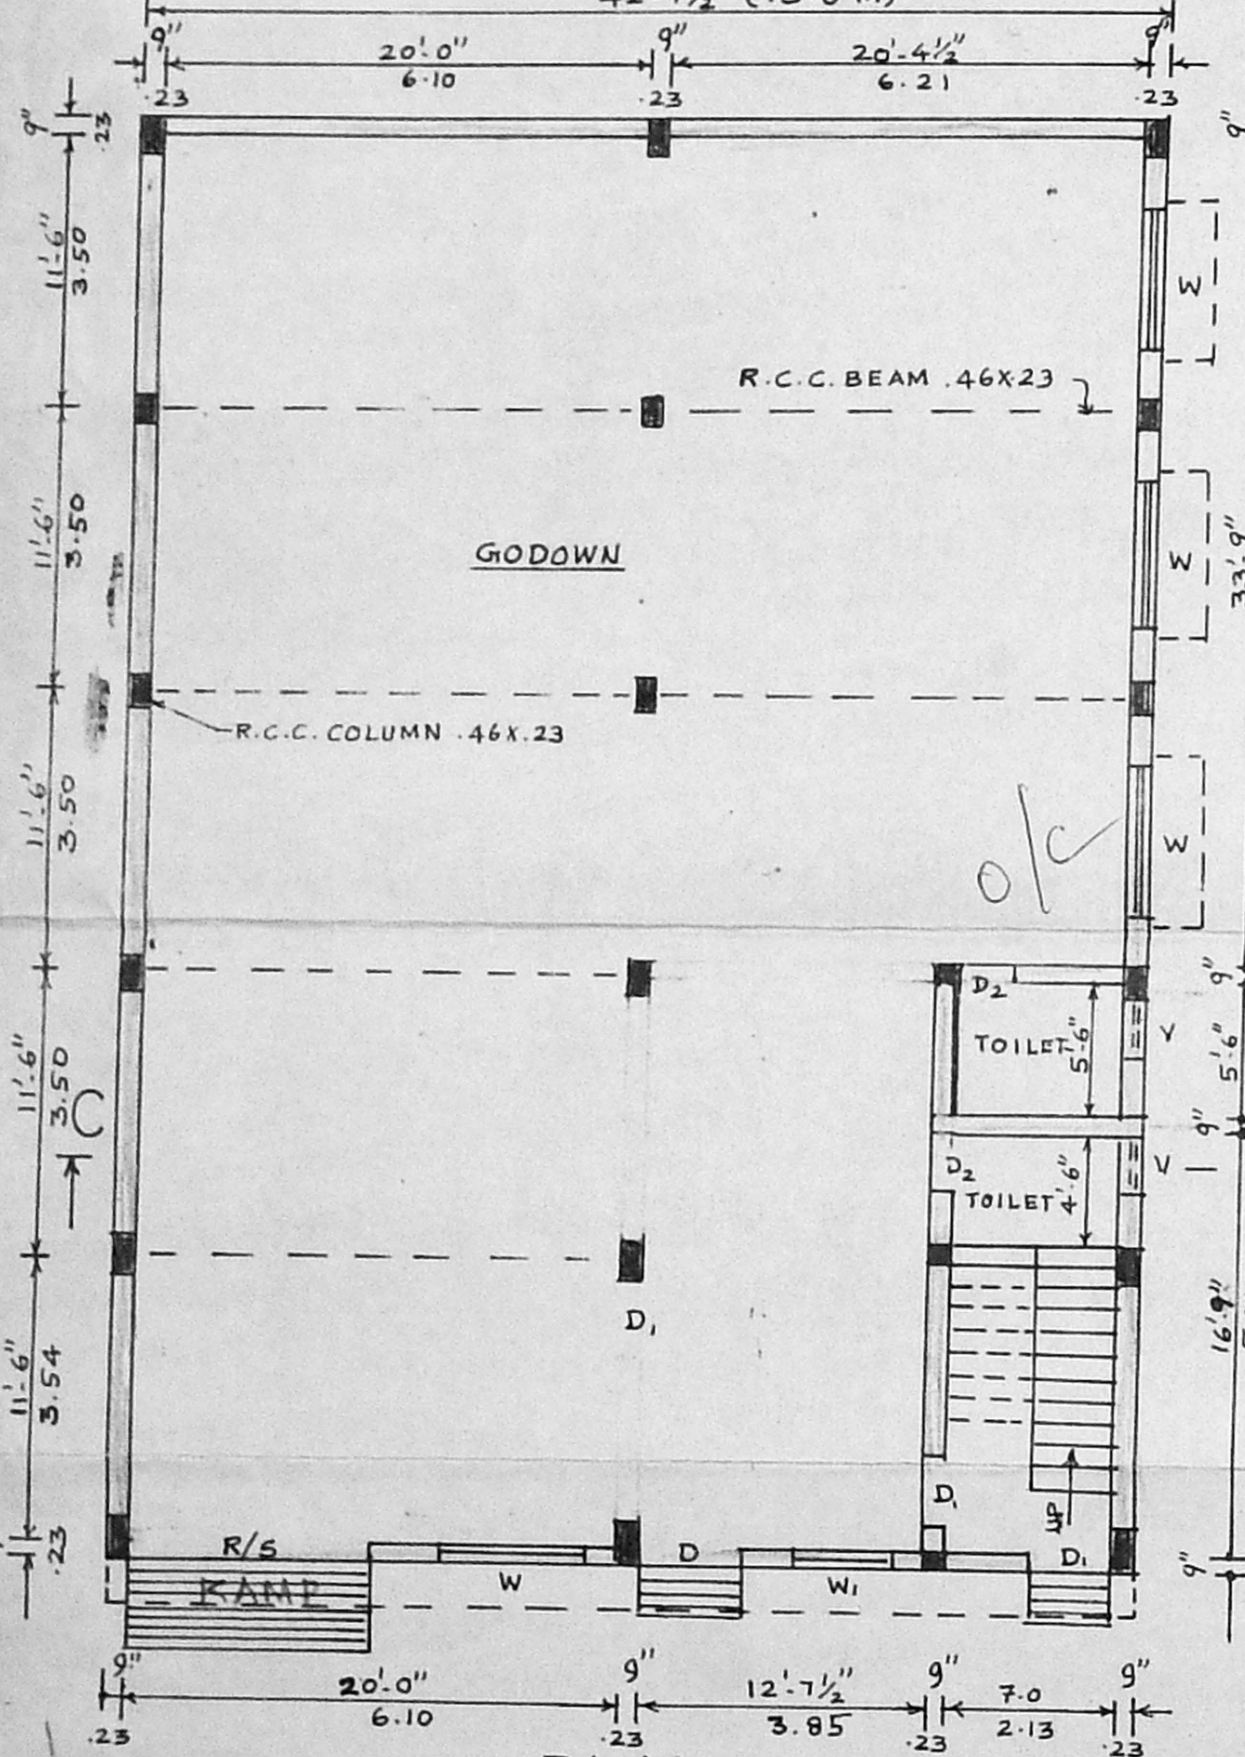

PLAN

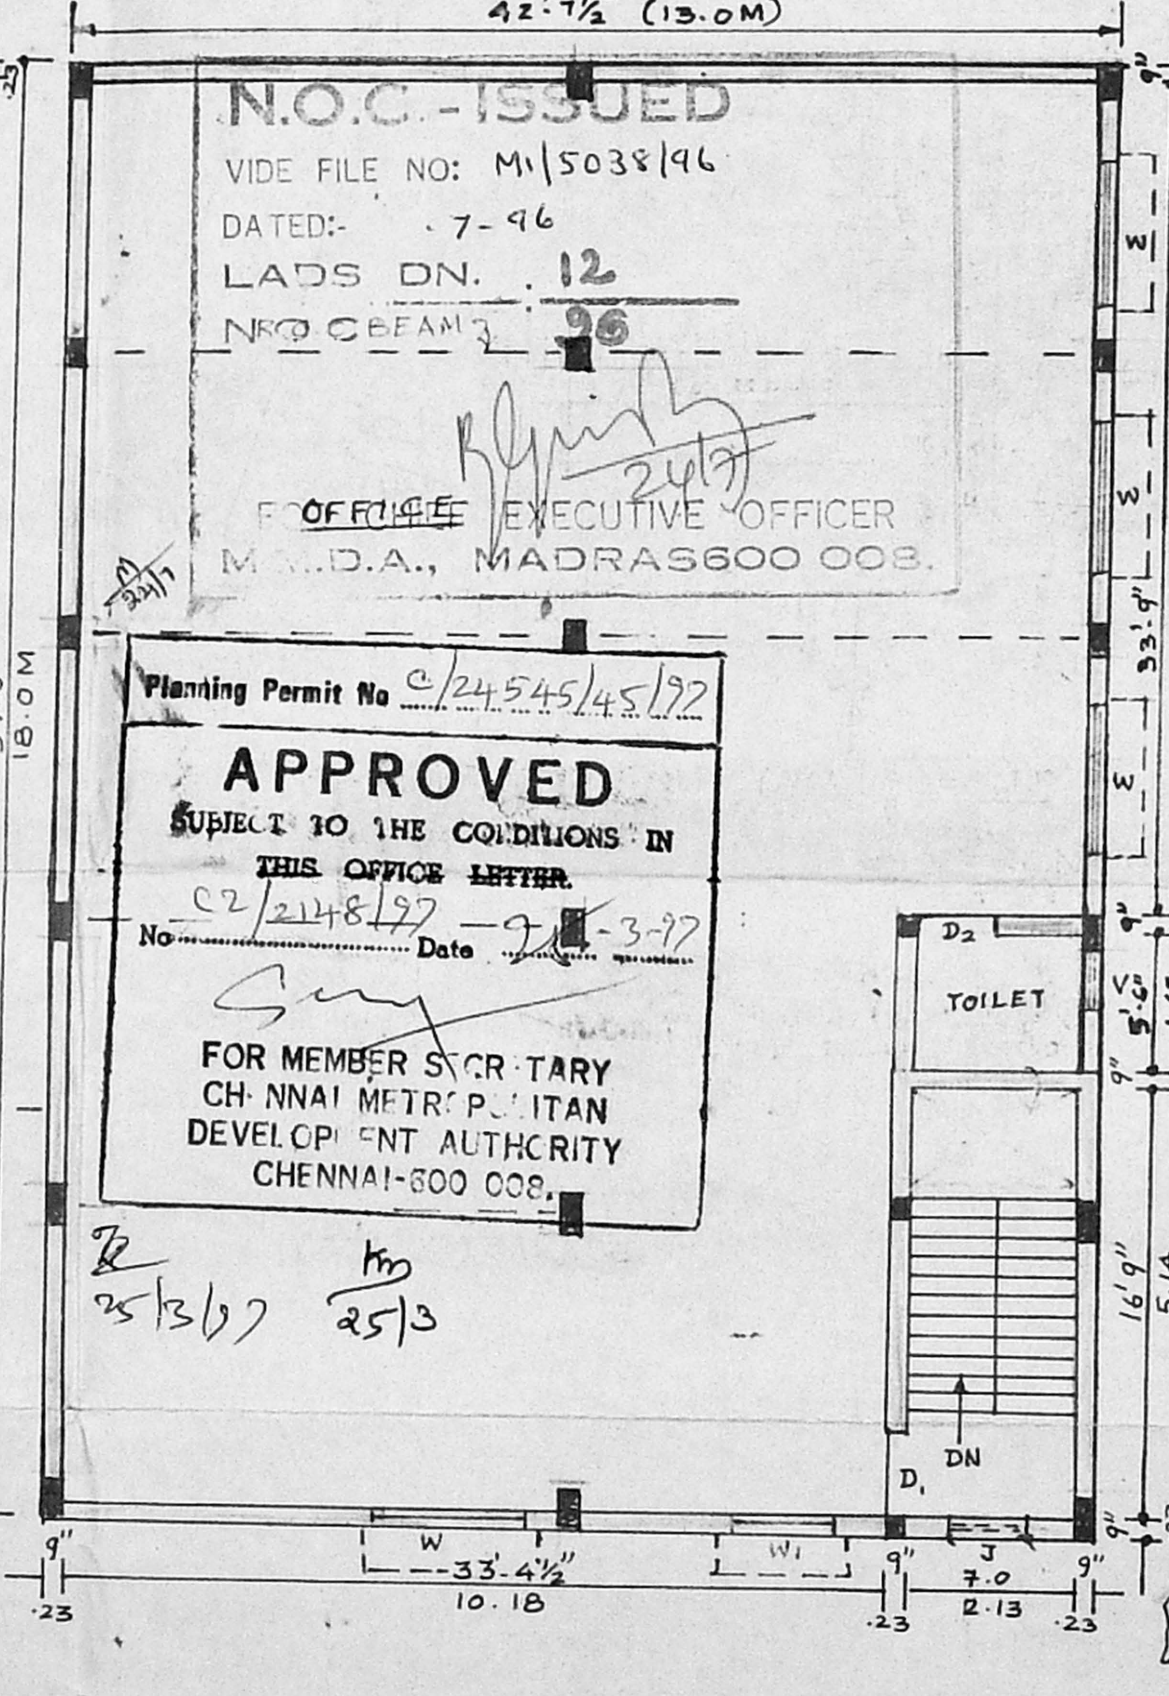


FIRST FLOOR PLAN

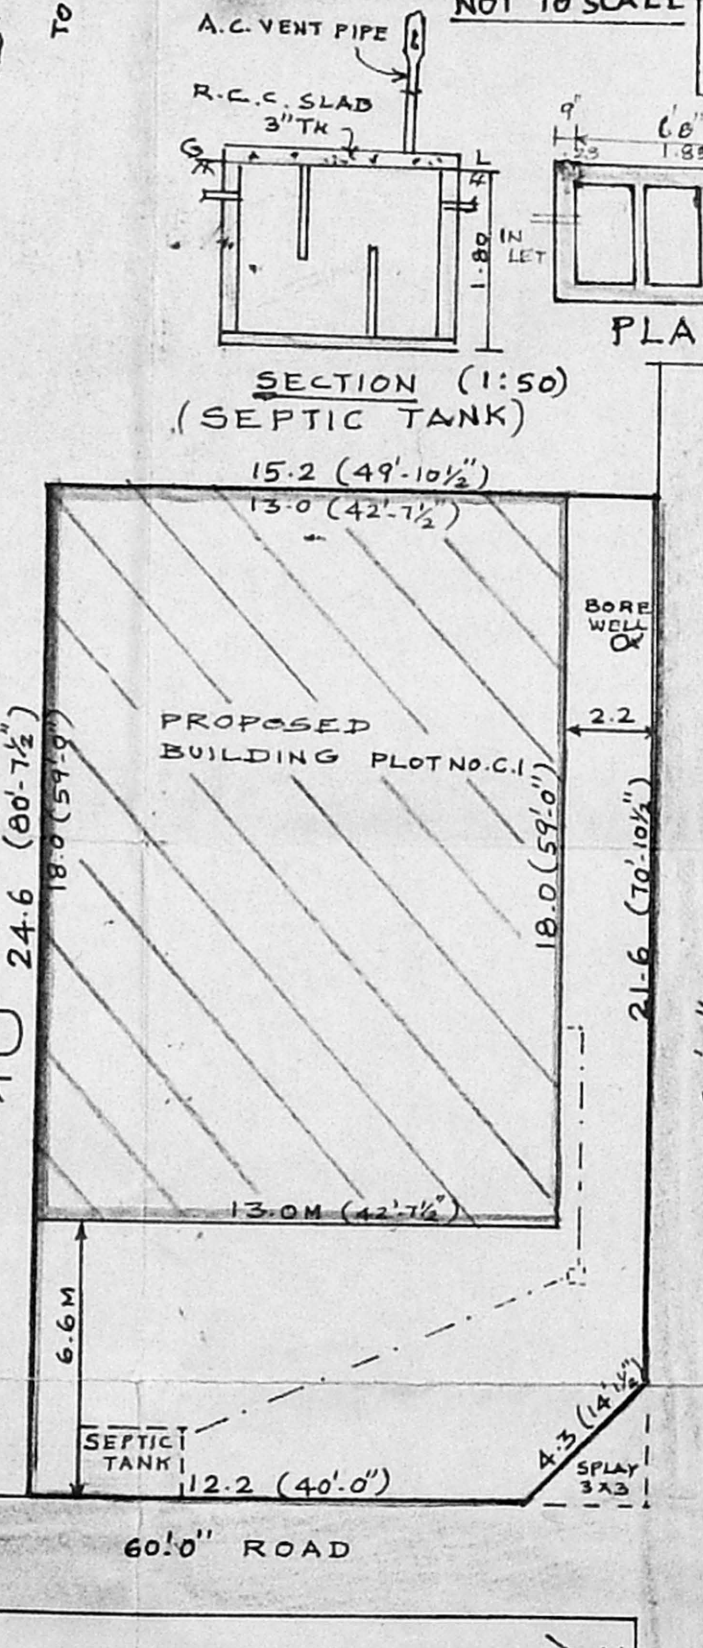


SITE PLAN SCALE :- 1"=16'-0"

N.O.C. - ISSUED
VIDE FILE NO: M/5038/96
DATED: 7-96
LADS DN. 12
NOC BEAMS 96
2019
OFFICE EXECUTIVE OFFICER
M.A.D.A., MADRAS 600 008.


Planning Permit No. C/24545/45/92
APPROVED
SUBJECT TO THE CONDITIONS IN THIS OFFICE LETTER.
No. C2/2148/92 Date 9-3-97
Surya
FOR MEMBER SECRETARY
CHENNAI METROPOLITAN
DEVELOPMENT AUTHORITY
CHENNAI-600 008.

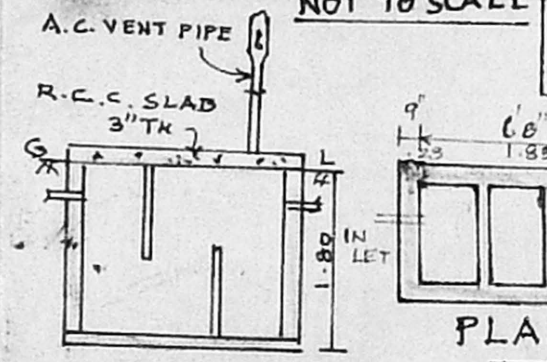

SECTION (1:50) (SEPTIC TANK)

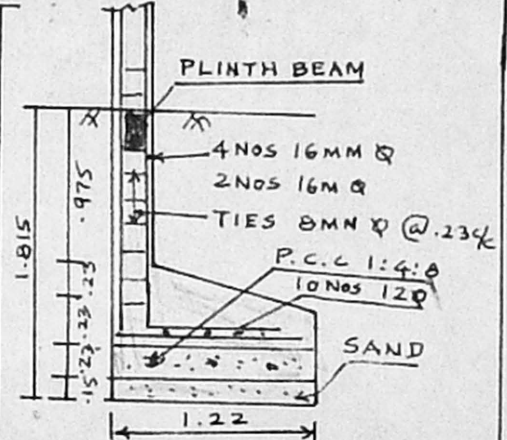

FOUNDATION DETAILS R.C.C. (9'x18") COLUMN

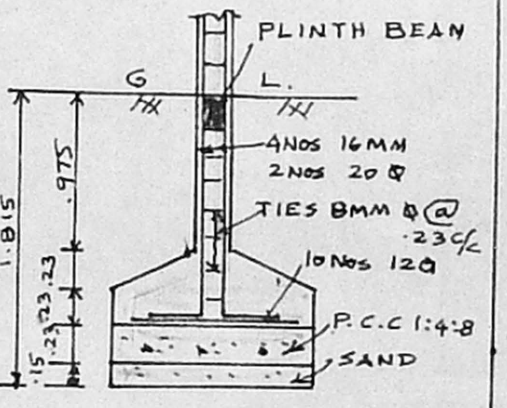

FOUNDATION DETAILS 9'x18" R.C.C. COLUMN

SCALE: 1"=4'-0"

AREA DETAILS
PLOT AREA = 369.27 M²
G. FLOOR = 234 M²
F. FLOOR = 234 M²
COVERAGE = 63%
F.S.I = 1.27