



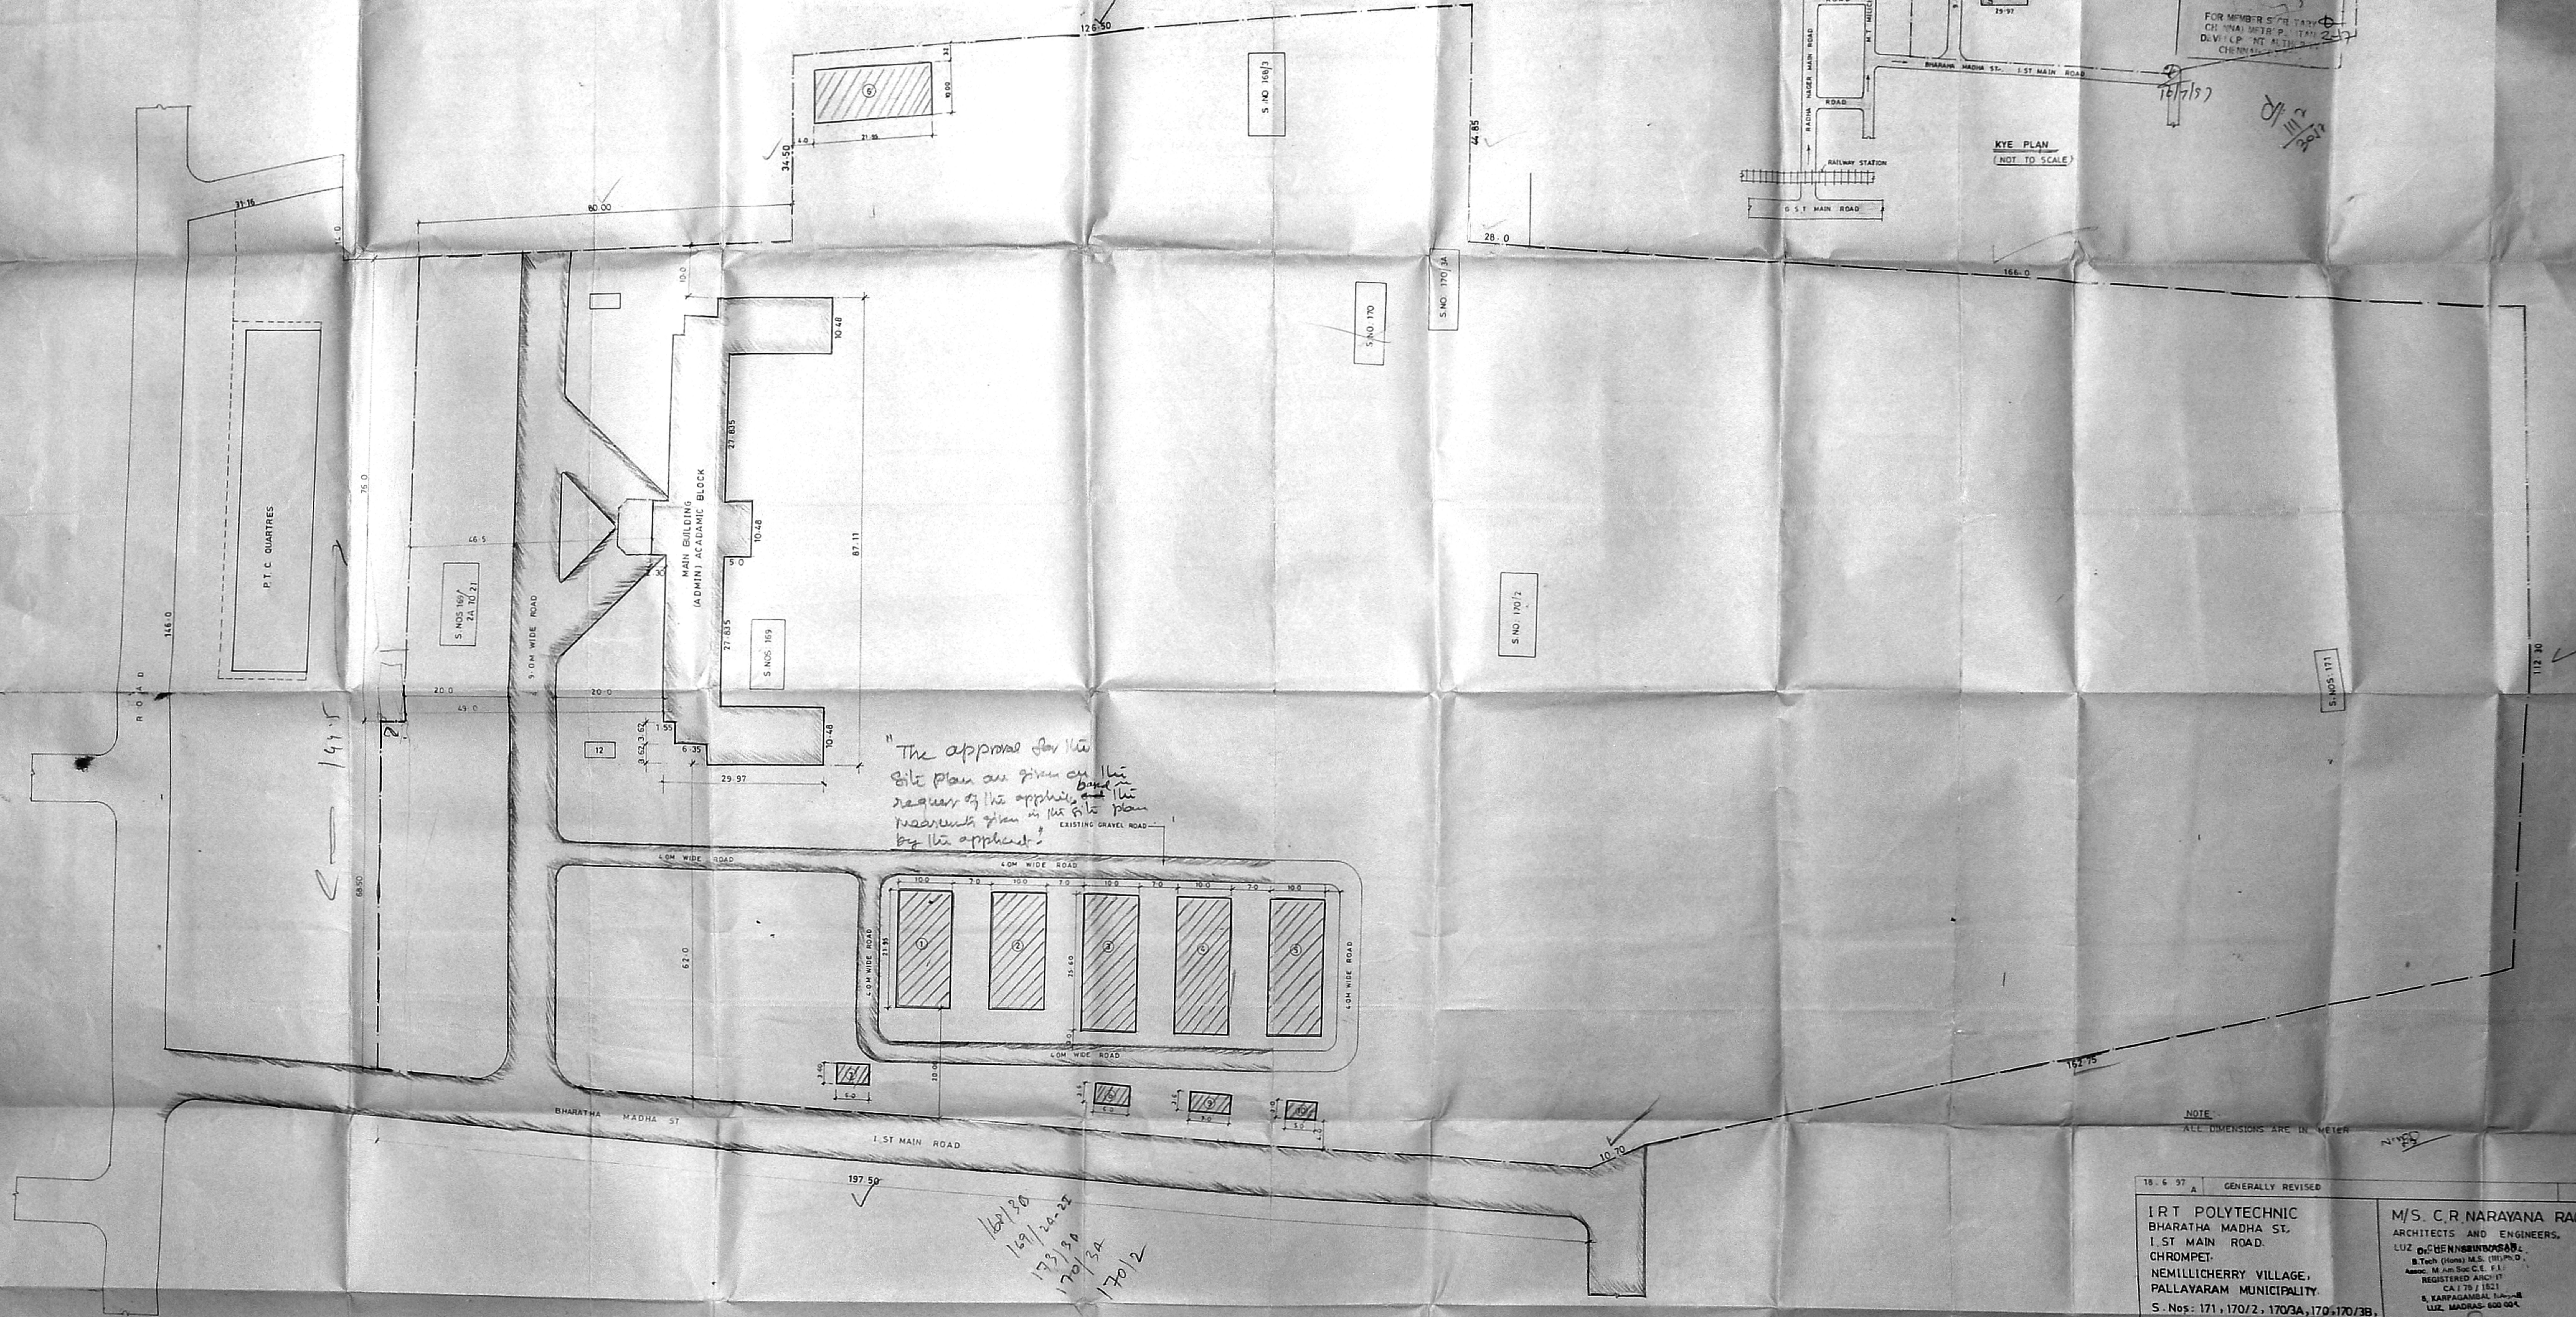

INDEX NO	CLASSIFICATION	DESCRIPTION
1.	CLASS ROOM OFFICE	A. C. ROOFING
2.	CLASS ROOM & COMPUTER	A. C. ROOFING
3.	CLASS LABS & STAFF ROOM	A. C. ROOFING
4.	WORKSHOP	A. C. ROOFING
5.	CLASS ROOM & ELECTRICAL LAB	A. C. ROOFING
6.	CLASS ROOM	A. C. ROOFING
7.	GENERATOR ROOM	R. C. ROOFING
8.	GIRLS TOILET	A. C. ROOFING
9.	BOYS TOILET	A. C. ROOFING
10.	SEPTIC TANK	R. C. ROOFING
11.	MAIN BUILDING	R. C. ROOFING
12.	SEPTIC TANK	R. C. ROOFING

RED PROPOSED - [Hatched Box]
 RED EXISTING - [Diagonal Lines Box]
 GREEN ROAD - [Solid Box]
 BLACK BOUNDRY - [Dashed Box]

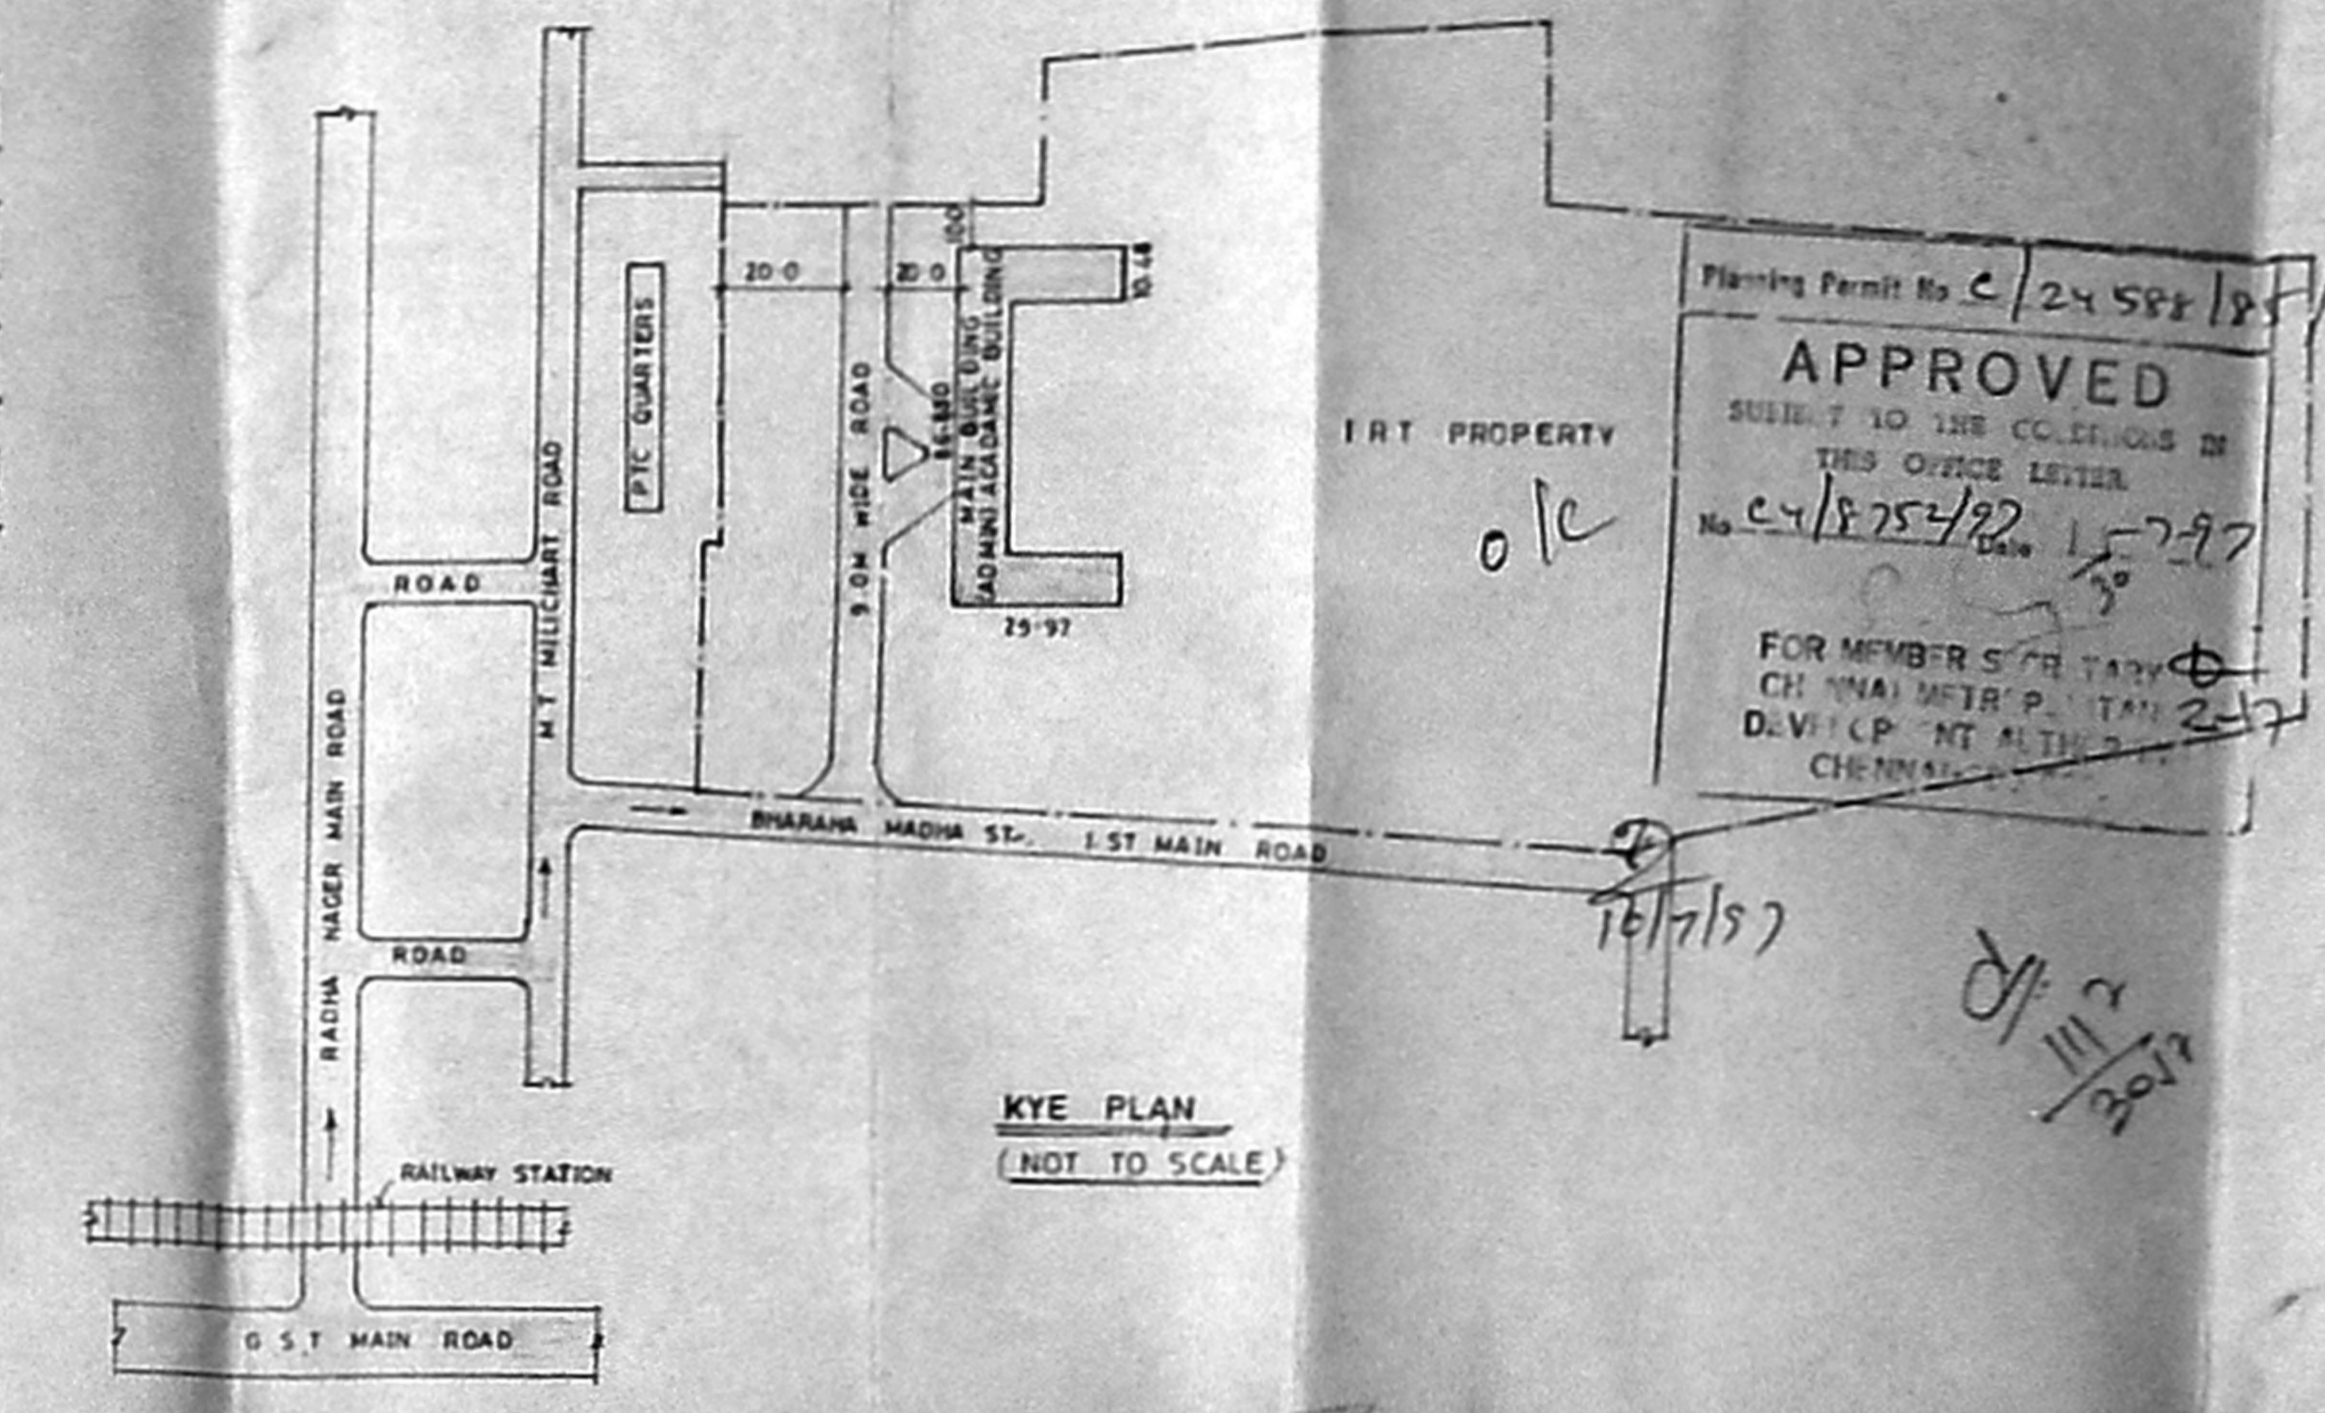

"The approval for the site plan are given on the basis of the request of the applicant and the requirements given in the site plan by the applicant."


169/20
 169/20-21
 170/20
 170/21
 170/22

NOTE:
 ALL DIMENSIONS ARE IN METERS

APPLICANT SIGNATURE
 M. S. C. R. NARAYANA RAO
 INSTITUTE OF ROAD TRANSPORT POLYTECHNIC
 Chrompet, Madras-44

18.6.97 A GENERALLY REVISED	
IRT POLYTECHNIC BHARATHA MADHA ST. 1 ST MAIN ROAD CHROMPET. NEMILICHERRY VILLAGE, PALLAYARAM MUNICIPALITY. S. Nos: 171, 170/2, 170/3A, 170-170/3B, 169/2A TO 21, 168/3B, 168/1, 169/3.	
M/S. C. R. NARAYANA RAO. ARCHITECTS AND ENGINEERS. LUZ CHENNAI B. Tech. (Hons) M.S. (ILL) PHD. ASSOC. MAM. SOC. CE. FIE. FIV. REGD. ARCHITECT. CA 170/1821 8, RAJFAGANBIL, T. Nagar LUZ, MADRAS-600 004	
SITE DEVELOPMENT PLAN PROPOSED ACADEMIC BUILDING	
DRAWN: Deva CHECKED:	SCALE: 1:400 DATE: 12.3.97
SYSTEM FILE NAME - MANUAL REGISTER NO. - MD 2677/97 PROJECT TITLE - IRT	

85X.62
o/c
①

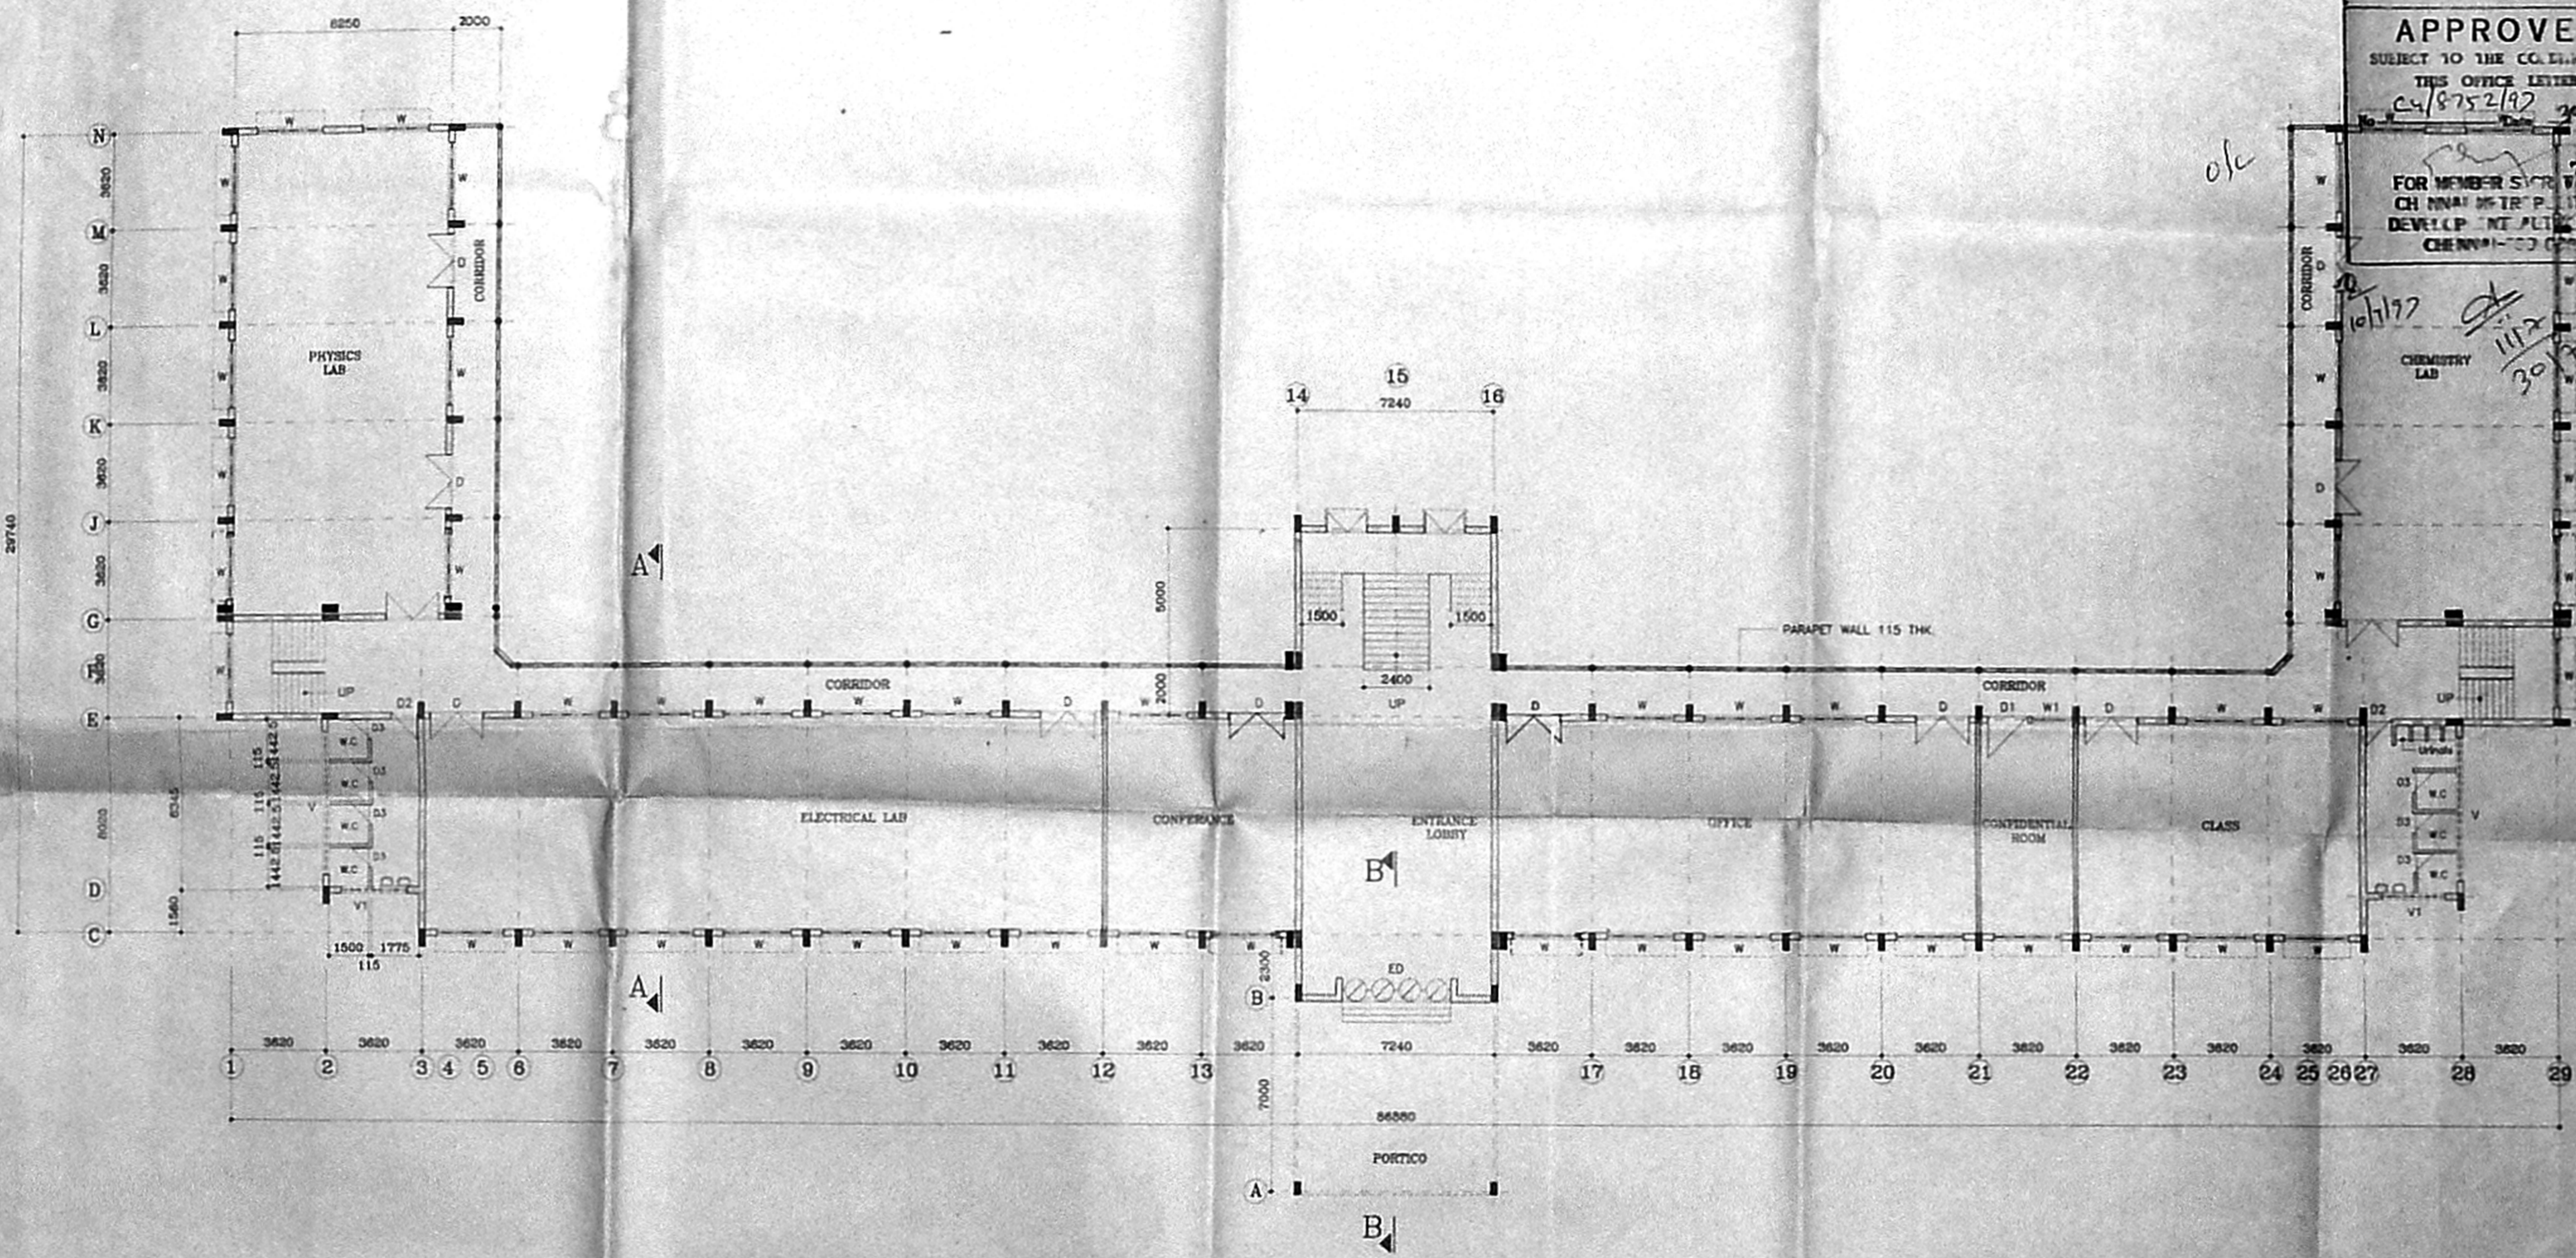

Planning Permit No. C/24588/85/B/L/97
APPROVED
 SUBJECT TO THE CONDITIONS IN THIS OFFICE LETTER.
 C/18752/97 20-7-97
 FOR MEMBER SVR. VARY CH. NNAY. NTR. P. LITAN DEVELOP. IN PLANNING CHENNAI-600 007

Schedule of joinery

D	DOOR	2000 X 2100
D1	DOOR	1500 X 2100
D2	DOOR	1000 X 2100
D3	DOOR	750 X 2100
W	WINDOW	2500 X 1500
W1	WINDOW	1600 X 1500
V	VENTILATOR	5345 X 750
V1	VENTILATOR	2500 X 750

Notes

ALL DIMENSIONS ARE IN MM.
 FOR SECTION & ELEVATION REF. DWG. NO. 07/1844 & 1844/97

GROUND FLOOR PLAN

A	17.6.97	GENERALLY REVISED
CLIENT	INSTITUTE OF ROAD TRANSPORT	
PROJECT	IRT POLYTECHNIC	
TITLE	GROUND FLOOR PLAN	
DATE:	19-02-97	DRAWN: A.N.
SCALE:	1:150	CHECKED:
M/S. C.R.NARAYANA RAO, ARCHITECT & ENGINEERS REGISTERED ARCHITECT LUZ, CHENNAI - 4. CA / 75 / 1521 B, KARPAGAMBAL NAJAR LUZ, MADRAS-600 007		
ASSISTANT ENGINEER (CIVIL) INSTITUTE OF ROAD TRANSPORT POLYTECHNIC Chromebot, Madras-44.		
B.TECH(HONS), M.S.(LL), PH.D., ASSOC. MAM., SOCC., C.E., F.I.E., F.I.V., REGD.Architect.		
SYSTEM FILE NAME:	4 /IRT-P	
REGISTER NAME:	ZH/ 1844 /97	
PROJECT DWG.NO:	IRT-A-001.	

84.7x61 o/c

Planning Permit No. C/24538/SS/C/L/97


APPROVED

SUBJECT TO THE CONDITIONS IN THIS OFFICE LETTER


No. C/875492/2-7-97

[Signature]


FOR MEMBER SECRETARY
CHENNAI METROPOLITAN
DEVELOPMENT AUTHORITY
CHENNAI-600 088.

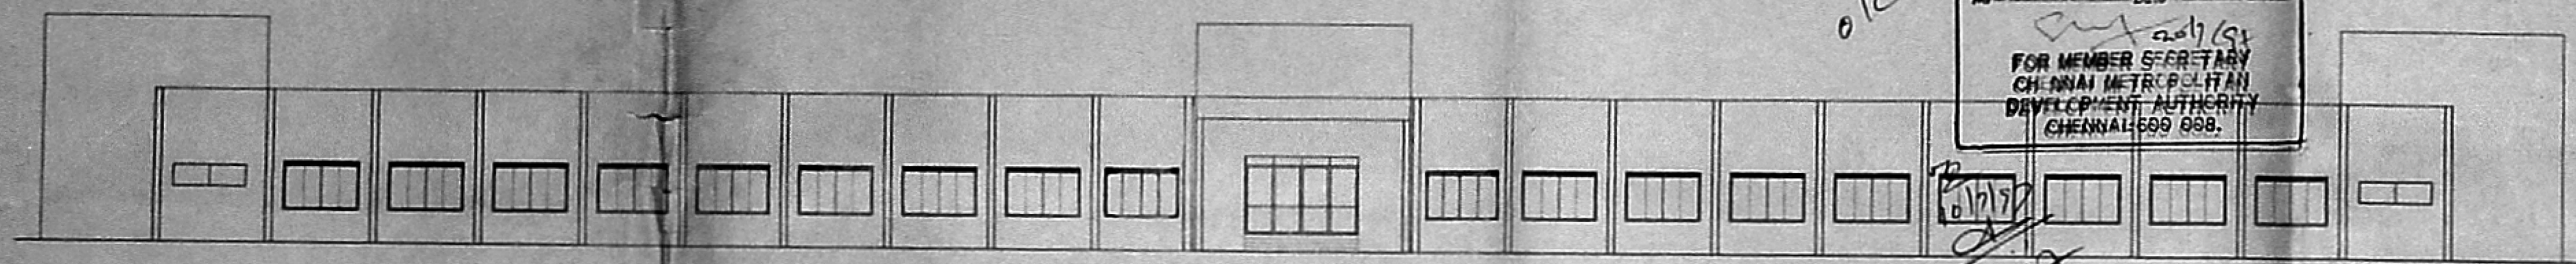

ELEVATION

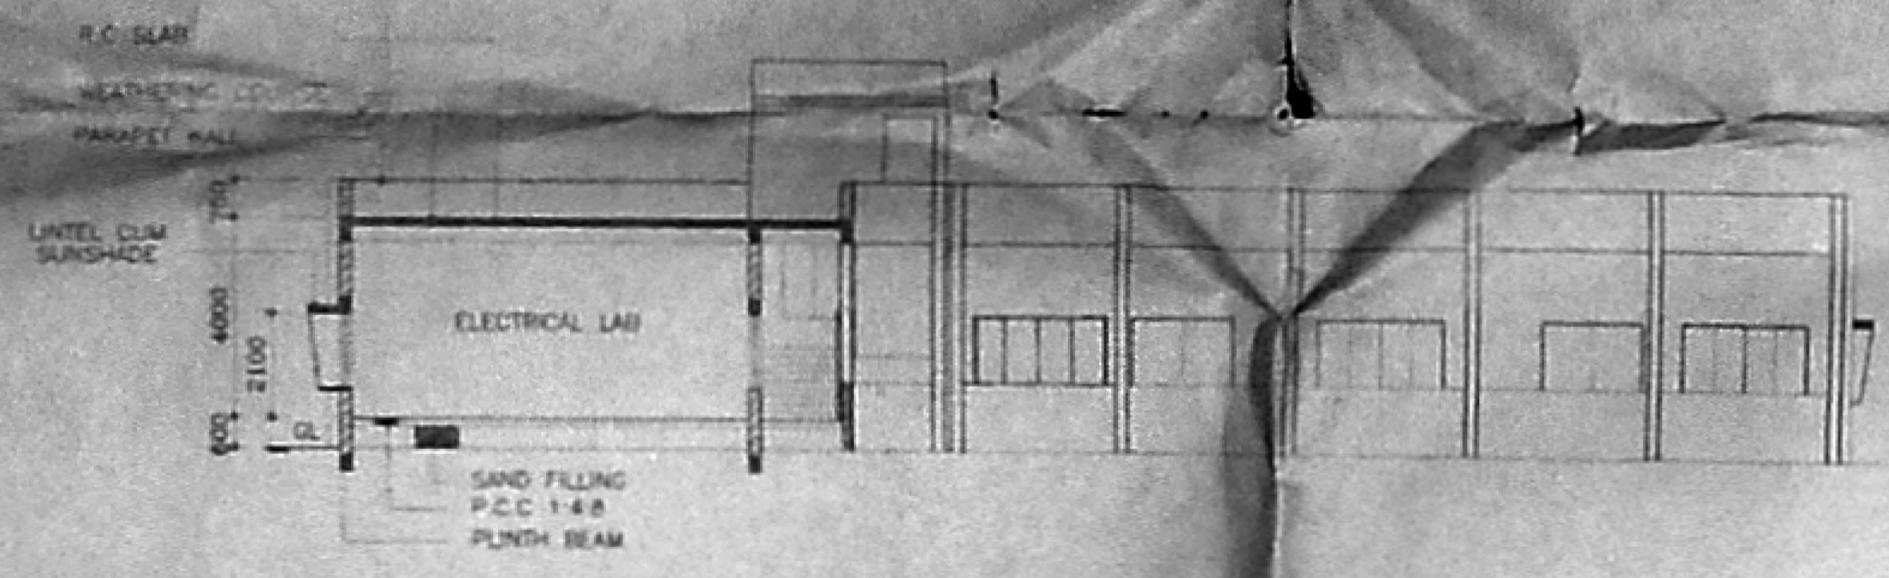

SECTION A-A

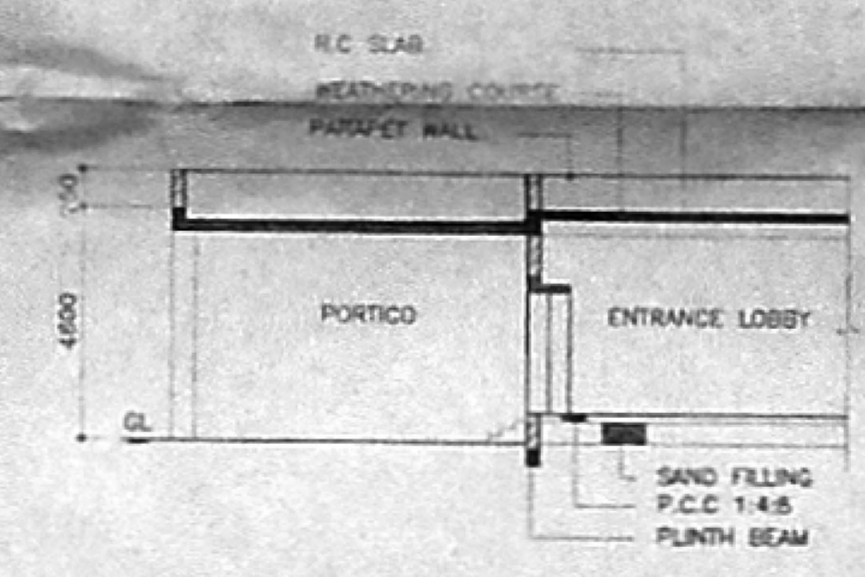

SECTION B-B

Notes

- ALL DIMENSIONS ARE IN MM
- FOR ARCH.PLAN REF.DWG.NO.ZH/1844/97

A/17.6.97	GENERALLY REVISED
CLIENT	INSTITUTE OF ROAD TRANSPORT
PROJECT	IRT POLYTECHNIC
TITLE	SECTION & ELEVATION
DATE: 19-02-97	DRAWN: A.N.
SCALE: 1:150	CHECKED:
M/S. C.R.NARAYANAIAH ARCHITECT & ENGINEERS REGISTERED ARCHITECT LUZ, CHENNAI - 4. CA 175 71621 B, KARPAGASDAL NA-SAP LUZ, MADRAS-600 061	
Assistant Engineer (Civil) INSTITUTE OF ROAD TRANSPORT POLYTECHNIC Chromebet, Madras-44	
B.TECH(HONS), M.S(ILL), PH.D., ASSOC. MAN. SOCC., C.E., F.A.E. F.A.V., REGD ARCHITECT.	
SYSTEM FILE NAME: 4 /IRT-E	
REGISTER NAME: ZH/ 1846 /97.	
PROJECT DWG.NO: IRT-A-003	

[Signature]

Assistant Engineer (Civil)
INSTITUTE OF ROAD TRANSPORT
POLYTECHNIC
Chromebet, Madras-44

STX 42-3


Planning Permit No C/24588/85/B/L/97

APPROVED


SUBJECT TO THE CONDITIONS IN THIS OFFICE LETTER.

C-1/8752/22, 30-7-97

FOR MEMBER SECRETARY
CHENNAI METROPOLITAN
DEVELOPMENT AUTHORITY
CHENNAI-600 002.

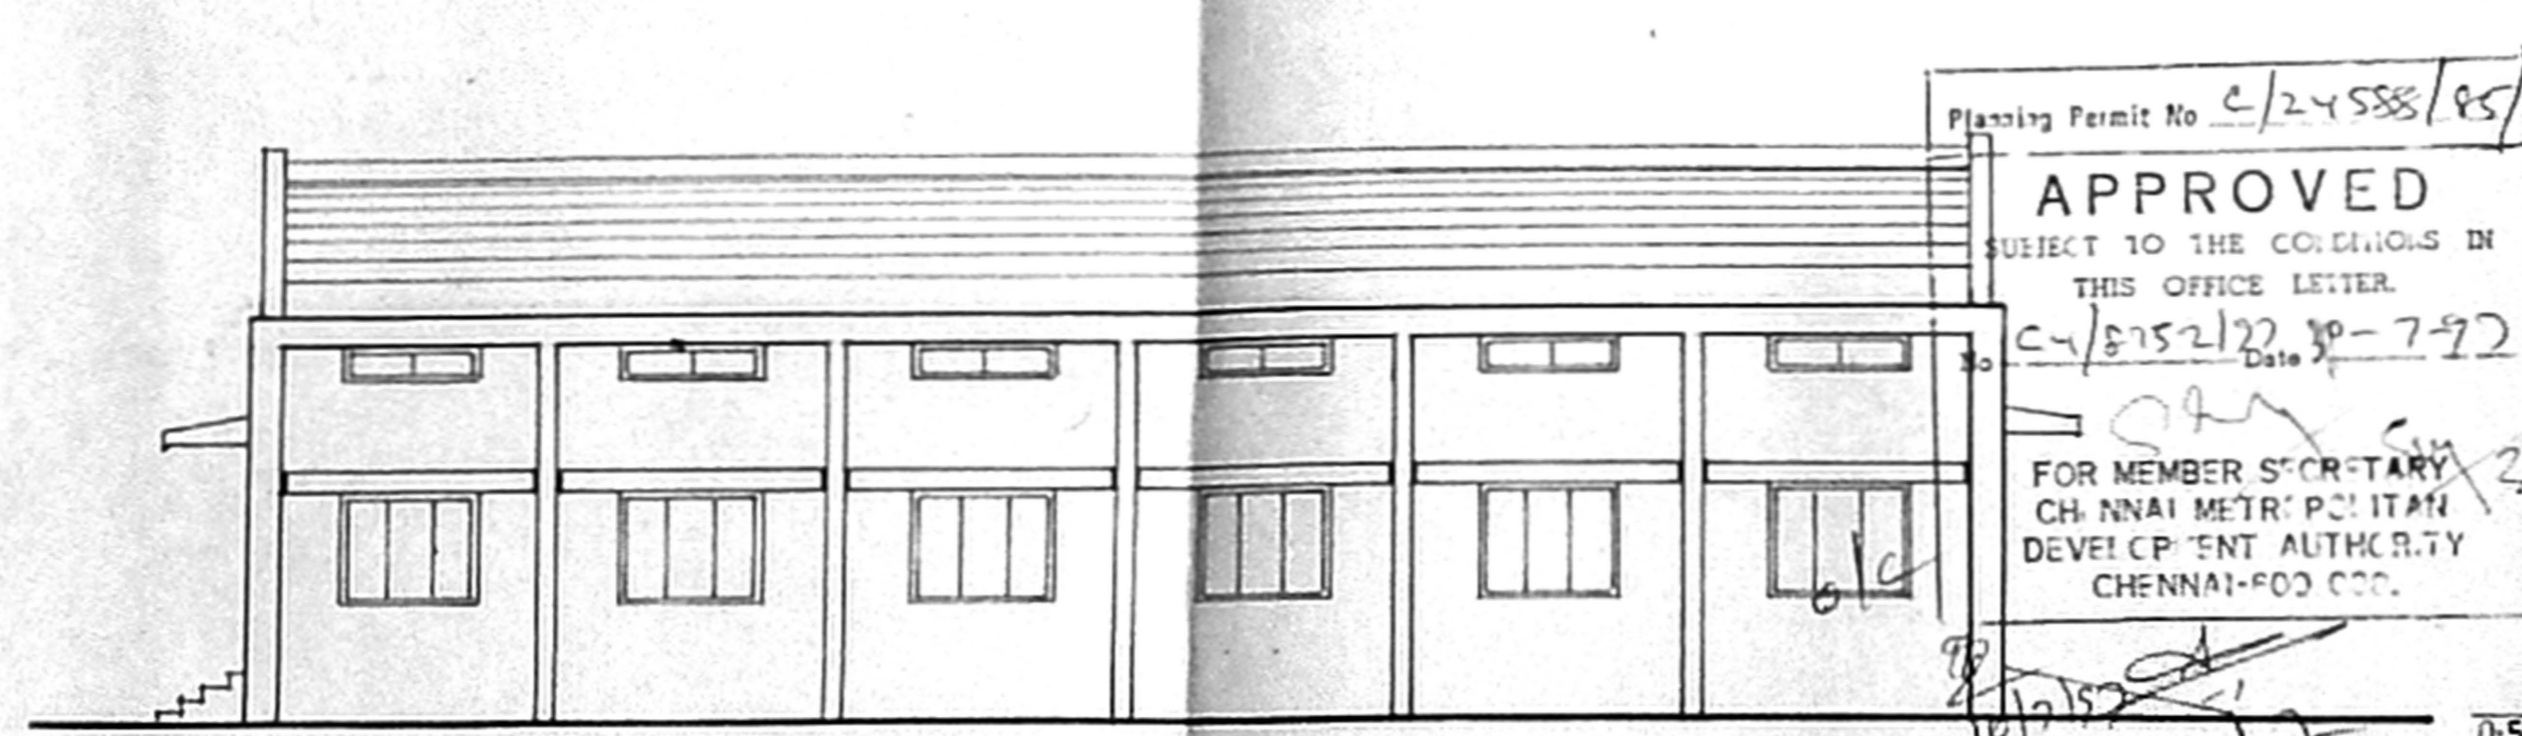


SIDE ELEVATION

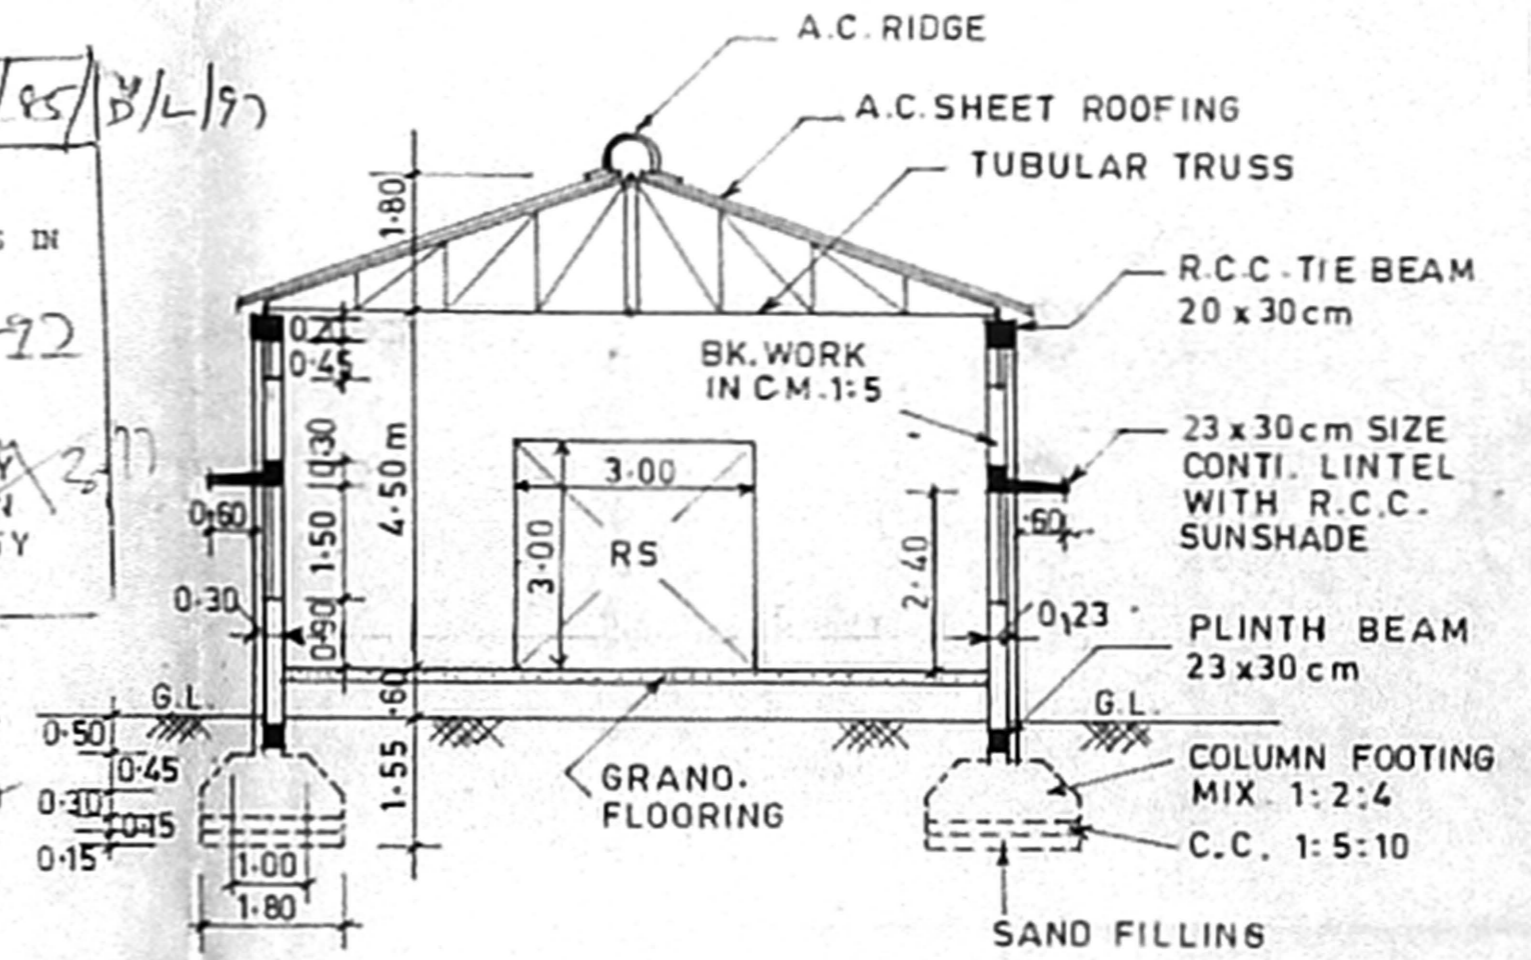

CROSS SECTION ON A/A

REF

- RS - ROLLING SHUTTER - 3.00 x 3.00 m
- W - WINDOW (STEEL) - 1.80 x 1.50 m
- V - VENTILATOR (R.C.C. JALLI) - 1.80 x 0.45 m

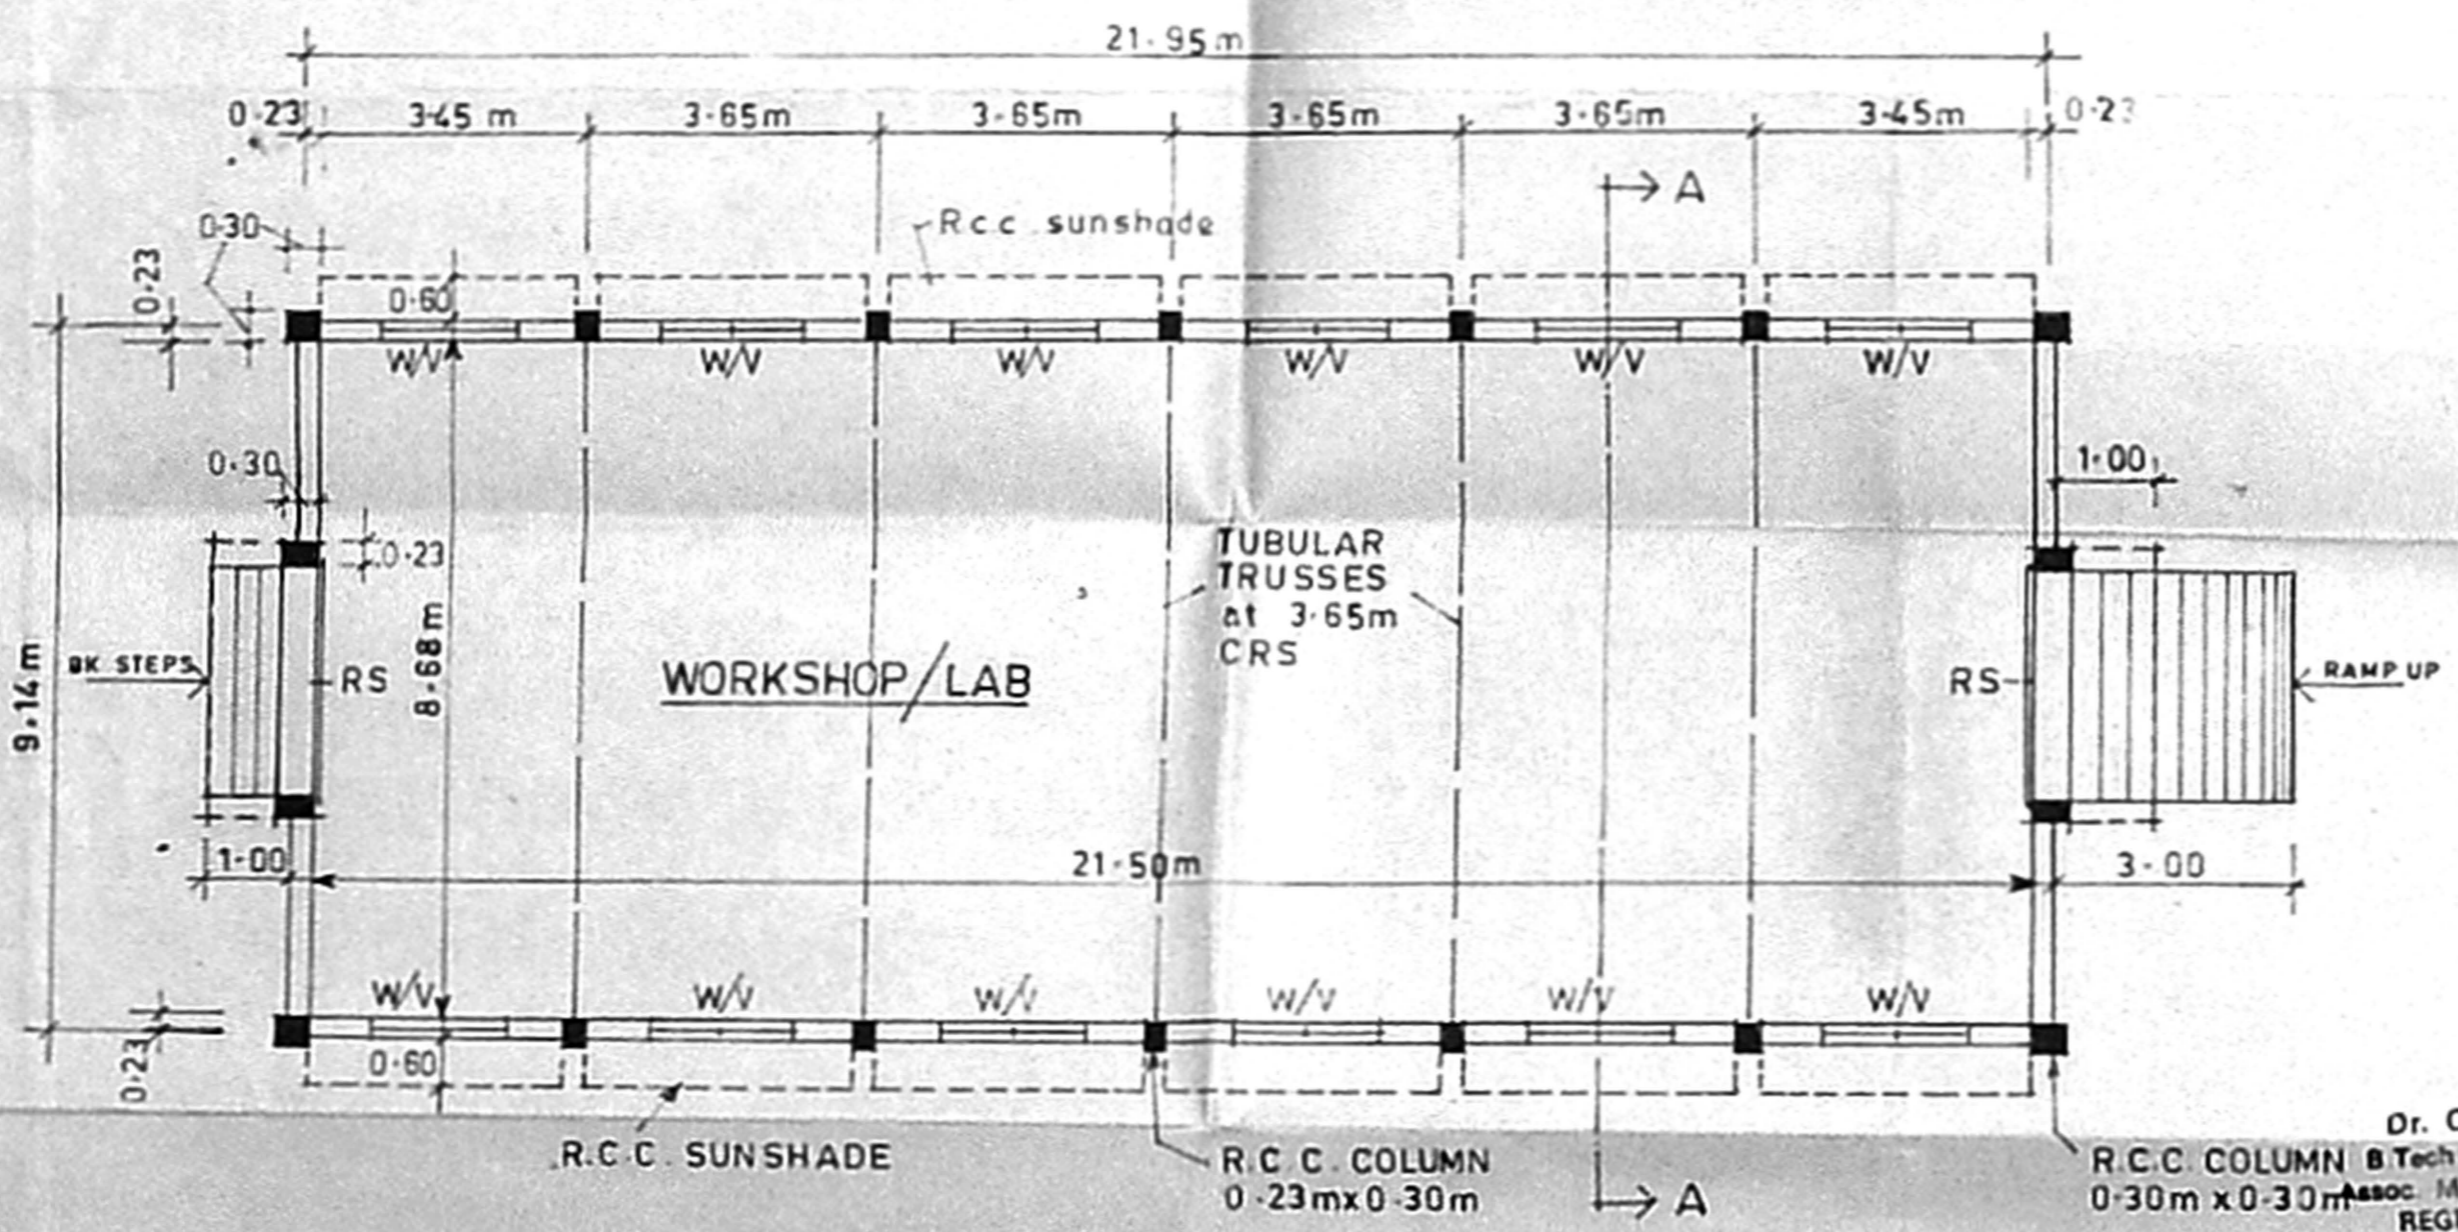

PLAN

All Dimensions are in Metres

Dr. C. N. SRINIVASAN
B.Tech (Hons) M.S. (III) Ph.D.,
Assoc. Mem. Soc. C.E. F.I.E. F.I.V.
REGISTERED ARCHITECT
CA/75/1521
6, KARPAGAMBAL NAJAP
LIIZ, MADRAS-600 007


N. J. S.
Assistant Engineer (Civil)
INSTITUTE OF ROAD TRANSPORT
POLYTECHNIC
CHROMPET, Madras 44

IRT - POLYTECHNIC

DATE	TITLE: PROPOSED CONSTRUCTION OF WORKSHOP SHED IN IRT POLYTECHNIC CAMPUS AT CHROMPET, NEMILlicherry VILLAGE, PALLAVARAM MUNICIPALITY. S. Nos: 171, 170/2, 170/3A, 170, 173/3B, 169, 169/2A TO 21, 168/3B, 168/1, 169/3
DRN	
TRD	


SCALE - 1:100 DRG. No.

o/c
5x43
D

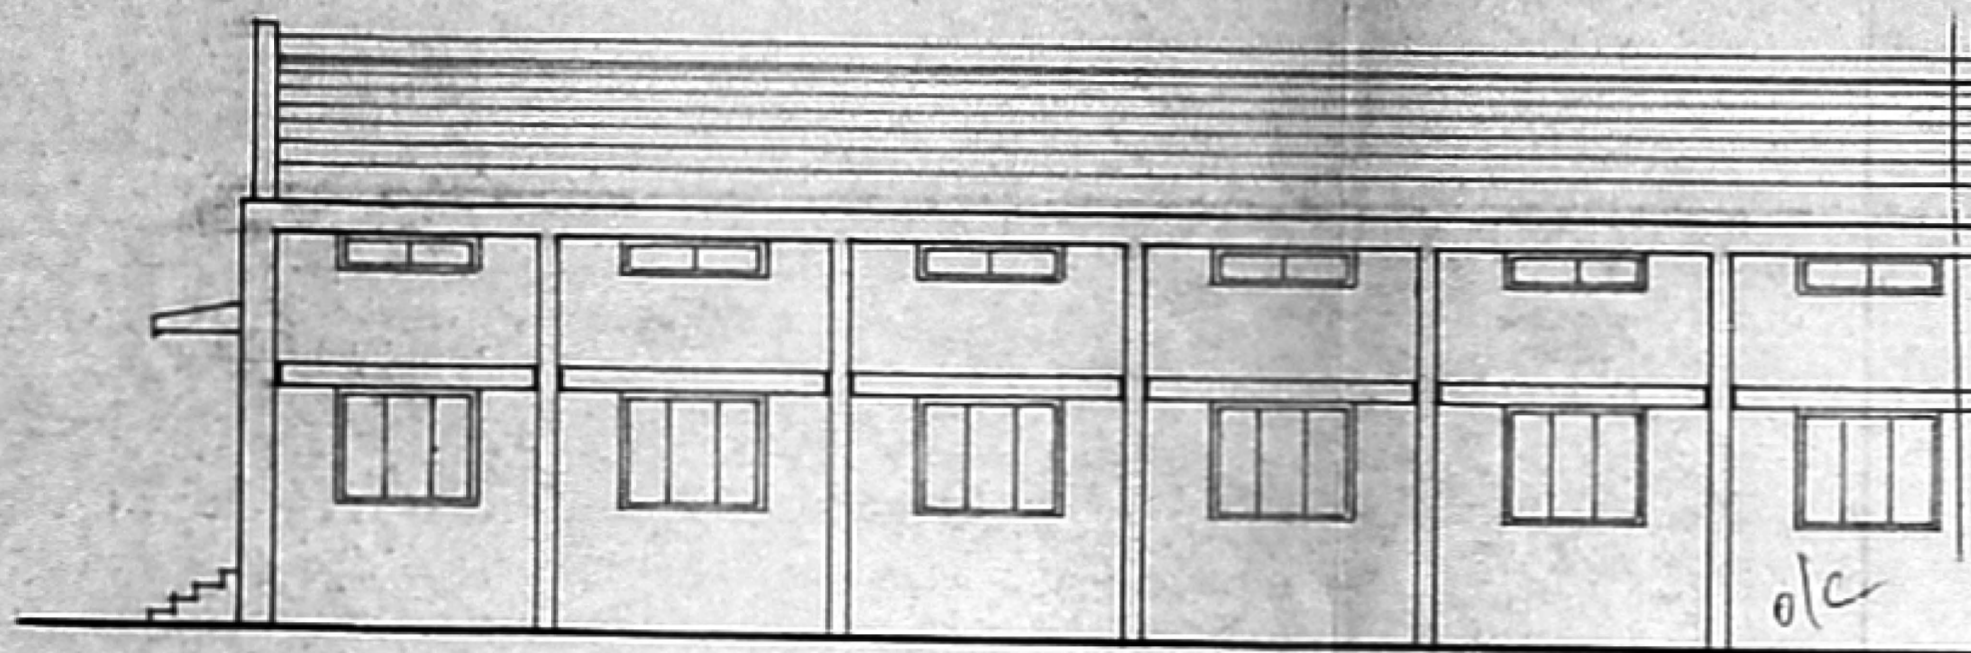


SIDE ELEVATION

Planning Permit No C/24588/85/E/197
APPROVED
 SUBJECT TO THE CONDITIONS IN THIS OFFICE LETTER.
 No. C/418754/82 Date 30-7-97
 FOR MEMBER SECRETARY
 CHENNAI METROPOLITAN DEVELOPMENT AUTHORITY
 CHENNAI-600 006.
 o/c
 16/1/97
 11/7
 3-17
 20/7/97
 0-50
 0-30
 0-15

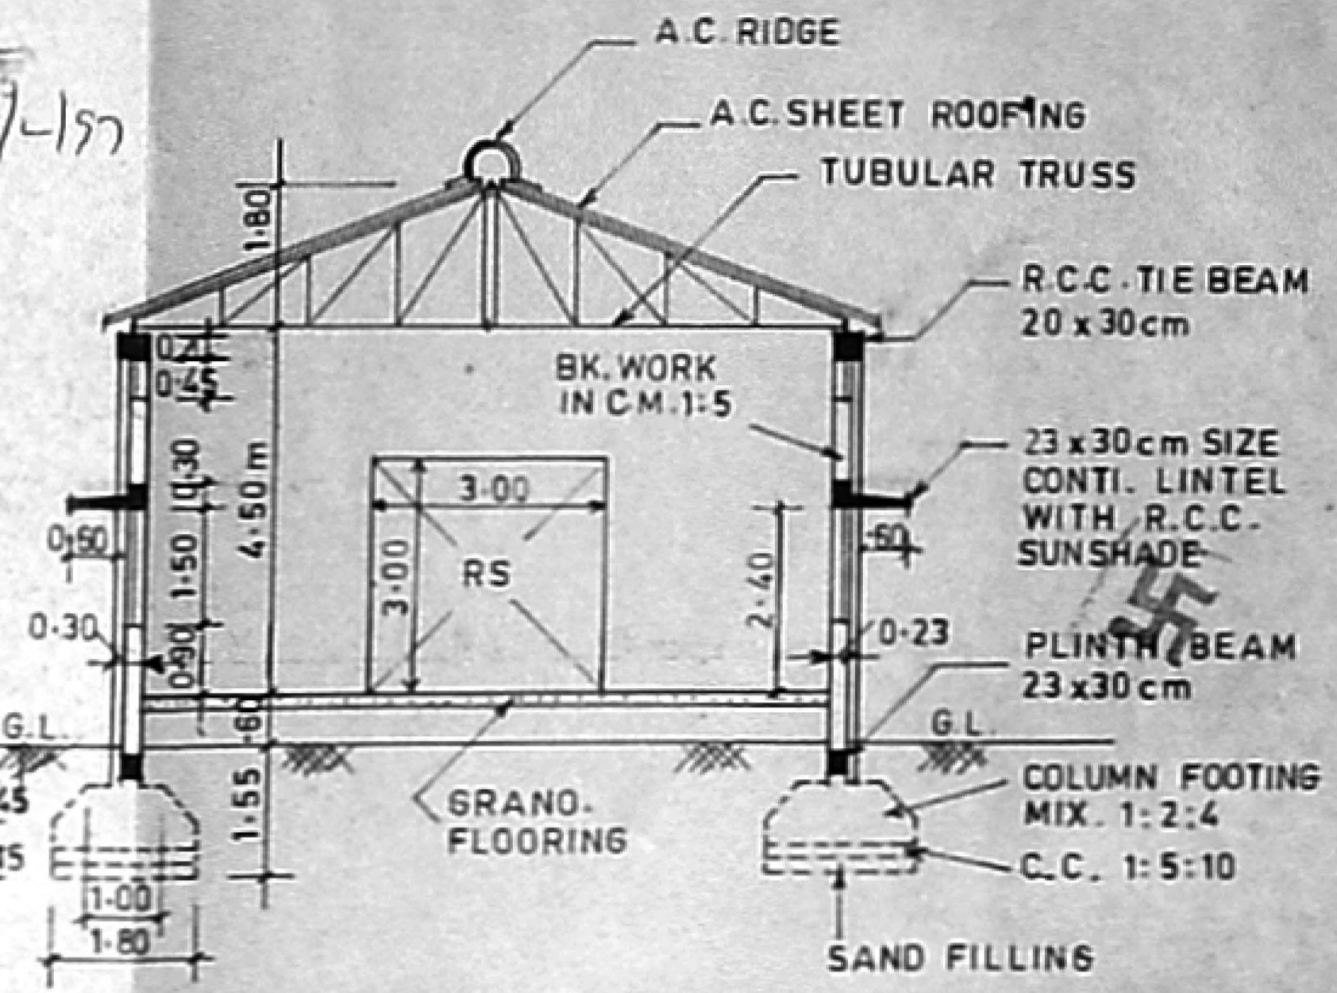

CROSS SECTION ON A/A

- REF
- RS - ROLLING SHUTTER - 3-00 x 3-00 m
 - W - WINDOW (STEEL) - 1-80 x 1-50 m
 - V - VENTILATOR (R.C.C. JALLI) - 1-80 x 0-45 m

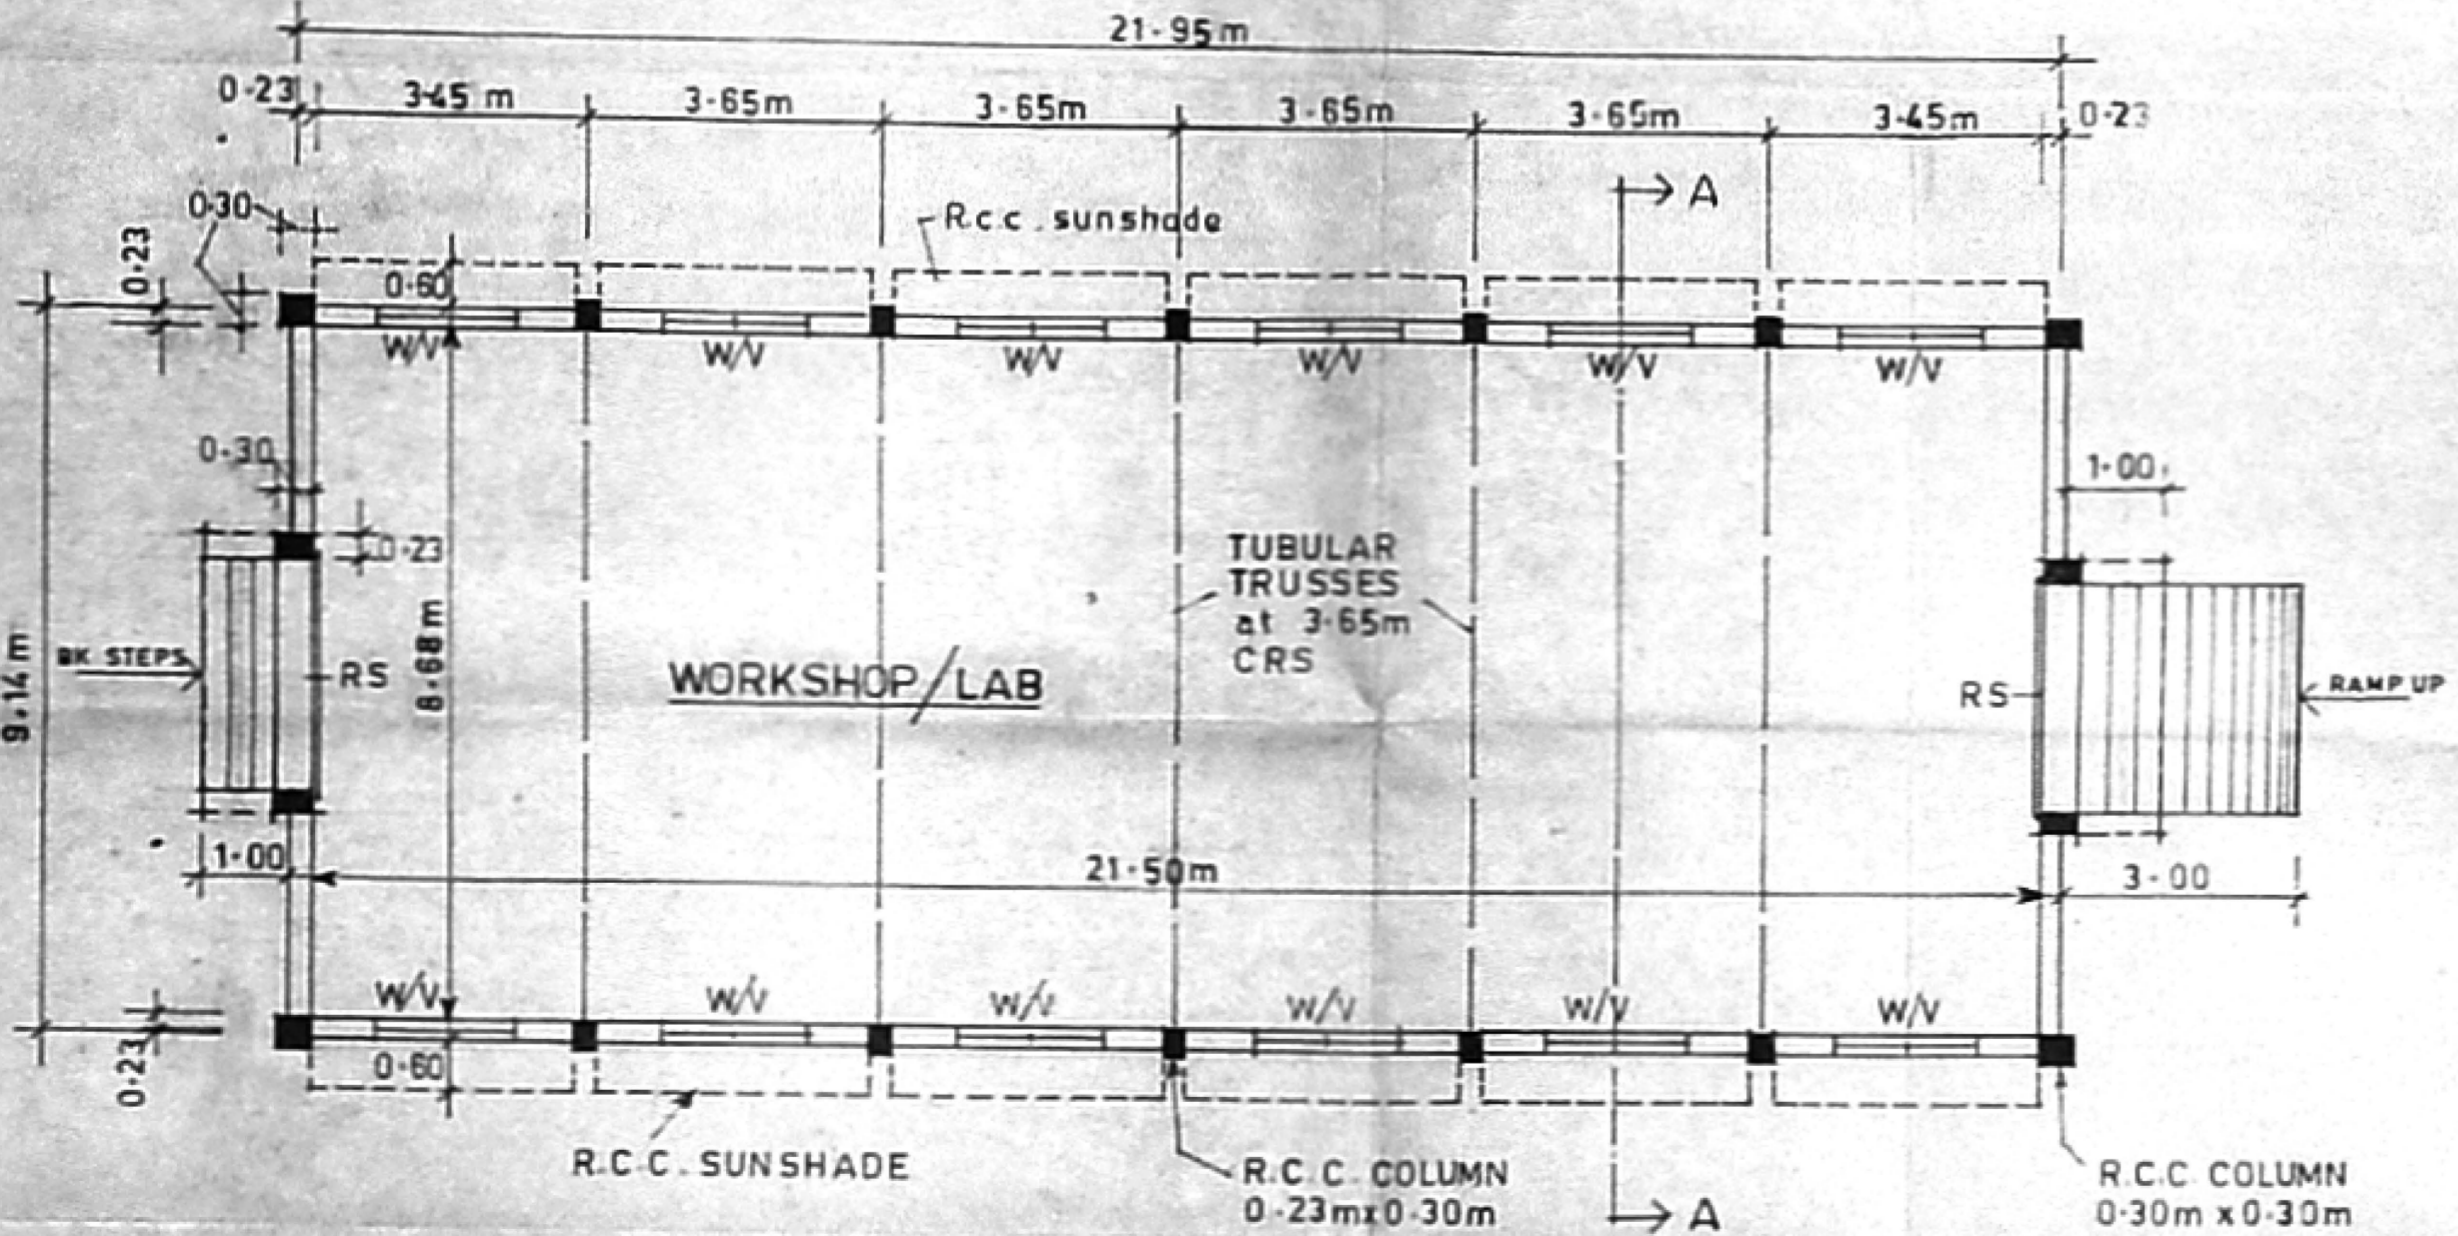

PLAN



All Dimensions are in Metres

Dr. C. N. SRINIVASAN
 B.Tech (Hons) M.S. (III) Ph.D.,
 Assoc. M. Am. Soc. C.E. F.I.E. F.I.V.
 REGISTERED ARCHITECT
 CA / 75 / 1621
 6, KARPAGAMBAL NAJAP
 LUZ, MADRAS-600 007

Handwritten signature

IRT - POLYTECHNIC	
DATE	TITLE: PROPOSED CONSTRUCTION OF WORKSHOP SHED IN IRT POLYTECHNIC CAMPUS AT CHROMPET, NEMILICHERY VILLAGE, PALLAVARAM MUNICIPALITY. S. Nos. 171, 170/2, 170/3A, 170, 173/3B, 169, 169/2A TO 21, 168/3B, 168/1, 169/3
DRN	
TRD	
SCALE - 1:100	DRG. No.

42.2 x 300/4

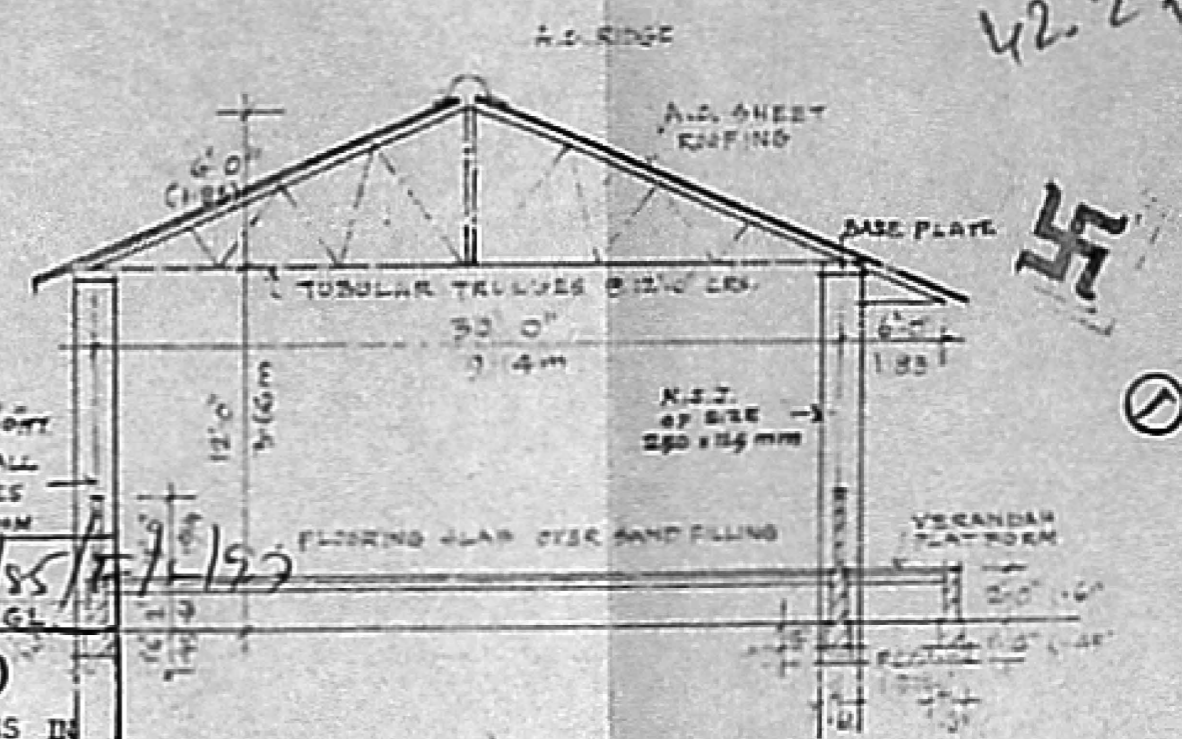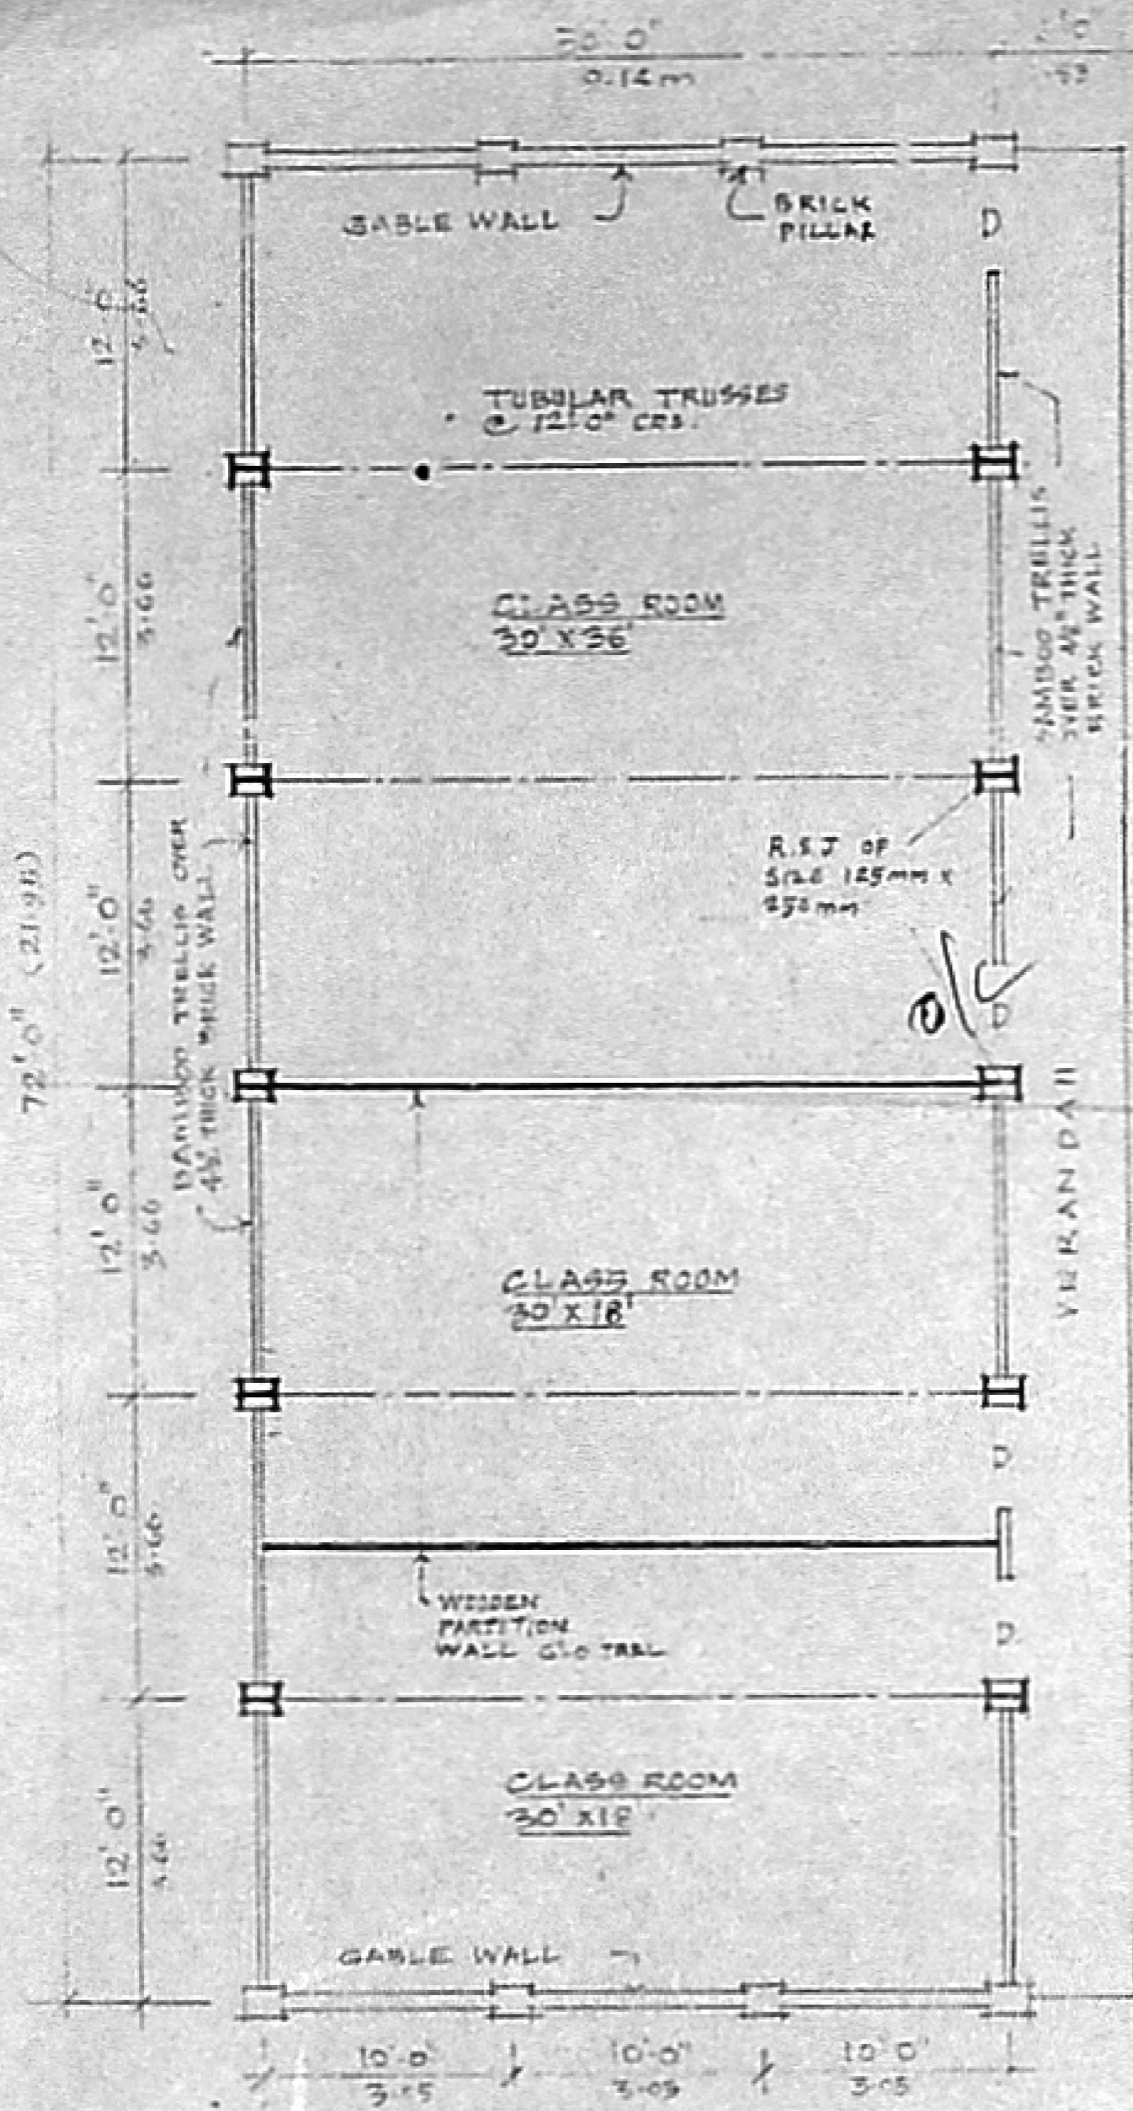


Building Permit No. C/24588/85/7/1/92


APPROVED
 SUBJECT TO THE CONDITIONS IN
 THIS OFFICE LETTER.

Date 20-7-92


FOR MEMBER SECRETARY
 CHENNAI METROPOLITAN
 DEVELOPMENT AUTHORITY
 CHENNAI-600 008.

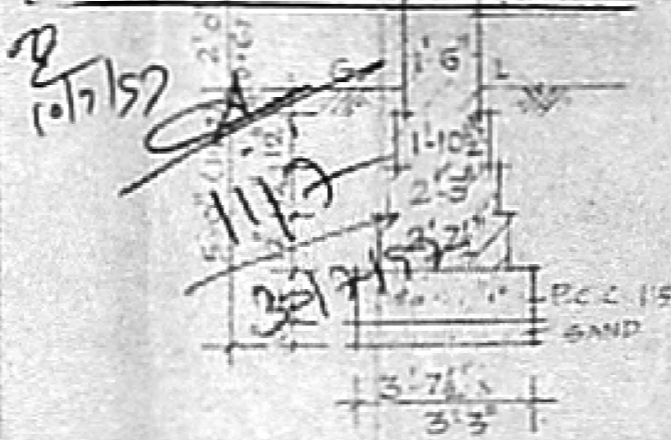

FOUNDATION DETAILS FOR BRICK PILLAR

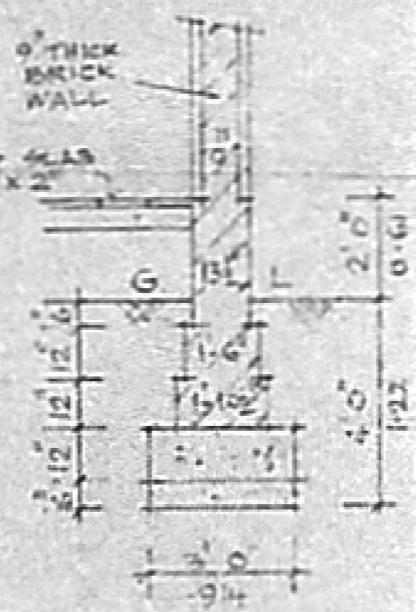

FOUNDATION DETAILS FOR 9" THICK BRICK GABLE WALL

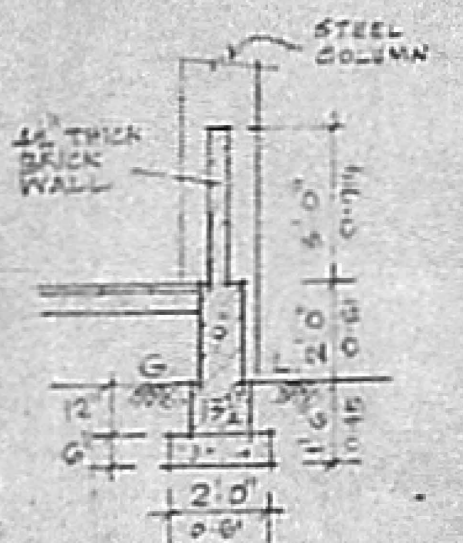

FOUNDATION DETAILS FOR 4 1/2" THICK BRICK WALL

Dr. C. N. SRINIVASAN
 B.Tech (Hons) M.S. (III) P.D.
 Assoc. M. in C.E. E.I. F.I.
 REGISTERED ARCHITECT
 CA/76/1221
 8, KARPAGAMBAL NAJAR
 CHROMPET, MADRAS 600 004

PROPOSED CONSTRUCTION OF
 CLASS ROOM FOR IRT POLYTECHNIC
 AT CHROMPET,
 NEMILlicherry VILLAGE,
 PALLAVARAM MUNICIPALITY.

(SCALE: 1" = 8'-0")


Assistant Engineer (Civil)
 INSTITUTE OF ROAD TRANSPORT
 POLYTECHNIC
 Chrompet, Madras

S. Nos: 171, 170/2, 170/3A, 170, 173/3B,
 169, 169/2A TO 21, 168/3B, 168/1, 169/3


Planning Permit No C/24588/85/A/L/197

APPROVED
 SUBJECT TO THE CONDITIONS IN THIS OFFICE LETTER.
 No C/4/8752/92 Date 30-7-90
 FOR MEMBER SECRETARY
 CHENNAI METROPOLITAN DEVELOPMENT AUTHORITY
 CHENNAI-600 008.


etc
 57x43.3
 ⑤

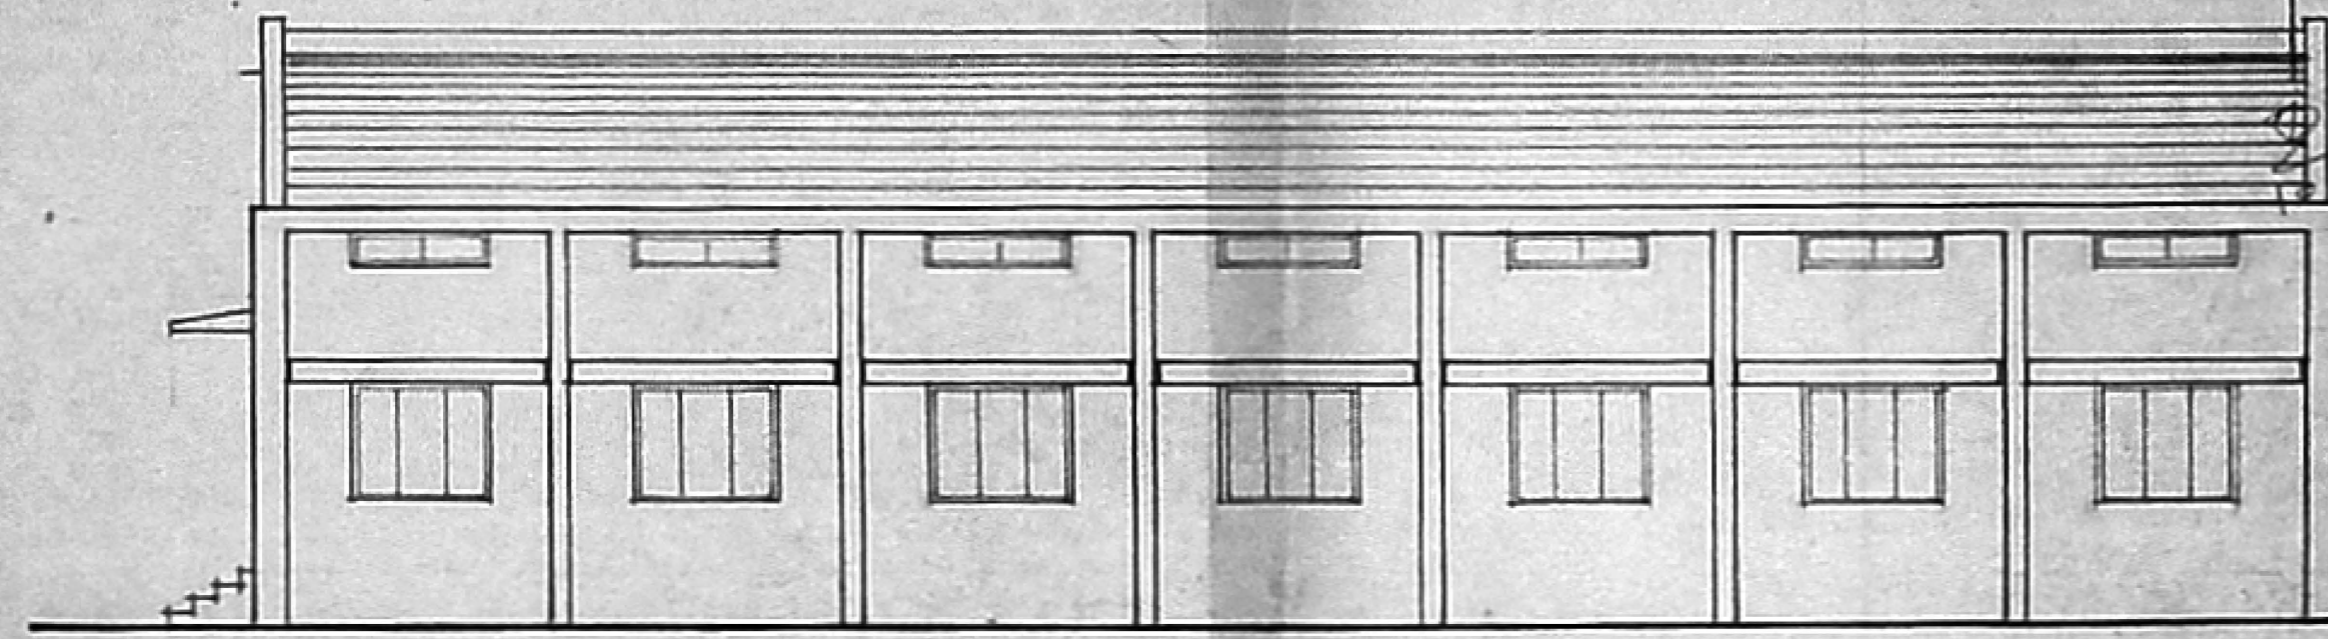

SIDE ELEVATION

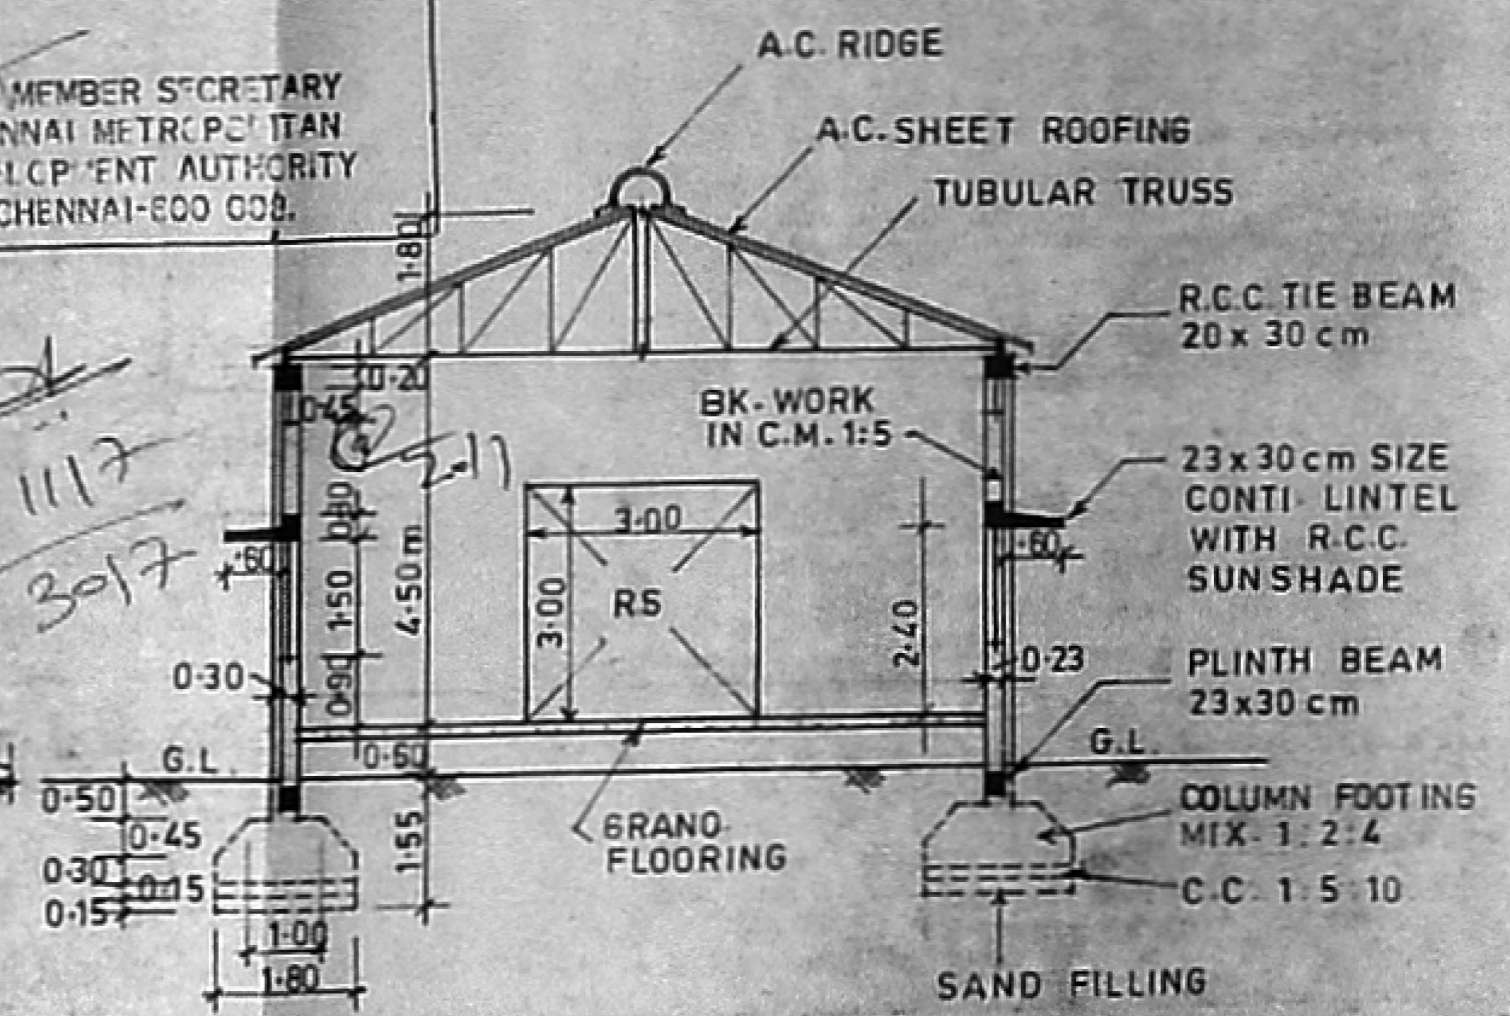

CROSS SECTION ON A/A

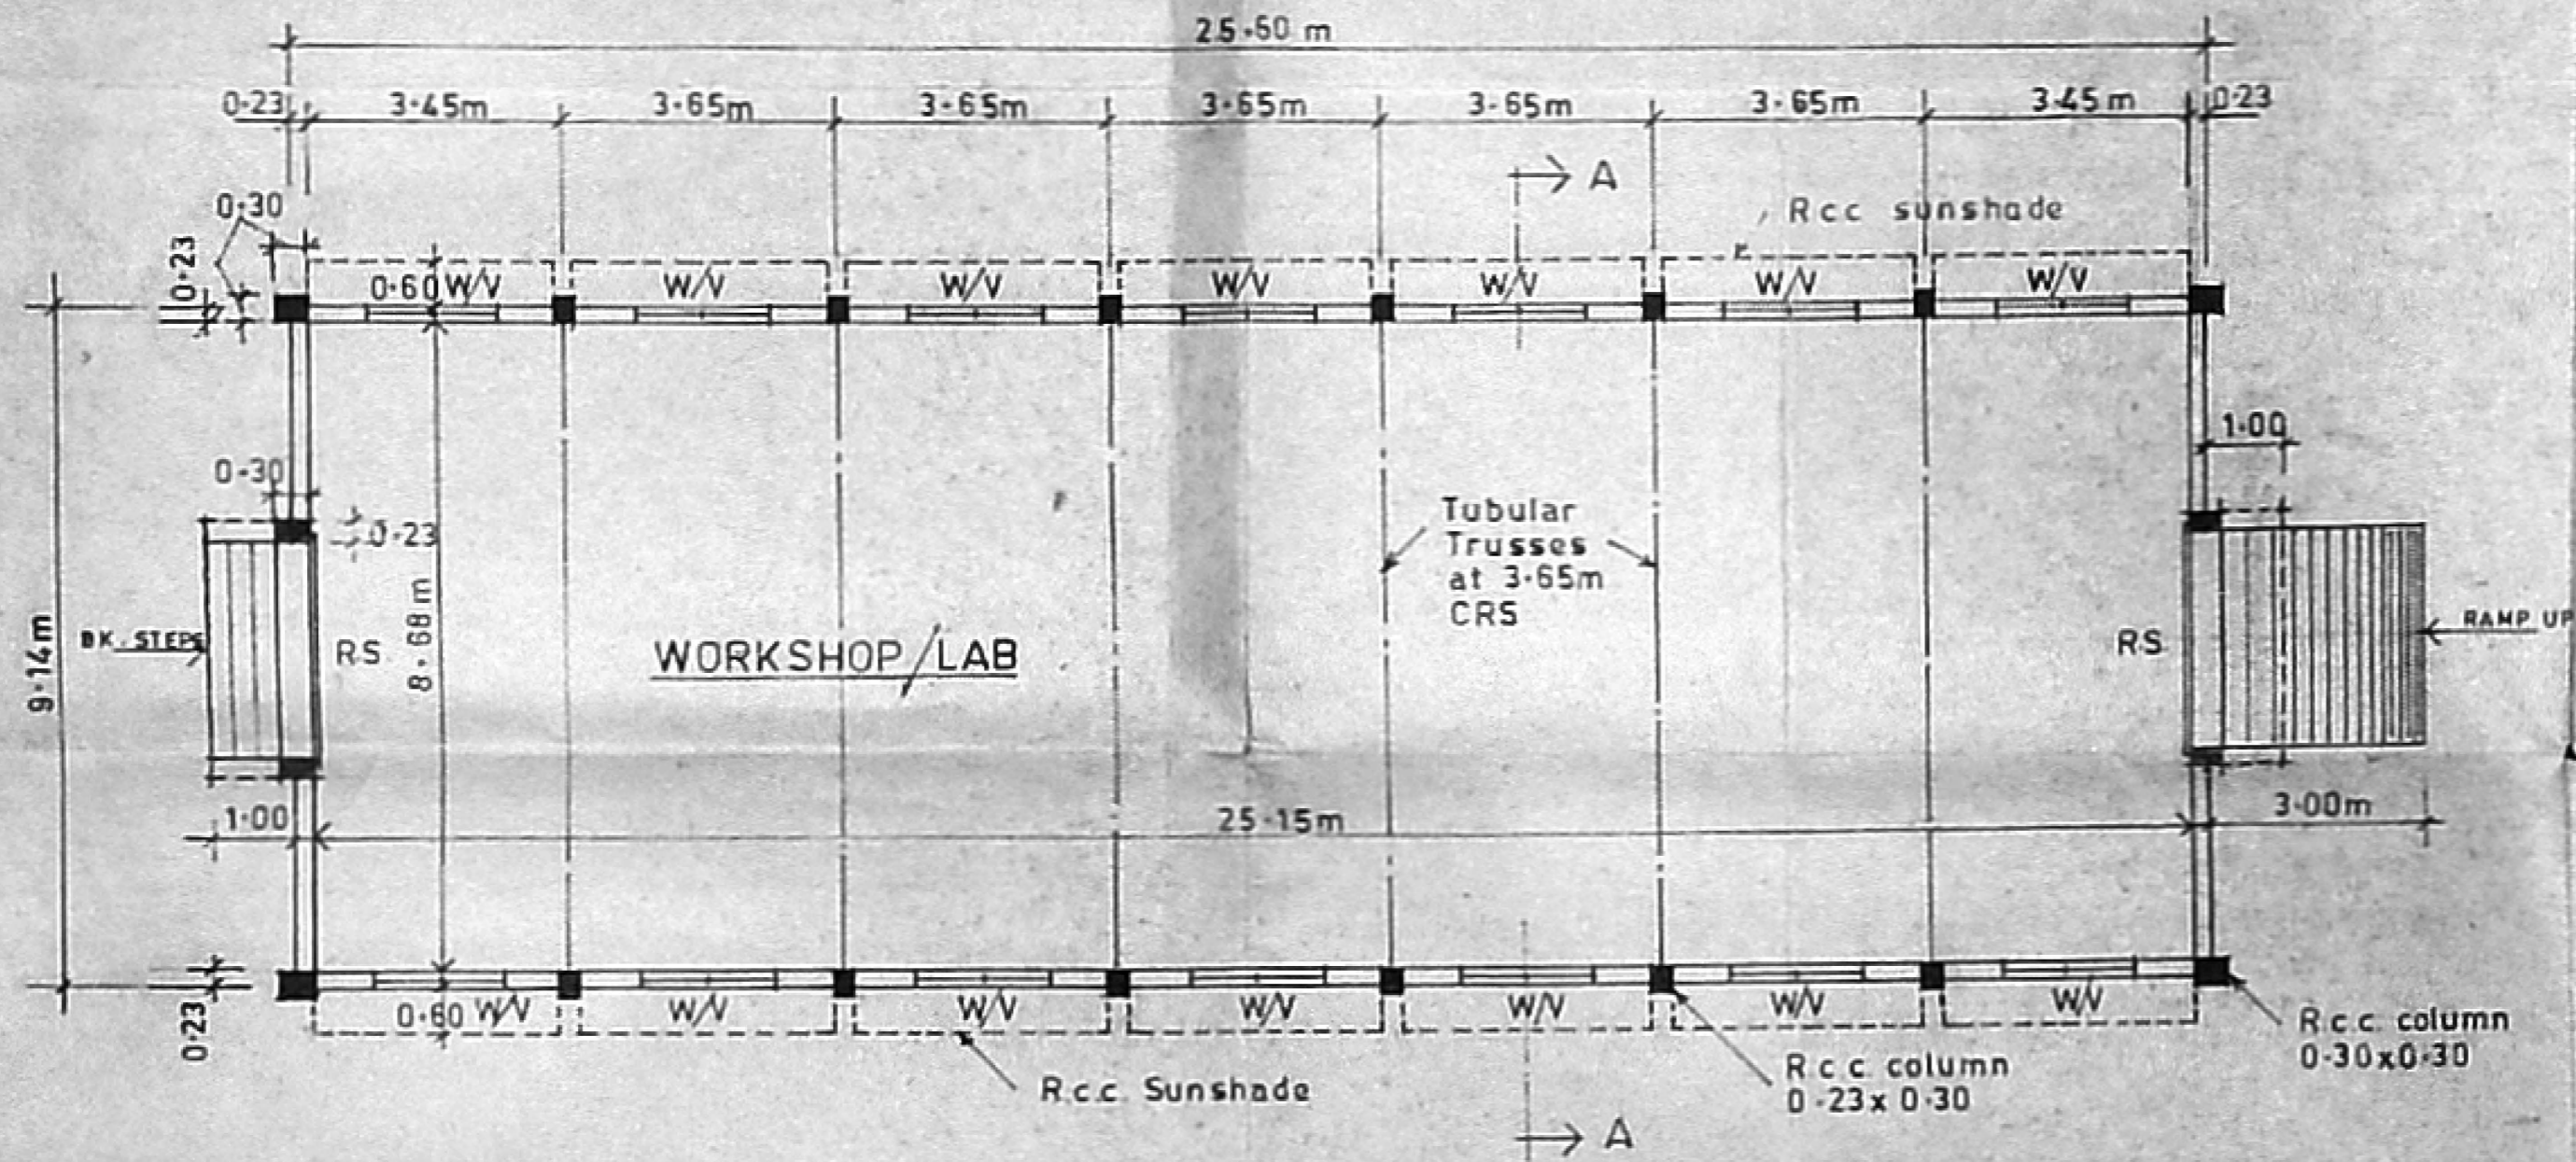

PLAN
 All Dimensions are in Metres

- REF.
- RS - ROLLING SHUTTER - 3.00 x 3.00 m
 - W - WINDOW (STEEL) - 1.80 x 1.50 m
 - V - VENTILATOR (RCC JALLI) - 1.80 x 0.45 m


Dr. C. N. SRINIVASAN
 B.Tech (Hons) M.S. (III) Ph.D.,
 Assoc. M. Am. Soc. C.E. F.I.E., F.I.A.
 REGISTERED ARCHITECT
 CA / 75 / 1521
 6, KARPAGAMBAL NAJAR
 LUZ, MADRAS-600 004

Handwritten signature

IRT - POLYTECHNIC	
DATE	TITLE PROPOSED CONSTRUCTION OF WORK SHOP IN IRT POLYTECHNIC CAMPUS AT CHROMPET, NEMILICHERRY VILLAGE, PALLAVARAM MUNICIPALITY. S. Nos : 171, 170/2, 170/3A, 170, 173/3B, 169, 169/2A, 202L, 166/3B, 166/1, 169/3.
DRN	
TRD	
SCALE : 1:100	DRG NO


Planning Permit No C/24588/85 I/-197
APPROVED
 SUBJECT TO THE CONDITIONS
 THIS OFFICE LETTER.
 No. C4/8752/92 Date 20-7-97
 FOR MEMBER SECRETARY
 CHENNAI METROPOLITAN
 DEVELOPMENT AUTHORITY
 CHENNAI-600 004

o/c
 58.24

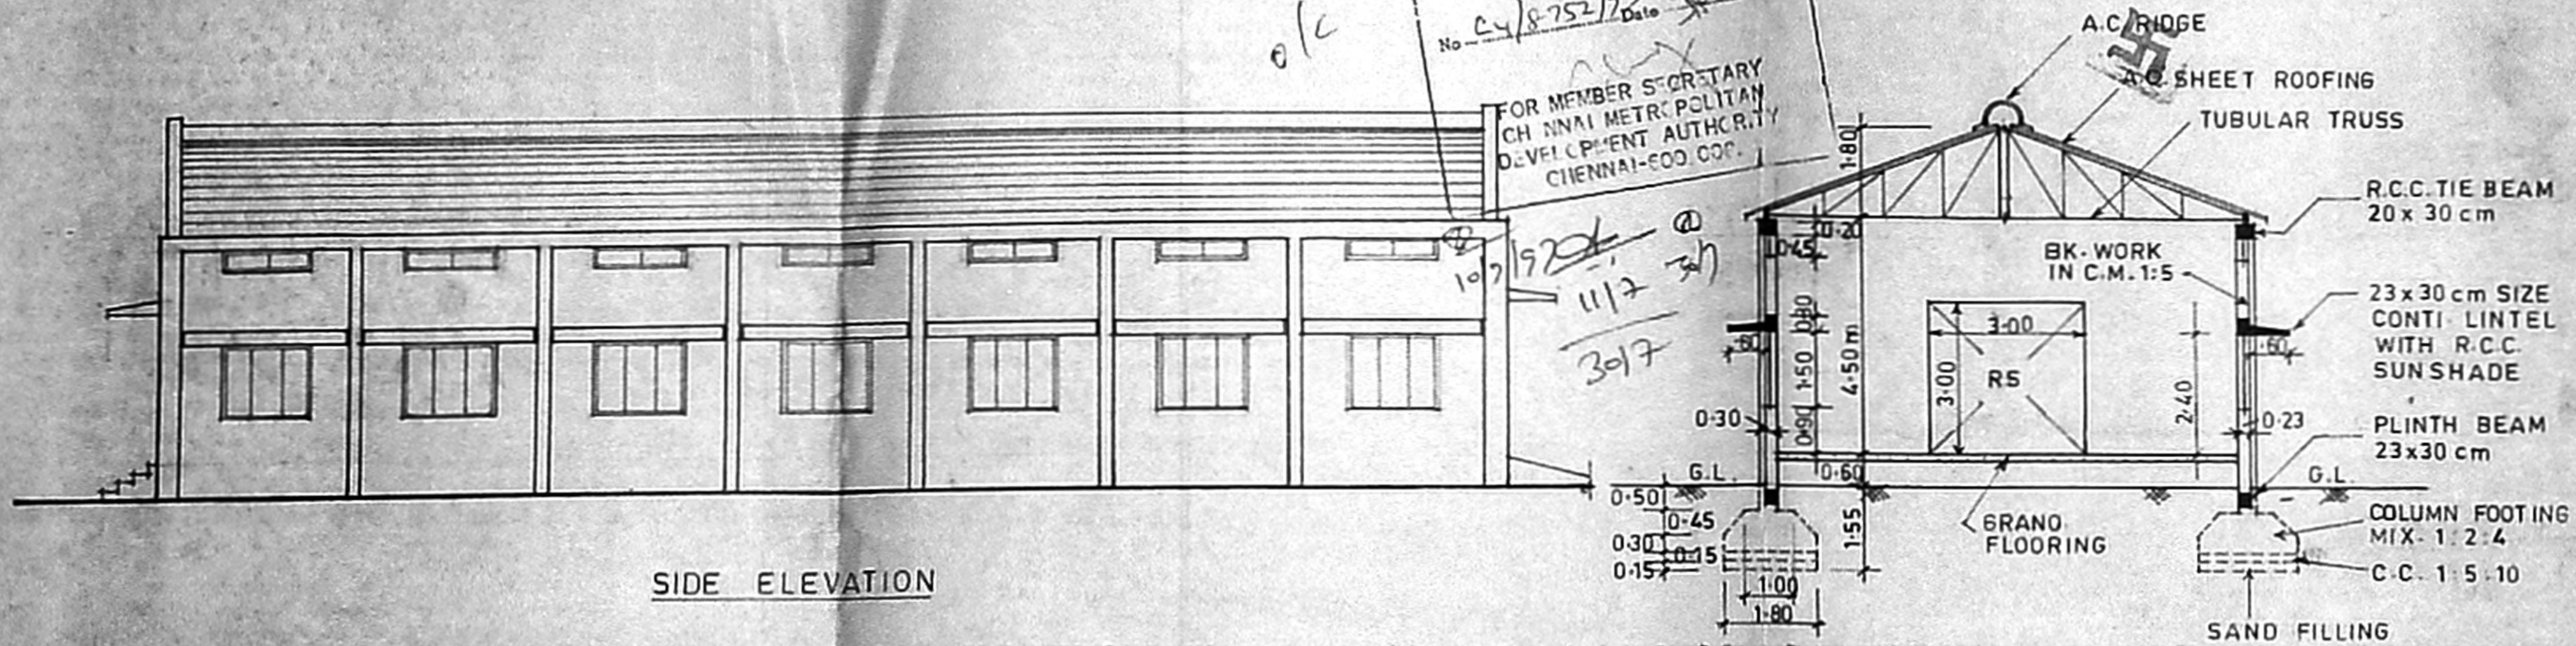

SIDE ELEVATION

CROSS SECTION ON A/A

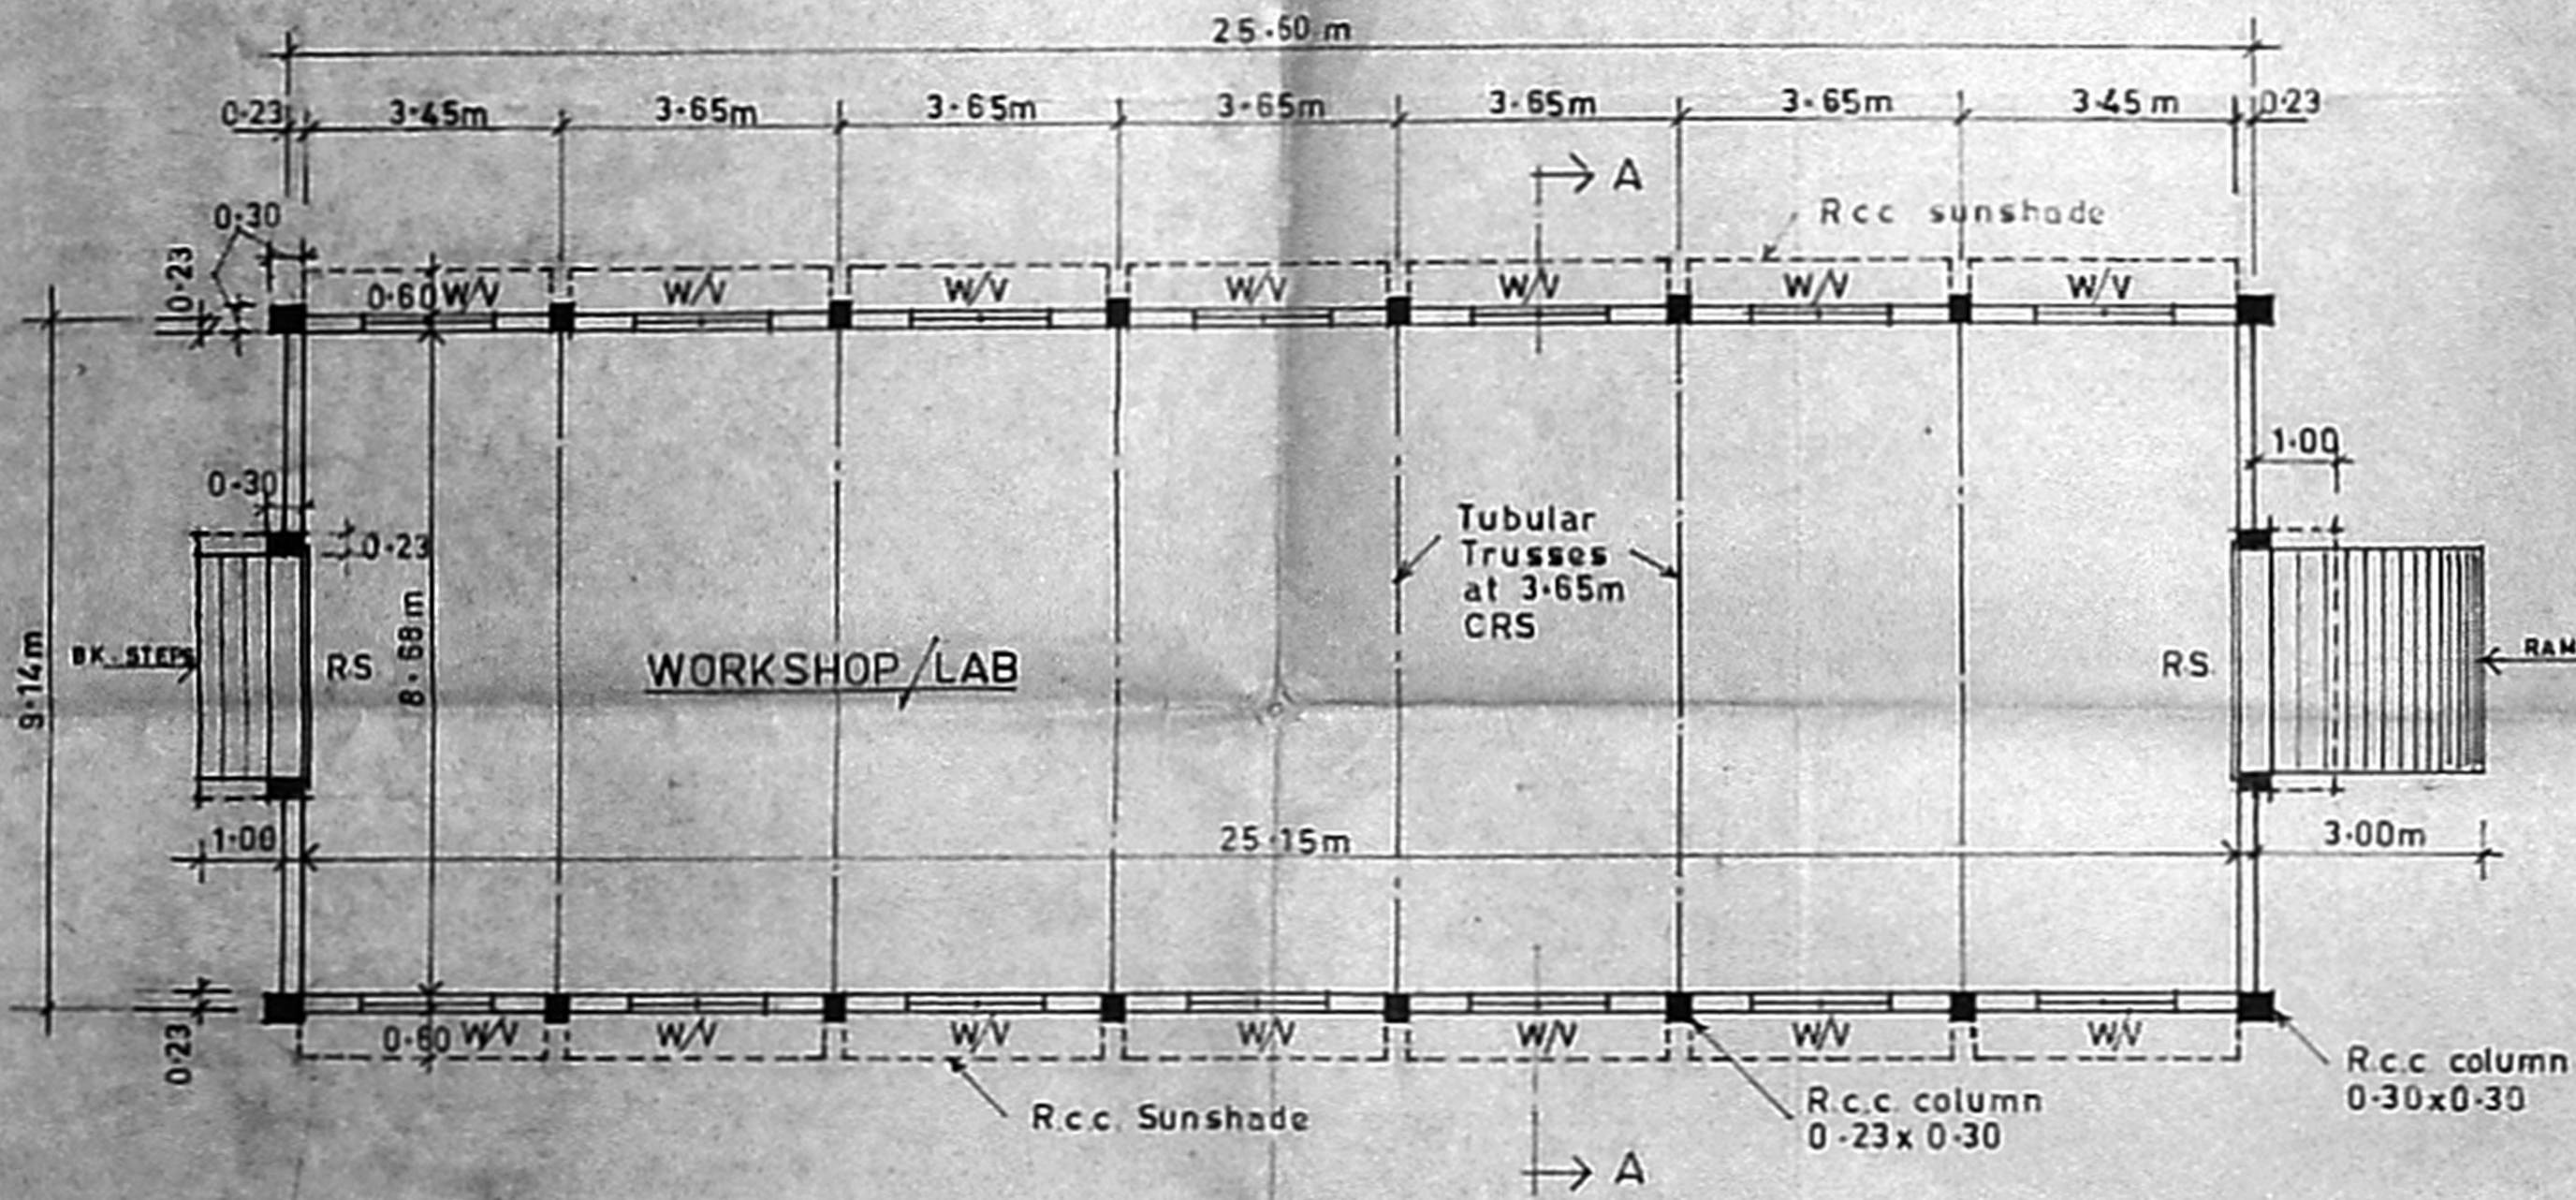

PLAN

All Dimensions are in Metres

- REF.
- RS - ROLLING SHUTTER - 3.00 x 3.00 m
 - W - WINDOW (STEEL) - 1.80 x 1.50 m
 - V - VENTILATOR (R.C.C. JALLI) - 1.80 x 0.45 m

Dr. C. N. SRINIVASAN
 B.Tech (Hons) M.S. (III) Ph.D.,
 Assoc. M. Am. Soc. C.E. F.I.E., F.I.A.
 REGISTERED ARCHITECT
 CA / 75 / 1521
 6, KARPAGAMBAL NAJAP
 MUZ, MADRAS-600 004

IRT - POLYTECHNIC	
DATE	TITLE
DRN	PROPOSED CONSTRUCTION OF WORK SHOP IN IRT POLYTECHNIC CAMPUS AT CHROMPET- NEMILICHERRY VILLAGE, PALLAVARAM MUNICIPALITY.
TRD	S. Nos : 171, 170/2, 170/3A, 170, 173/3B, 169, 169/2A, TO 21, 168/3B, 168/1, 169/3.
SCALE : 1:100	DRG. NO.

20/28.6


Planning Permit No. C/2, 588/85/J/H/92

APPROVED


SUBJECT TO THE CONDITIONS IN THIS OFFICE LETTER.

No. C4/8752/92 Date 11-7-97


FOR MEMBER SECRETARY
CHENNAI METROPOLITAN
DEVELOPMENT AUTHORITY
CHENNAI-600 004.

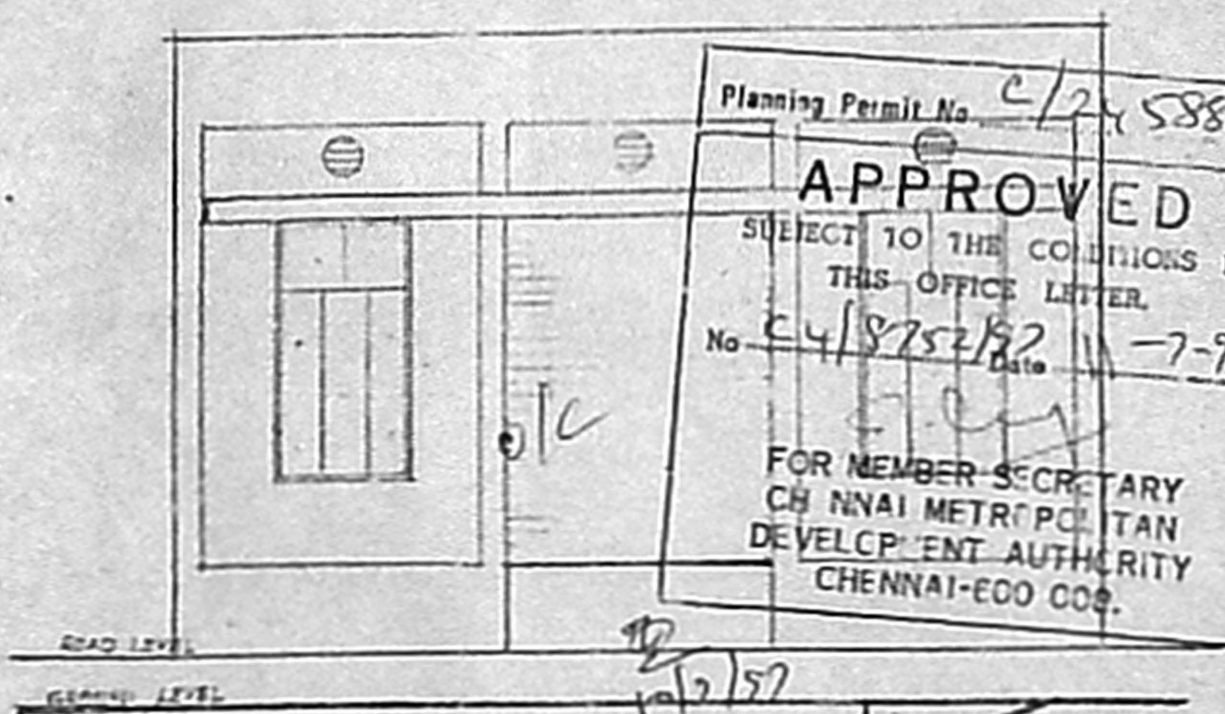

ELEVATION:

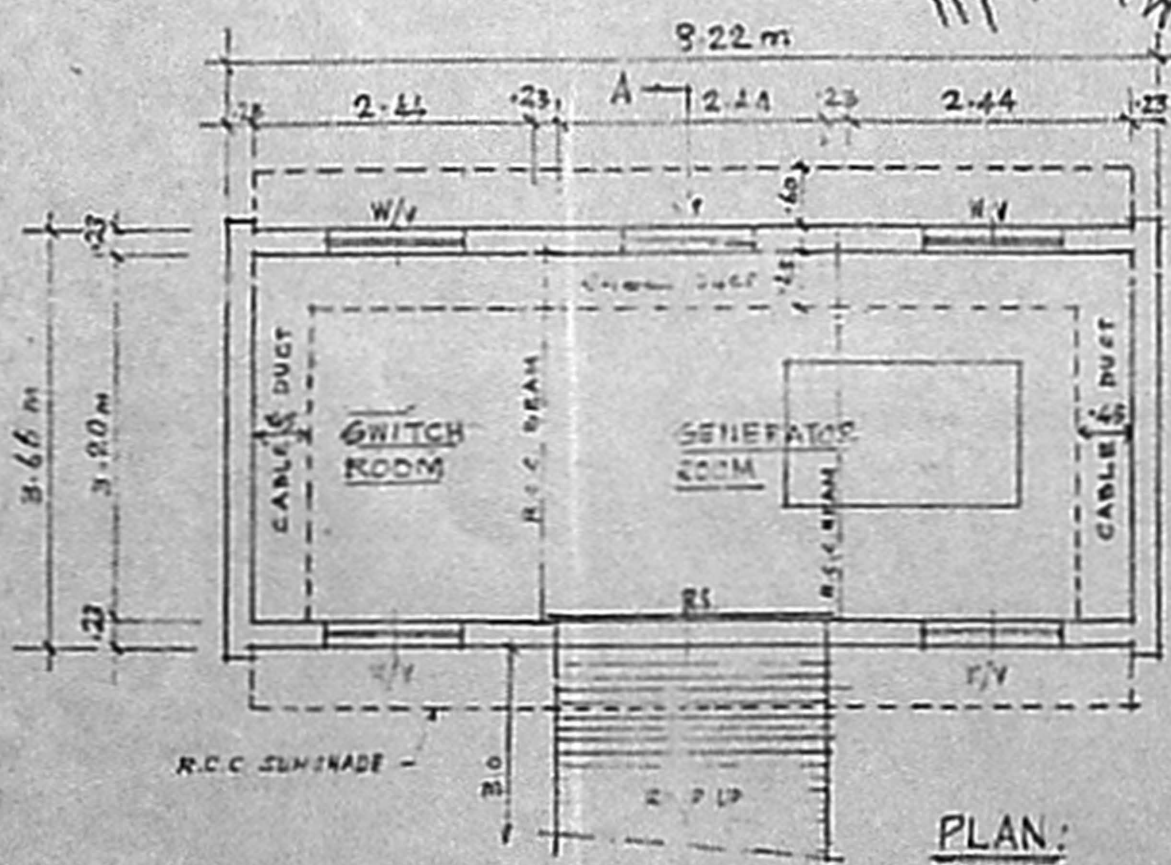

PLAN:

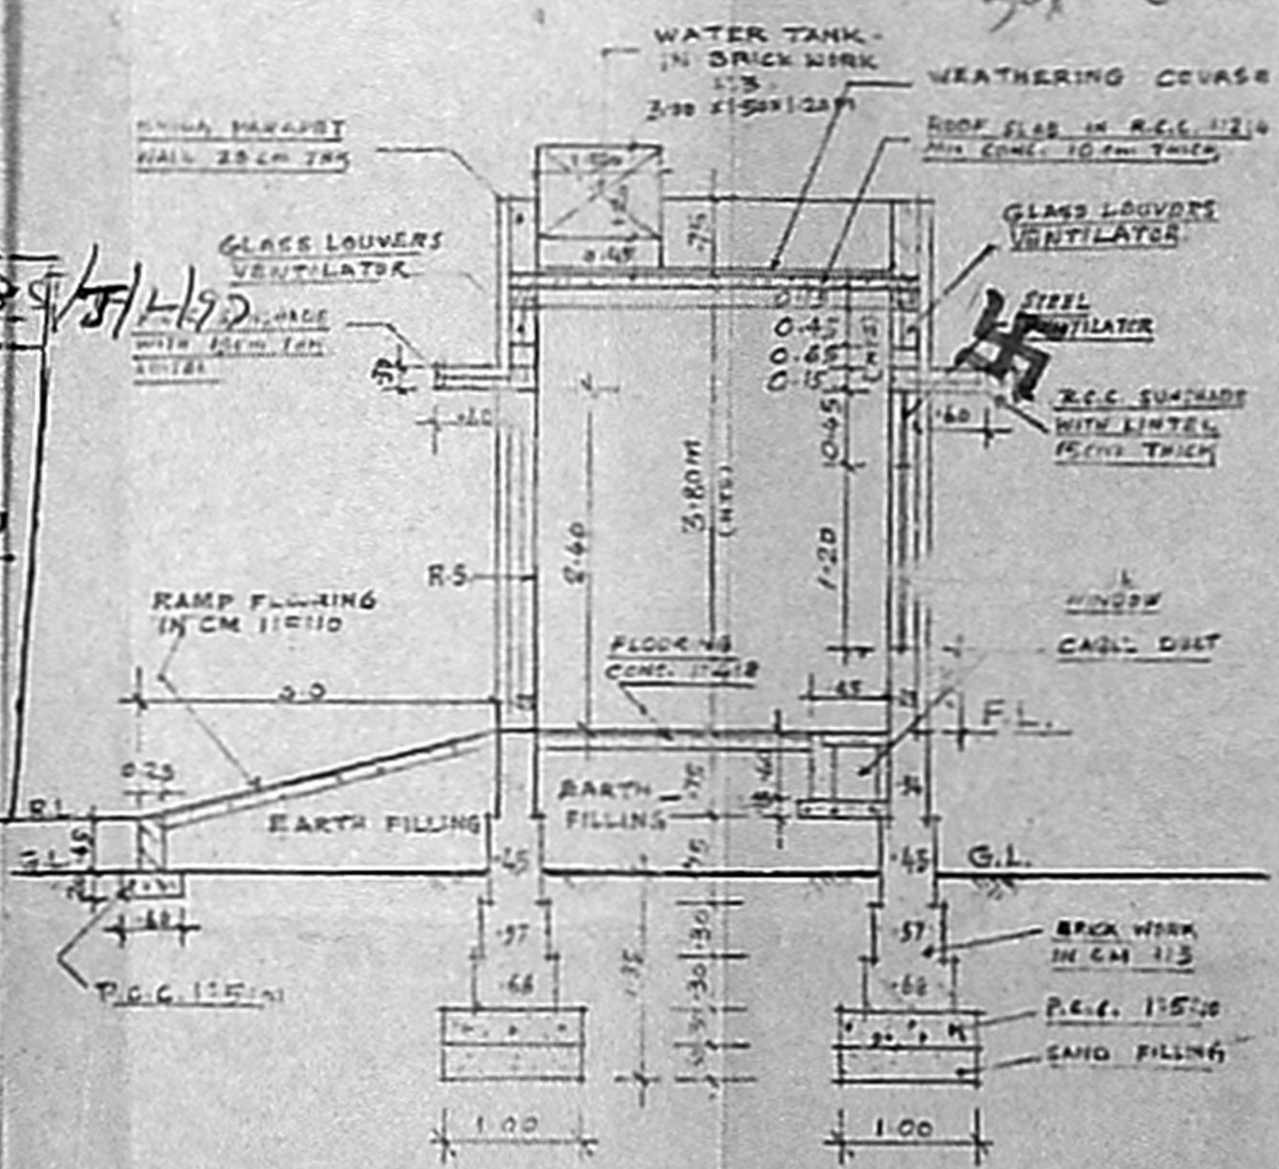

SECTION ON A-A

R.S.	ROLLING SHUTTER	2.40 X 2.40
D.	DOOR - T.W. PANELLED	1.20 X 2.10
W.	WINDOW - STEEL	1.20 X 1.20
V.	VENTILATOR - STEEL	1.20 X 0.45

Dr. C. N. SRINIVASAN
B.Tech (Hons) M.S. (III) P.D.,
Assoc. M. Am Soc C.E. F.I. F.I.V.
REGISTERED ARCHITECT
CA/75/1521
8, KARPAGAMBAL NAGAR
MADRAS-600 004


PROPOSED CONSTRUCTION OF
SWITCH CUM GENERATOR ROOM
FOR IRT POLYTECHNIC,
AT CHROMPET.

Assistant Engineer (Civil)
INSTITUTE OF ROAD TRANSPORT
POLYTECHNIC
Chrompet, Madras-44.

NEMILlicherry VILLAGE,
PALLAVARAM MUNICIPALITY.

S. Nos, 171, 170/2, 170/3A, 170, 173/3B,
169, 169/2A TO 21, 168/3B, 168/1,
169/3.

492/28.2

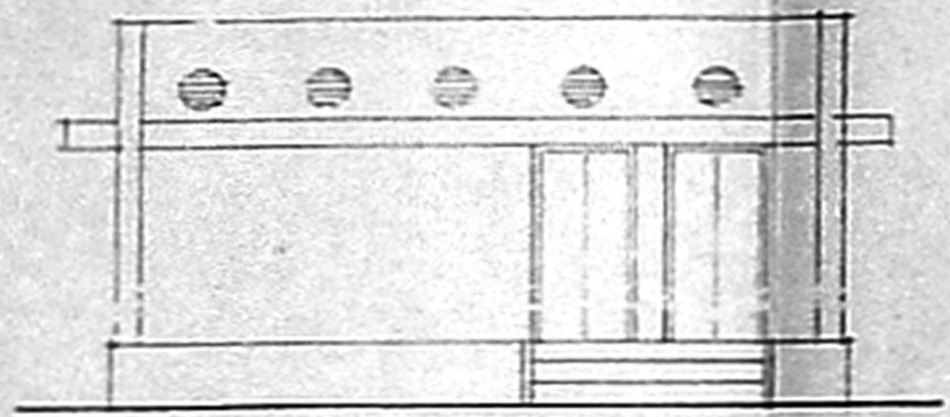

ELEVATION

Permit No C/24588/85/14/197


APPROVED

OBJECT TO THE CONDITIONS IN THIS OFFICE LETTER


No. C/4/8752/92 Date 10-7-92

FOR MEMBER SECRETARY
CHENNAI METROPOLITAN
DEVELOPMENT AUTHORITY
CHENNAI-600 008


O/C

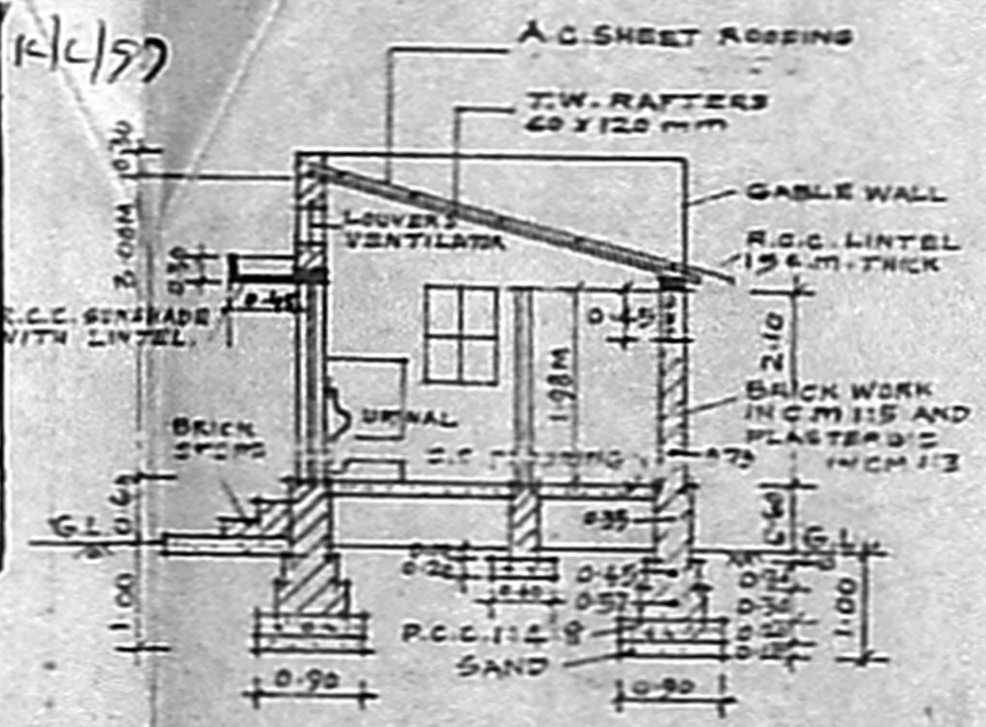

SECTION ON A-A

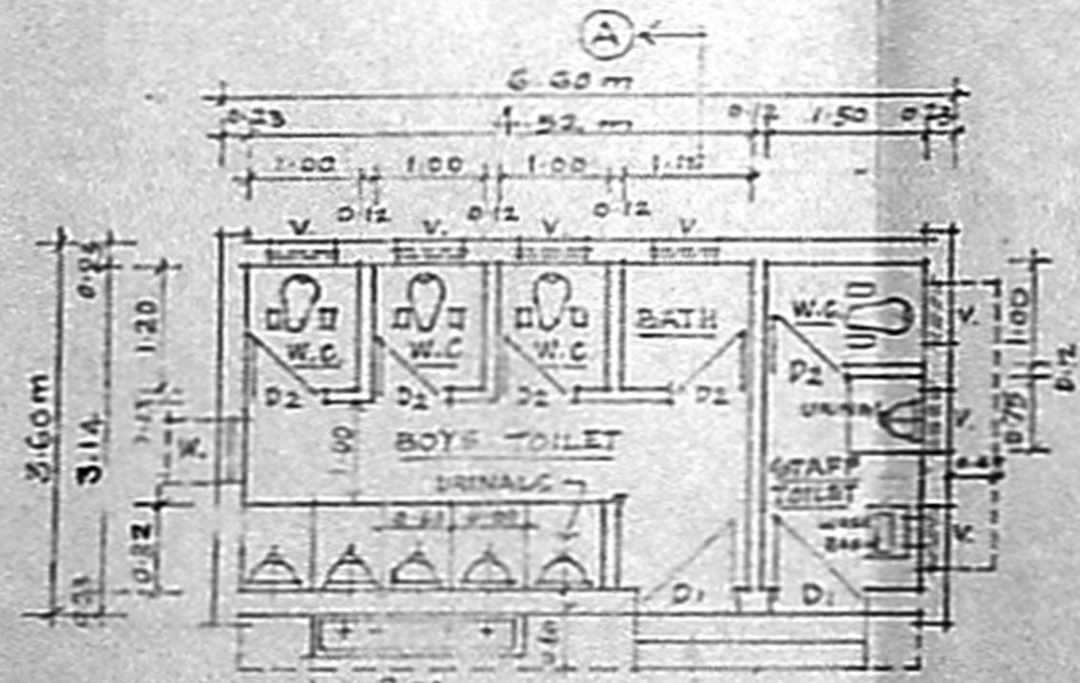

PLAN
BOYS TOILET

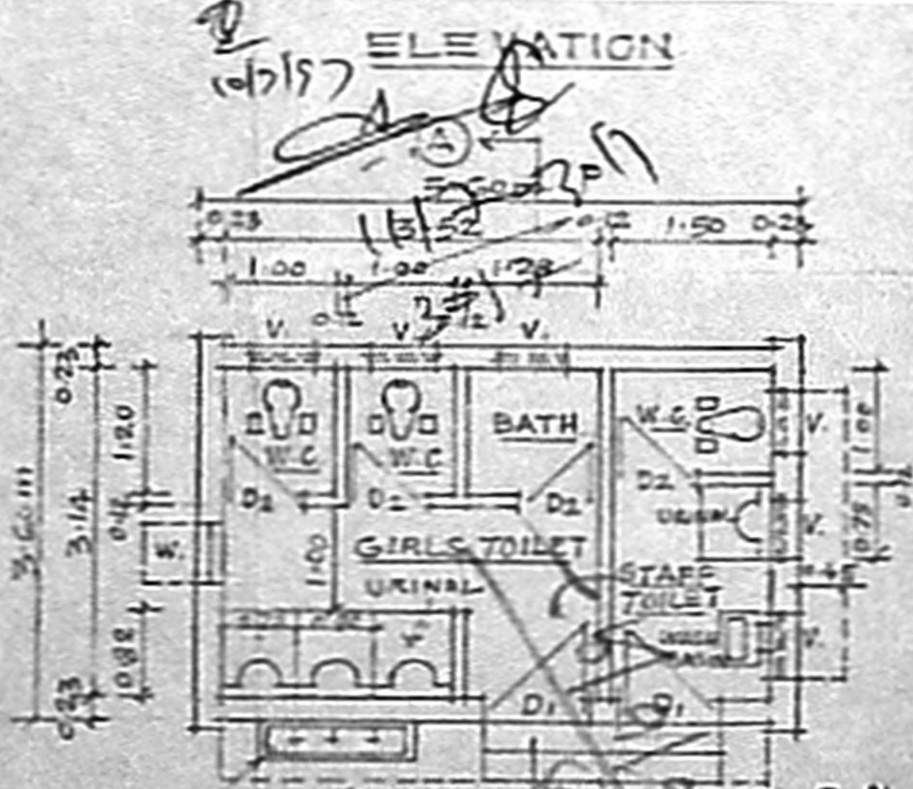

PLAN
GIRLS TOILET

REF.

D1. DOOR	1.00 x 1.98 m
D2. DOOR	0.75 x 1.98 m
W. WINDOW	0.60 x 1.20 m
V. VENTILATOR	0.60 x 0.45 m


PROPOSED CONSTRUCTION OF
TOILET BLOCKS FOR
IRT POLYTECHNIC AT CHROMPET.

Dr. C. N. SRINIVASAN NEMILICHERRY VILLAGE,
B.Tech (Hons) M.S. (III) Ph.D. PALLAVARAM MUNICIPALITY.
Assoc. Mem Soc C.E. F.I.E. F.I.A.
REGISTERED ARCHITECT SCALE: 1:50
CA/75/1521
S. Nos, 171, 170/2, 170/3A, 170, 173/3B,
169, 169/2A TO 21, 168/3B, 168/1,
169/3.


Handwritten signature

Assistant Engineer (Civil)
INSTITUTE OF ROAD TRANSPORT
POLYTECHNIC
Chrompet, Madras 600 004


o/c
792/197

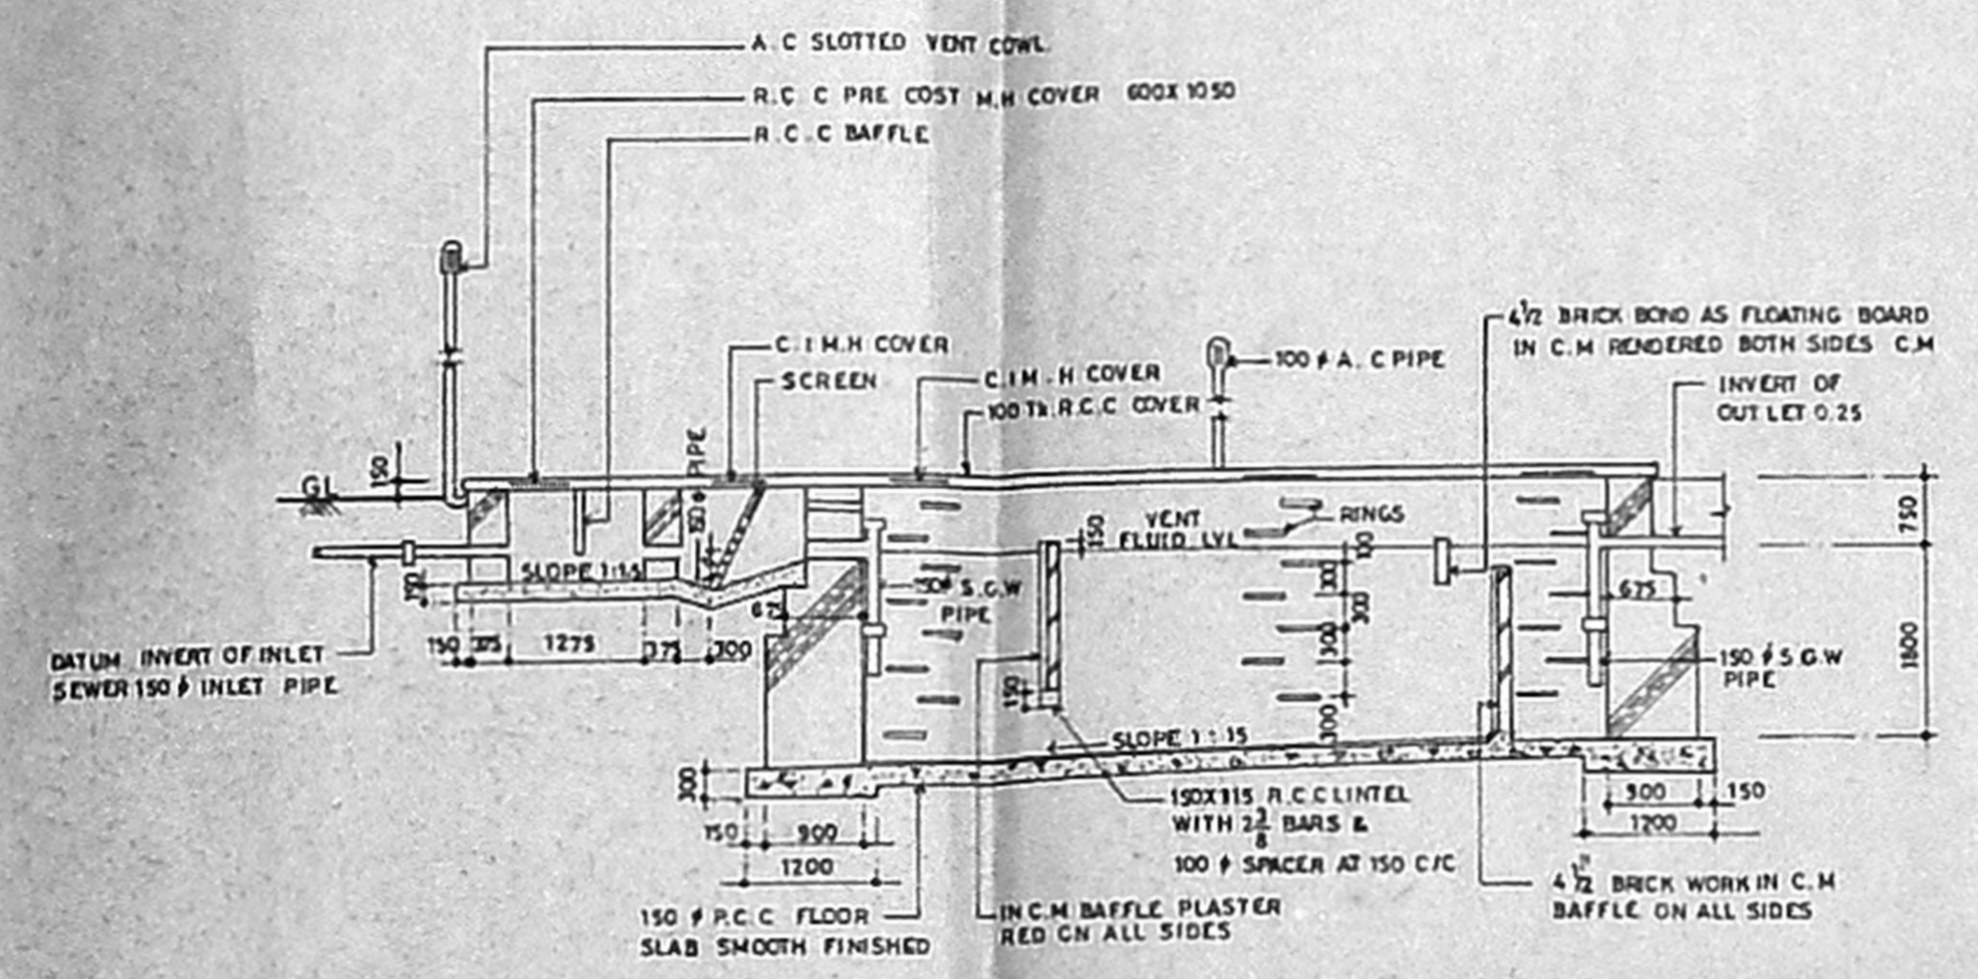


SECTION A - A

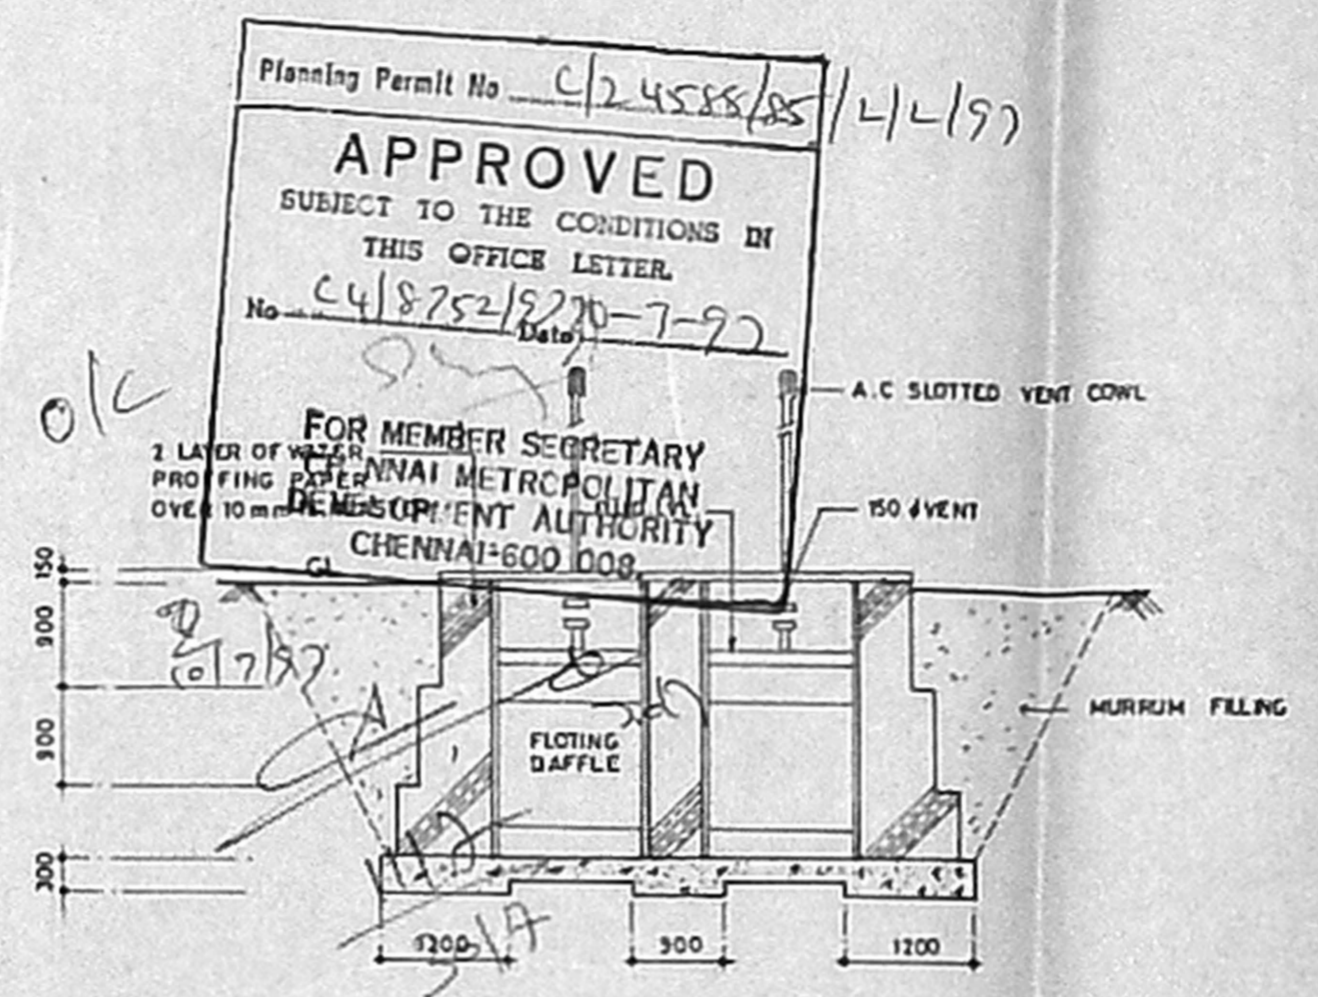

SECTION B - B

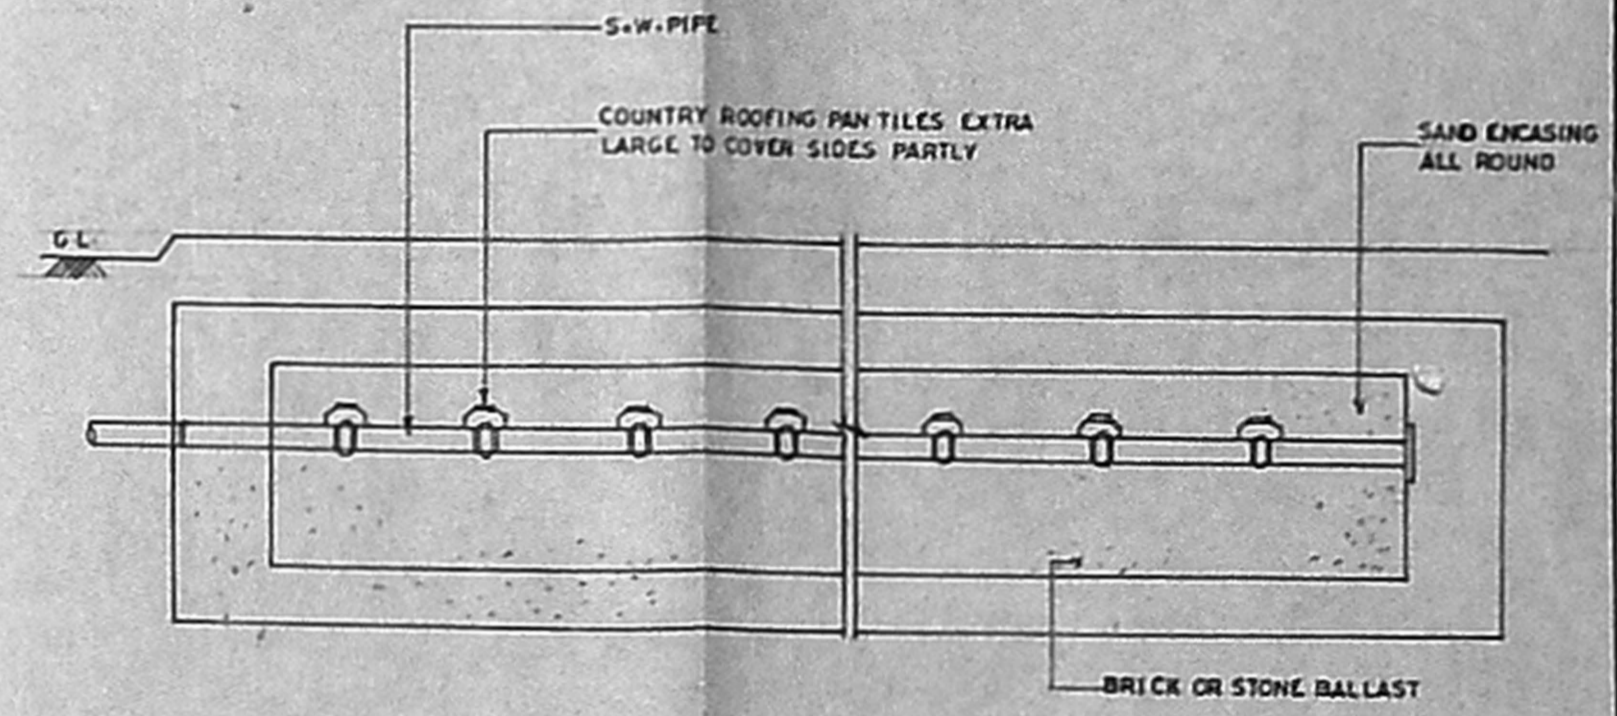

SECTION C - C

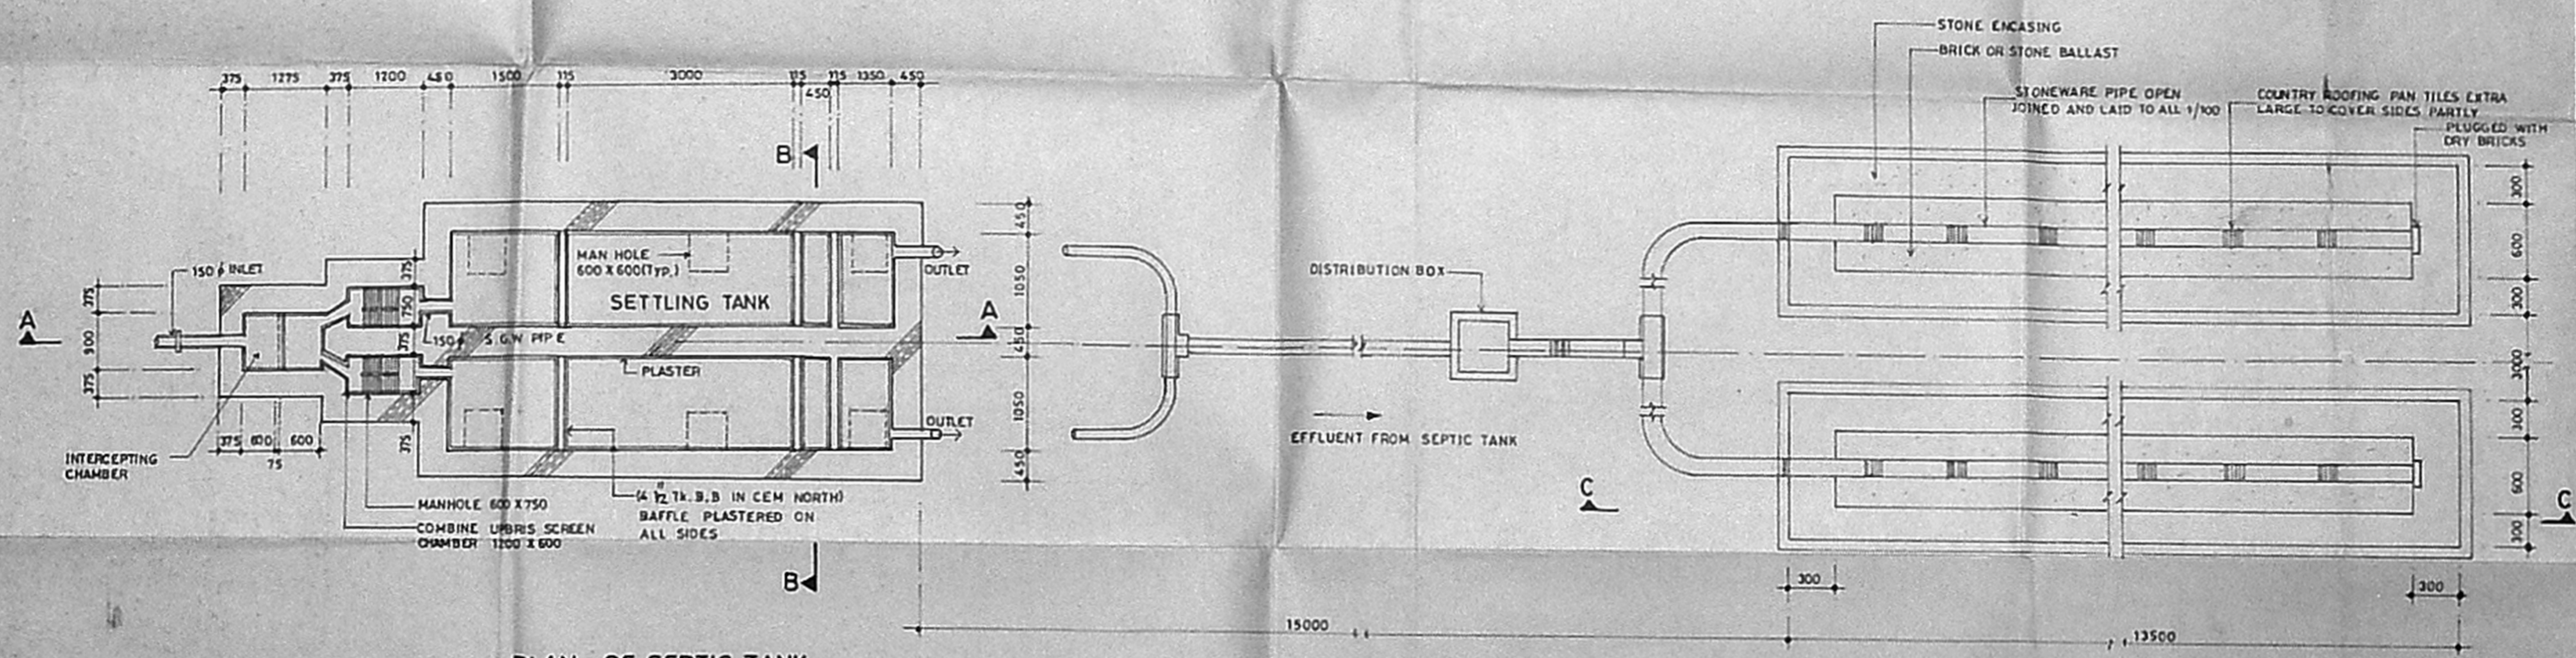

PLAN OF SEPTIC TANK
300 USERS.

PLAN OF DISPERSION TRENCH

M/s. INSTITUTE OF ROAD TRANSPORT,
IRT POLYTECHNIC AT CHROMPET,
NEMILlicherry VILLAGE,
PALAVARAM MUNICIPALITY.
S. Nos - 171, 170/2, 170/3A, 170, 170/3B, 169,
169/2A TO 21, 168/3B, 168/1, 169/3.

SEPTIC TANK (300 USERS)
PLAN & SECTIONS.

M/s. C.R. NARAYANA RAO,
architect & engineers,
Srinivasan
Iyer, Chennai - 48
B.Tech (Hons) M.S. (III) Ph.D.,
Assoc. Mem Soc C.E. F.I.E. F.I.V.
REGISTERED ARCHITECT
CA / 75 / 1521
B, KARPAGAMBAL NAGAR
LUZ, MADRAS - 600 007

B.TECH (HONS), M.S. (III), P.H.D., M.A.M. ASSOC. S.O.C., C.E. F.I.E. F.I.V. REGD. ARCH.	
DATE: 17.06.97	DRN: Ma
SCALE:	CHD
SYSTEM FILE NAME: MANUAL	
REGISTER NO: ZH / 4818 / 97	
PROJECT TITLE: IRT	

Assistant Engineer (Civ)
INSTITUTE OF ROAD TRANSPORT
POLYTECHNIC
Chrompet, Madras-44