





OFFICE COPY

Planning Permit No. **01251/031/2005**
APPROVED
 SUBJECT TO THE CONDITIONS IN THIS OFFICE LETTER.
 No. **01/369/04/35-1-2005**
 MEMBER SECRETARY
 CHENNAI METROPOLITAN
 DEVELOPMENT AUTHORITY
 CHENNAI - 600 008.

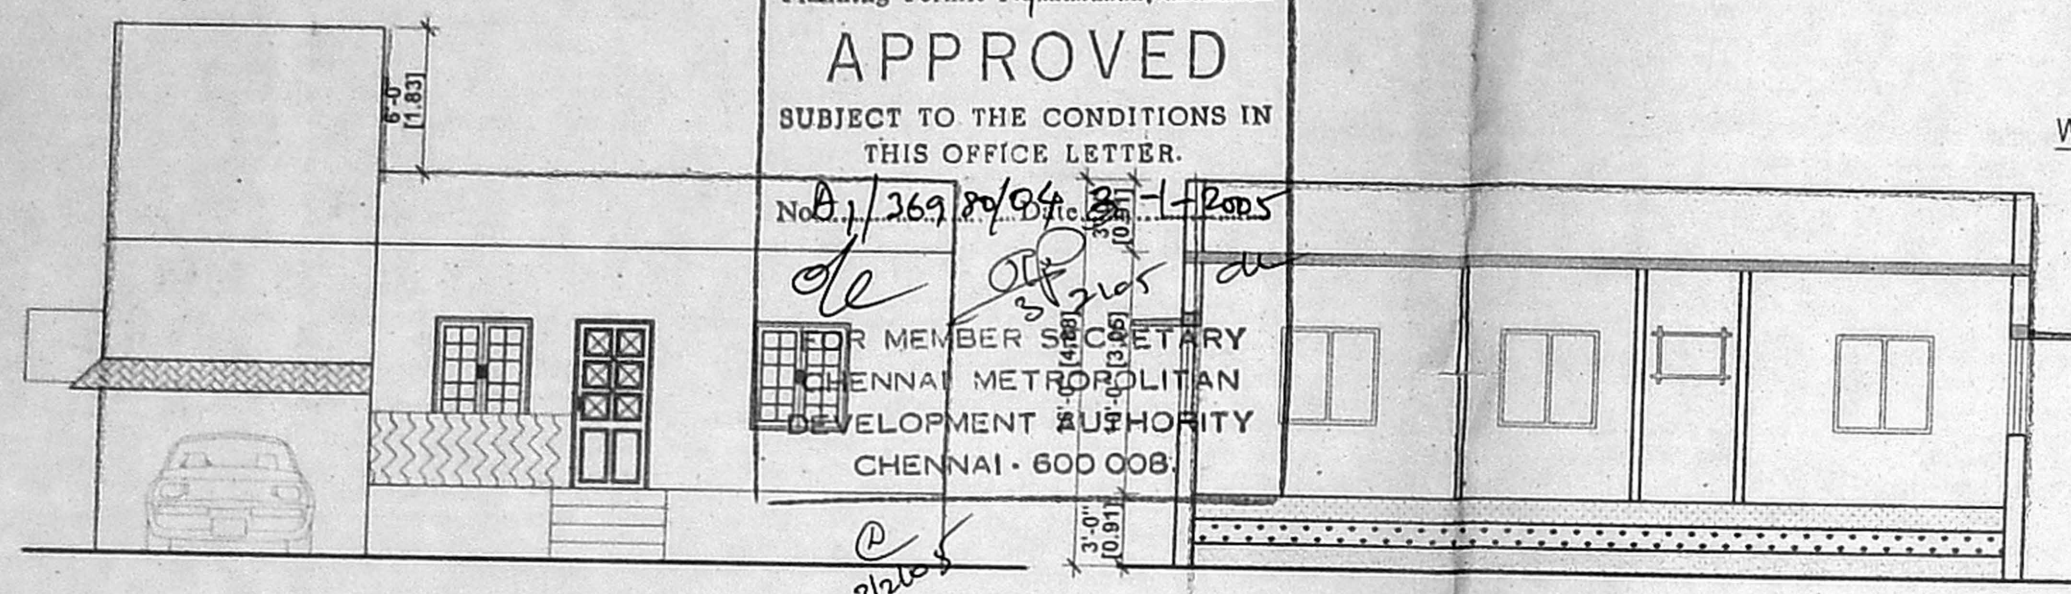


ELEVATION

SECTION ON 'SE'

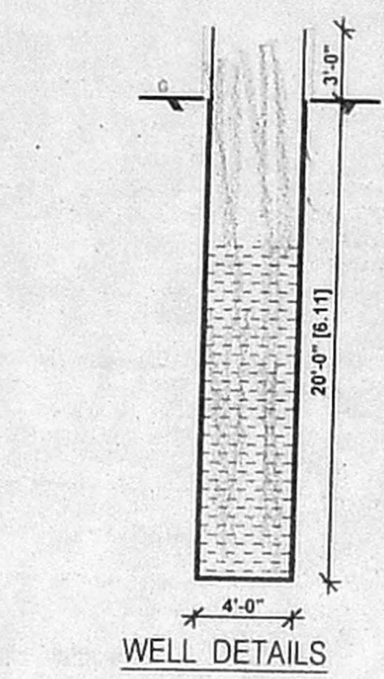


WELL DETAILS

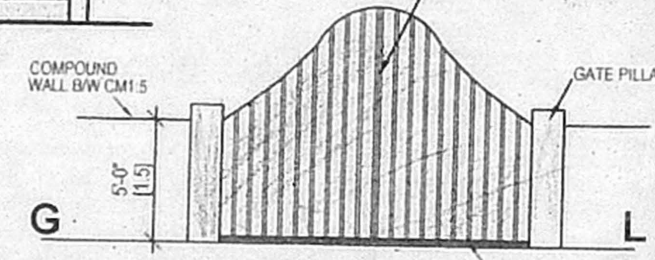



COMPOUND WALL DETAIL

Key Plan


N.T.S

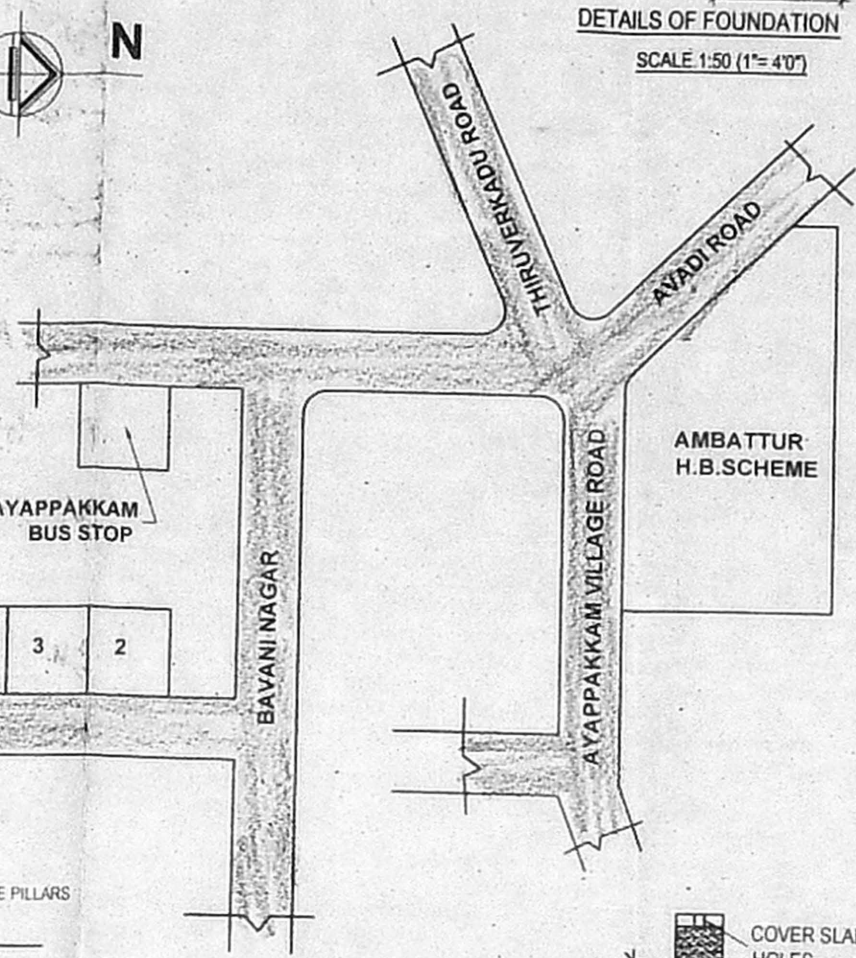


DETAILS OF FOUNDATION
SCALE 1:50 (1"=40')

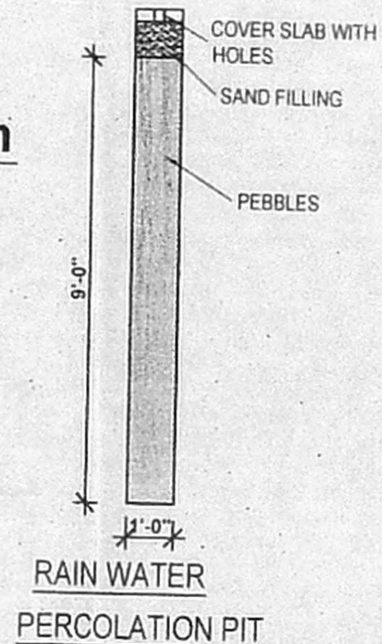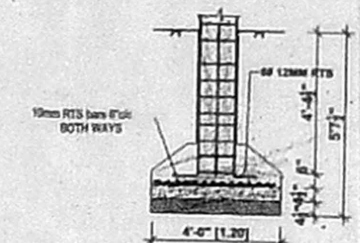


RAIN WATER PERCOLATION PIT

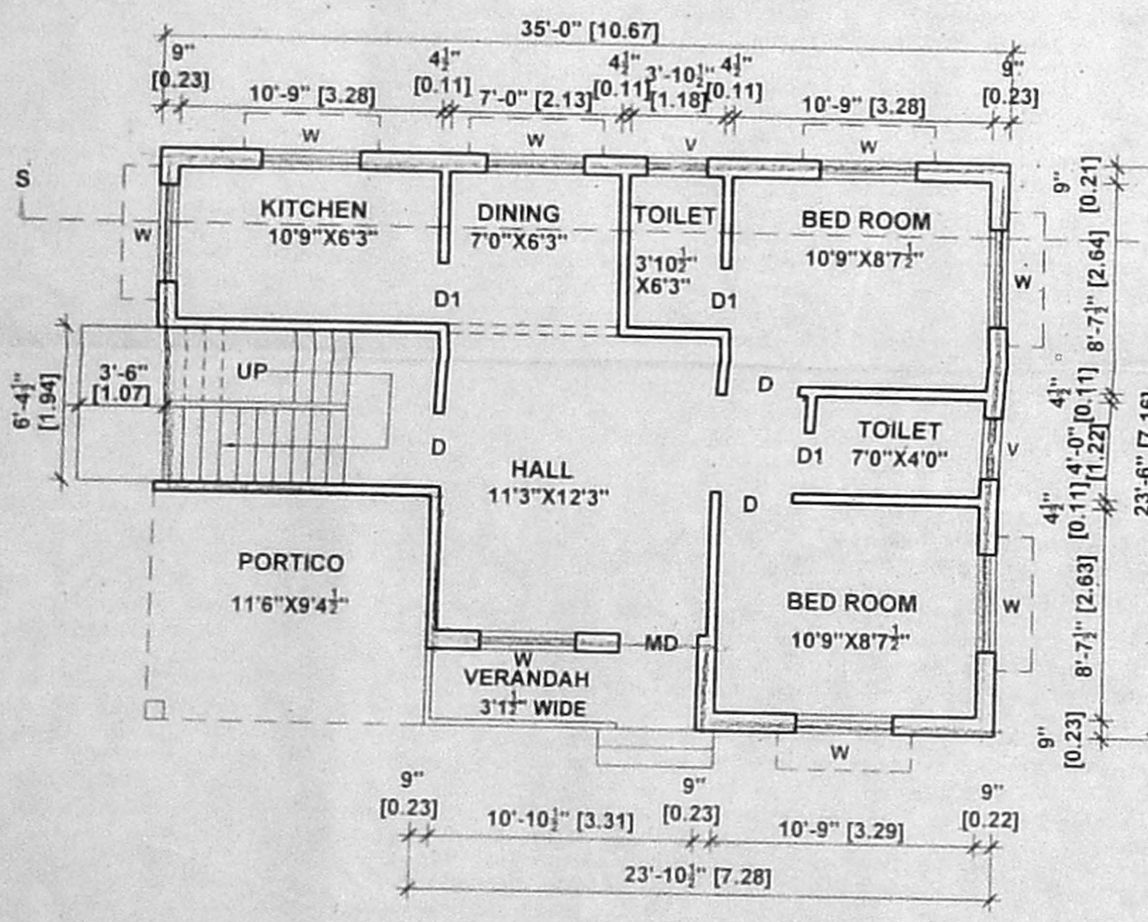

GROUND FLOOR PLAN

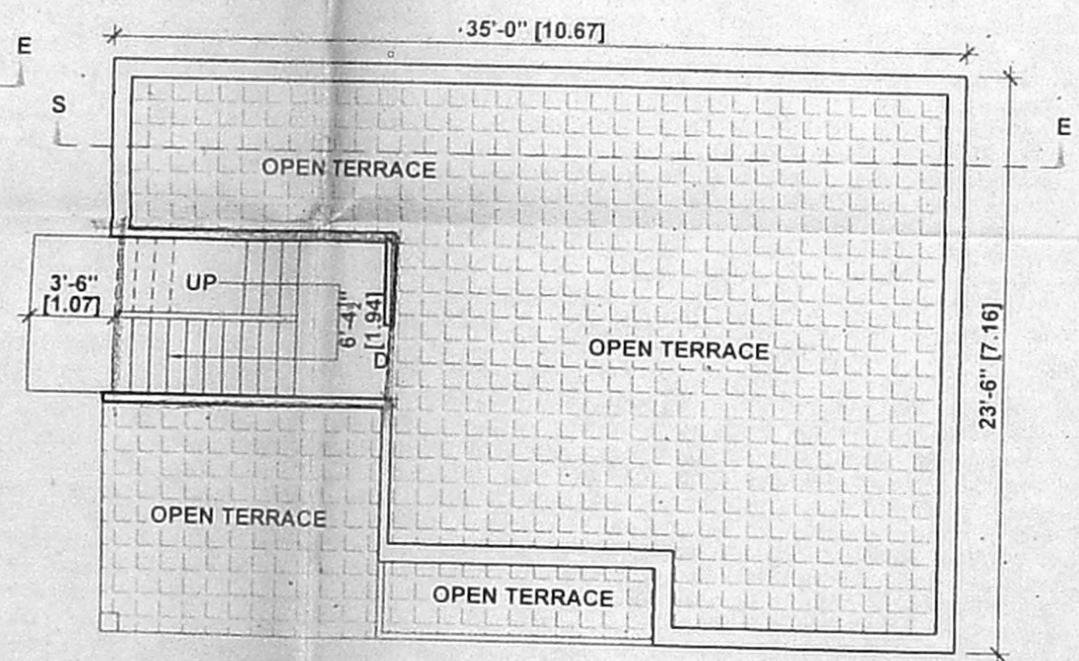

OPEN TERRACE FLOOR PLAN

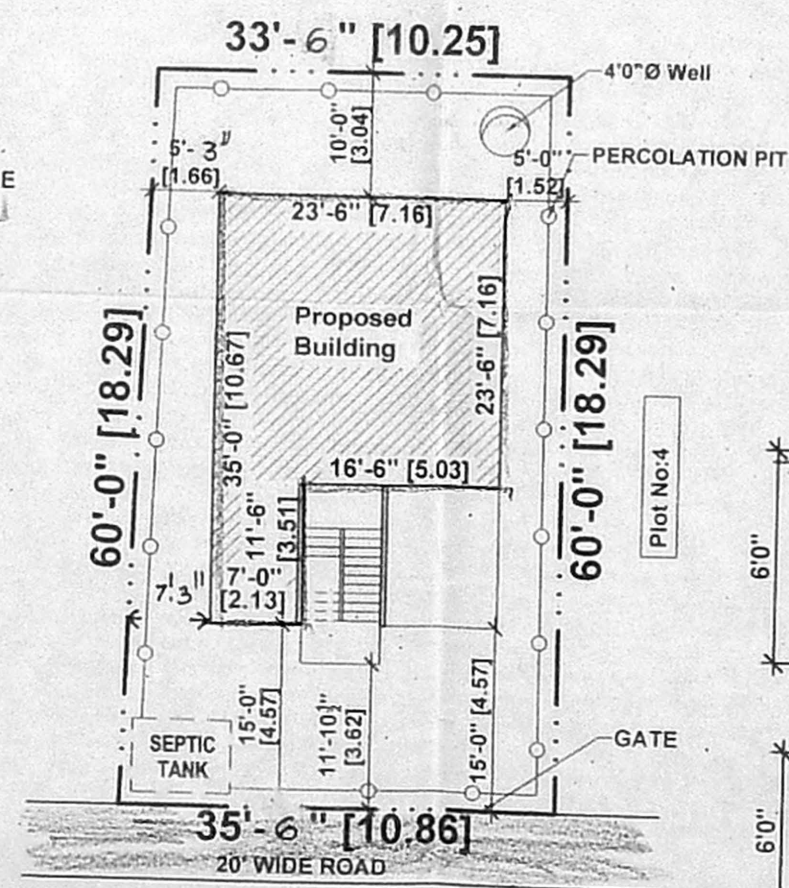

Site Plan

Scale :- 1" = 16' 0" (1:200)

OFFICE USE ONLY

CMDA "A" CHANNEL

C. No. **A1/369/04/2004**

Security Plan / Revised Plan
P. A. I. **28/1/05**

A.P. **31/1/05**
D.P.

SPECIFICATIONS

- SAND FILLING IN FOUNDATION 150 MM THICK
- P.C.C 1:2:4 USING 40MM HBG METAL FOR FOUNDATION BASEMENT
- R.C.C 1:2:4 USING 20MM HBG METAL FOR FOLLOWING WORKS:
 A) COLUMNS
 B) BEAMS
 C) INTERIORS, LOFT, SUNSHADE
 D) ROOF SLAB
- PLASTERING IN C.M 1:4 12MM THICK
- BRICK WORK IN C.M 1:5 USING I CLASS CHAMBER BURNT BRICKS
- WEATHERING COURSE WITH B.J.C TOP FINISHED WITH SQUARE TILES

SCALE: 1:100

COLOUR INDEX

PROPOSED	
ROADS	
PLOT BOUNDARY	

JOINERY

	M X M
M.D MAIN DOOR	1.00 X 2.10
D DOOR	0.91 X 2.10
D1 DOOR	0.76 X 2.10
W WINDOW	1.37 X 1.22
W1 WINDOW	0.91 X 1.22
V VENTILATOR	0.91 X 0.61

AREA DETAILS

	Sq.M	Sq.ft
PLOT AREA	192.30	2070.00
PLINTH AREA G.FLOOR	76.41	822.50
PLOT COVERAGE	39.73%	
F.S.I	0.39	

PLAN SHOWING THE PROPOSED CONSTRUCTION OF BUILDING IN P.No- 5, BHAVANI NAGAR, AYAPAKKAM VILLAGE, S.No-242(Part) AMBATTUR TALUK, THIRUVALLUR DISTRICT.

சாரதி எஞ்சினியர்ஸ்
 எண். 15 (ஆடி.ஆடி. மாளிகை)
 த.நா.கு.மா.வா வணிக வளாகம்
 திருமங்கலம் அண்ணா நகர்
 சென்னை - 40. 2621 6221

Drg.No:- 1210/NOV/18 Drawn. **ச.செல்வசி.சுப்**

OWNER **P. J. Prabaharan**

P. J. PRABAHARAN. B.E
 CLASS I, LICENSED SURVEYOR NO
 No 15, TNSCB Complex, Thirumangalakudi,
 ANNA NAGAR. CHENNAI-600 040.
 6220316, 6216221
 LICENSED SURVEYOR