





CMDA "A" C
 C. No. 81/3628/2004
 Security Plan / Revised Plan
 P. A. I. 99/105
 A.P. D.P.

OFFICE COPY


255/075/2005
 Planning Permit No. 255/075/2005
APPROVED
 SUBJECT TO THE CONDITIONS IN
 THIS OFFICE LETTER.
 No. 26981/04 D.M. 3-2-2005
 FOR MEMBER SECRETARY
 CHENNAI METROPOLITAN
 DEVELOPMENT AUTHORITY
 CHENNAI - 600 008.

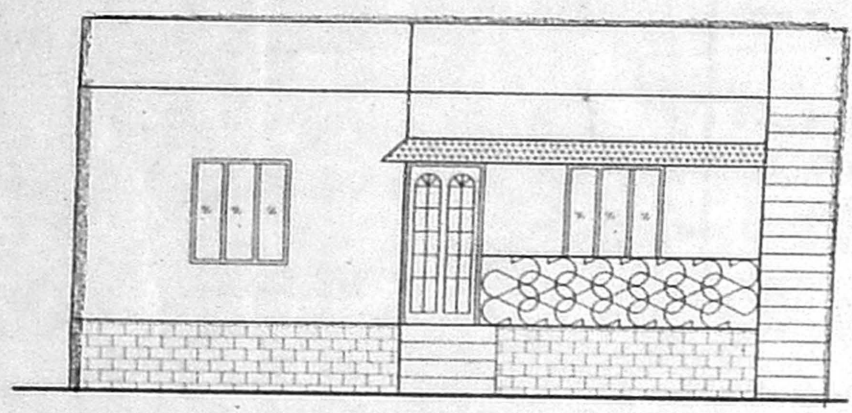



ELEVATION

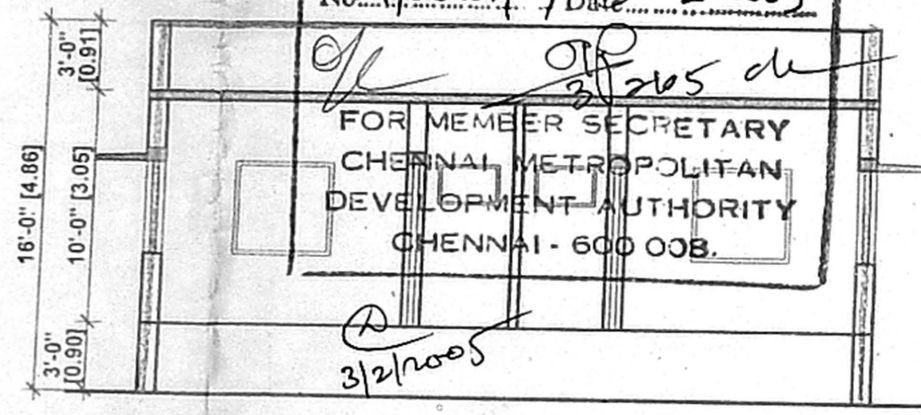


SECTION ON 'SE'

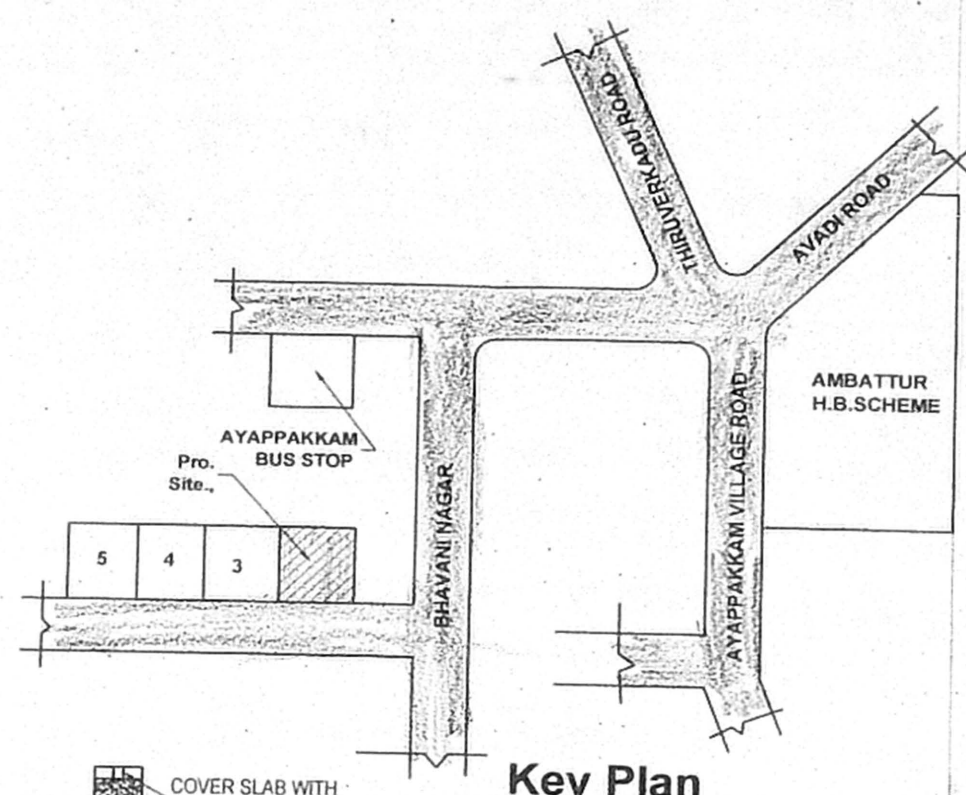


Key Plan
N.T.S.

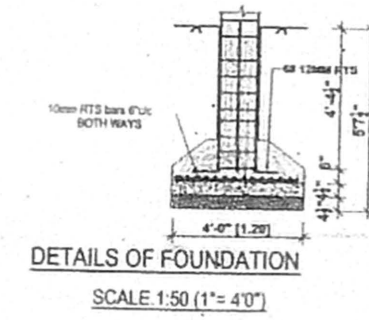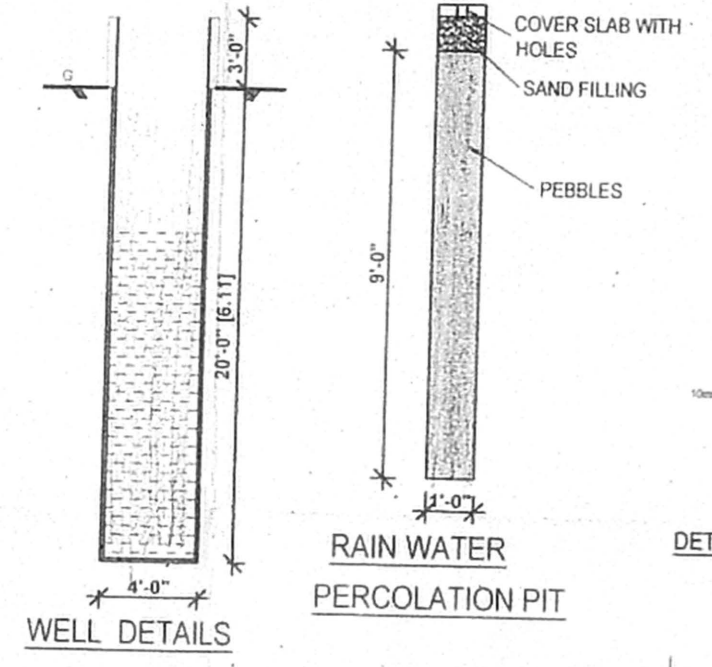


DETAILS OF FOUNDATION
SCALE 1:50 (1"=4'0")

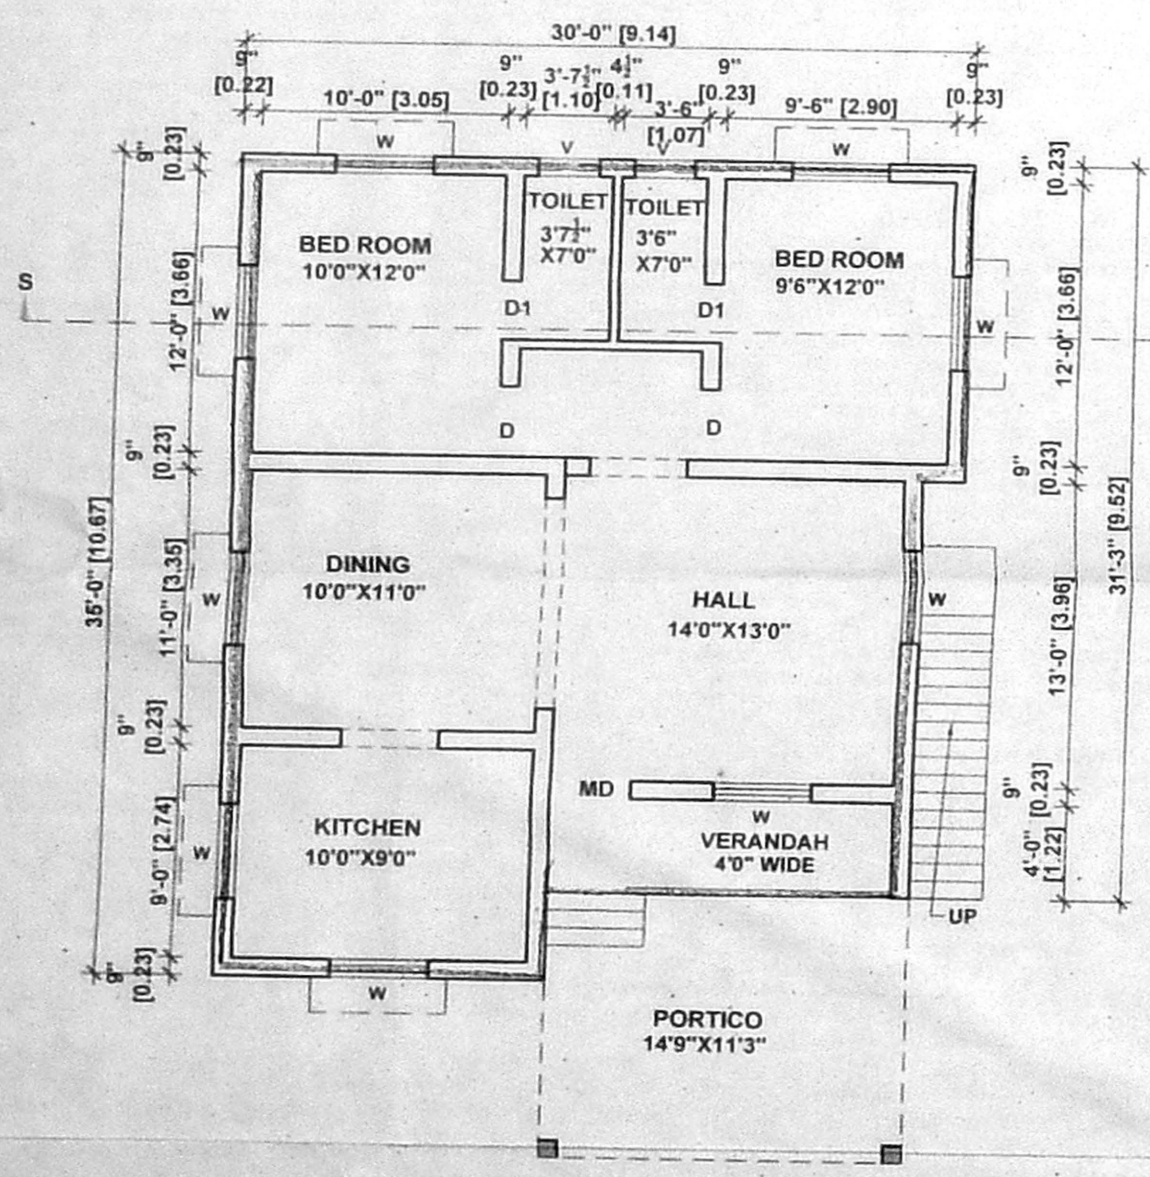


GROUND FLOOR PLAN

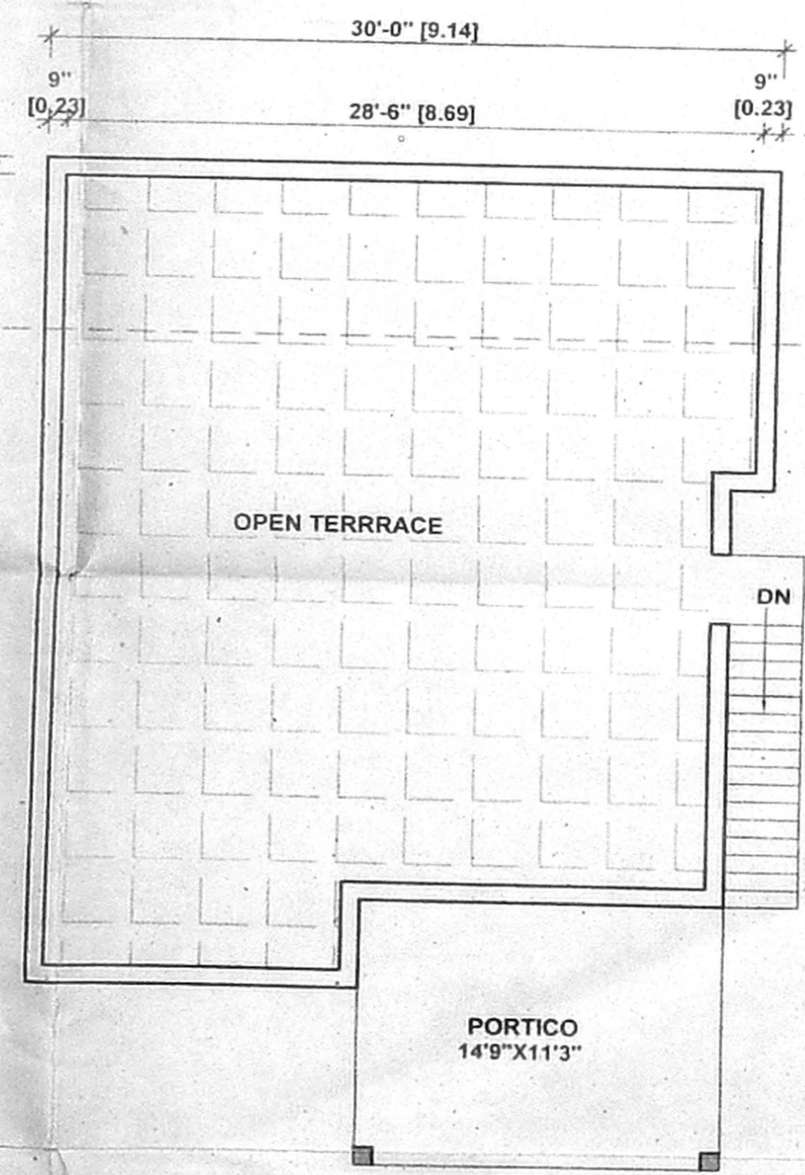

TERRACE FLOOR PLAN

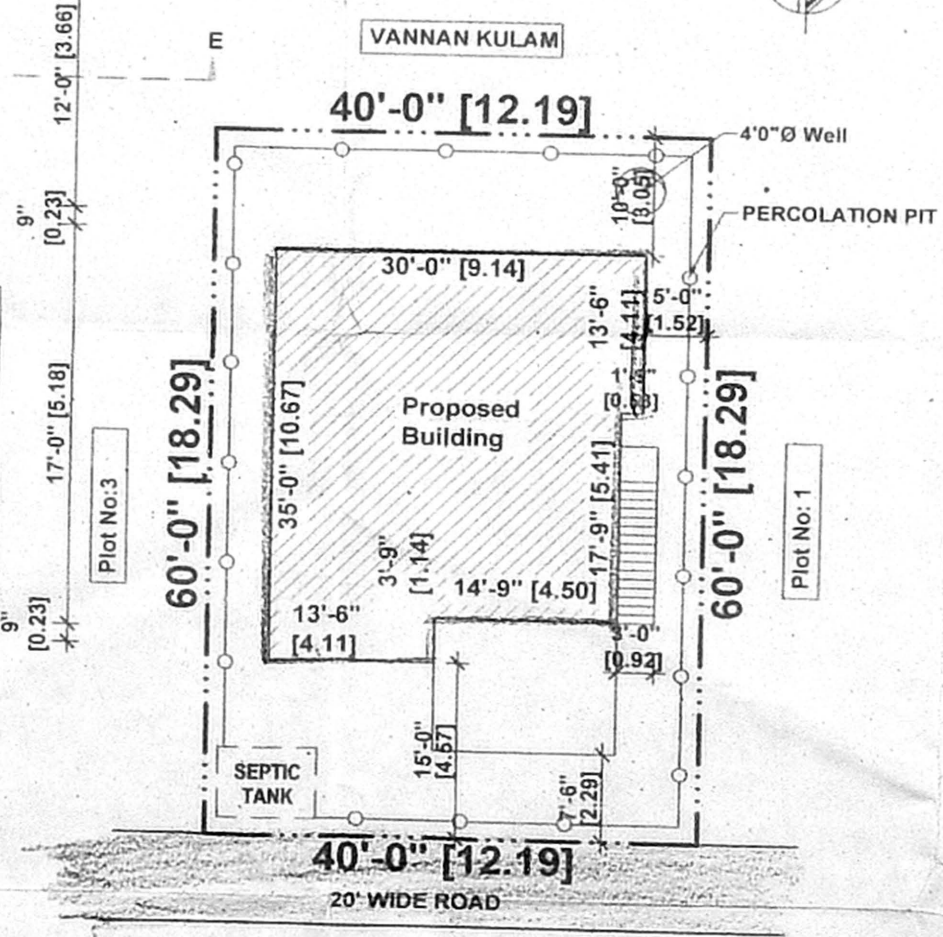

Site Plan
Scale :- 1" = 16' 0" (1:200)

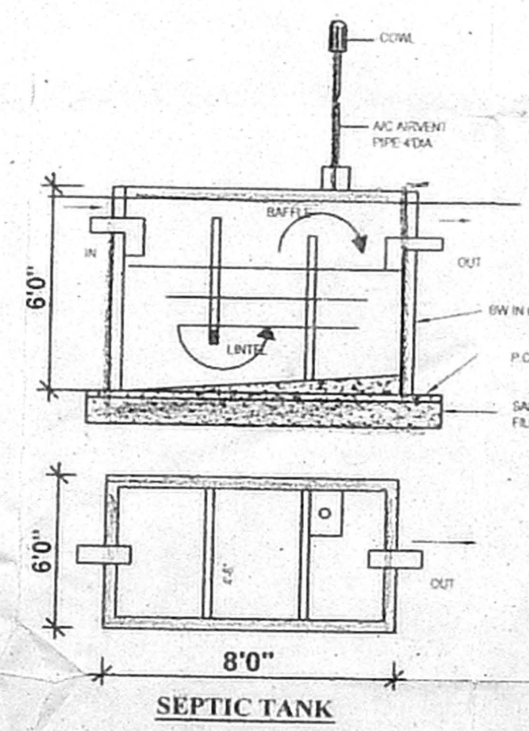

SEPTIC TANK

SPECIFICATIONS
 1. SAND FILLING IN FOUNDATION 150 MM THICK
 2. P.C.C 1:2:4 USING 40MM HBG METAL FOR FOUNDATIONS BASEMENT
 3. R.C.C 1:2:4 USING 20MM HBG METAL FOR FOLLOWING WORKS
 A/COLUMNS
 B/BEAMS
 C/JINTELS, LOFT, SUNSHADE
 D/ROOF SLAB
 4. PLASTERING IN C.M 1:4:12MM THICK
 5. BRICK WORK IN C.M 1:5 USING I CLASS CHAMBER BURNT BRICKS
 6. WEATHERING COURSE WITH B.J.C TOP FINISHED WITH SQUARE TILES
 SCALE: 1:100

COLOUR INDEX
 PROPOSED ROADS
 PLOT BOUNDARY

JOINERY

	M X M
M.D MAIN DOOR	1.00 X 2.10
D DOOR	0.91 X 2.10
D1 DOOR	0.76 X 2.10
W WINDOW	1.37 X 1.22
W1 WINDOW	0.91 X 1.22
V VENTILATOR	0.91 X 0.61

AREA DETAILS

	Sq.M	Sq.ft
PLOT AREA	222.96	2400.00
PLINTH AREA G.FLOOR	104.32	1123.00
PLOT COVERAGE	46.78%	
F.S.I	0.46	

PLAN SHOWING THE PROPOSED CONSTRUCTION OF BUILDING IN P.No- 2, BHAVANI NAGAR, AYAPAKKAM VILLAGE, S.No-242, AMBATTUR TALUK, THIRUVALLUR DISTRICT.

சாரதி எஞ்சினியர்ஸ்
 எண்.15 (ஆ.ஆ. மாளிகை)
 த.நா.கு.மா.வா வணிக வளாகம்
 திருமங்கலம் அண்ணா நகர்
 சென்னை -40. 2621 6221

Drg.No:- 1211/NOV/18 Drawn. க.வெங்கடேசன்

OWNER
P.J. PRABAHARAN, B.E.
 CLASS I, LICENSED SURVEYOR NO.
 No 15, TNSCB Complex, Thirumangalam,
 ANNA NAGAR, CHENNAI-600 040.
 LICENSED SURVEYOR 6220316, 6216221