



REFERENCE	
EXISTING BUILDING	
PROPOSED BUILDING	
SITE BOUNDARY	<i>de</i>
ROAD	
SEWER LINE	
AREA STATEMENT	BRITISH (S&T) METR. (S&M)
F.S.L AREA	
CMDA "A" CHANNEL	
C No. <i>13267/05</i>	
Security Plan / Revised Plan	
Plot Coverage	44.07
NON F.S.L AREA D.P.	
HT. IN ROOM	184.87 17.18

OFFICE COPY


Planning Permit No. *1511531/2005*
APPROVED
 SUBJECT TO THE CONDITIONS IN THIS OFFICE LETTER
 No. *13267/05* Date *27.2.05*
 FOR MEMBER SECRETARY
 CHENNAI METROPOLITAN
 DEVELOPMENT AUTHORITY
 CHENNAI - 600 008.

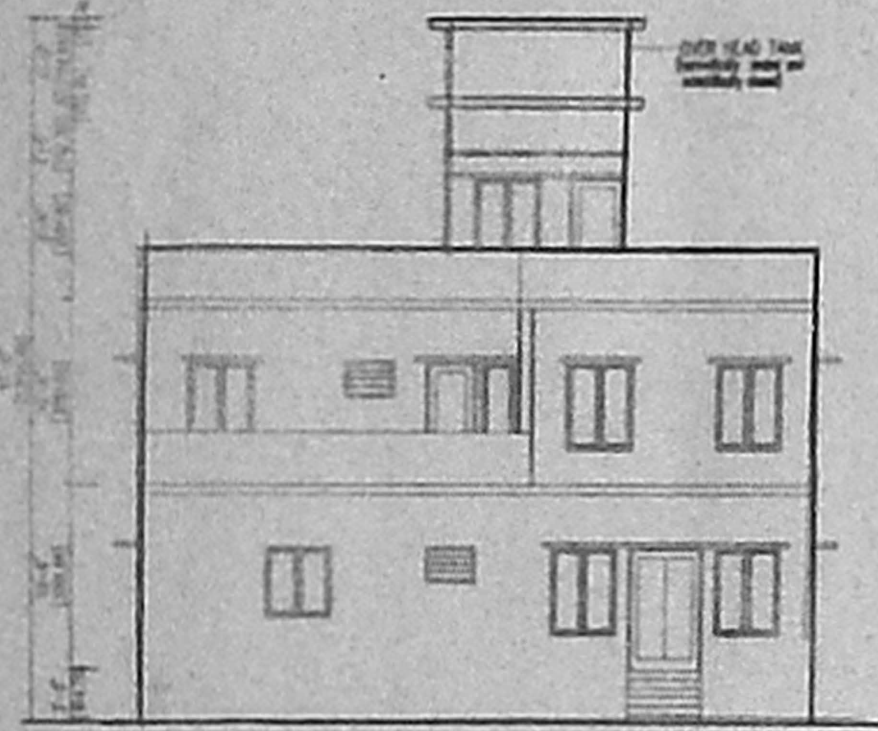


FRONT ELEVATION

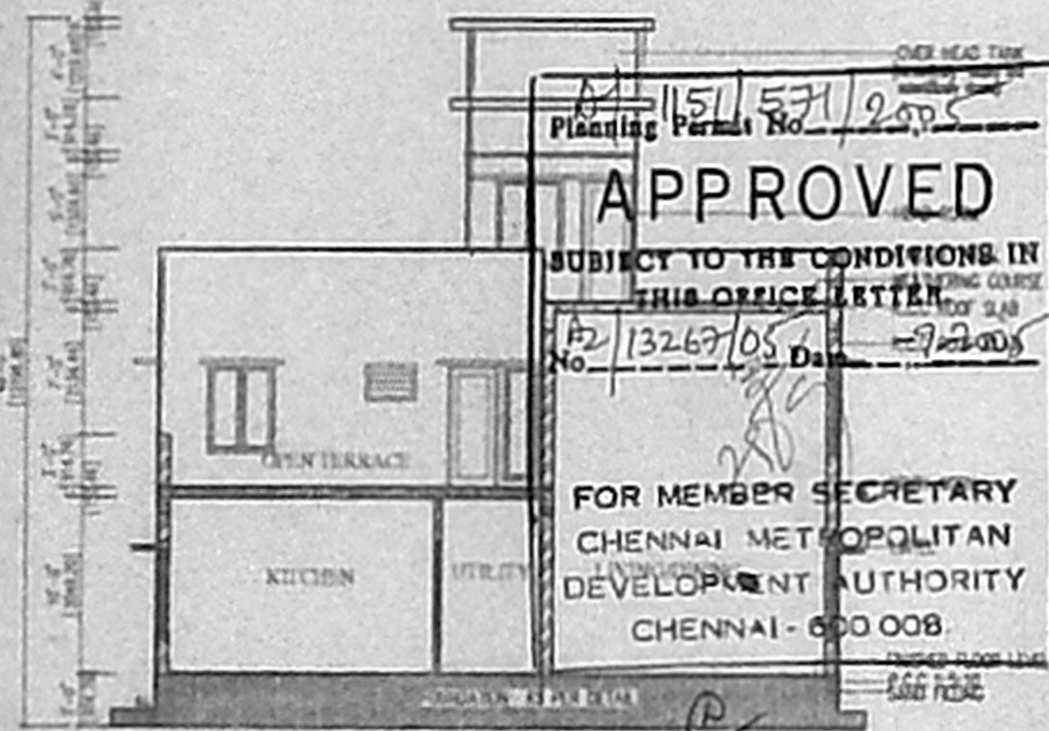

SECTION ON AA

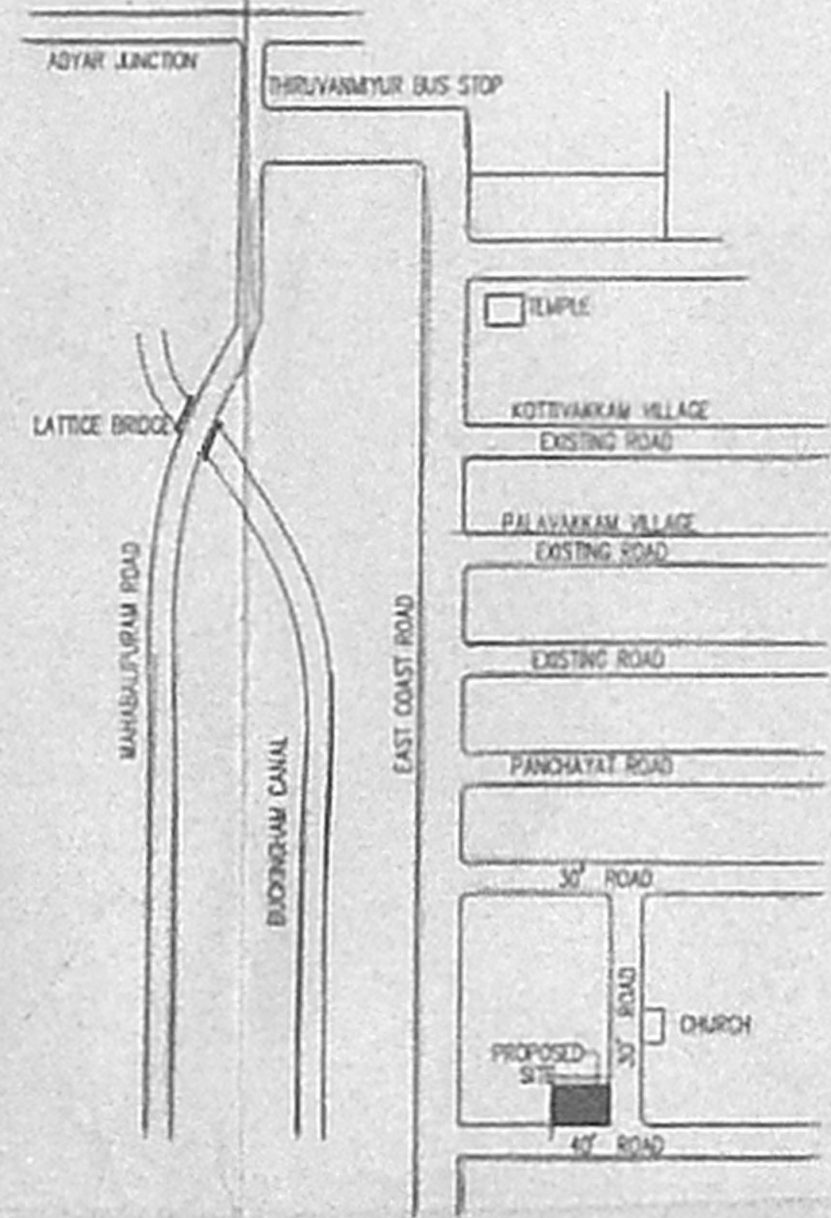

TOPO PLAN

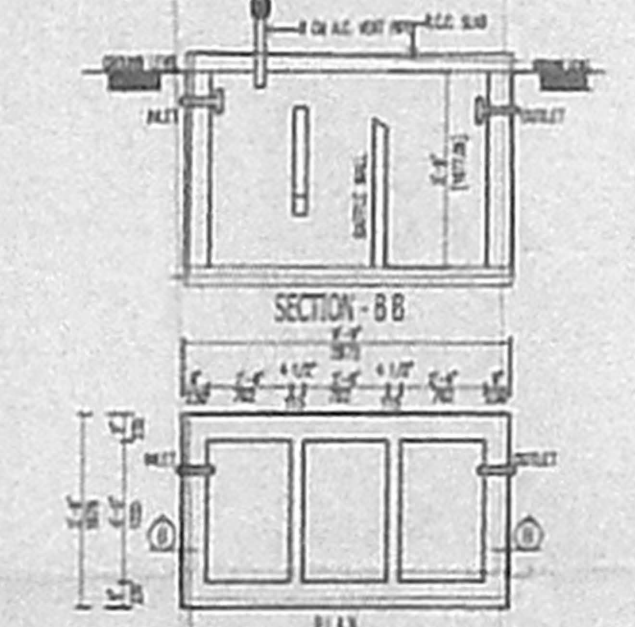


SEPTIC TANK DETAILS


SCHEDULE OF JOINERY			
NO	DESCRIPTION	METRIC	FEET
D0	WALL DOOR	1380x2128	4'-6"7"-0"
D1	FLUSH DOOR	790x2128	3'-5"7"-0"
D2	FLUSH DOOR	830x2128	2'-9"7"-0"
FD	POONA DOOR	1024x2128	6'-0"7"-0"
W1	WINDOW	1824x1520	6'-0"5"-0"
W2	WINDOW	1266x1520	4'-0"5"-0"
FW	FRENCH WINDOW	608x1976	2'-0"5"-0"
FW	FRENCH WINDOW	812x1976	4'-0"5"-0"
KW	WINDOW	1266x1216	4'-0"4"-0"
V	VENTILATOR	608x608	2'-0"2"-0"
VI	VENTILATOR	912x608	3'-0"2"-0"

PLAN SHOWING THE PROPOSED BUILDING AT PLOT NO - 358 KAPALEESWARAR NAGAR, NEELANKARAI, COMPRISED IN THE APPROVED NO-LPDM/OTR CPWD-24 1974, IN SURVEY NO 9172A/1, 1.1 (91/2A) OF NEELANKARAI VILLAGE, SAIDAPET TALUK, CHENGALPATTU M.C.R. DISTRICT.


ALL METRIC DIMENSIONS ARE IN "MM"

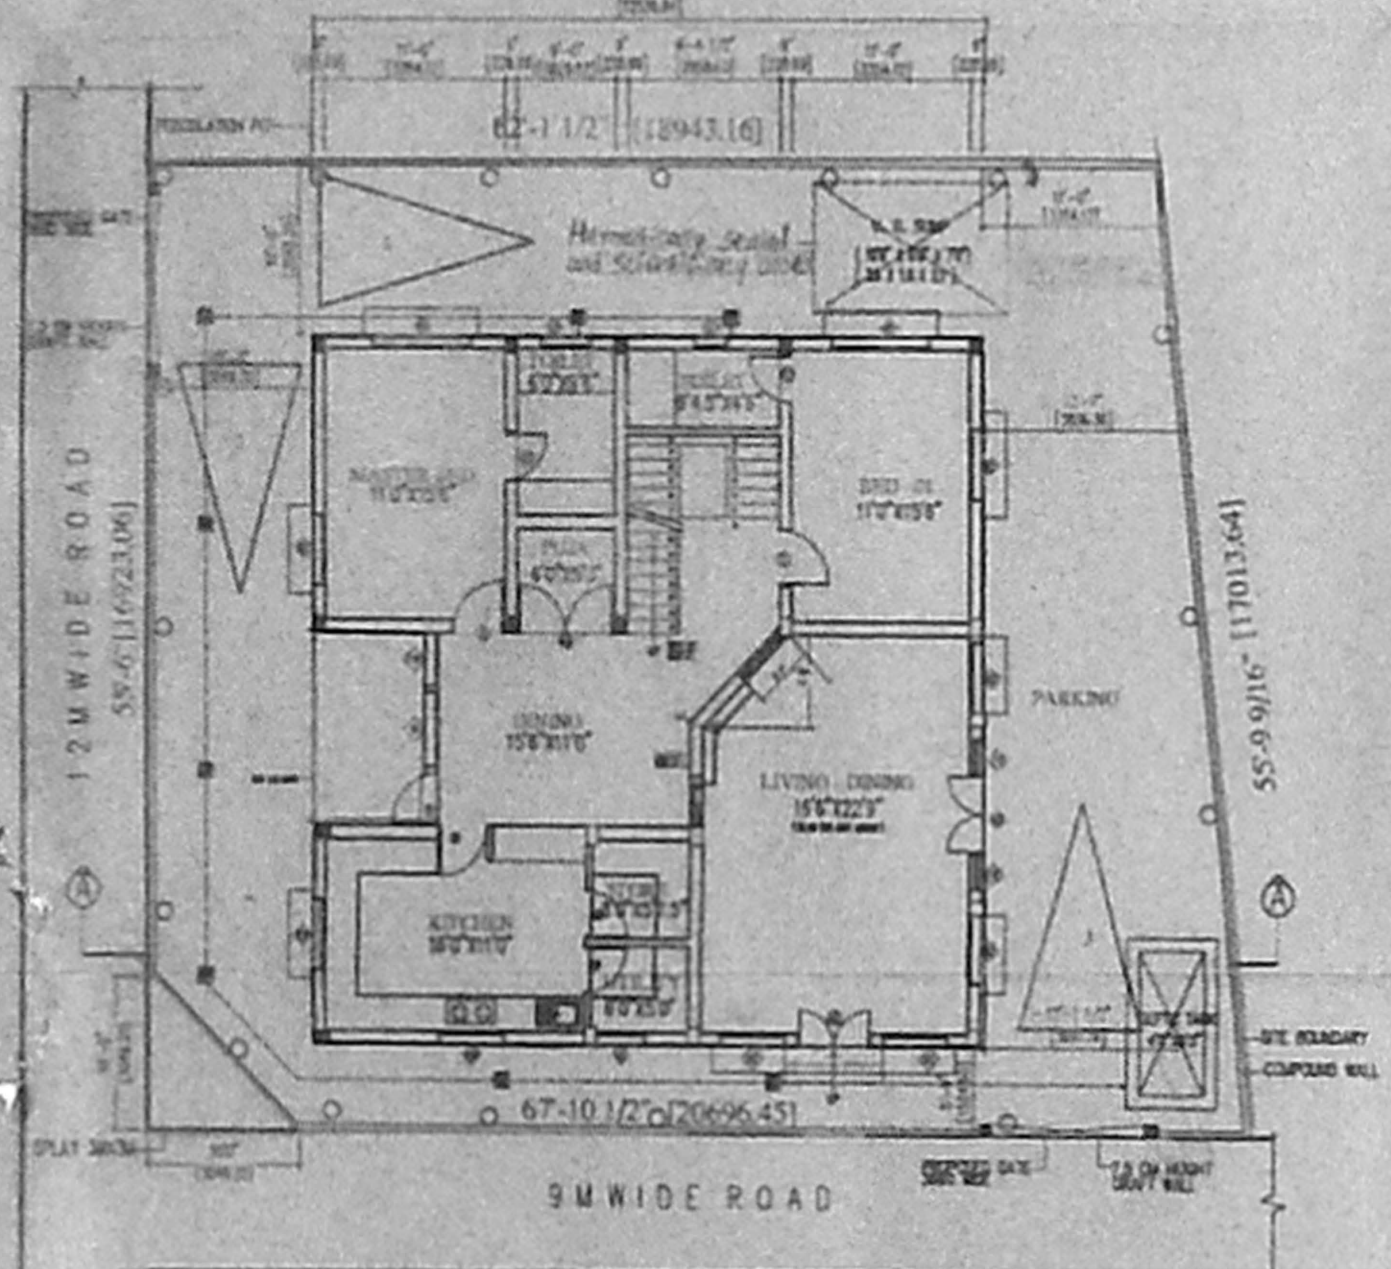

SITE CUM GROUND FLOOR PLAN

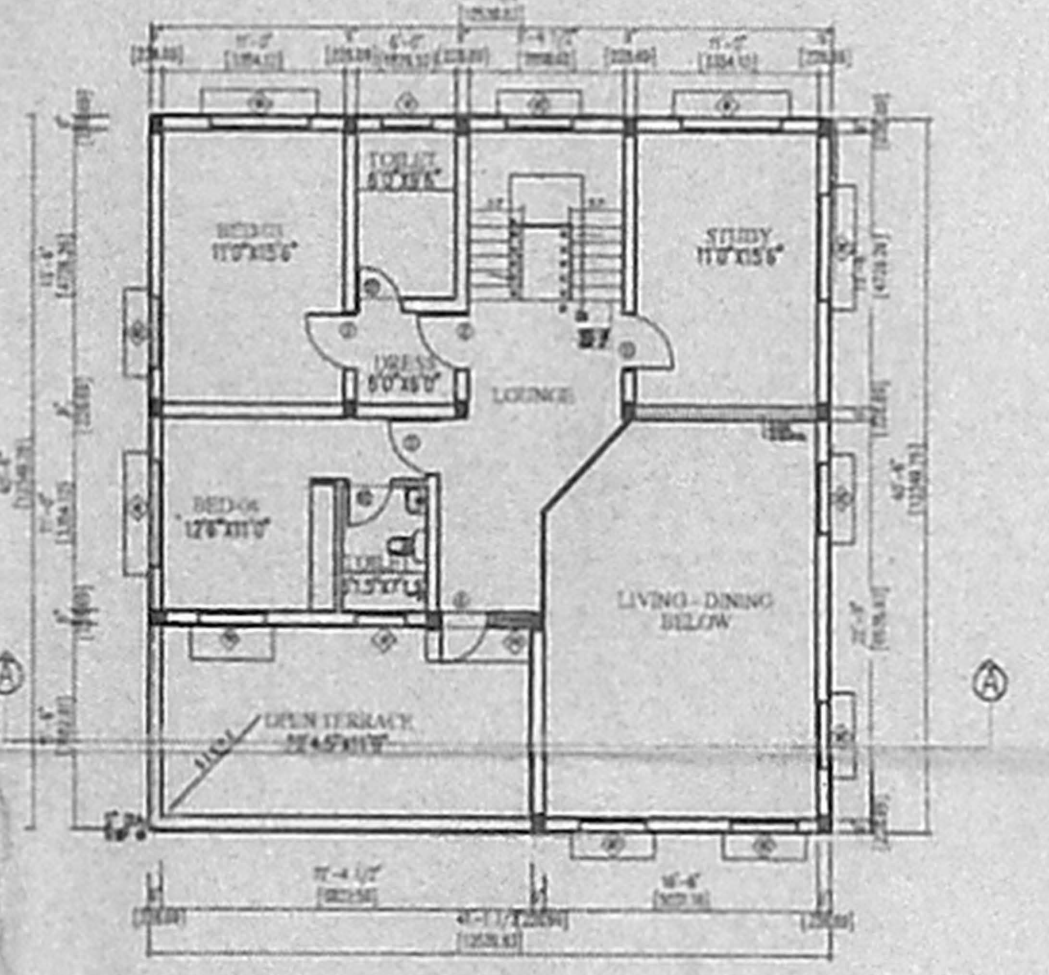

FIRST FLOOR PLAN

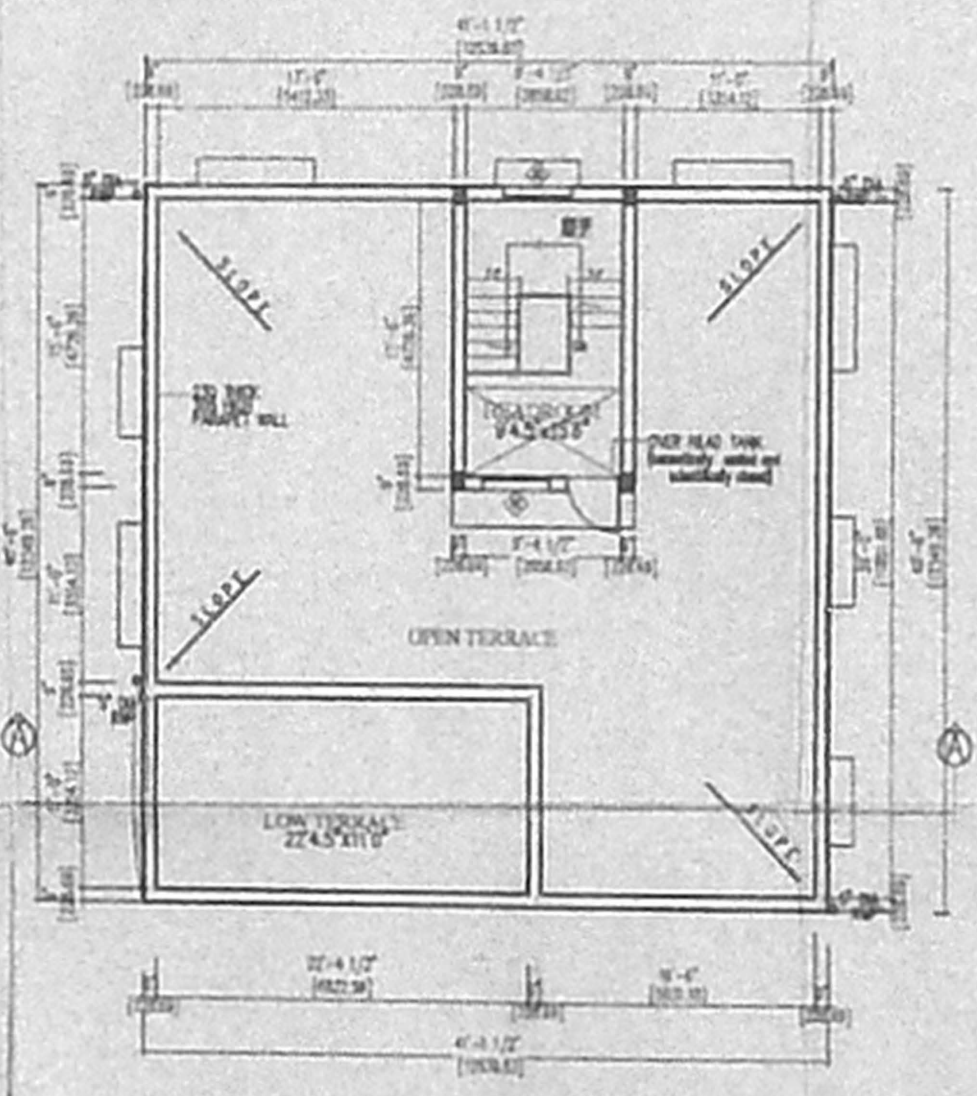

TERRACE FLOOR PLAN

REV. NO.	02.07.2005	DRG. NO.	CS-01
DATE	02.07.2005	SCALE	1" = 8'0" (1:96)
DEALT	BHARATHI S	DRAWN	GRACIA

J. Nagarajan

OWNER
B. Bharathi
BHARATHI SENGOTTUVEL
 B. Arch., M.H., A.I.A.
 ARCHITECTURE * INTERIORS * HOUSES
 77, (Old No. 8) S-Block, 6th Avenue,
 Anna Nagar, Chennai - 600 004.
 Ph. : 267684, 6265010

LICENSED SURVEYOR