


TOTAL EXTENT : 5221M²
ROAD AREA : 1323M²
NO. OF PLOTS : 24

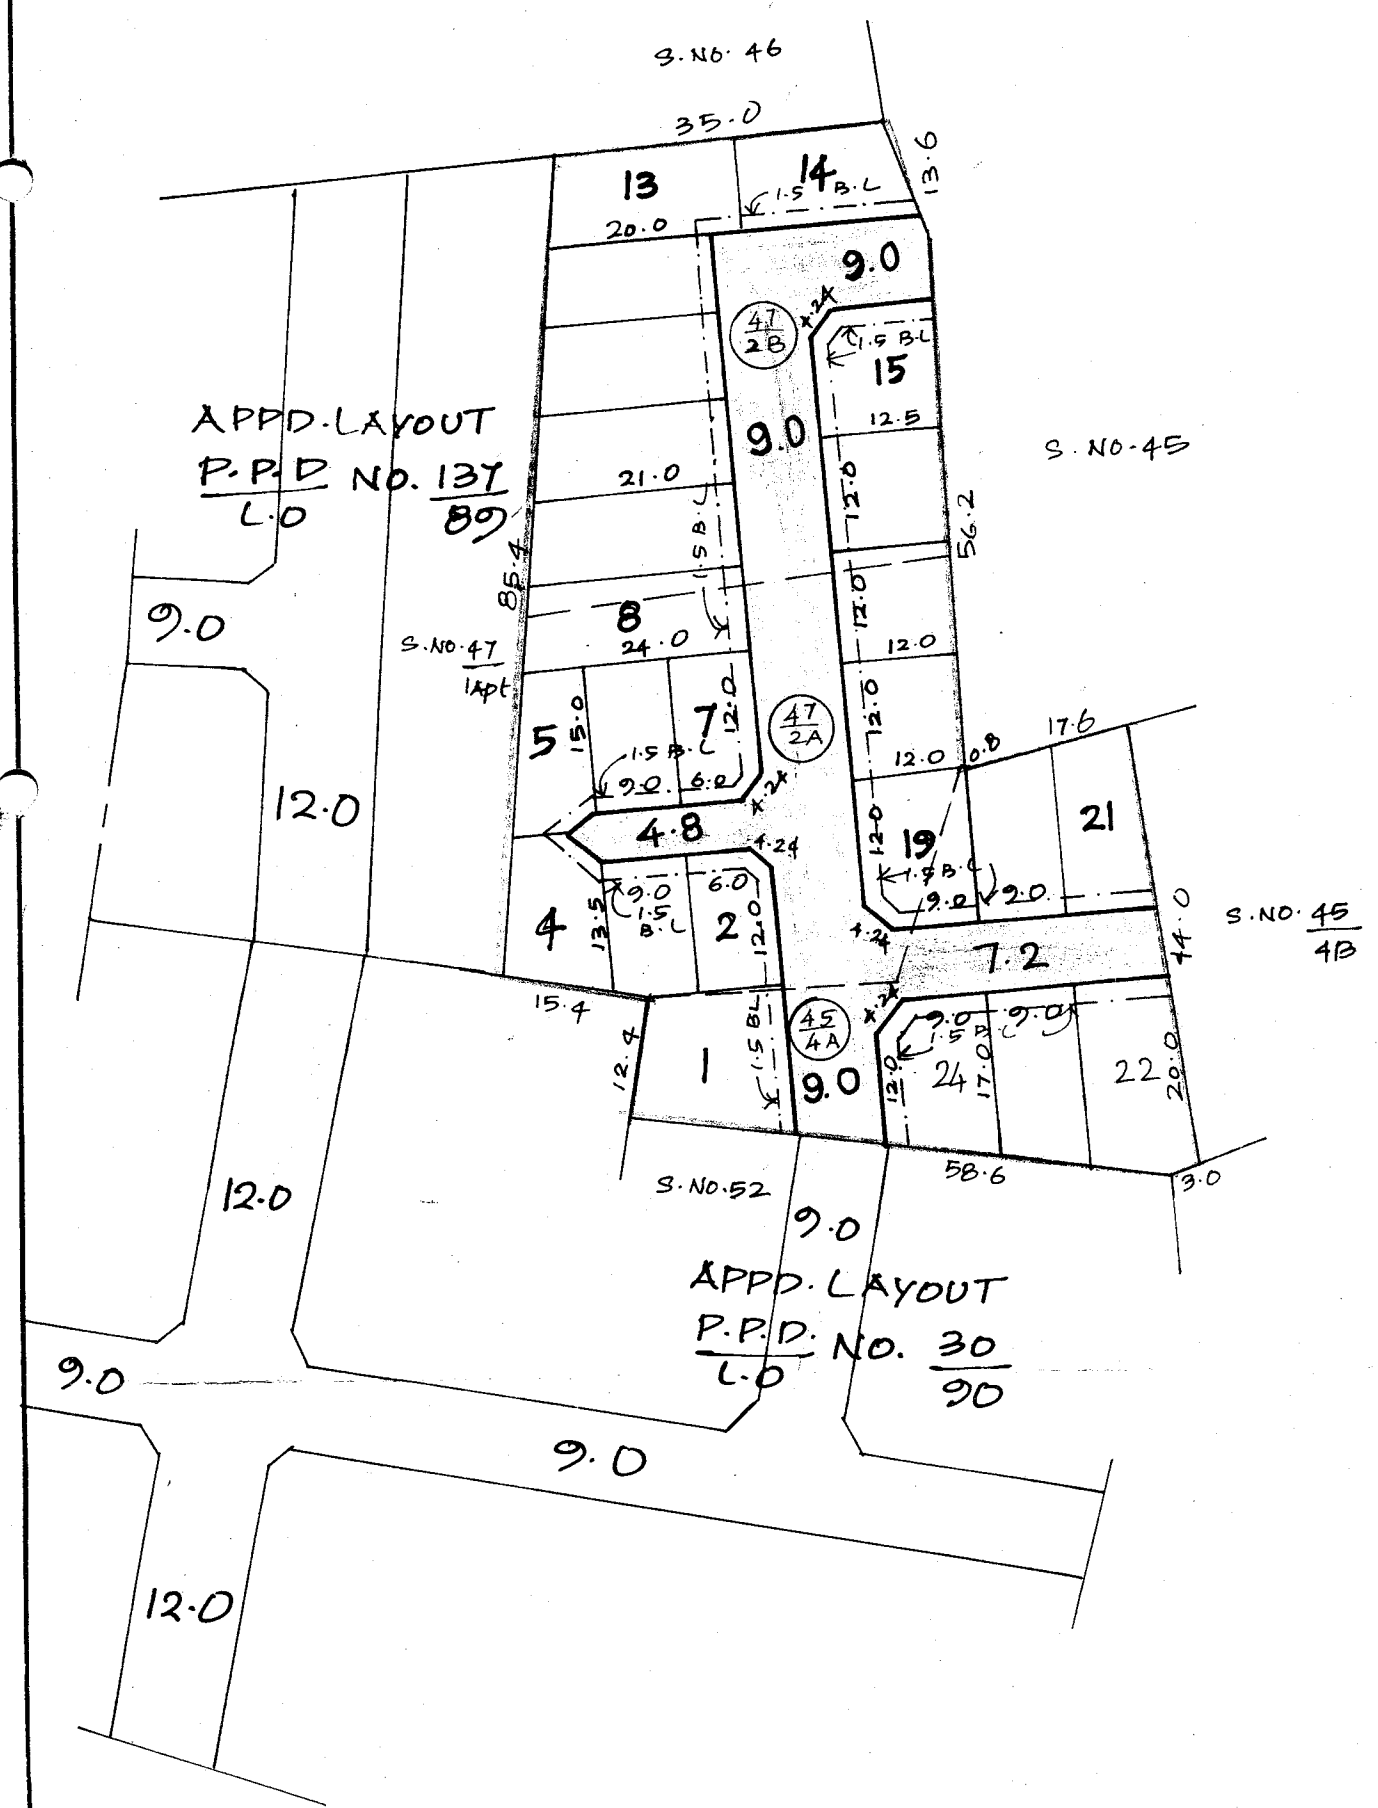

NOTE:
1. SPLAY 3.0M X 3.0M
2. MEASUREMENTS INDICATED ARE EXCLUDING SPLAY DIMENSIONS.
3. ROAD AREA WAS ALREADY HANDED OVER TO THE LOCALBODY VIDE GIFT DEED DDC. NO. 1659/07, DATED 2/3/07

LEGEND:
SITE BOUNDARY
EXISTING ROAD
PROPOSED ROAD

PERUNGALATHUR SPECIAL VILLAGE PANCHAYAT
LAYOUT OF HOUSE SITES IN S.NO. 45/4A, 47/2A & 47/2B
OF PERUNGALATHUR VILLAGE

SCALE: 1:800 (ALL MEASUREMENTS ARE IN METRE)

P.P.D. NO. 28
L.O. 2007
APPROVED
VIDE LETTER NO : LI/5258/07
DATED : 30/3/07
OFFICE COPY
FOR MEMBER-SECRETARY
CHENNAI METROPOLITAN
DEVELOPMENT AUTHORITY

